




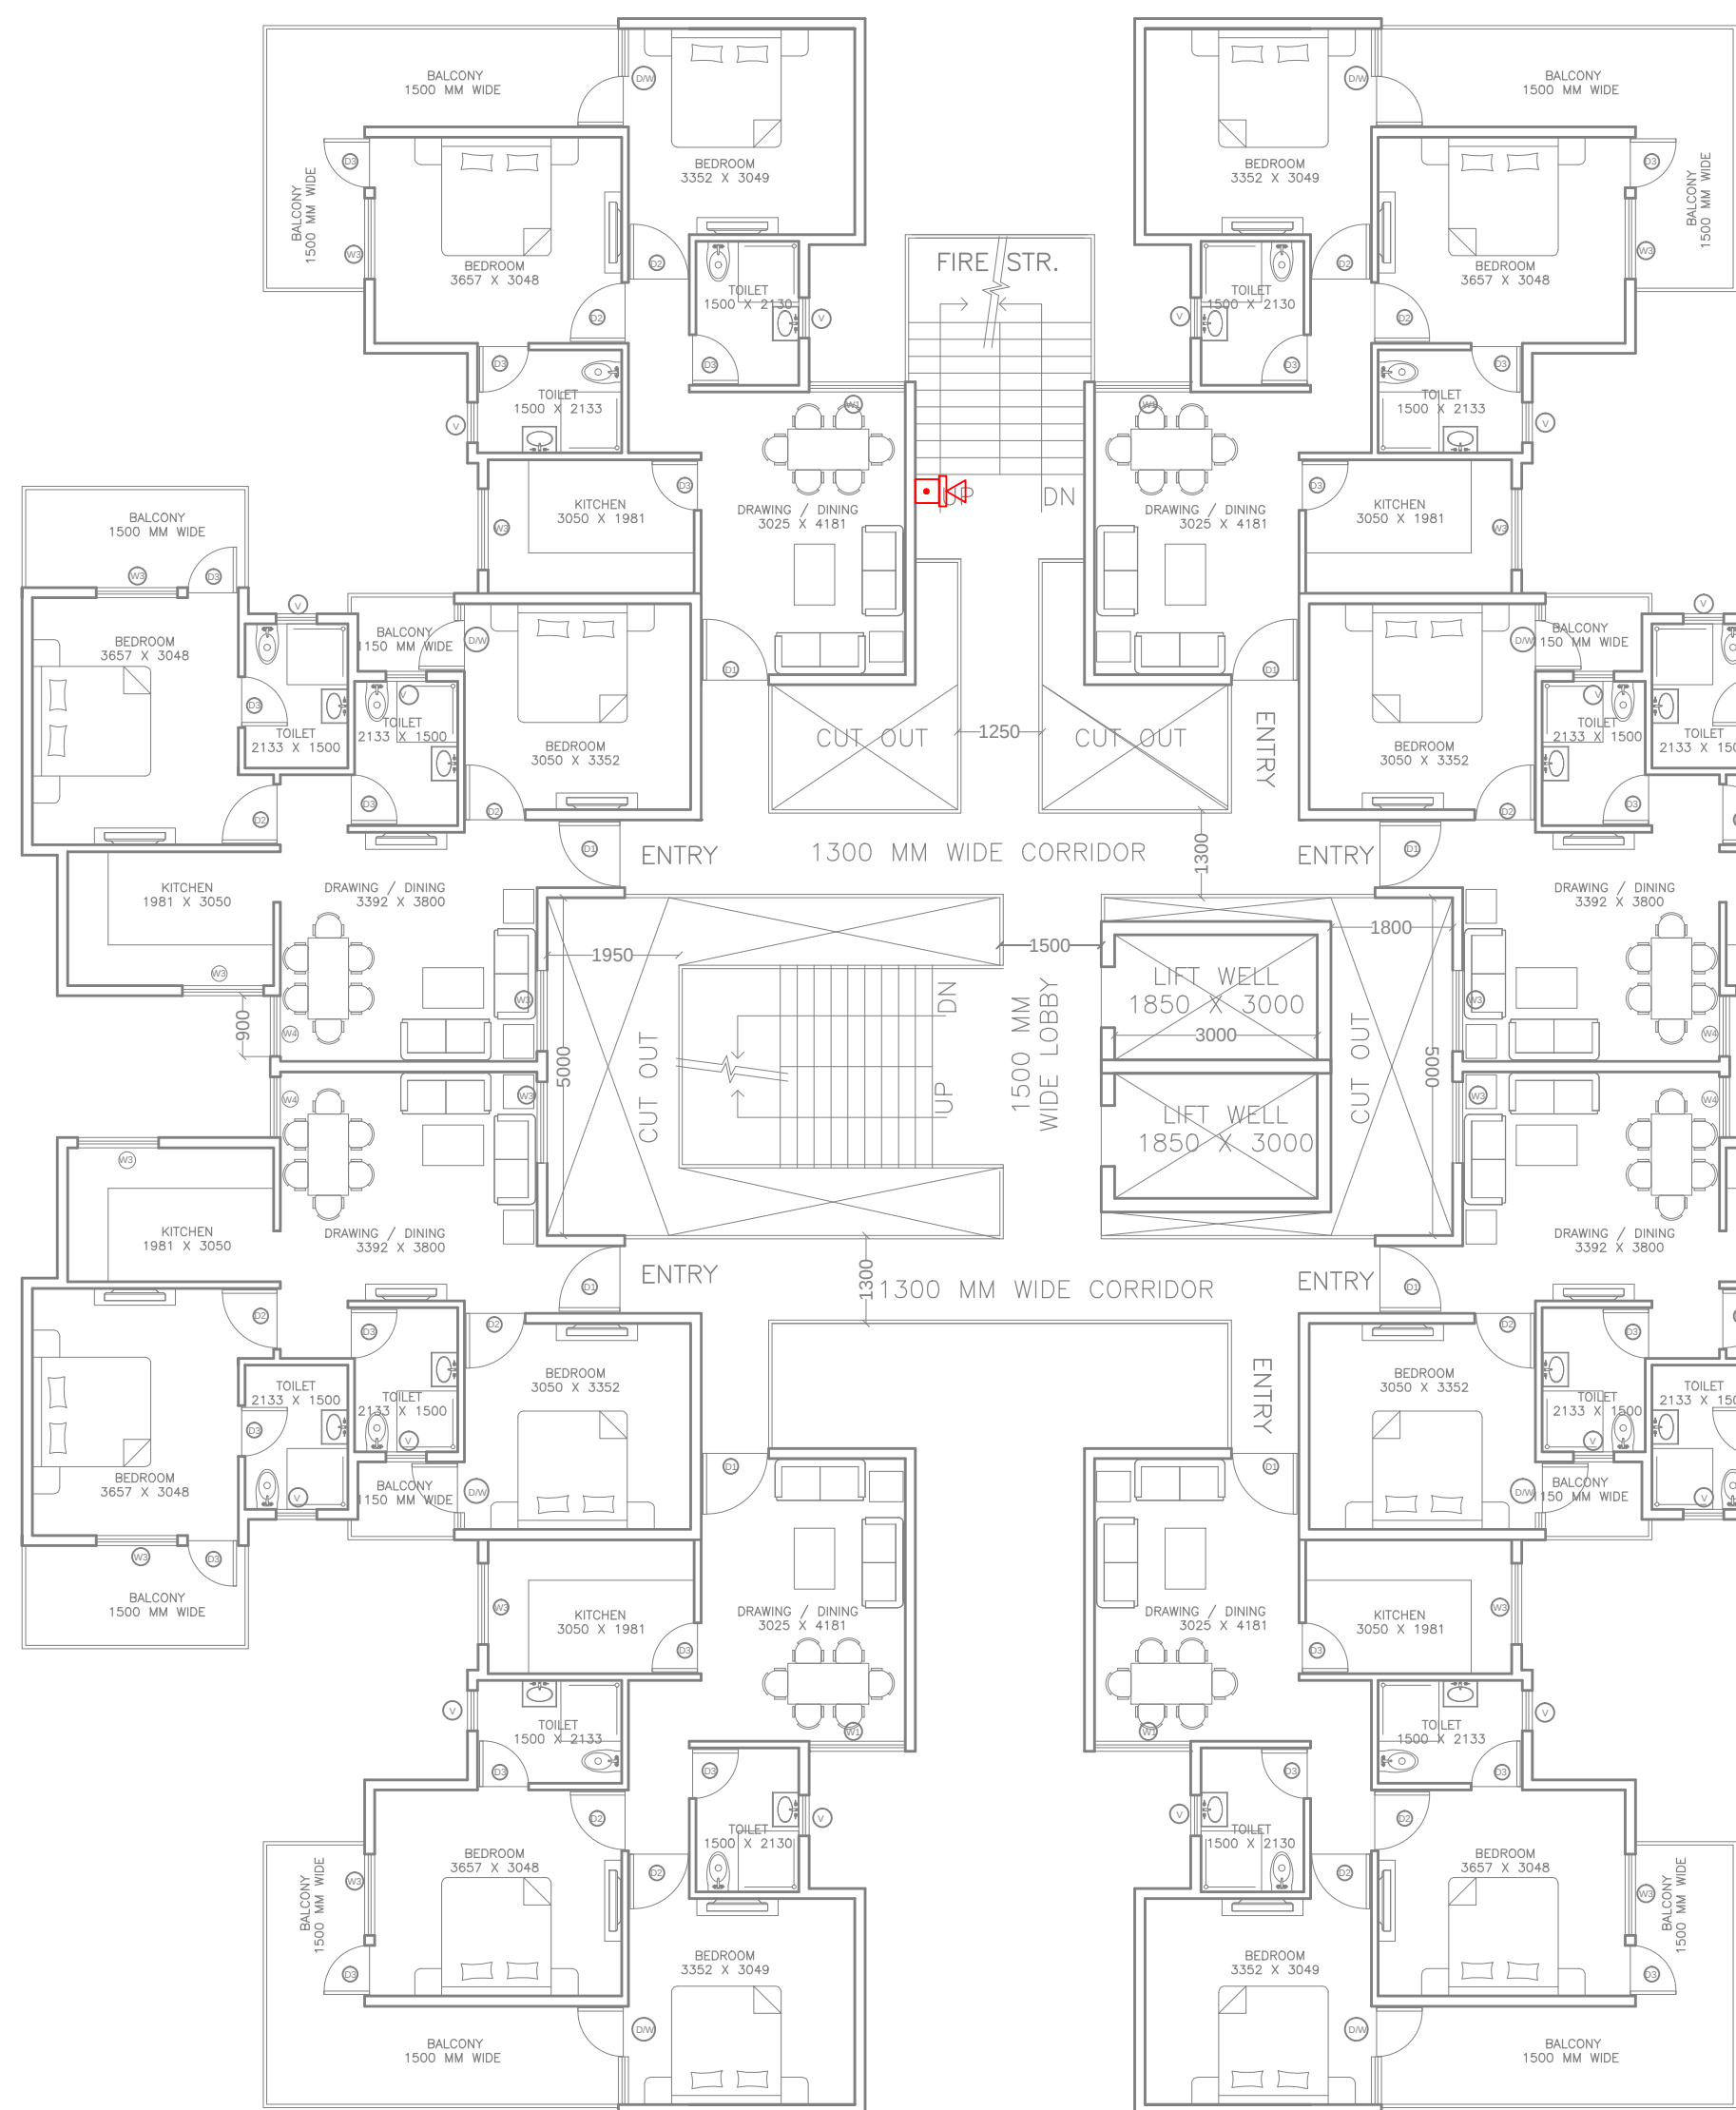

TYPICAL PLAN

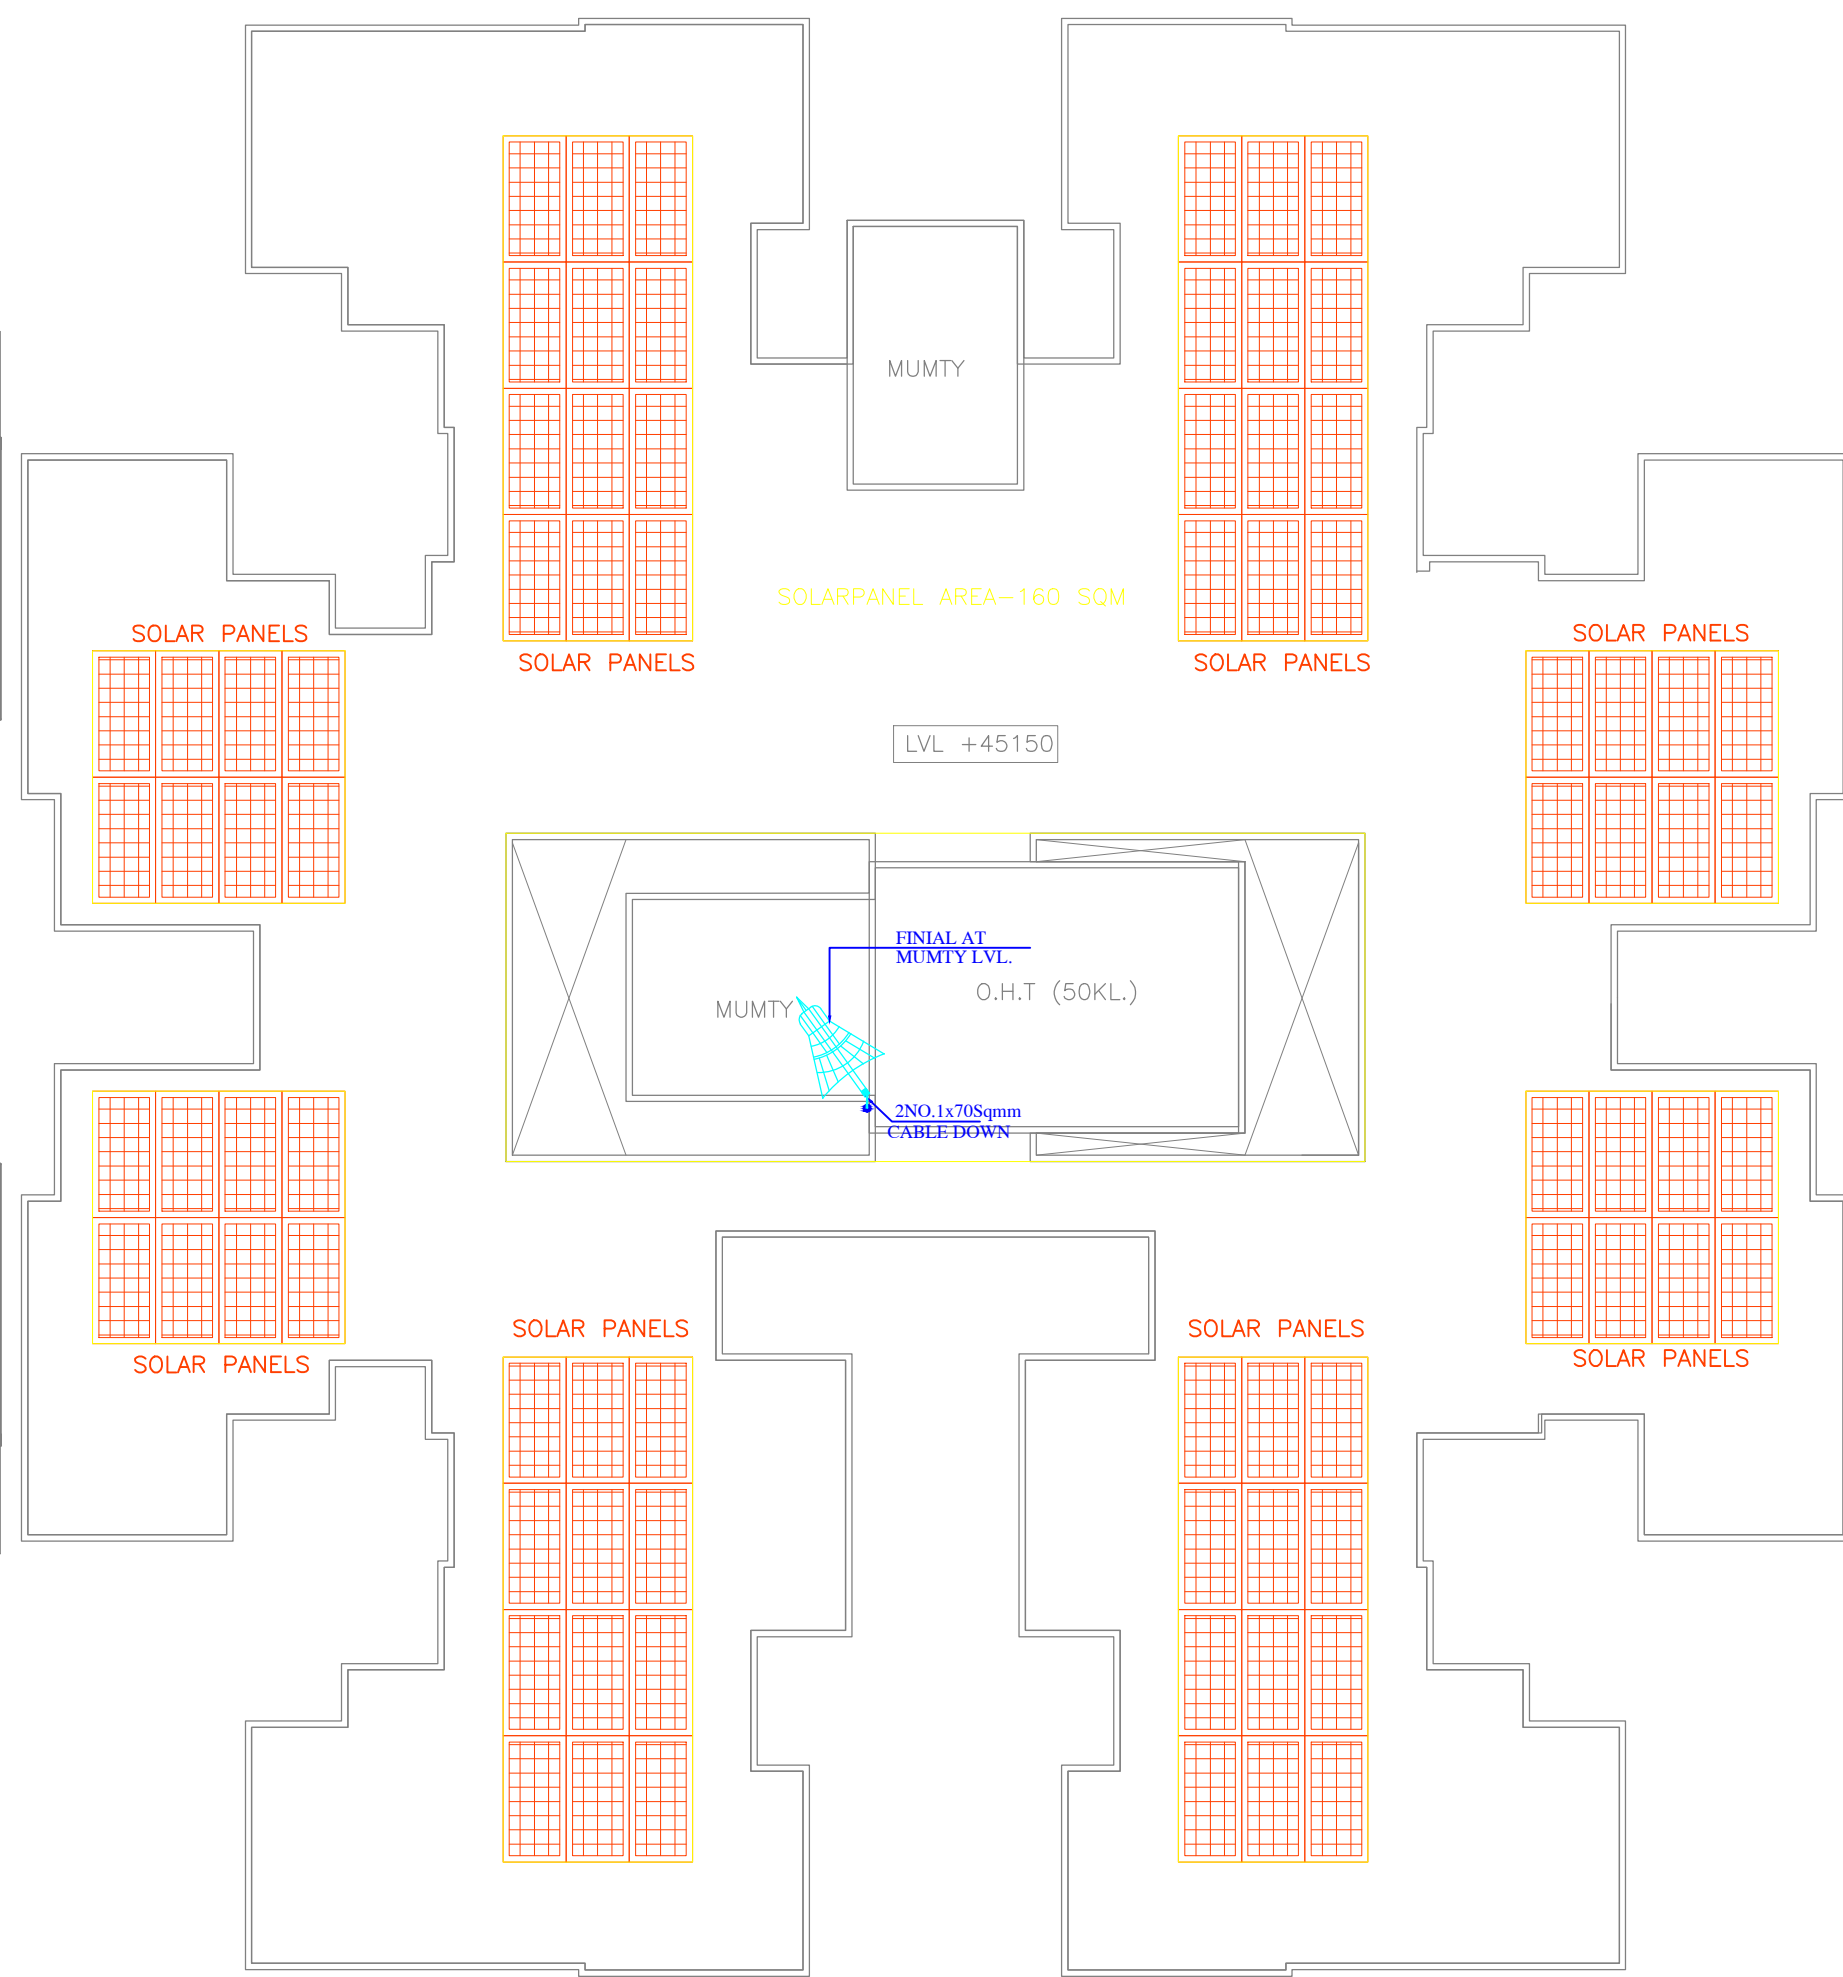

TERRACE PLAN

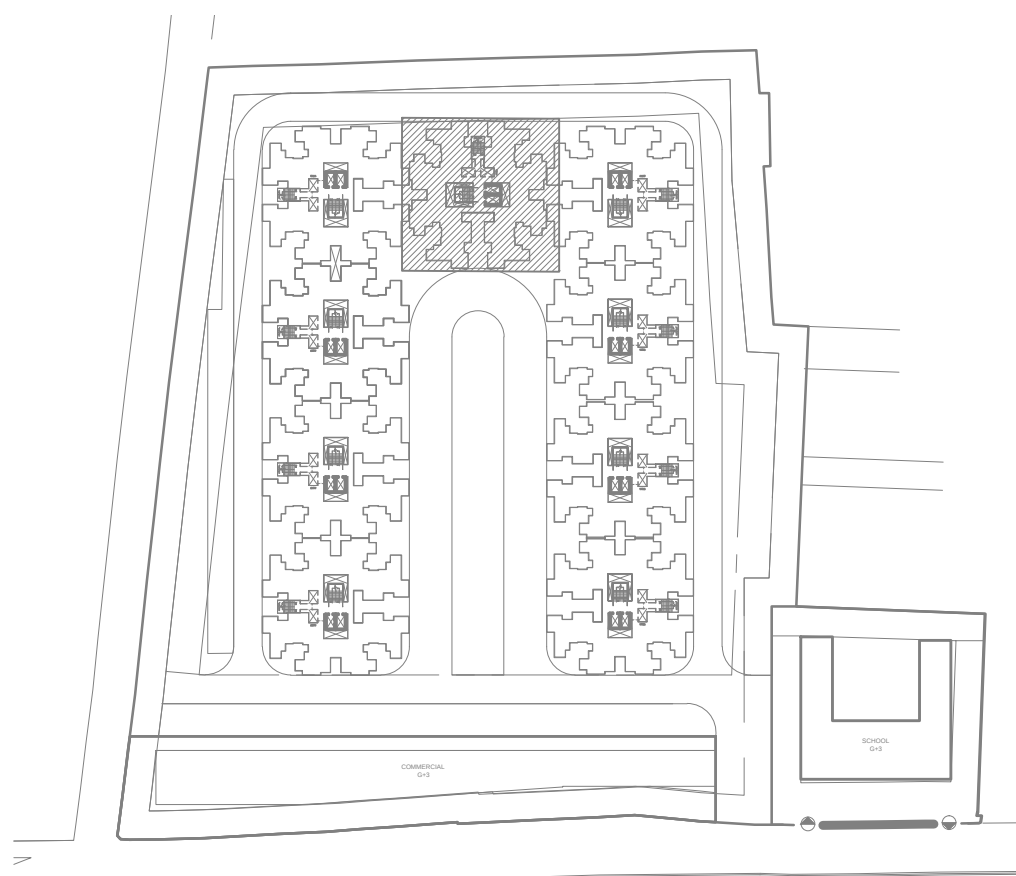

KEY PLAN

FIRE LEGEND:

SYB.	DESCRIPTION	QUANTITY
	HOOTER CUM STROBE FLASHER	210
	MANUAL CALL POINT	110
	PV PANEL	

PV LEGEND:

SYB.	DESCRIPTION	QUANTITY
	FINIAL	
	GREEN CABLE FOR LIGHTNING PROTECTION	

NOTES:
THIS ENTIRE DEVELOPEMENT HAS BEEN CONCEIVED
DESIGNED AND DRAFTED ON THE BASIS OF THE FOLLOWING
PARAMETRES.
1. ALL DIMENSIONS. ARE IN MM.
2. DIMENSIONS NOT TO BE SCALED

DRAWING TITLE:
FIRE ALARM - TYPICAL FLOOR PLAN

PROJECT TITLE:
ANTHELA- AFFORDABLE HOUSING AT
SECTOR 12D,AWAS VIKAS SIKANDRA
YOJNA, AGRA

CLIENT:
M/S OP CHAINS HOUSINGS LLP &
M/S BHARAT NAGAR HOUSING

DRAWN BY:
NIKITA

CHECKED BY:
DD UPADHYAY

SHEET NO.

SCALE 1:100

NORTH:

CLIENT

ARCHITECT

PREETISH KHATWANI
ARCHITECT
C/NO 15/100

ARCHITECT:
NEXUSPLUS
CONSULTANTS PVT. LTD.
B-116 2ND FLOOR, SECTOR-50,
NOIDA-201301
PHONE NO. 0120 4355781 / 4250663

nexus
architects