


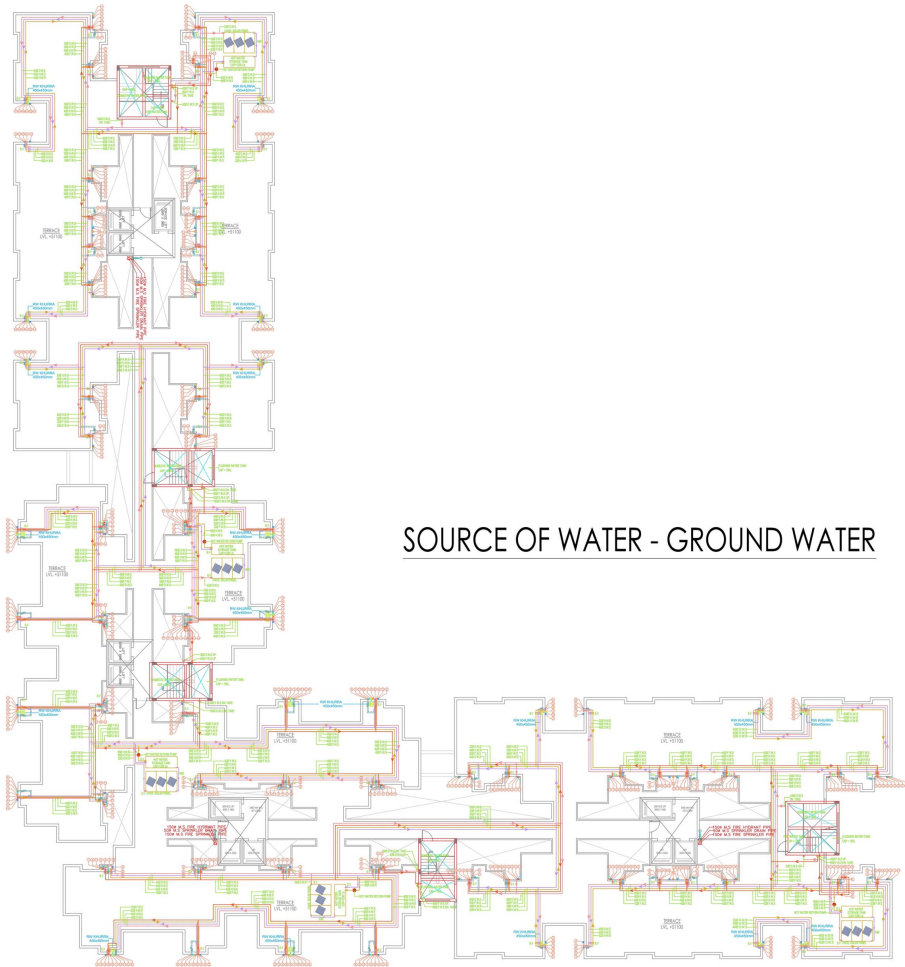

LEGEND FOR PLUMBING :	
①	1/2" OD SANI PVC SOIL & VENT PIPE
②	1/2" OD SANI PVC SOIL & VENT PIPE
③	1/2" OD SANI PVC WASTE & VENT PIPE
④	DOMESTIC WATER SUPPLY ON TAKE PIPE
⑤	FLUSHING WATER SUPPLY ON TAKE PIPE
⑥	DOMESTIC WATER SUPPLY ON TAKE PIPE TO UPPER FLOOR
⑦	FLUSHING WATER SUPPLY ON TAKE PIPE TO UPPER FLOOR
⑧	HOT WATER SUPPLY
⑨	HOT WATER RETURN
⑩	PWS RISER TO CH.T. FILLING
⑪	PWS RISER TO CH.T. FILLING
⑫	TRSD UPVC SANI WATER PIPE FOR BALCONY
⑬	TRSD UPVC SANI WATER PIPE FOR TERRACE
⑭	TRSD UPVC WED. SPRINKLING PIPE
⑮	COPROD Shower/Bathtub
F.D	FLOOR DRAIN
F.T	FLOOR TRAP

SOURCE OF WATER - GROUND WATER

DES ARC ARCHITECTS, INTERIORS, PLANNING UGSR - 1A, ANSAL PLAZA , SECTOR - I, VAISHALI, GZB PH: 0120 - 4253114 M : 0-9818711273 EMAIL- desarc14@gmail.com	PROJECT : PROPOSED AFFORDABLE HOUSING " SAI CITY " UNDER " P . M . A . Y " , AT DASEPUR , VARANASI FOR M/S : SHREE SAI BABA INFRA PROJECTS PVT. LTD.	DRAWING TITLE TERRACE FLOOR PLAN (TOWER 01)	DRAWING TYPE PLUMBING LAYOUT
		SCALE 1:200	DRG. NO. PL/PMAY/T-01/02

12.0 M. WIDE ROAD

SOURCE OF WATER - GROUND WATER

STORM WATER DRAINAGE:-

	DRAINAGE MANHOLE
	CATCH BASIN
	GROUND LEVEL
	INVERT LEVEL
	CONNECTION LEVEL
SIZE OF PIPE	SLOPE
150Ø	1:200
300Ø	1:350

HOUSING
(S + 16)

12.0 M. WIDE ROAD

108864

59103

59045

17594

34607

2033

22670

59103

17594

34607

2033

22670

59103

