


OTHER PLOT COMMUNITY CENTER

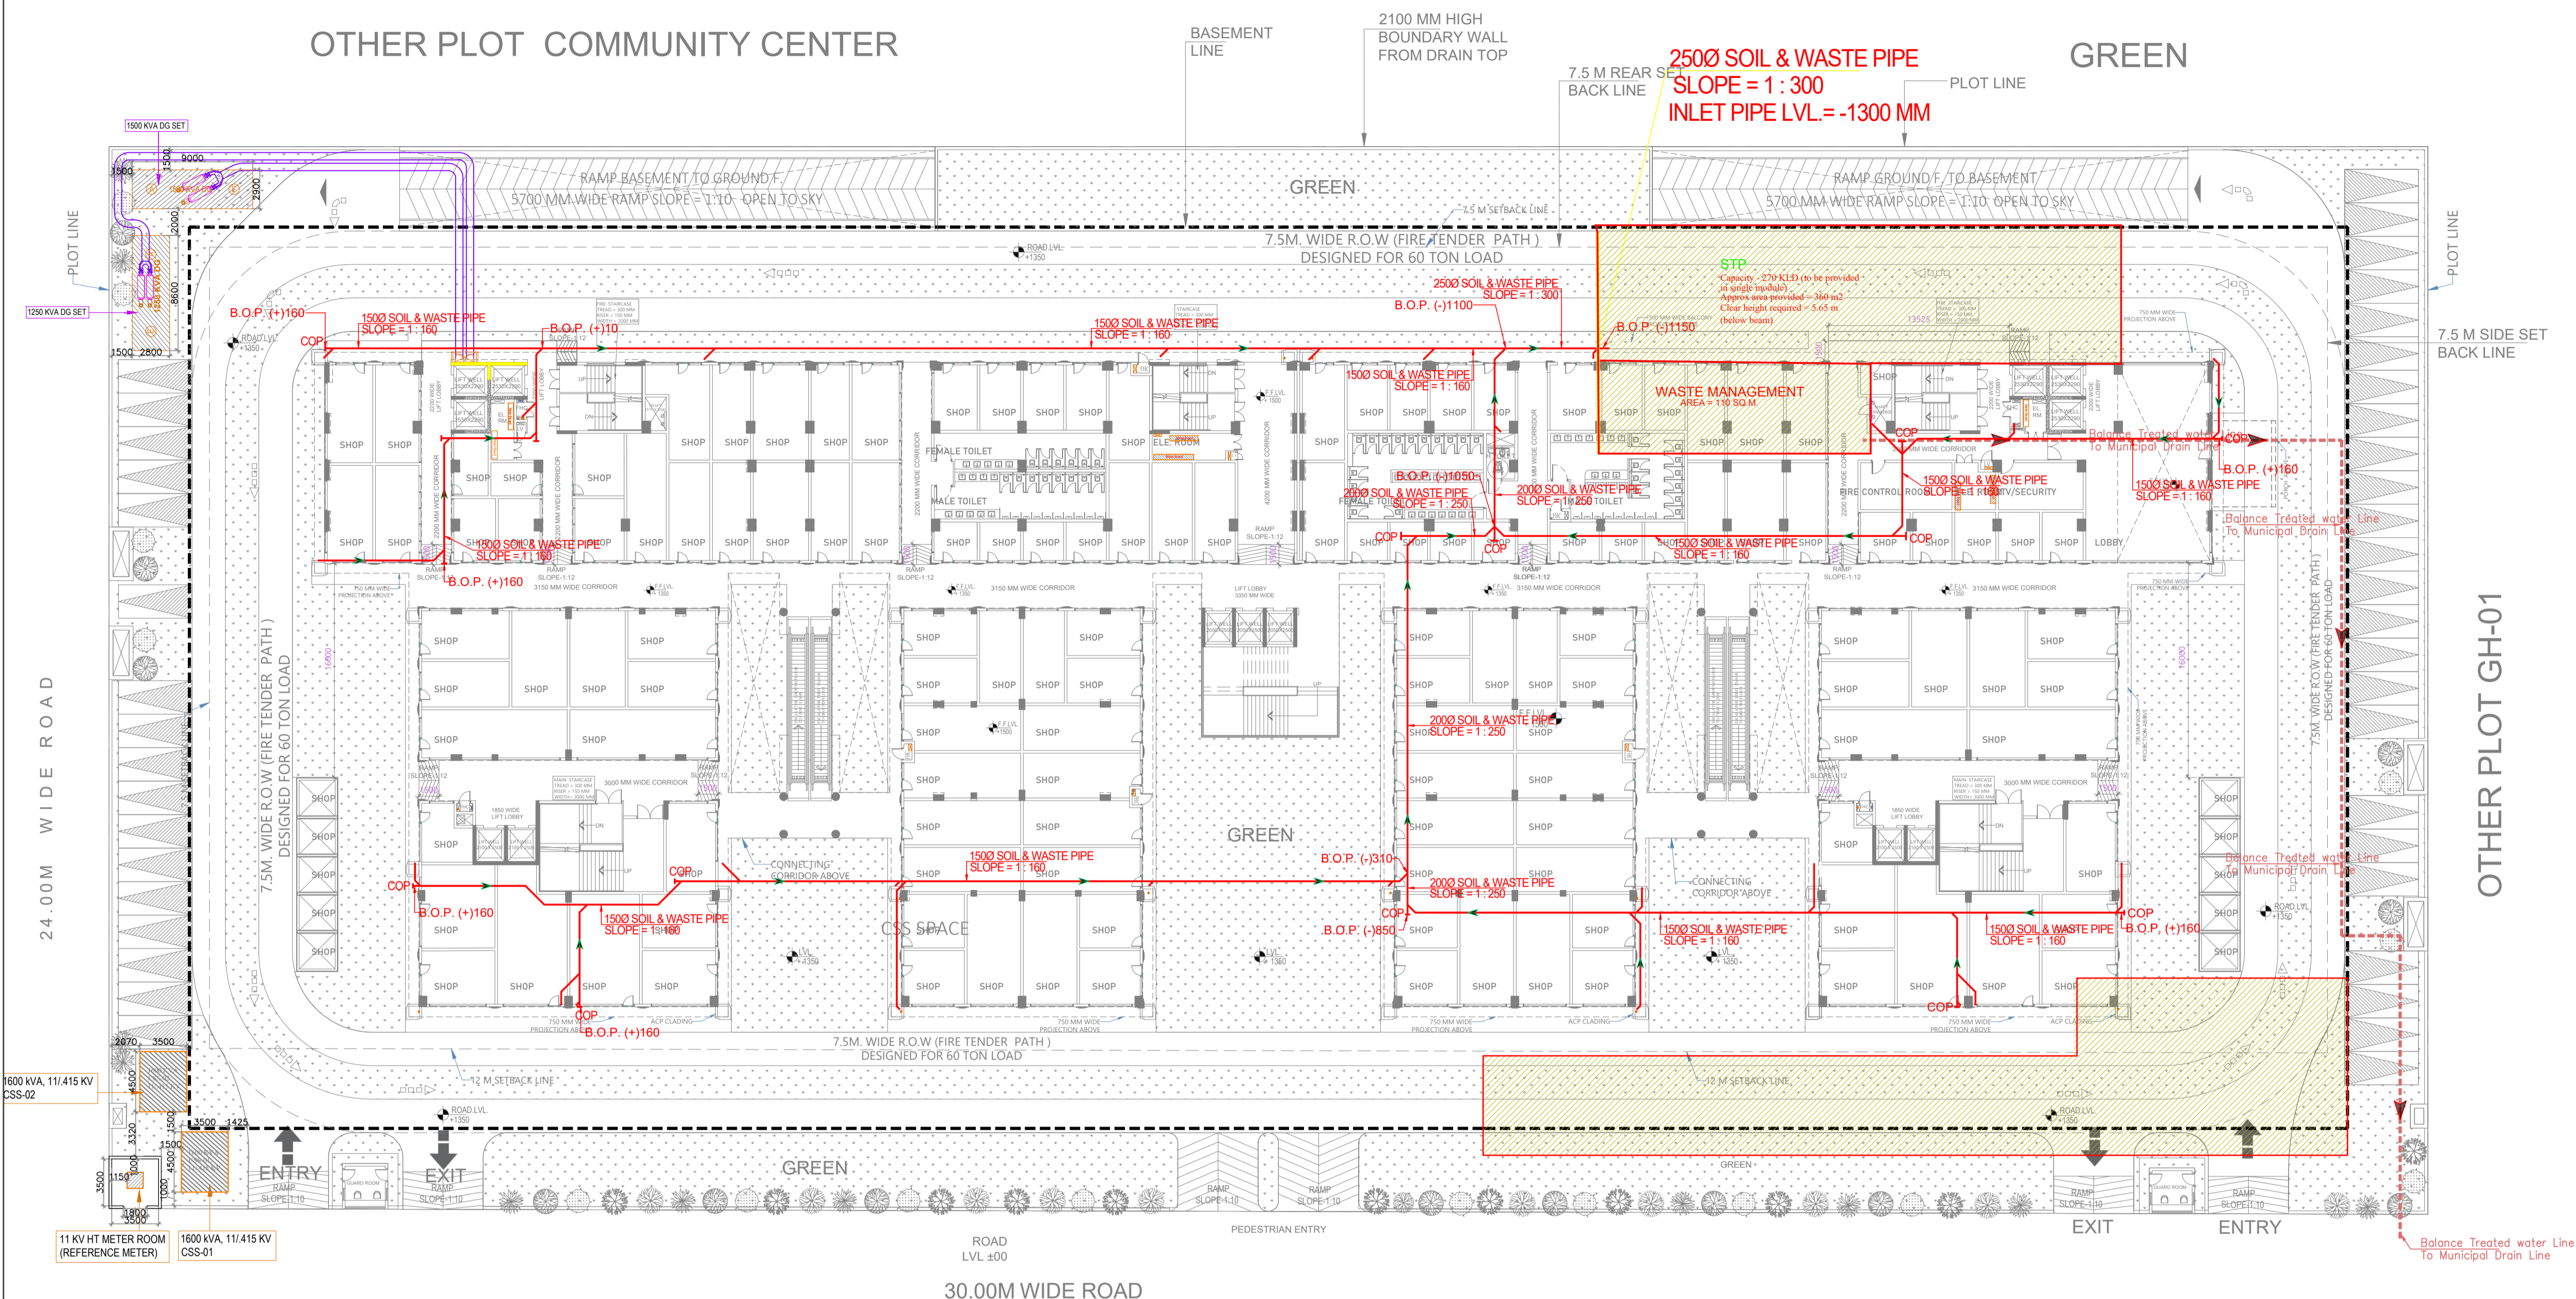

LEGEND :

S. No.	SYMBOL	DESCRIPTION
1.	-----	SEWER LINE
2.	-----	BYPASS SEWER LINE
3.	-----	BASEMENT LINE

Rev. No.	Date	Revision

OWNER
M/S LOGIX BULDESTATE PVT. LTD.

project
PROPOSED COMMERCIAL CENTER C-1 AT PLOT NO. TS-1B, SECTOR-22D, YAMUNA EXPRESSWAY, (U.P.) BELONGING TO

title M/S LOGIX BULDESTATE PVT. LTD.
SITE PLAN

subtitle
EXTERNAL SEWERAGE SERVICES

drawing released for
 APPROVAL SUBMISSION
 ADVANCE COPY CONSTRUCTION

drg. no. COMMERCIAL/EX / S-01 **drawn by** Kulwant

scale 1 : 300 **designed by** R.K.

date Mar. 2025 **checked by** Anand Havelia

architects
Confluence
 NEW DELHI, INDIA
 F-1, FIRST FLOOR, MIRRA CORPORATE SUITES,
 ISHWAR NAGAR, NEW DELHI 110085
 Ph- +91-11-26926688 confluence.cdno member of ICBG
 Ph- +91-11-40564768 confluence.cdno - 9001 : 2000
 architecture urban design hospitality interiors

services consultant
Cespl Consultants Pvt. Ltd.
 Huda Office : B - 67, Sector - 67, Noida - 201 301
 Tel : (0120) 3225400 / 3225401
 e mail : mail@cespl.in, website : www.cespl.in