


LEGEND :		
S. No.	SYMBOL	DESCRIPTION
1.	C.P.	CATCH PIT
2.	—○—	UNDER GROUND PIPE DRAIN
3.	—○—	EXISTING DRAINAGE CATCH PIT
4.	■	CATCH PIT (600x600mm)
5.	○	RAIN WATER HARVESTING
6.	R.L.	ROAD LEVEL
7.	I.L.	INVERT LEVEL
8.	C.L.	CONNECTION LEVEL
9.	④	2500 STORM WATER PIPE (SLOPE:1:350)
10.	⑤	3000 STORM WATER PIPE (SLOPE:1:450)
11.	⑥	4000 STORM WATER PIPE (SLOPE:1:500)

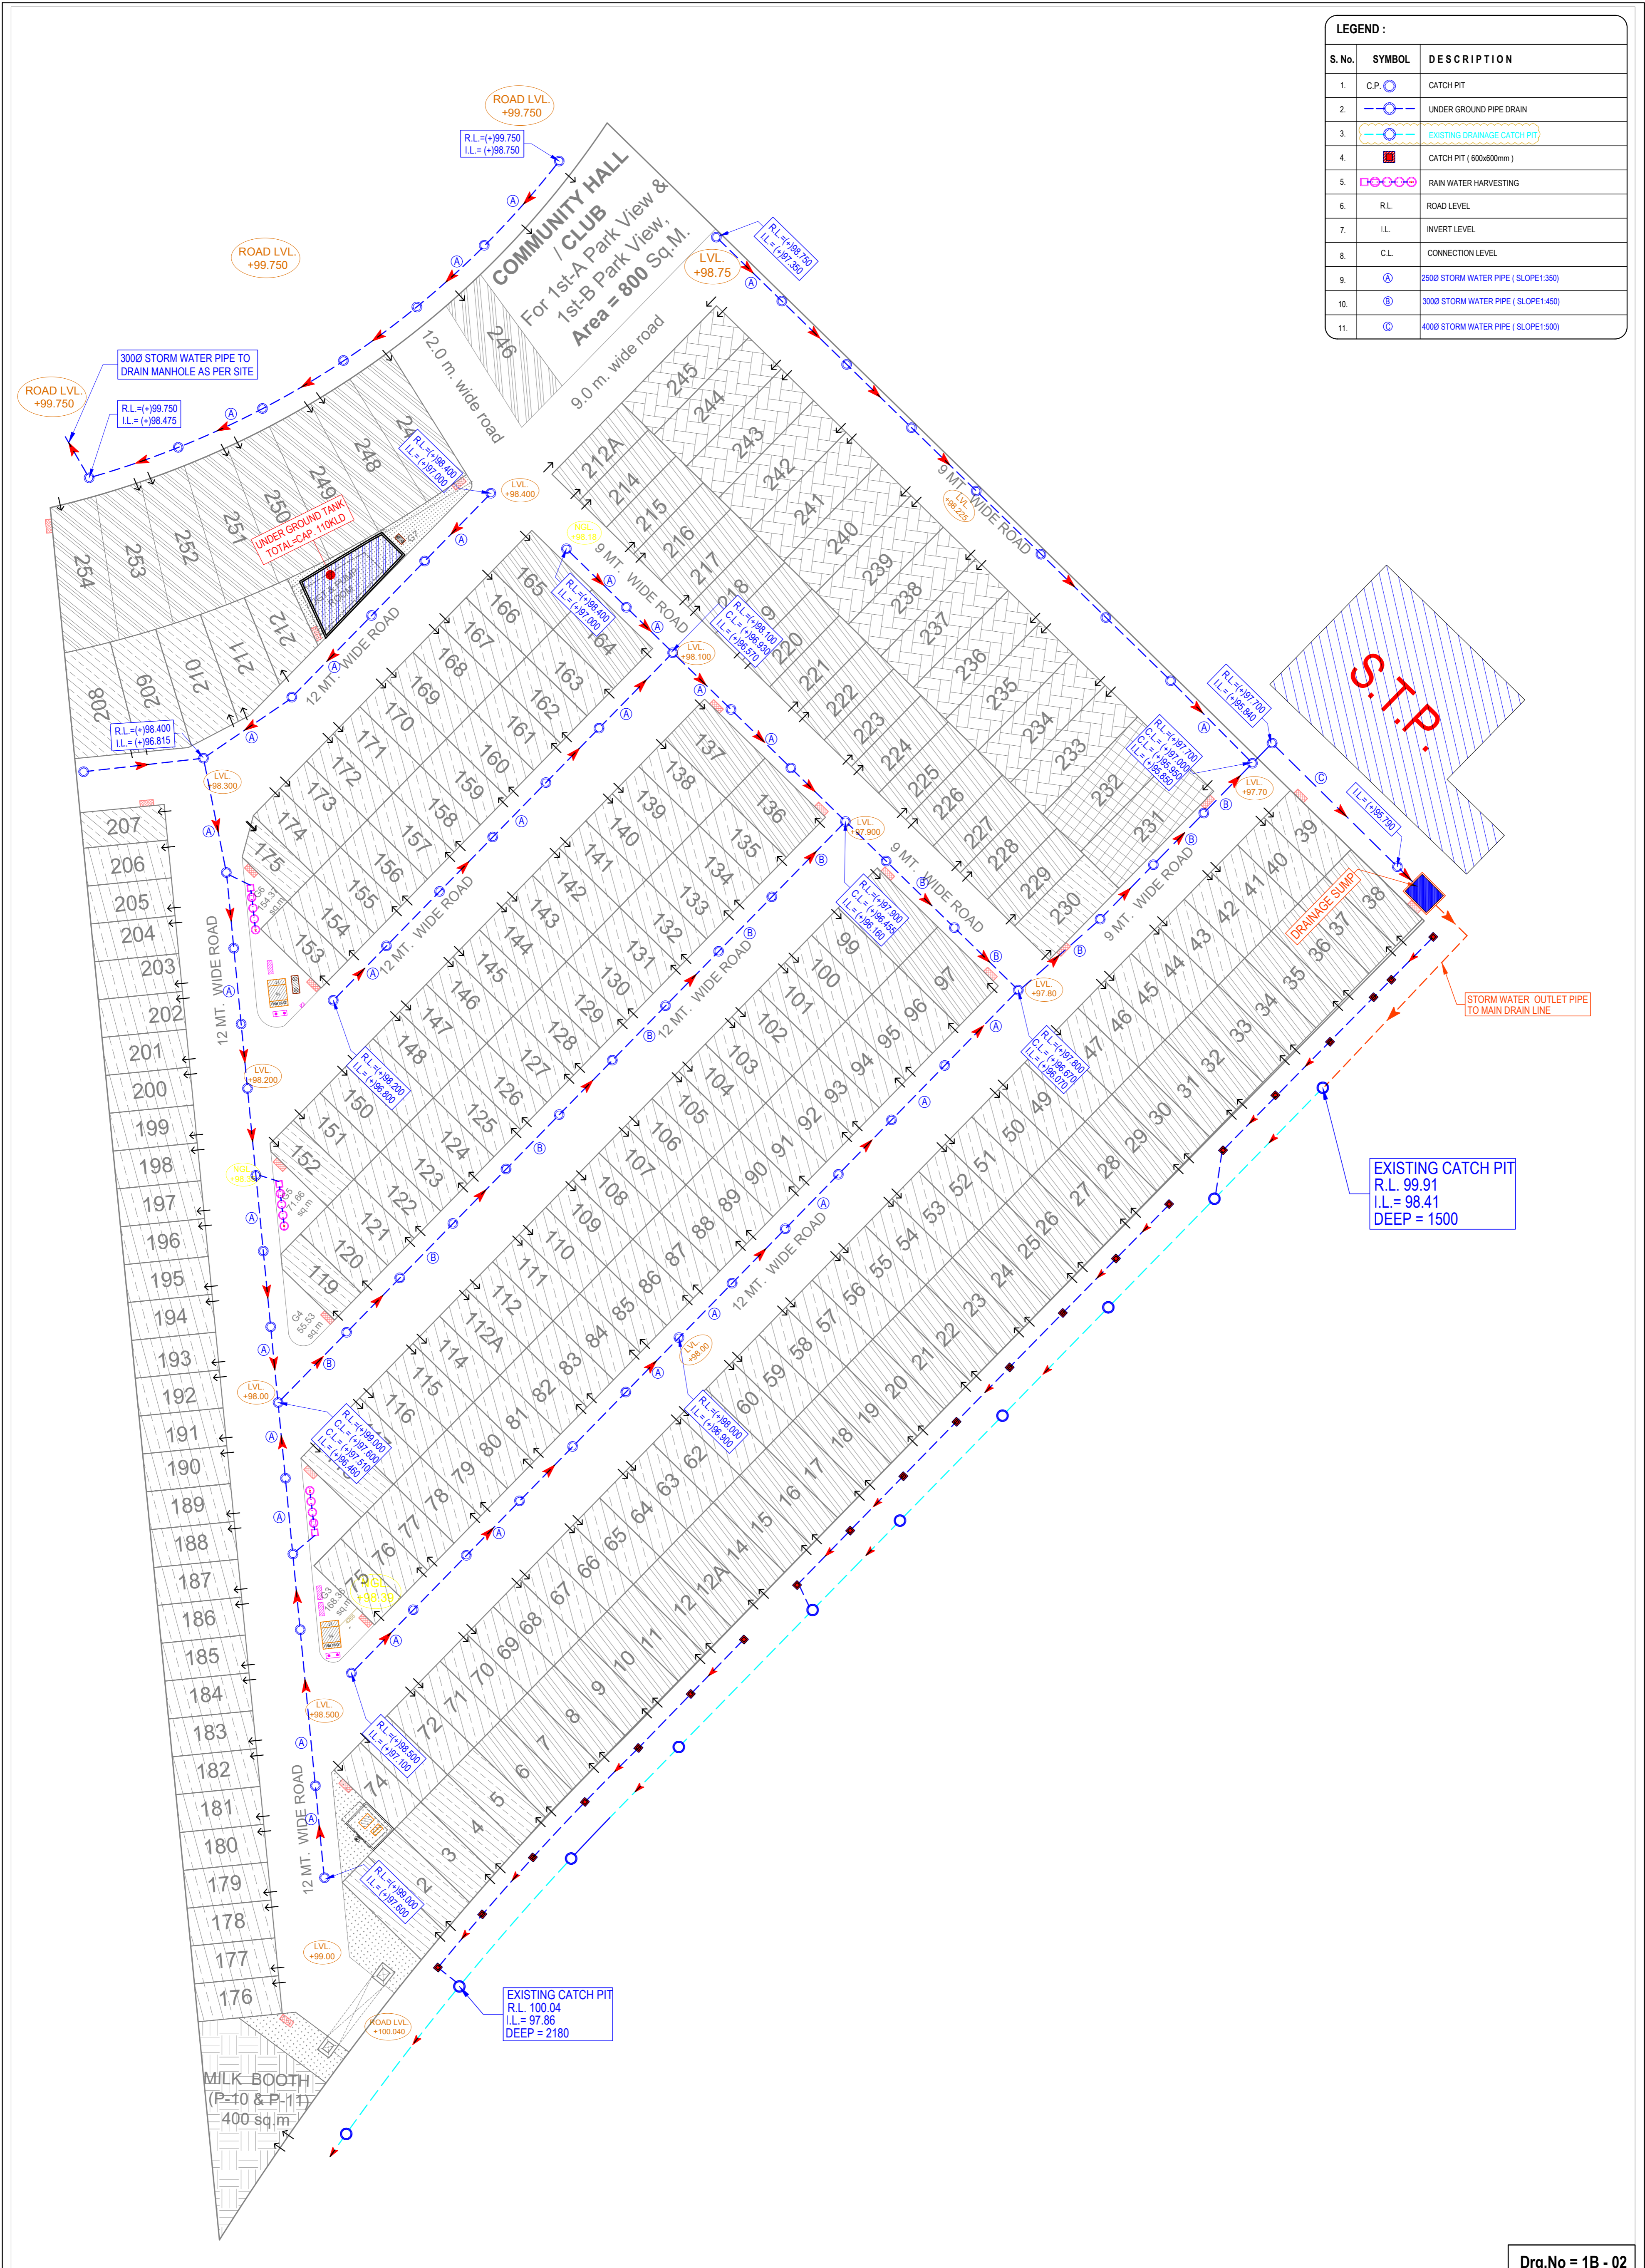

Drg.No = 1B - 02

PROPOSED VICTORIAN VILLAS
1st-B PARK VIEW-
GAUR YAMUNA CITY-
GREATER NOIDA

Title : **SITE PLAN**
 Subtitle : **EXTERNAL DRAINAGE LAYOUT**

Drawing Released For :
 APPROVAL
 ADVANCE COPY
 SUBMISSION
 CONSTRUCTION


Drg. No : GYC / 1st-B / SP / PL - 02
 Date : 23.07.2020
 Scale : A1@1:500

Drawn By : S.Bhandari
 Design By : Shkir Shabbir
 Ckd By : Anand Havela

architects
BRJ (INDIA) ARCHITECTS
 F-89, GREEN PARK, NEW DELHI - 16.
 Ph. +91-11-26853815, 26858307, Fax : +91-11-26850788
 E-mail : bjarch.atwin@gmail.com
 Website: www.atwin.in

services consultant
Consummate Engineering Services (P) Ltd.
 Noida Office : B - 67, Sector - 67, Noida - 201 301
 Tel : (0120) 26943500 (24 Lines)
 Lko. Office : R 006, Rohtas Puri, Gomi Nagar, Lucknow
 e mail : mail@cespl.in, website : www.cespl.in

LEGEND :		
S. No.	SYMBOL	DESCRIPTION
1.	M.H.	MANHOLE
2.	—○—	SEWER LINE
3.	—○—	EXISTING SEWER MANHOLE
4.	○	MANHOLE (900x800mm)
5.	○	2000 SEWER PIPE (SLOPE 1:200)
6.	○	2500 SEWER PIPE (SLOPE 1:250)
7.	R.L.	ROAD LEVEL
8.	IL	INVERT LEVEL
9.	C.L.	CONNECTION LEVEL

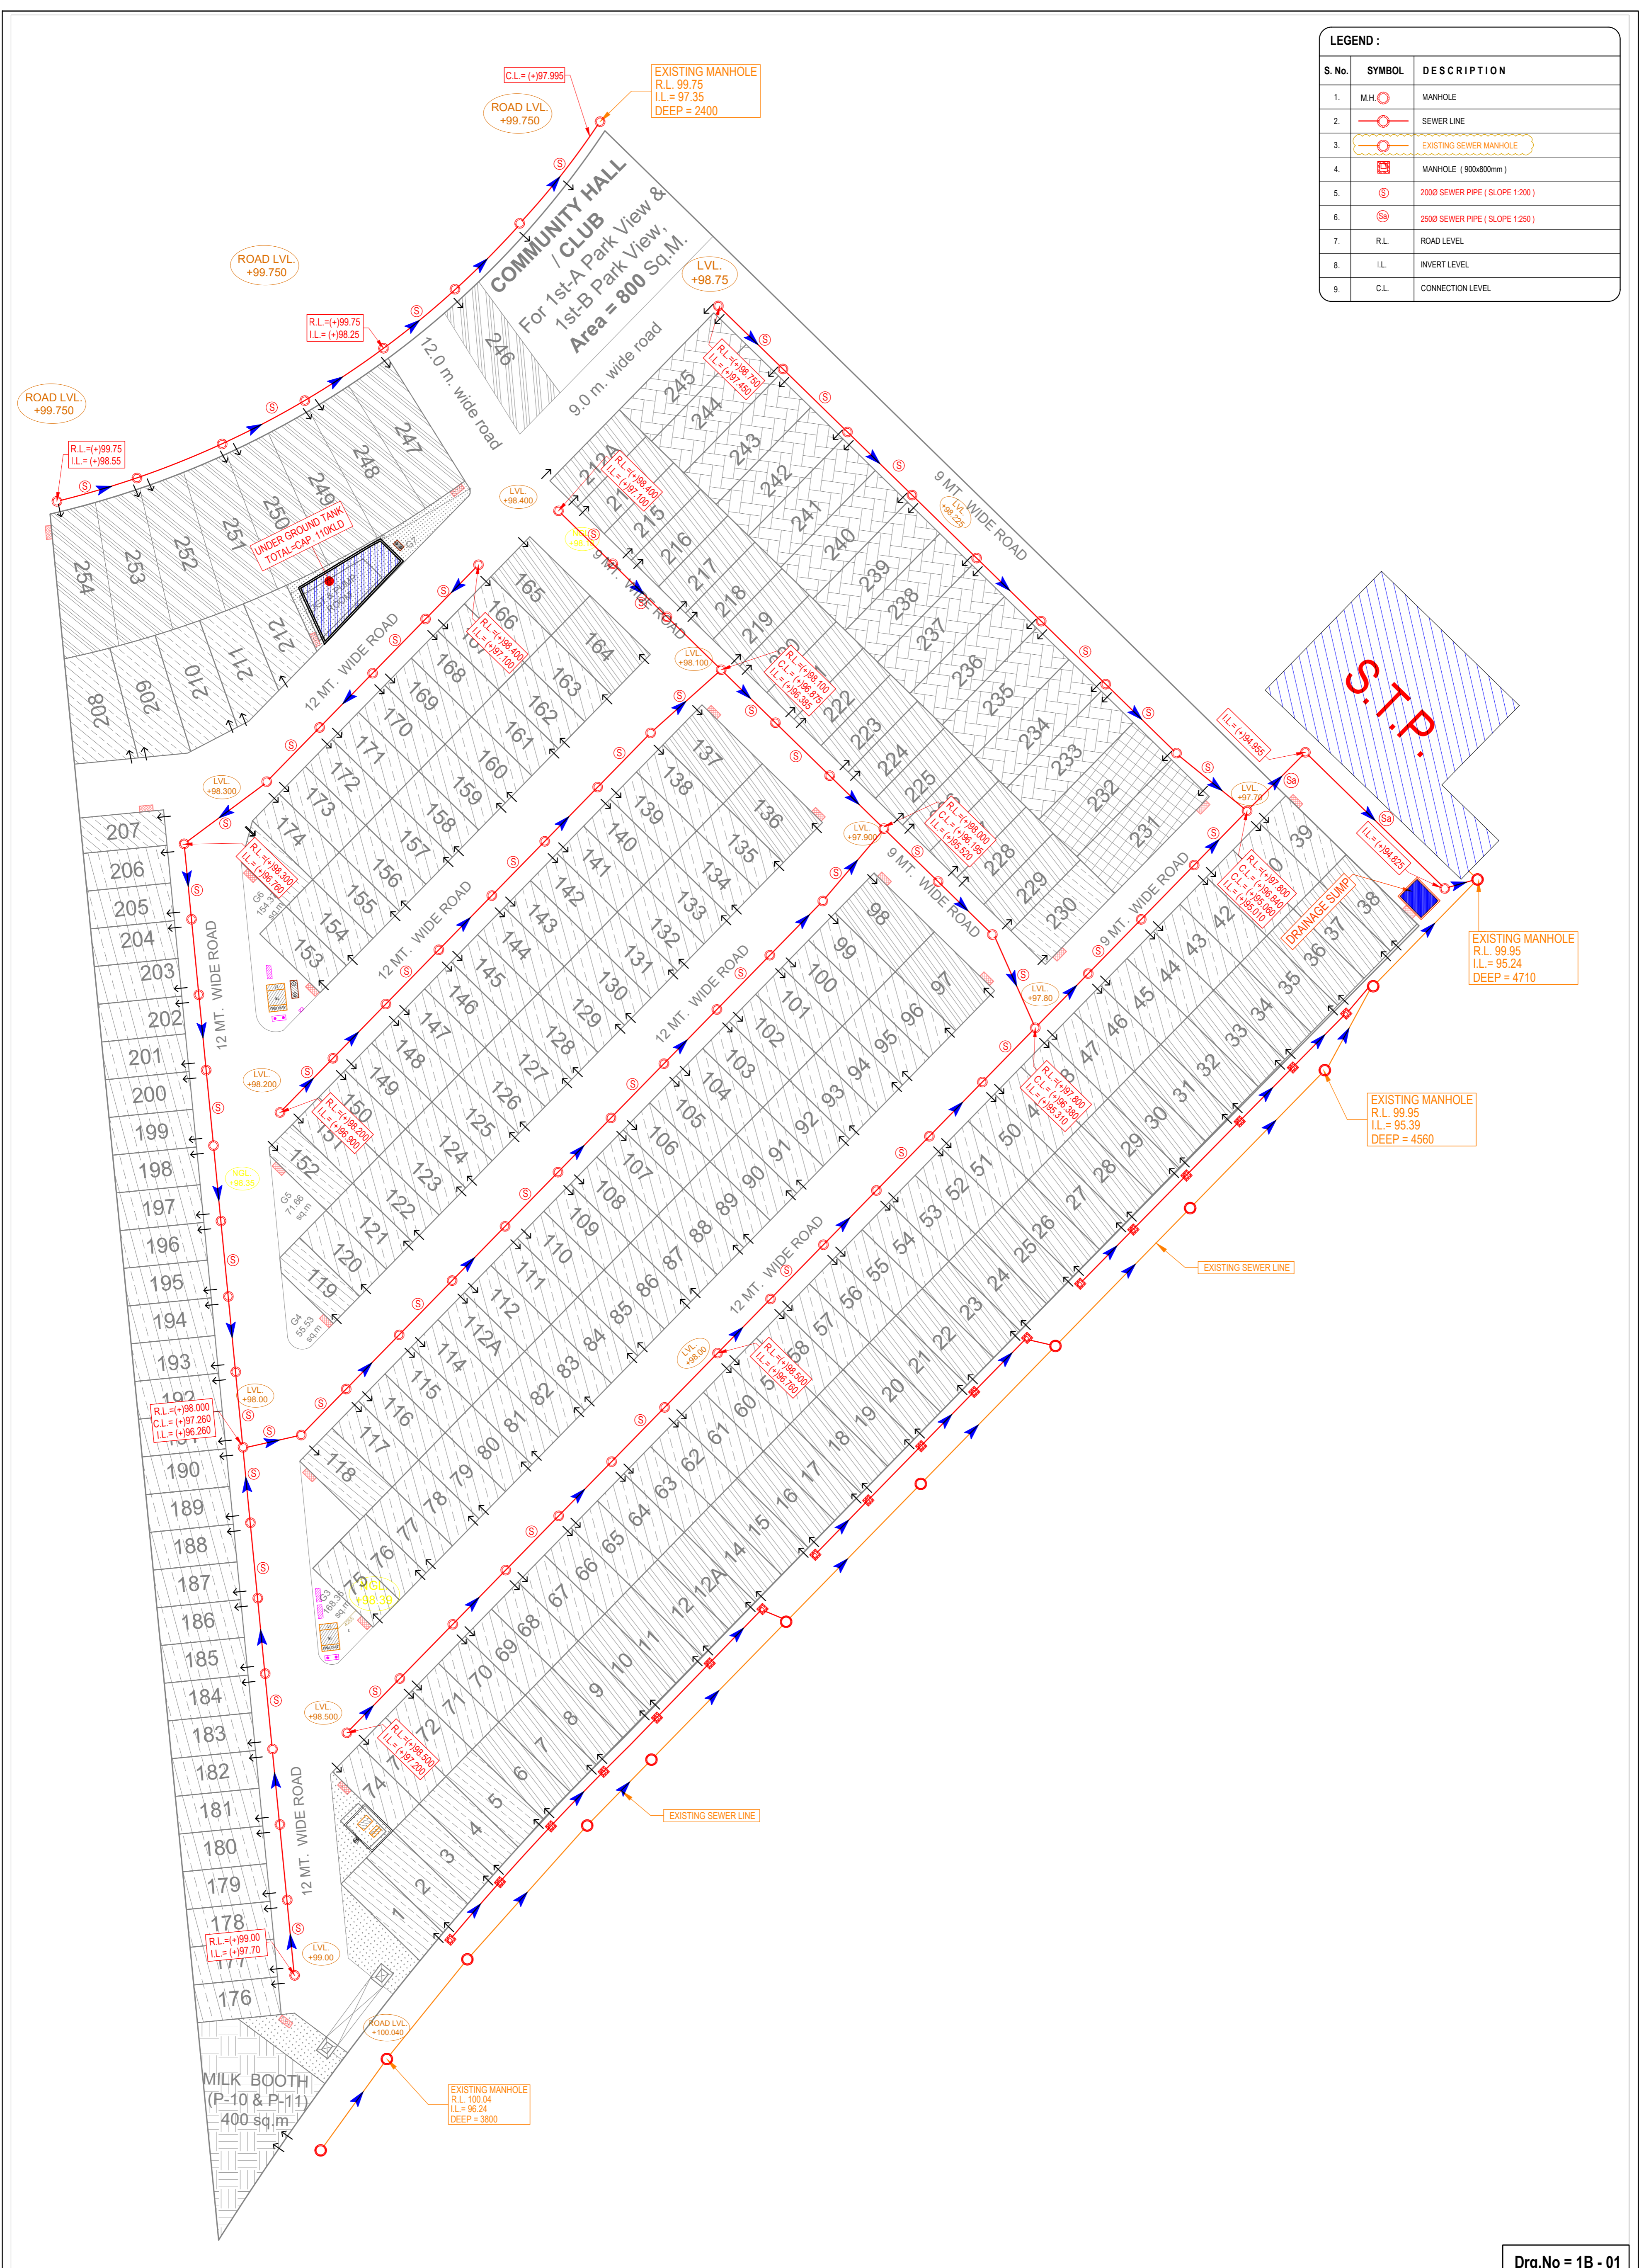

Drg.No = 1B - 01

PROPOSED VICTORIAN VILLAS
 1st-B PARK VIEW- GAUR YAMUNA CITY- GREATER NOIDA

Title : **SITE PLAN**
 Subtitle : **EXTERNAL SEWERAGE LAYOUT**

Drawing Released For :
 APPROVAL
 ADVANCE COPY
 SUBMISSION
 CONSTRUCTION

Drg. No : GYC / 1st-B / SP / PL - 01
 Date : 23.07.2020
 Scale : A1@1:500

Drawn By : S.Bhandari
 Design By : Shakir Shabbir
 Ckd By : Anand Havela

architects
BRJ (INDIA) ARCHITECTS
 F-89, GREEN PARK, NEW DELHI - 16.
 Ph. +91-11-26853815, 26858307, Fax : +91-11-26850788
 E-mail : biarch.atwin@gmail.com
 Website: www.atwin.in

services consultant
Consummate Engineering Services (P) Ltd.
 Noida Office : B - 67, Sector - 67, Noida - 201 301
 Tel : (0120) 26943500 (24 Lines)
 Lko. Office : R 006, Rohtas Puri, Gomi Nagar, Lucknow
 e mail : mail@cespl.in, website: www.cespl.in