


LEGEND :	
SUBSTATION	
FEEDER PILLAR	FP
STREET LIGHT POLE (9.0M. PCC POLE) SINGLE LINE	P
DOUBLE ARM POLE (9.0M. PCC POLE)	
H.T. U/G CABLE	
L.T. U/G CABLE	
EARTH PIT	

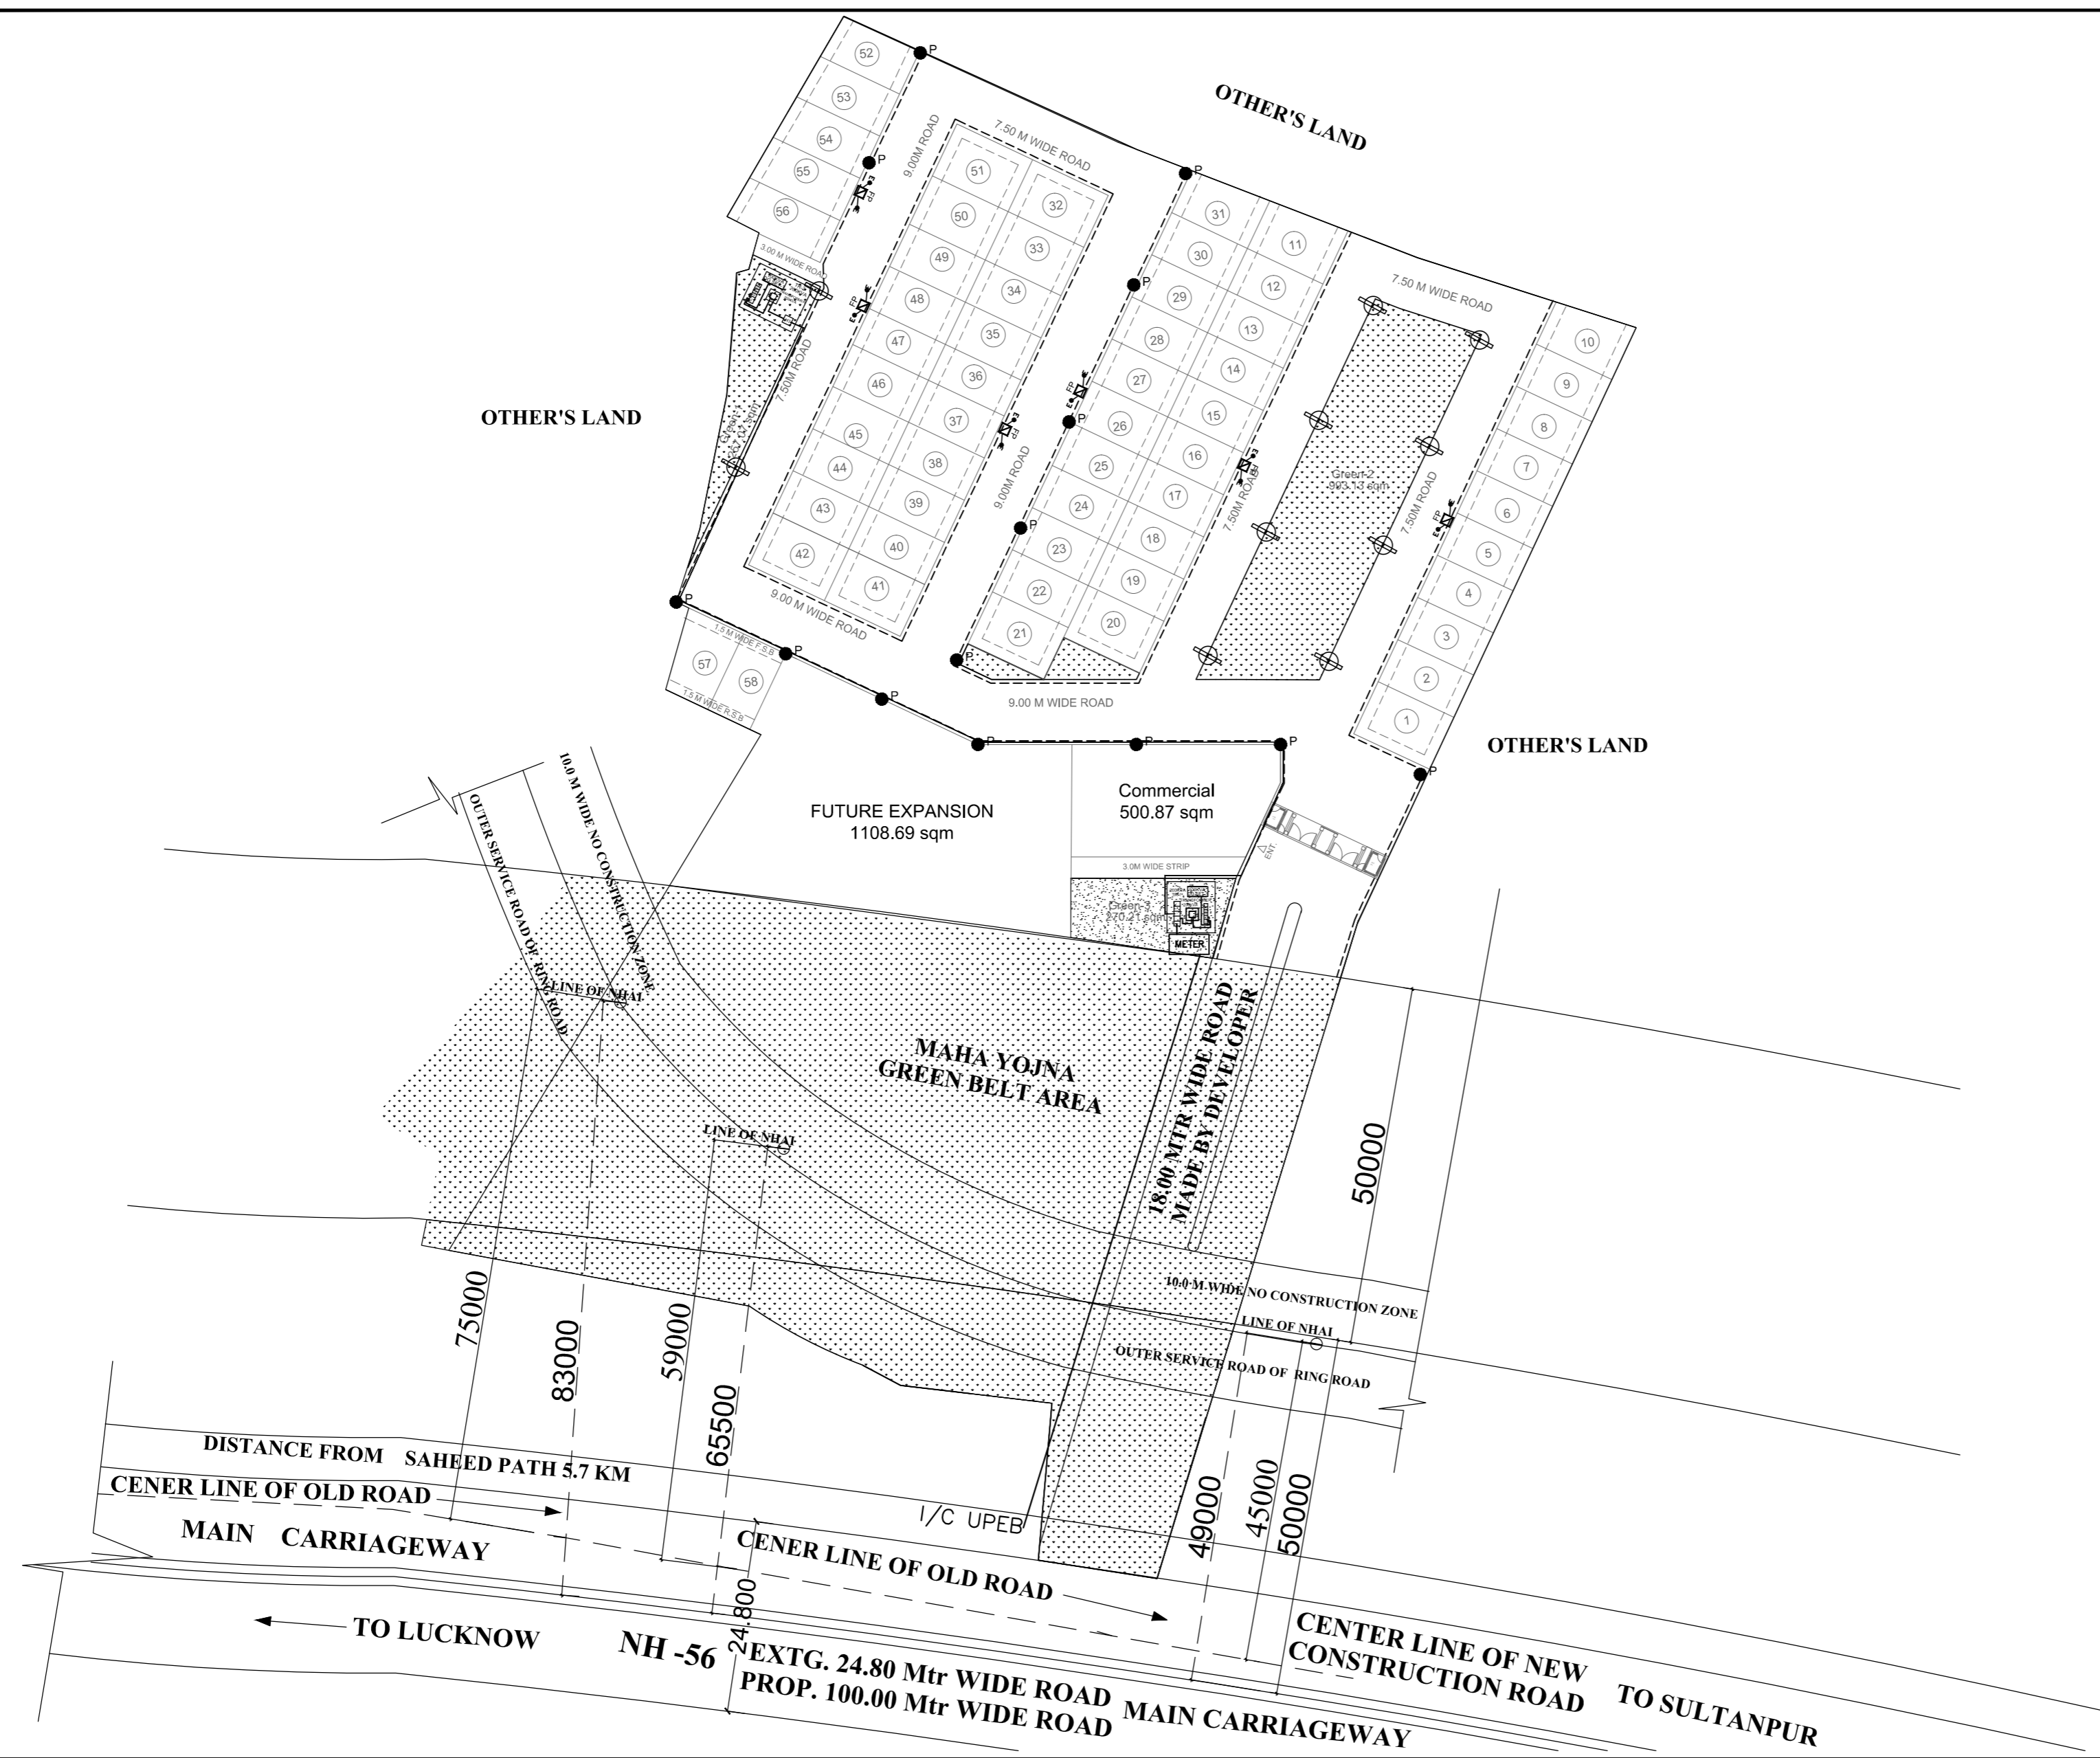

Owner Sign :

UNIWORLD INFRA TECH PVT. LTD., MUKESH KUMAR SRIVAS & SANFRAN DEVELOPER PVT. LTD.

Architect's Sign :

Project : PROPOSED COMBINED SERVICES LAYOUT PLAN OF RESIDENTIAL COLONY 'SANFRAN CITY' LOCATED AT KHASRA NOS. - 2899, 2900, 2908/1, 2908/2, 2910, 2911, 2912, 2913, 2914, 2915, 2916, 2917, 2918, 2919, 2920 & 2923
VILL- BAKKAS, DIST-LUCKNOW (U.P.)

Owner : UNIWORLD INFRA TECH (P) LTD., MUKESH KUMAR SRIVAS & SANFRAN DEVELOPER (P) LTD.

Title : ELECTRICAL LAYOUT PLAN

Drawing Released For :

- APPROVAL
- ADVANCE COPY
- SUBMISSION
- CONSTRUCTION

Drg. No : SCL / SD / R-01 / EL-01


Drawn By : Sumit

Date : 24 March 2019

Scale : 1:500

Design By : Ganesh H

Cheked By : Priyanka

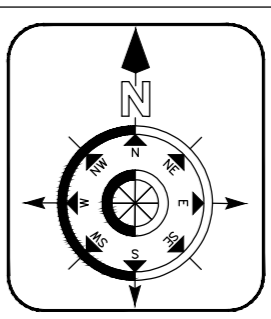

Architects :

SPACE CREATIONS
 ARCHITECTS PLANNERS ENGINEERS
 NEW DELHI BANGALORE