


CLIENT

LOTUS GREENS

ELDECO

PROJECT

ELDECO LIVE BY THE GREENS
SC02/A9, SPORTS CITY,
SEC.150, NOIDA

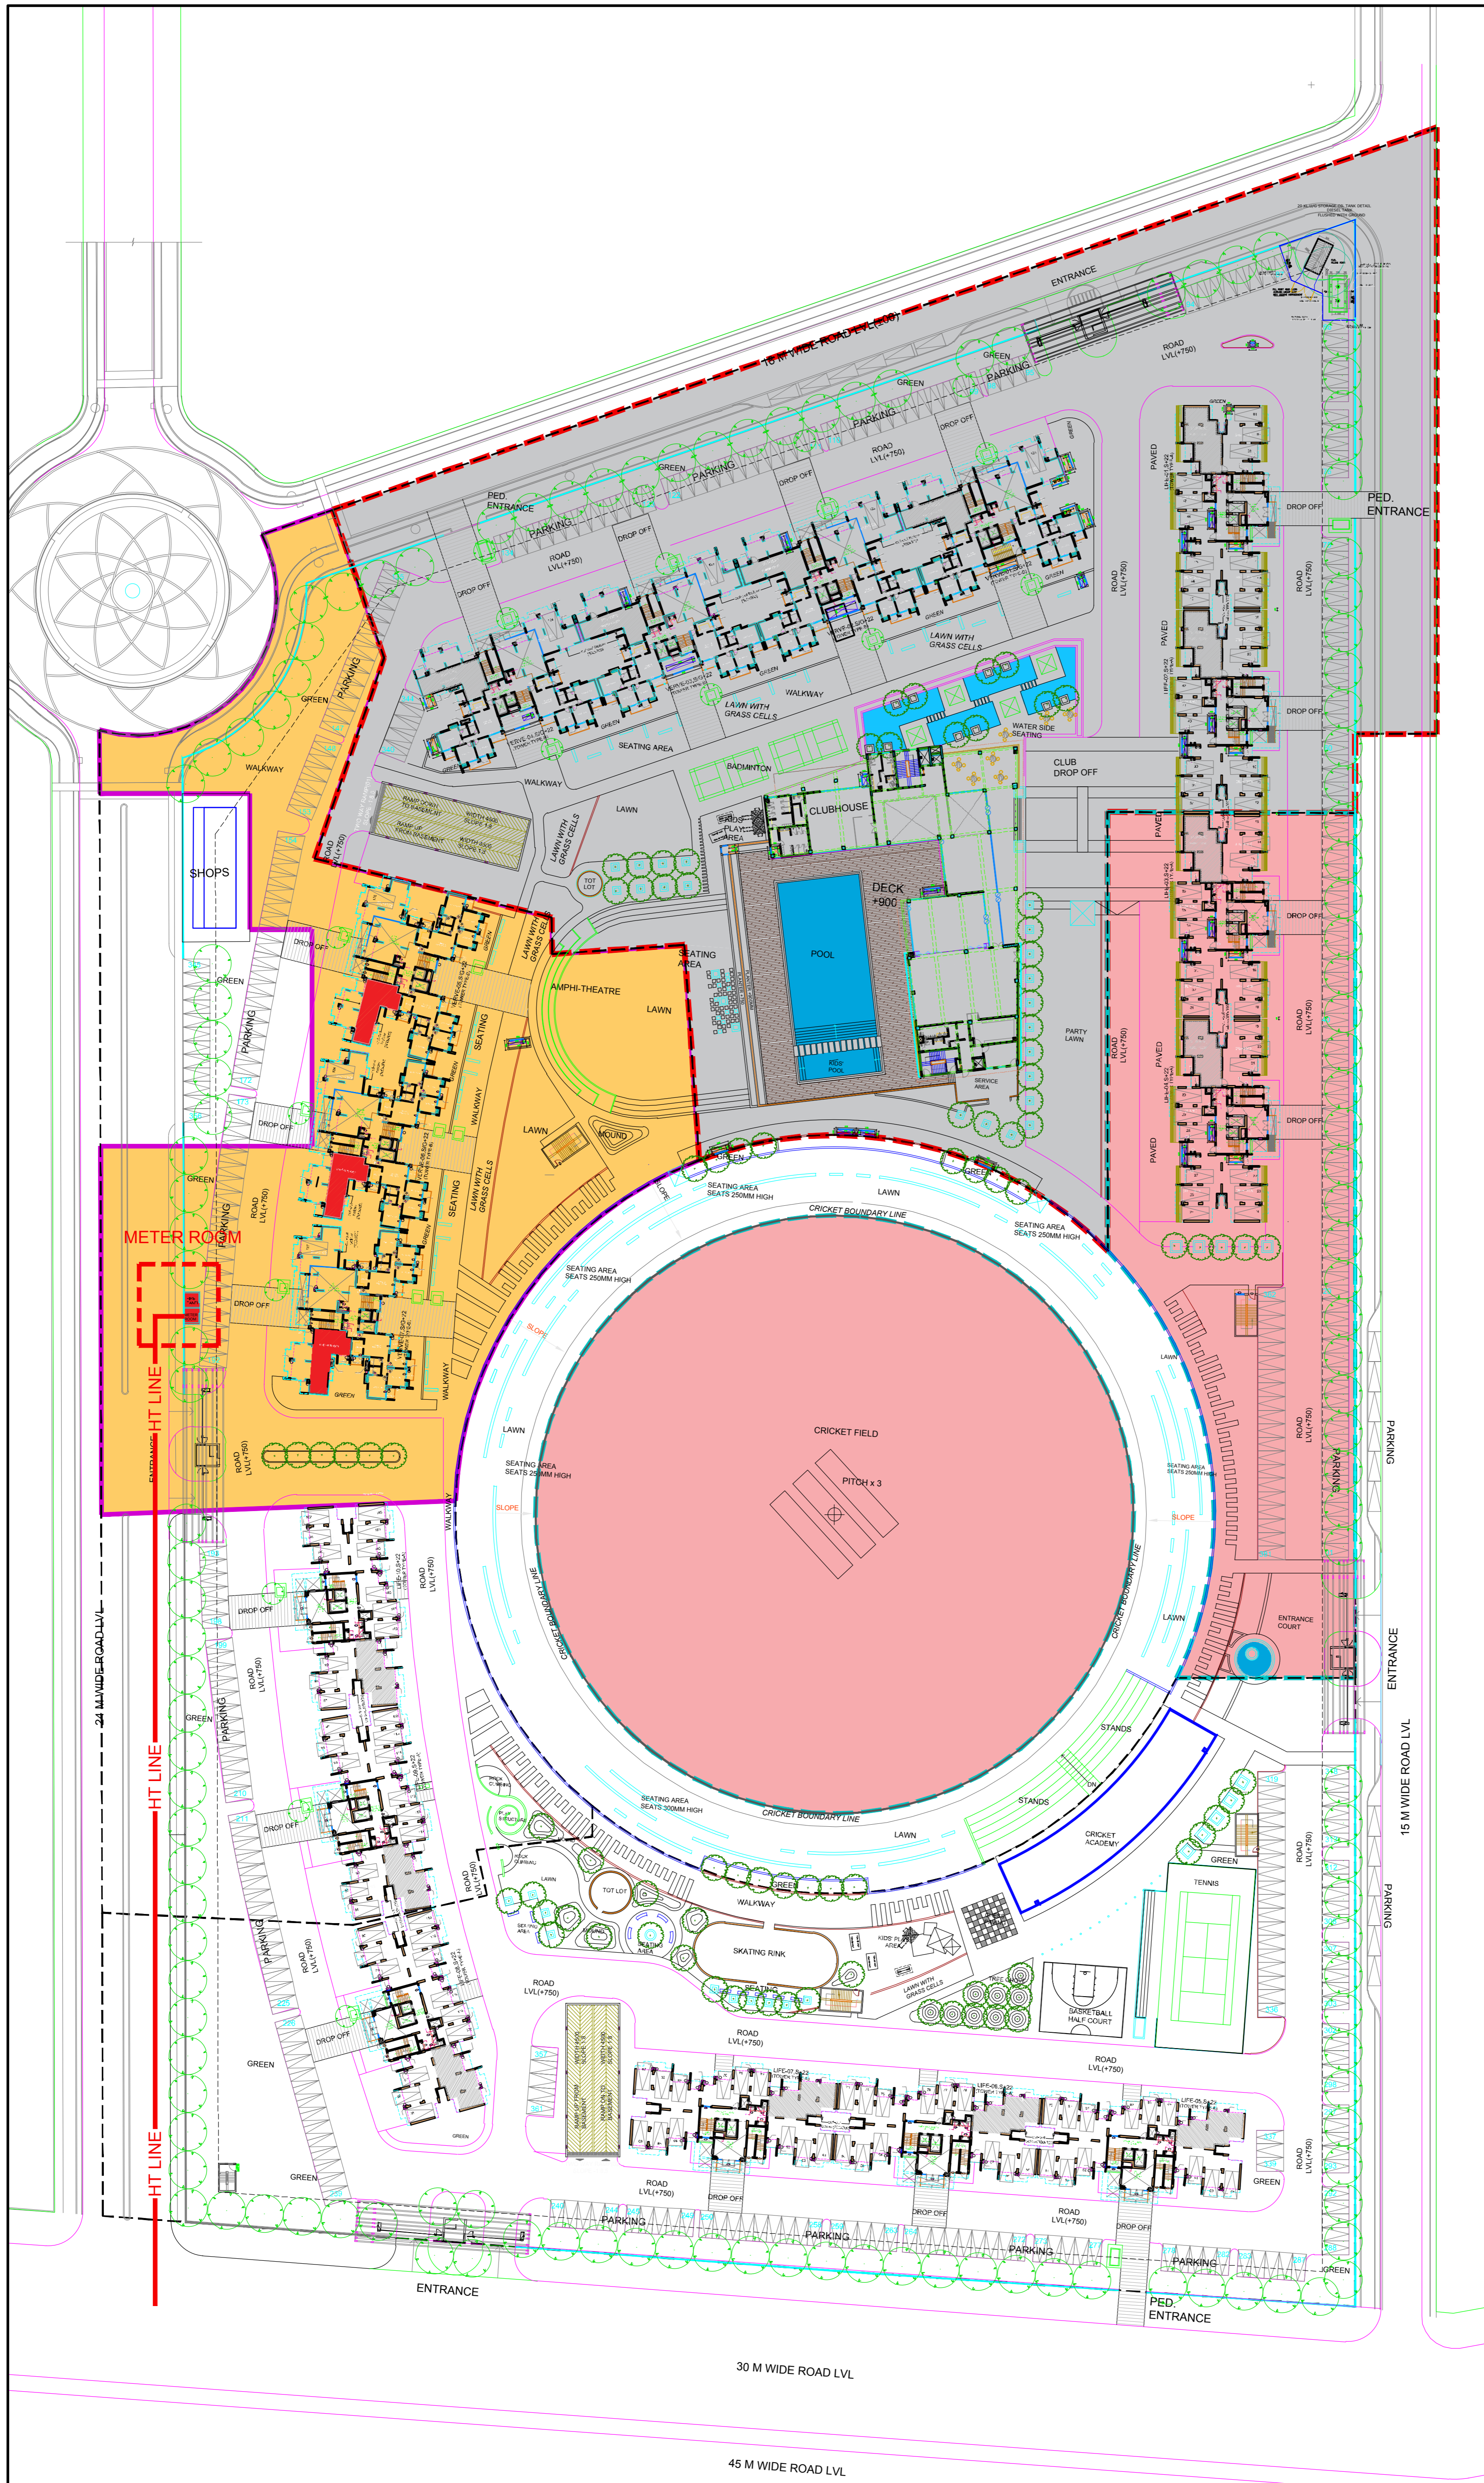

PHASE - I
TOTAL PLOT AREA
= 24111.93 SQM



PHASE - II
TOTAL PLOT AREA
= 15572.26 SQM



PHASE - III
TOTAL PLOT AREA
= 5070.75 SQM

ELECTRICAL CONSULTANTS

AMPOWER CONSULTANCY SERVICES
B-22, Second Floor, Naraina Industrial
Area Phase-I, New Delhi - 28, Phone - +91-11-25895772, +91-11-41414735

STRUCTURAL CONSULTANT

CE CON ENGG
H5-25, Second Floor, Kalash Colony Market New Delhi-110048,
Phone - +91-11-41631766 Email: sssaaaabbb@gmail.com

PLUMBING & FIRE FIGHTING

C P Vidya and Associates 312A, Unitech Arcadia, South City - II,
Sector-49, Gurgaon, Haryana - 122018 Phone - +91 124 4079336
Email: cpvidyaassociates@gmail.com

MEP CONSULTANTS

UDAYAN CHAUDHARI & ASSOCIATES PVT. LTD.
40/60, 2nd floor Chhatarangan Park, New Delhi-110 019
Phone - 011-26471312, 26418363, 40529512
e-mail: udayanchaudhari@gmail.com

DRAWING NAME

**ELECTRICAL SUPPLY
SITE PLAN -PHASE-3**

SCALE
1:400

DATE
10.08.21

DRAWING NO.

ES-01

ACPL ISO 9001:2015
Architecture
Management
Planning

ACPL Design Ltd E-24 South Extension - I T-01 11 24822195
New Delhi 110049 India +91 11 24844709
www.acplindia.com E-mail: acpl@acplindia.com P-01 11 24834069

ELDECO LIVE BY THE GREENS_PHASE-3