


ELECTRICAL DRAWING

PROJECT -
PROPOSED GROUP HOUSING, AT
RATAN KHAND, RAIBAREILLY ROAD,
LUCKNOW.



DRG TITLE -
ELECTRICAL PLAN
(TYPICAL FLOOR)

BUILDING -
BLOCK - 2

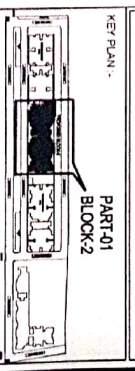

DATE -
MARCH - 2017
NORTH -

DESIGN BY -
HIMANSHU
DRG NO. -
CH-RK/LK/BL-2/ELE/003


CHECKED BY -
AKSRI

ARCHITECT -
SHUBHENDRA BAJPAL

ARCHITECTURAL CONSULTANTS :-

ARCH DOT CREATION
(LUCKNOW OFFICE) :-
4/404 VIVEK KHAND, GOMTI NAGAR
LUCKNOW, Ph. - 4071522, 9415021936.
e-mail add. - adcreation1@yahoo.co.in
(GHAZIABAD OFFICE) :-
2160-2161, Romana Mahagan
Masrat, Crossing Republic, Ghaziabad.
Ph. : 09871599836
e-mail add. - adcreation2@yahoo.co.in

MEP Consultant:
VIEW CONSULTANTS
Lucknow
Ph. No. : +91-9628296682
email : viewconsultants@vsnl.in

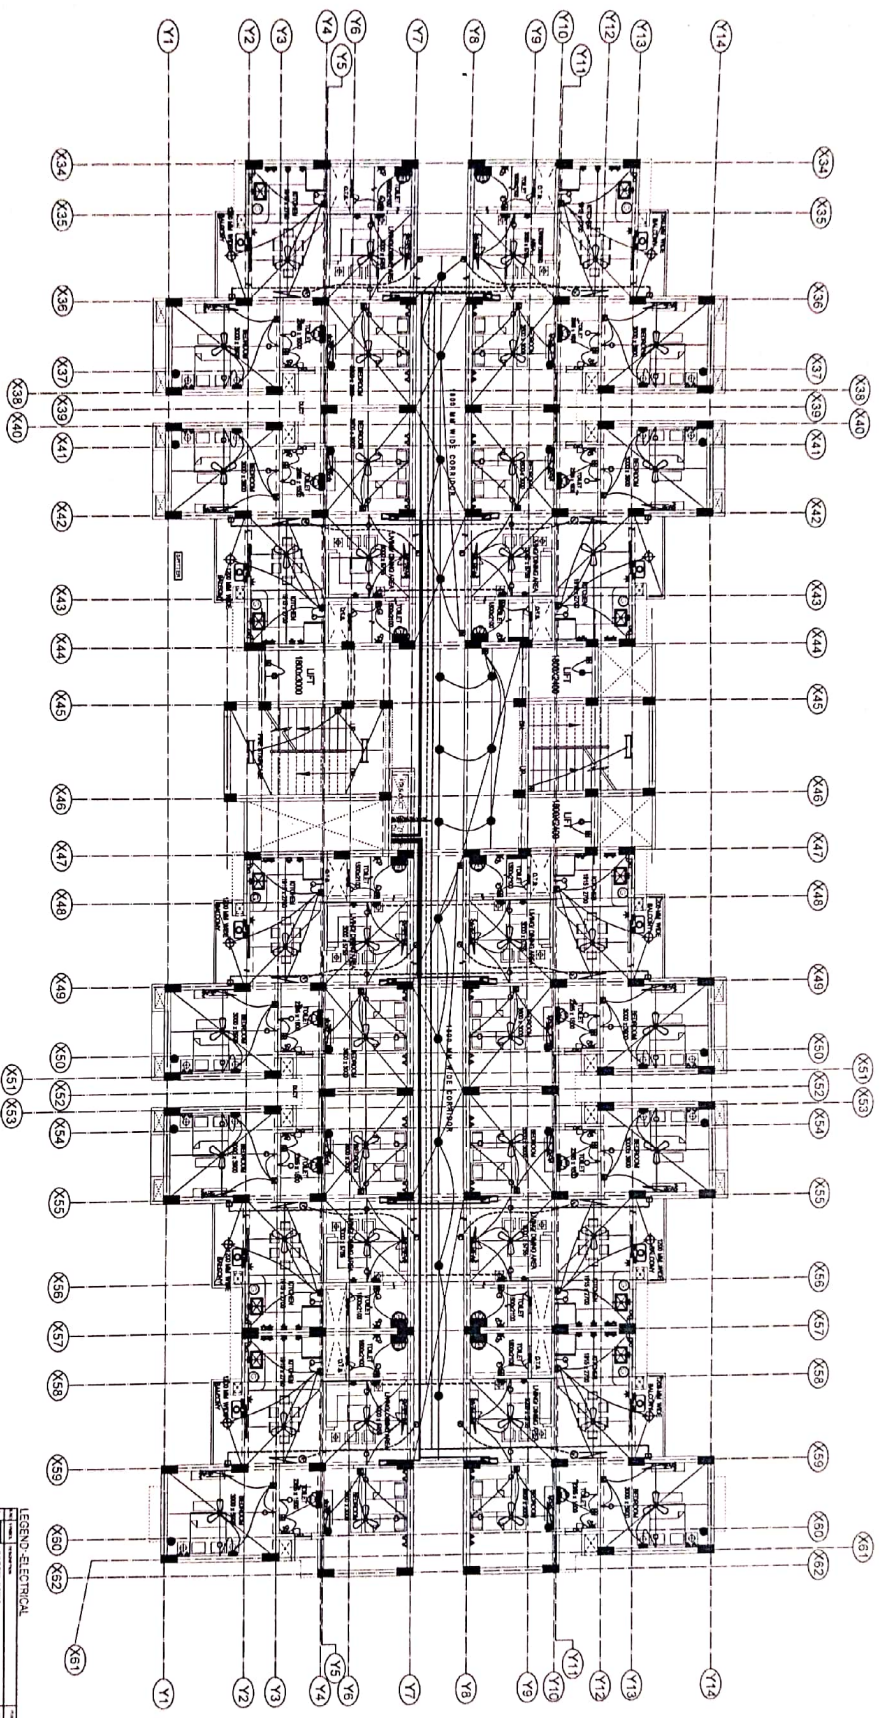

DISTRIBUTION BOARD (B) 6 WAY TYPICAL LOCATION (GROUND FLOOR BLOCK 2)			
DBL	WIRE SIZE NO. OF CIRCUITS	LOCATION	PHASE
B1	15	ENTRANCE LOBBY & ELEVATOR	
B2	15	COMMON CORRIDOR & ELEVATOR	
B3	15	STAIRS (GROUND TO 4TH FLOOR)	
B4	15	STAIRS (GROUND TO 4TH FLOOR)	
B5	15	STAIRS (4TH TO TERRACE FLOOR)	
B6	15	STAIRS (4TH TO TERRACE FLOOR)	
B7	15	COMMON CORRIDOR & ELEVATOR	
B8	15	COMMON CORRIDOR & ELEVATOR	
B9	15	COMMON CORRIDOR & ELEVATOR	
B100	15	COMMON CORRIDOR & ELEVATOR	

FOR THE RESPONSIBILITY OF INTERNAL CONDUIT CABLE TO BE CONNECTED TO THE MAINS

TYPICAL 1ST TO 8TH FLOOR PLAN