


मा0 मुख्यमंत्री शहरी विस्तारीकरण योजना फेज-1, झाँसी



KEY PLAN

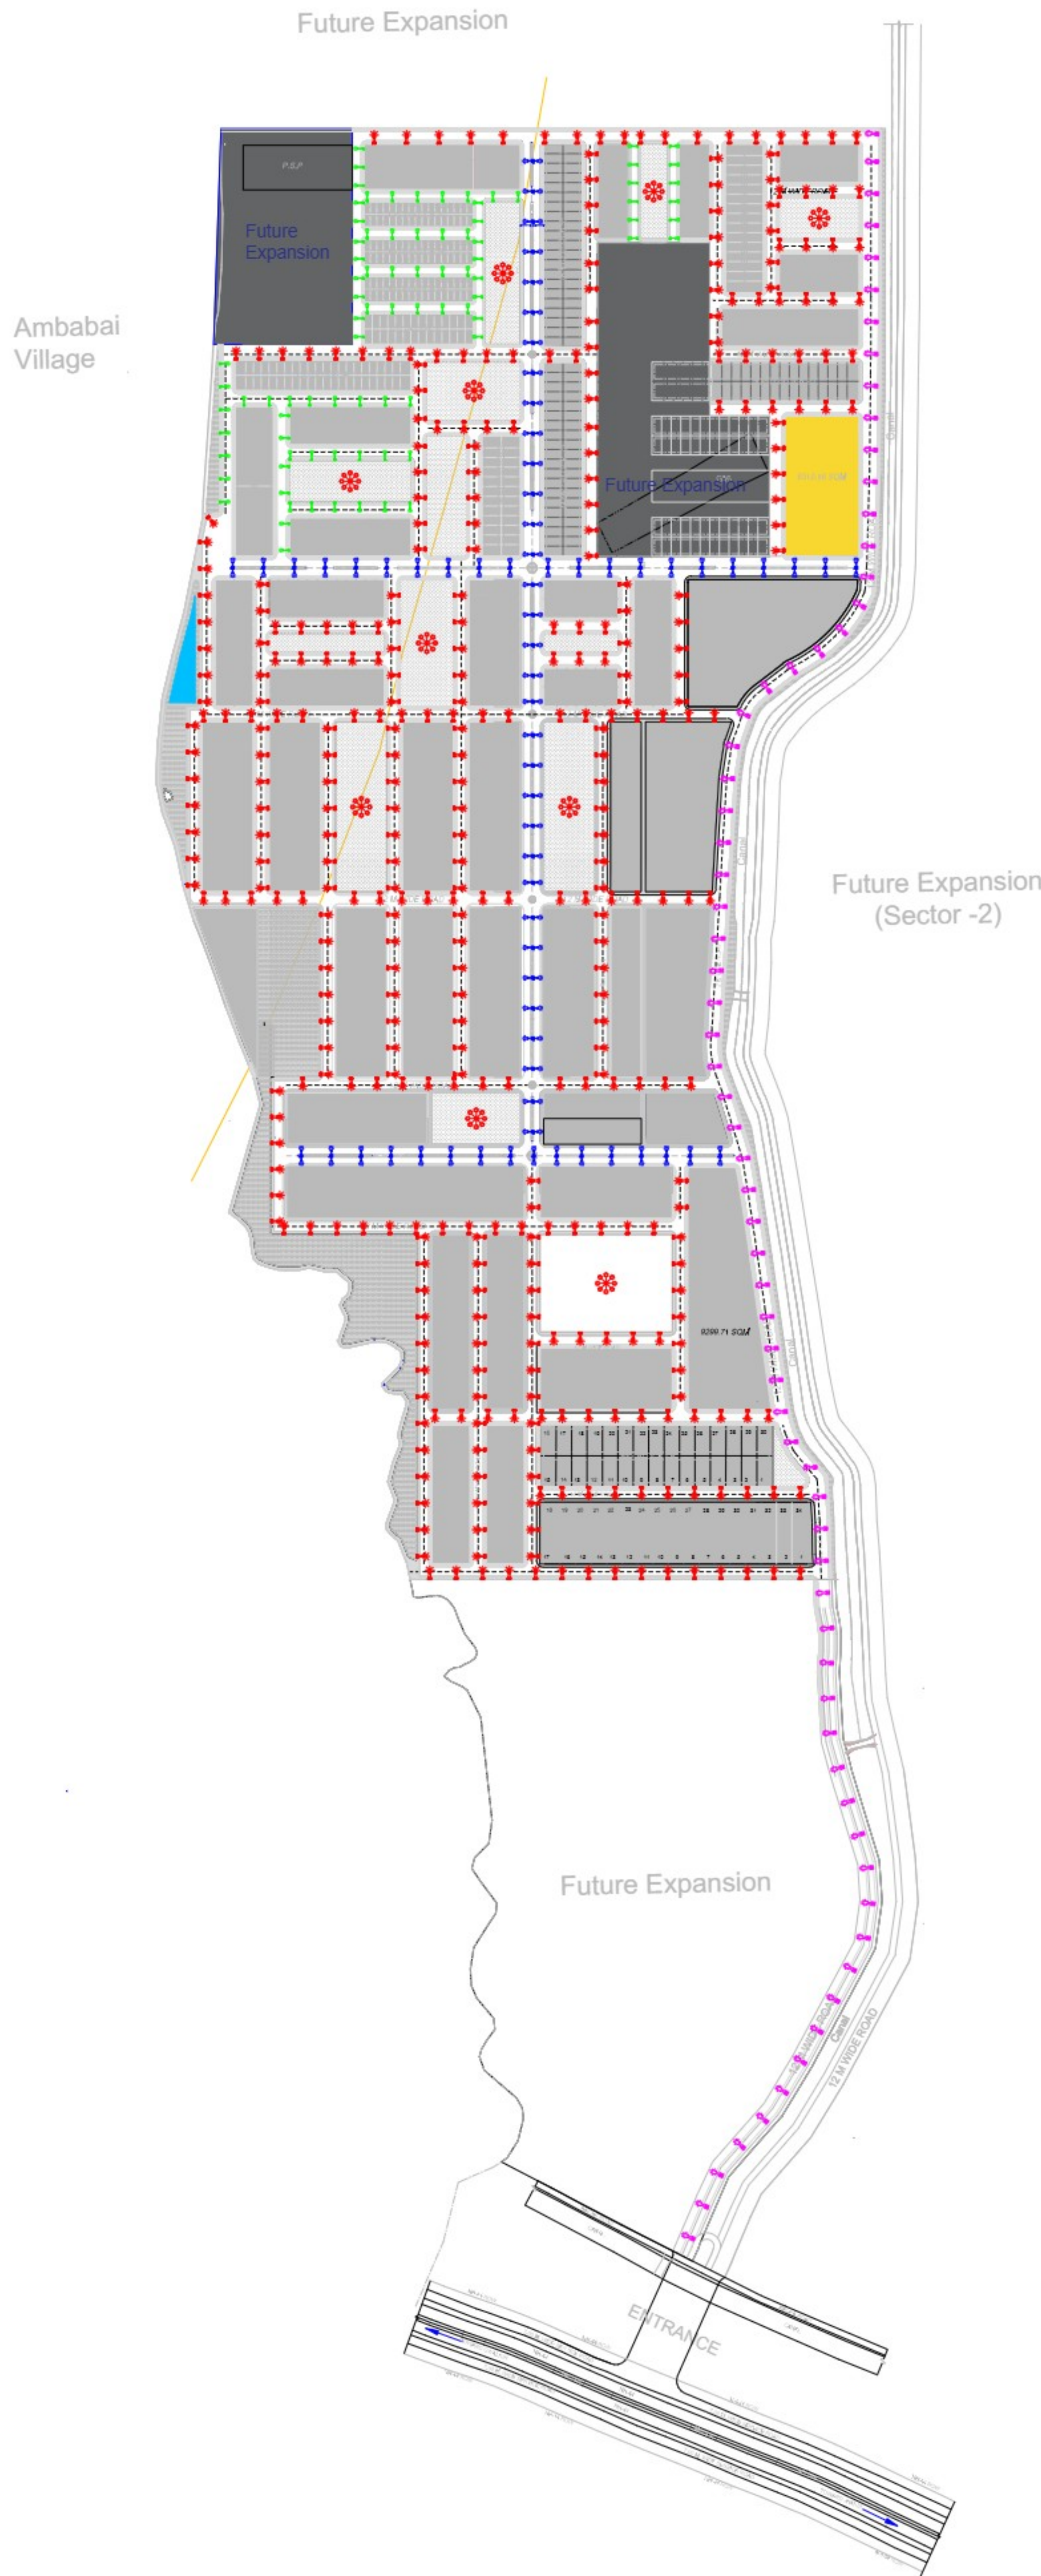

Electrical Legend:		
Symbol	QTY.	Description
	16 NOS	16 MTR. HEIGHT HIGH MAST WITH 8 NOS 150W LED FLOOD LIGHT FIXTURE
	70 NOS	9 MTR. HEIGHT 110W-130W STREET LIGHT POLE WITH SINGLE ARM
	465 NOS	7 MTR. HEIGHT 75W-90W STREET LIGHT POLE WITH SINGLE ARM
	68 NOS	8 MTR. HEIGHT 110W-130W STREET LIGHT POLE WITH SINGLE ARM
	81 NOS	6 MTR. HEIGHT 60W-72W STREET LIGHT POLE WITH SINGLE ARM
	20 NOS	STREET LIGHT CUBICAL PANEL
		EARTHING

JHANSI DEVELOPMENT AUTHORITY
 Infront of, Commissionary Compound,
 Circuit House Rd, Gwal Toli, Jhansi, Uttar Pradesh 284001

PROJECT TITLE: MANANIYA MUKHYAMANTRI SHAHARI VISTARIKARAN YOJNA JHANSI PHASE -1

DRAWING TITLE: DETAILED STREET LIGHT LAYOUT PLAN

R.F.: 1:2000 DATE :

SCALE : 0 25 50 100 200



J. E. A. E. E. E. T. P.

SECRETARY

VICE CHAIRMAN