






PLUMBING LEGEND:-

	STORM LINE
	SEWER LINE
	GARDEN HYDRENT LINE
	G.L. GROUND LEVEL
	I.L. INVERT LEVEL
	C.L. CONNECTION LEVEL
	RWH RAIN WATER HARVESTING PIT
	GH GARDEN HYDRENT
	VALVE
	DRAINAGE MANHOLE
	SEWER MANHOLE
	CATCH BASIN

FIRE LEGEND:-

	EXTERNAL FIRE PIPE
	EFH EXTERNAL FIRE HYDRANT
	FBC FIRE BRIGADE INLET CONNECTION

	6.0 METER HEIGHT POLE WITH 60W LED LIGHT
	40W POST TOP LANTERN
	HT U/G CABLE
	HUME PIPE
	MAN HOLE-900X900X900MM
	CABLE TRENCH
	BODY EARTH PIT FOR G.I. EARTHING
	NEUTRAL EARTH PIT FOR CU. EARTHING
	EXTERNAL LIGHTING FEEDER PILLAR

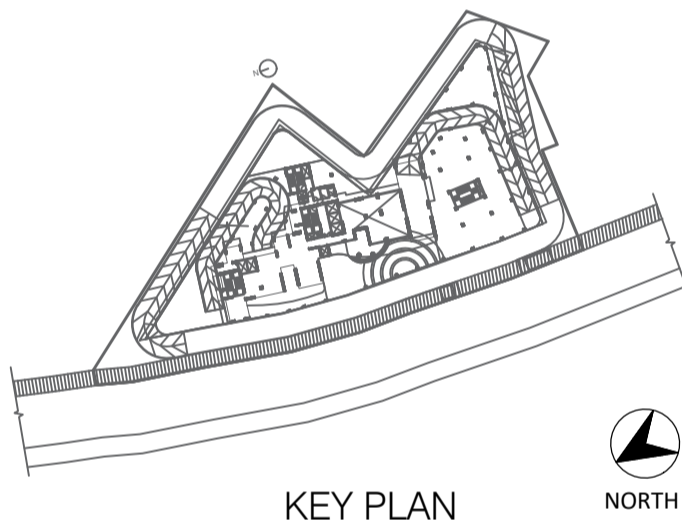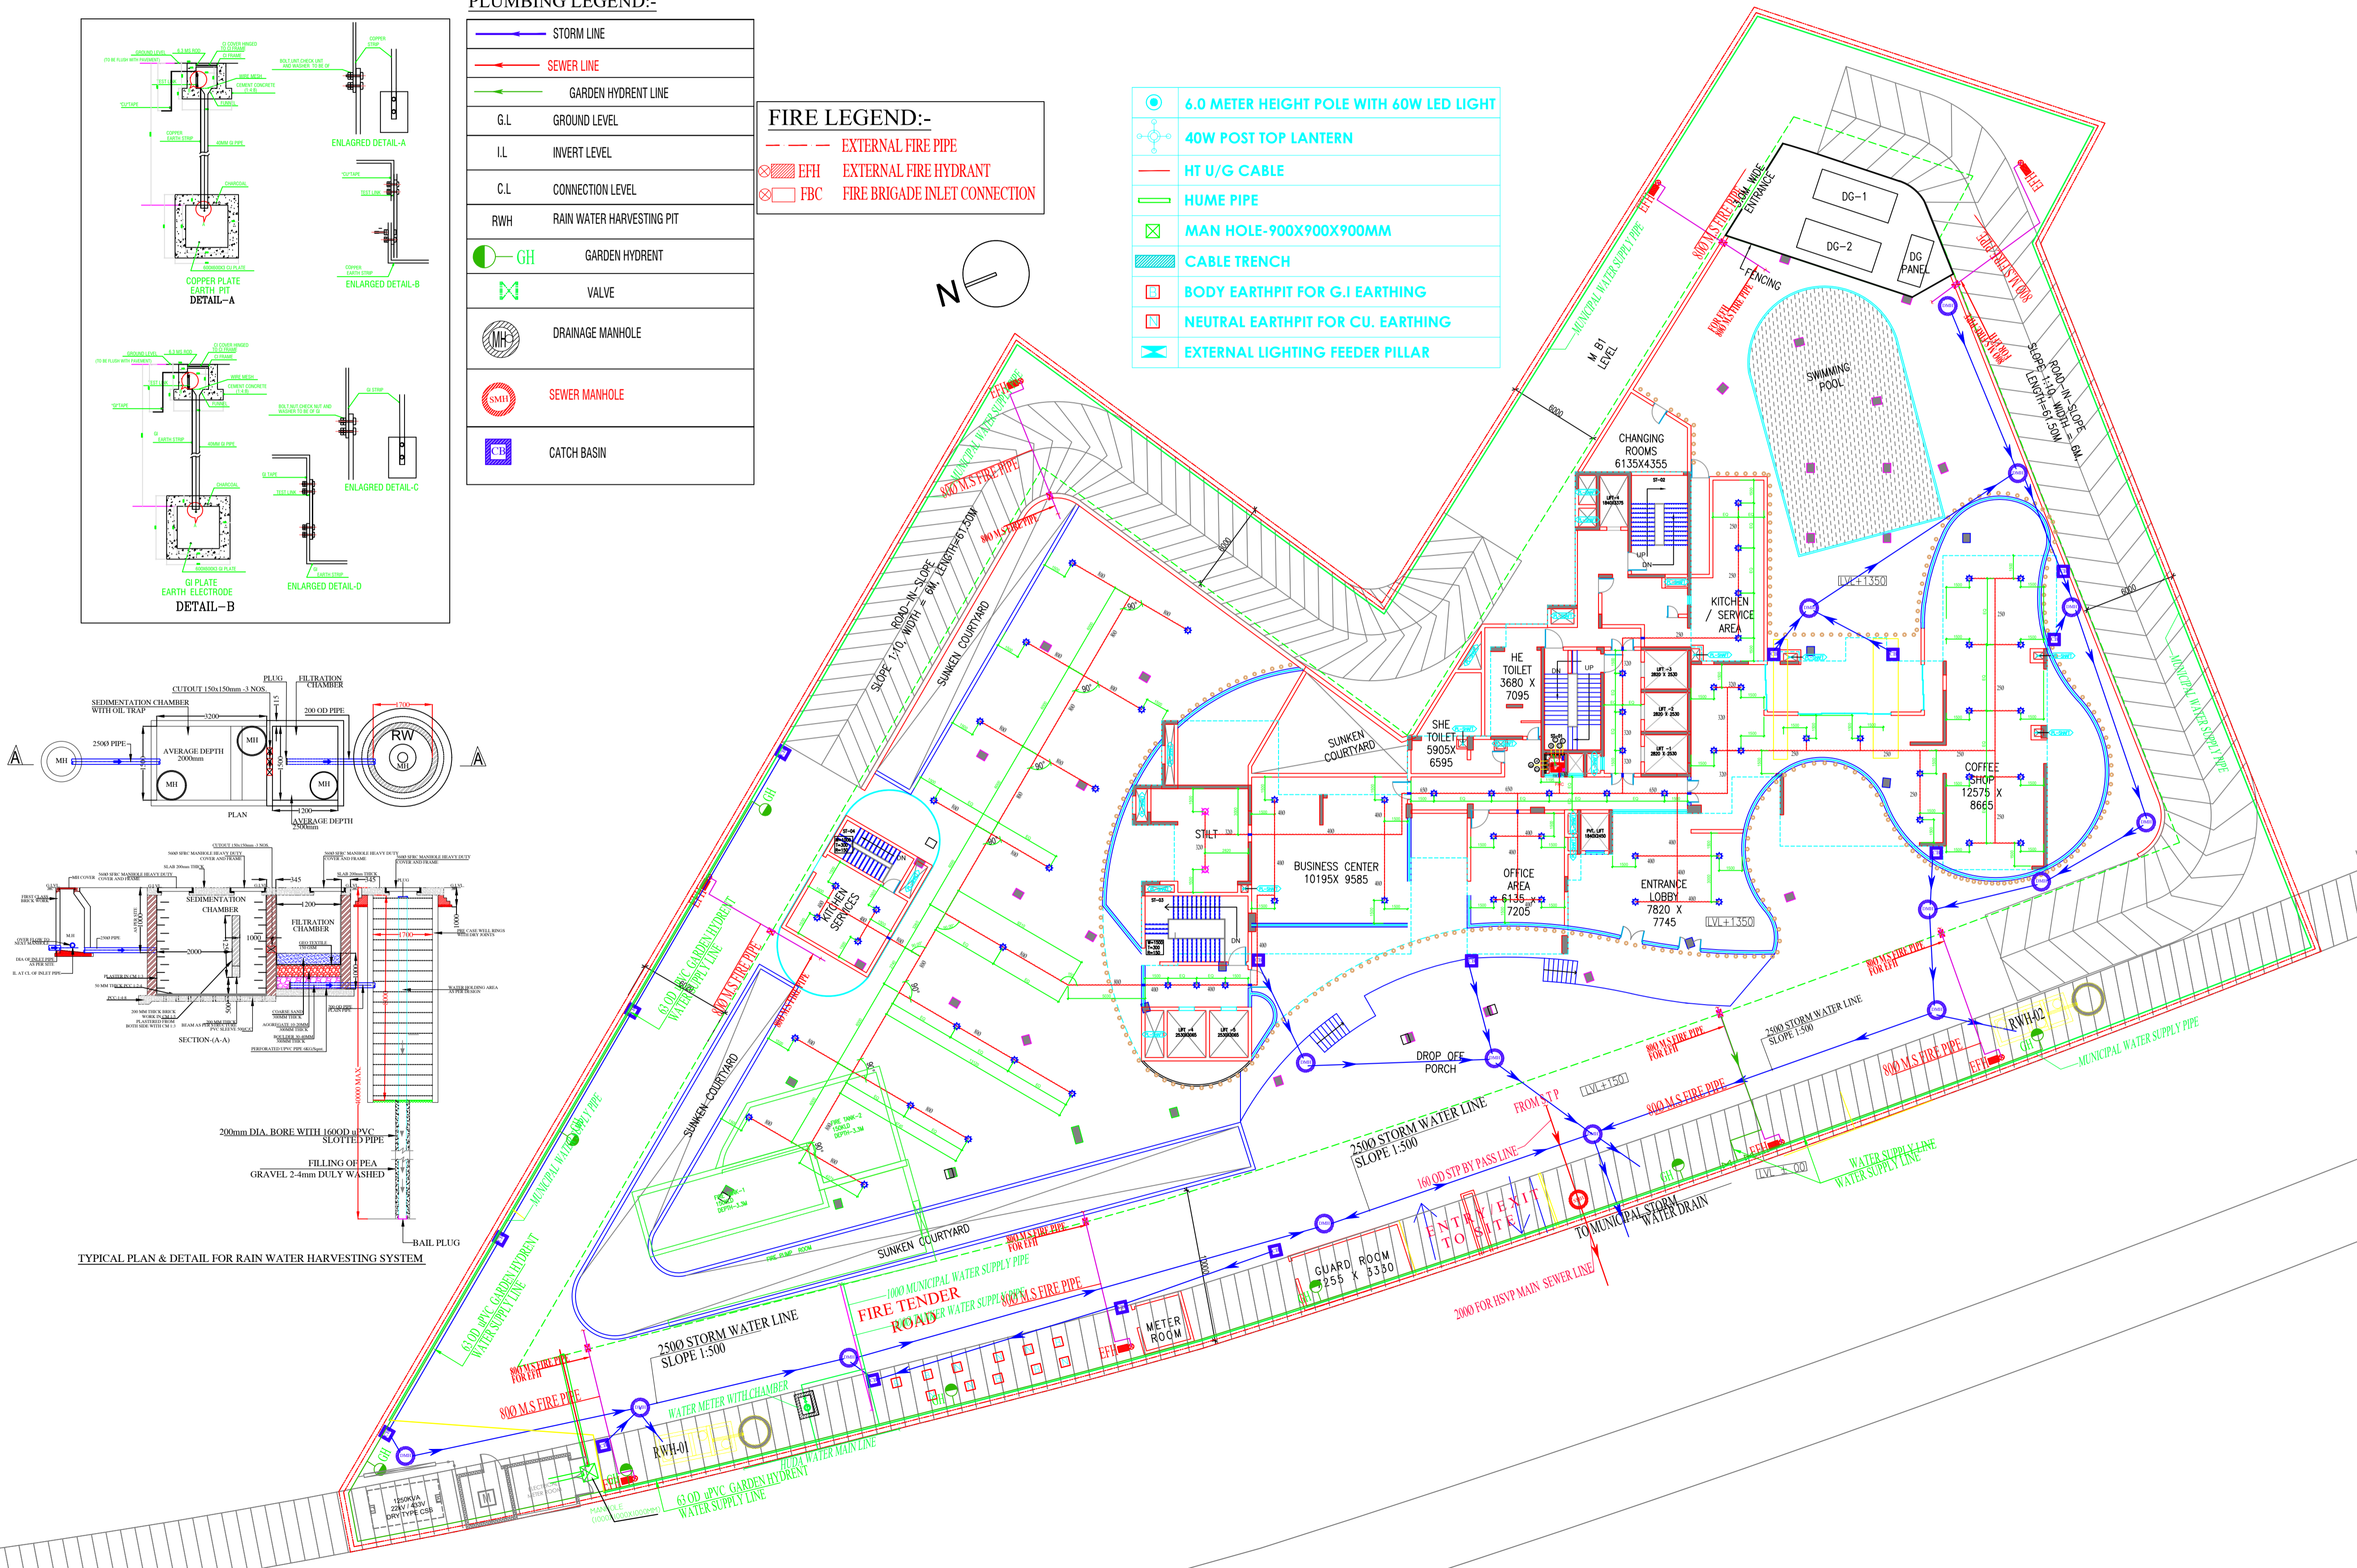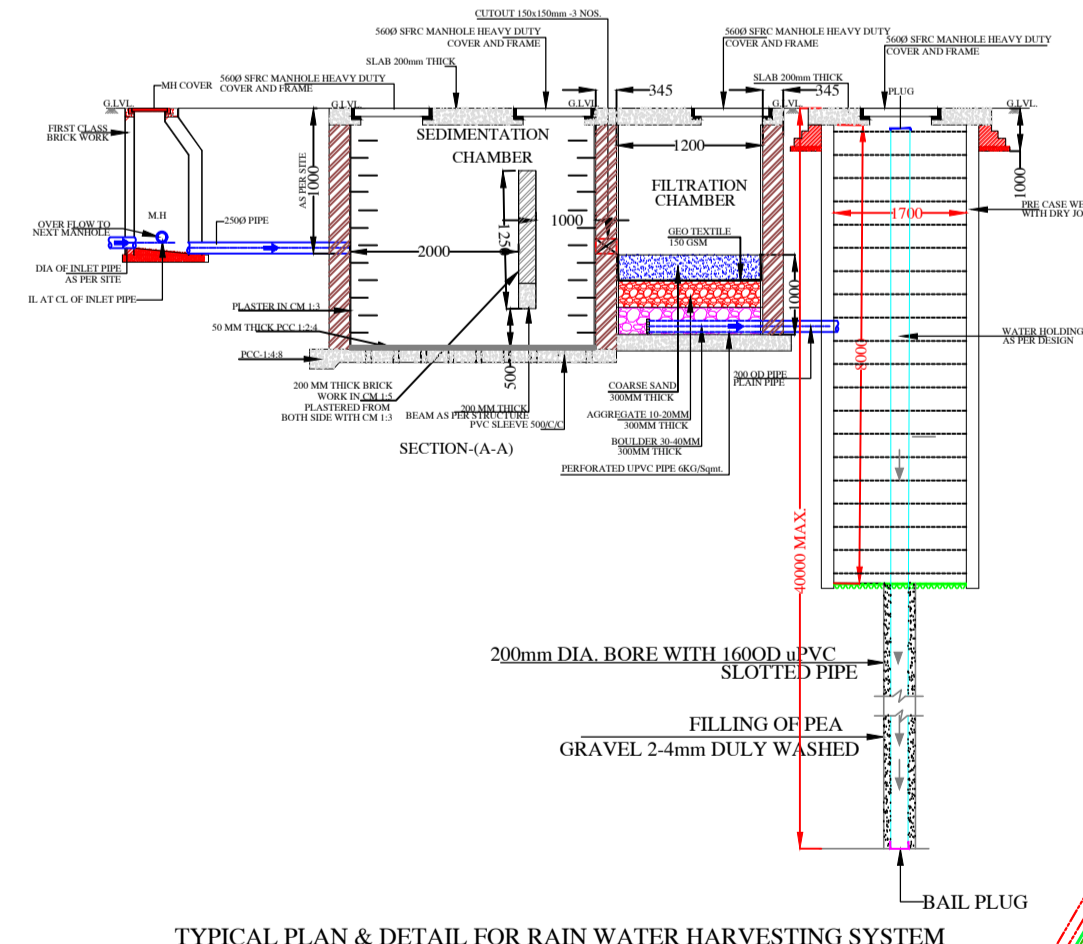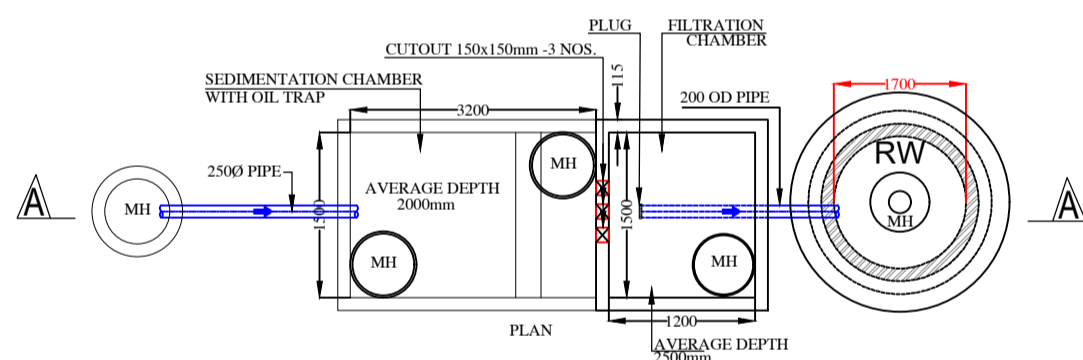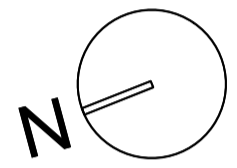

SUBMISSION

PROJECT:
**KINGS LANDING
B-58 WISH TOWN SECTOR - 128,
NOIDA FOR JAYPEE INFRATECH LTD**

DRAWING TITLE :
ELECTRICITY SUPPLY PLAN LAN

OWNER'S SIGN ARCHITECT'S SIGN.

SCALE 1:150	DEALT BY	DATE - 08.06.2020
DESIGN BY	CHECKED BY	DRG. No. A-01