



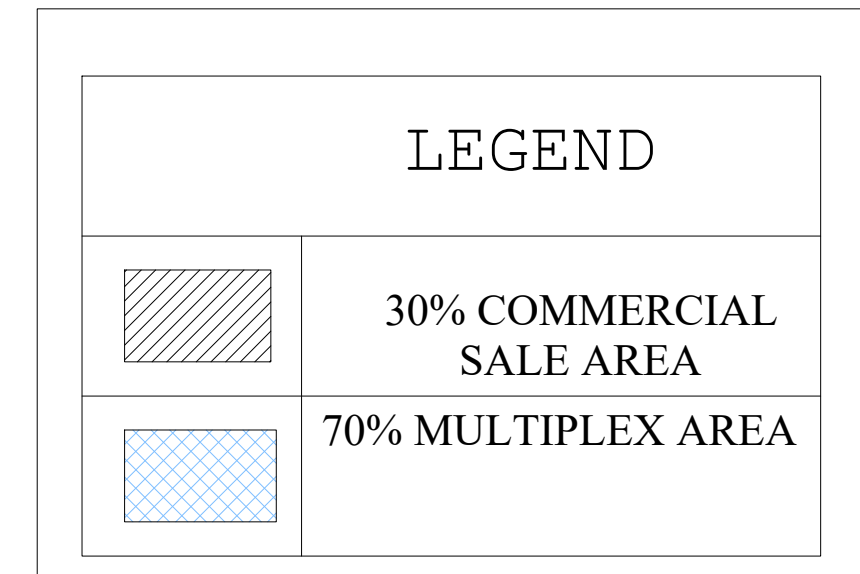

AREA STATEMENT		
S.NO	PARTICULARS	SQ.MTR
1	PURCHASED LAND AREA	23,823.3
2	ROAD AREA IN LAND	1,935.05
3	BALANCE PLOT AREA = (1-2)	21,888.2
4	REQUIRED 5% LAYOUT GREEN AREA	1094.41
5	NET PLOT AREA FOR PROJECT = (3-4)	20,793.8
6	PERMISSIBLE F.A.R	1.5
7	PERMISSIBLE F.A.R AREA= 1.5 X 20,793.856 = 31190.784 SQ.MT.	31190.78

45 MT. WIDE DRIVE WAY

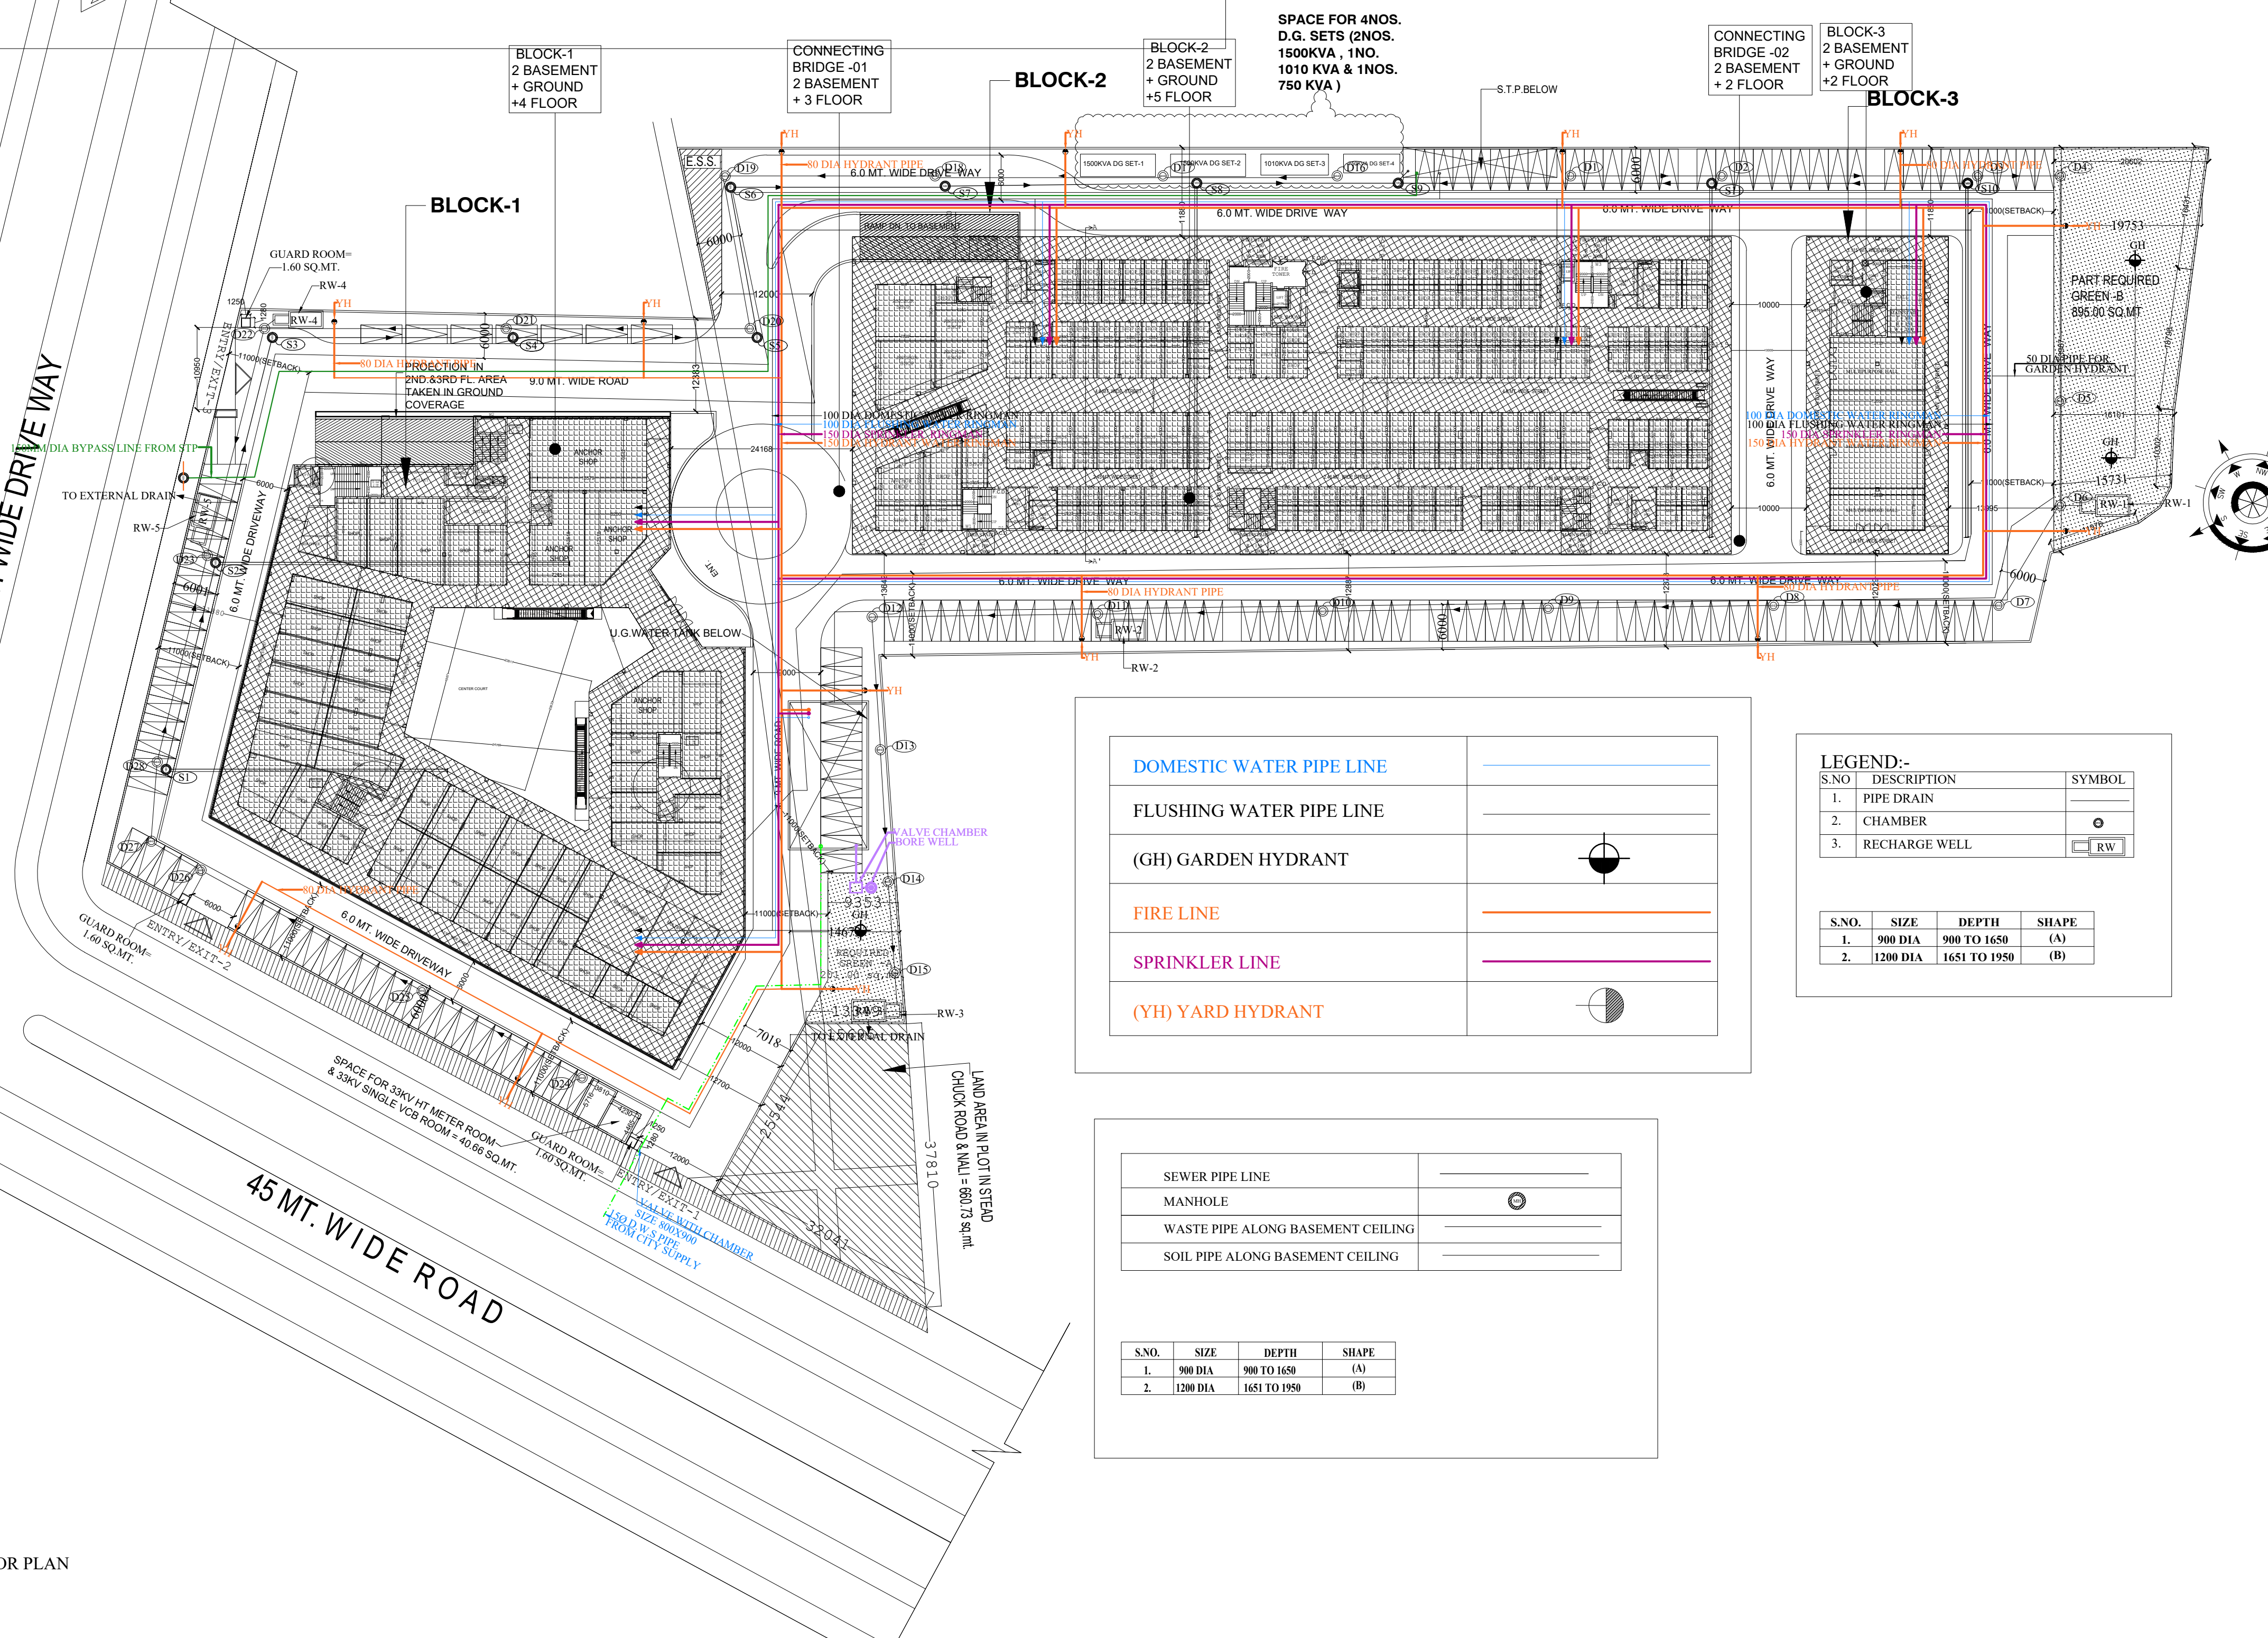

DOMESTIC WATER PIPE LINE	
FLUSHING WATER PIPE LINE	
(GH) GARDEN HYDRANT	
FIRE LINE	
SPRINKLER LINE	
(YH) YARD HYDRANT	

S.NO	DESCRIPTION	SYMBOL
1.	PIPE DRAIN	
2.	CHAMBER	
3.	RECHARGE WELL	

S.NO.	SIZE	DEPTH	SHAPE
1.	900 DIA	900 TO 1650	(A)
2.	1200 DIA	1651 TO 1950	(B)

SEWER PIPE LINE	_____
MANHOLE	
WASTE PIPE ALONG BASEMENT CEILING	_____
SOIL PIPE ALONG BASEMENT CEILING	_____

S.NO.	SIZE	DEPTH	SHAPE
1.	900 DIA	900 TO 1650	(A)
2.	1200 DIA	1651 TO 1050	(B)

GROUND FLOOR PLAN

PROJECT :-
PROPOSED MULTIPLEX AT KHASRA No.
524,540,544,
537,538 VILLAGE :- NOORNAGAR
GHAZIABAD U.P.

BUILDERS & PROMOTER :-
R.B.Infraestate Pvt. Ltd.
7365 Prame Nagar
Shakti Nagar Delhi - 7

DRAWING TITLE :-

MASTER PLAN

DRAWN BY :- DINESH	CHECKED BY :- PKS	SCALE NTS	DATED :- 07.08.20
-----------------------	----------------------	--------------	----------------------

ARCHITECT'S SIGN.

DRG.NO. - 001

CONSULTANT:-
PEE CONSULTANT
EAST OF LONI ROAD DELHI-110093
815-C,DDA FLATES
PH.& FAX:-011-22816297
email:-pramod@pkv.co.in