
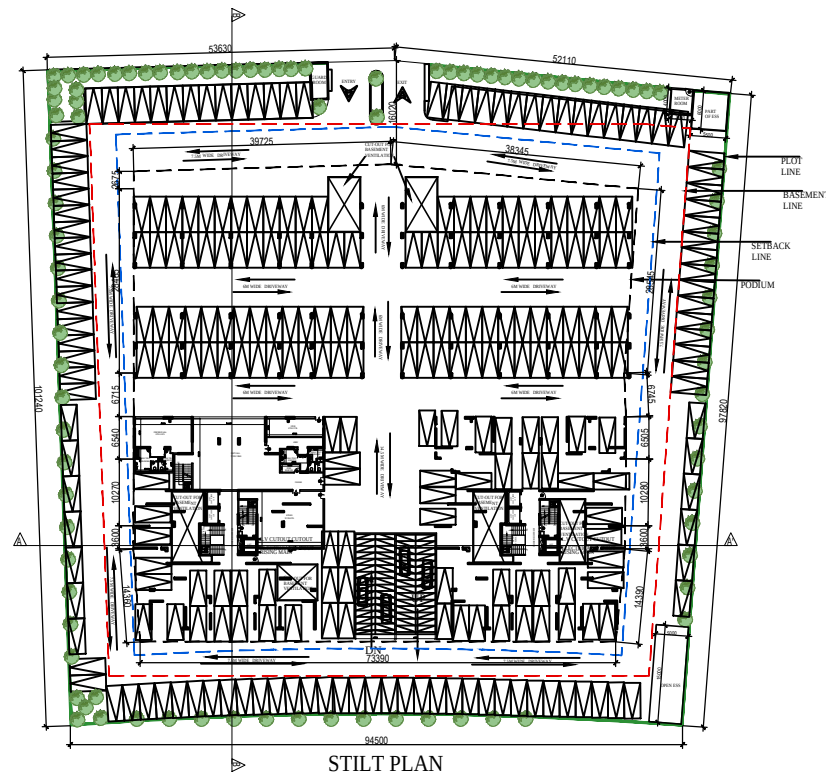
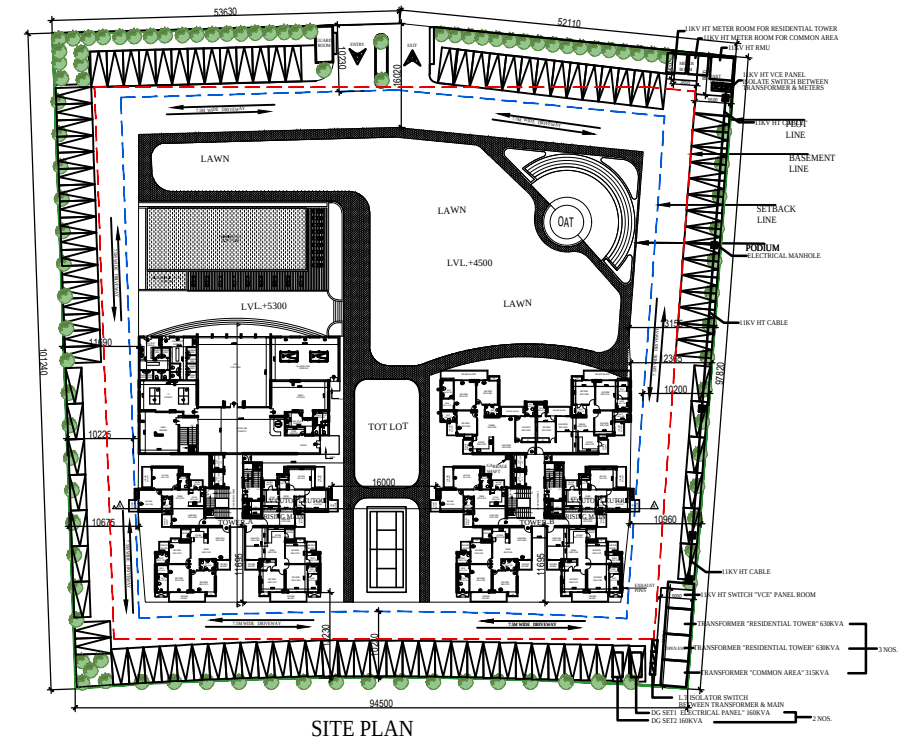


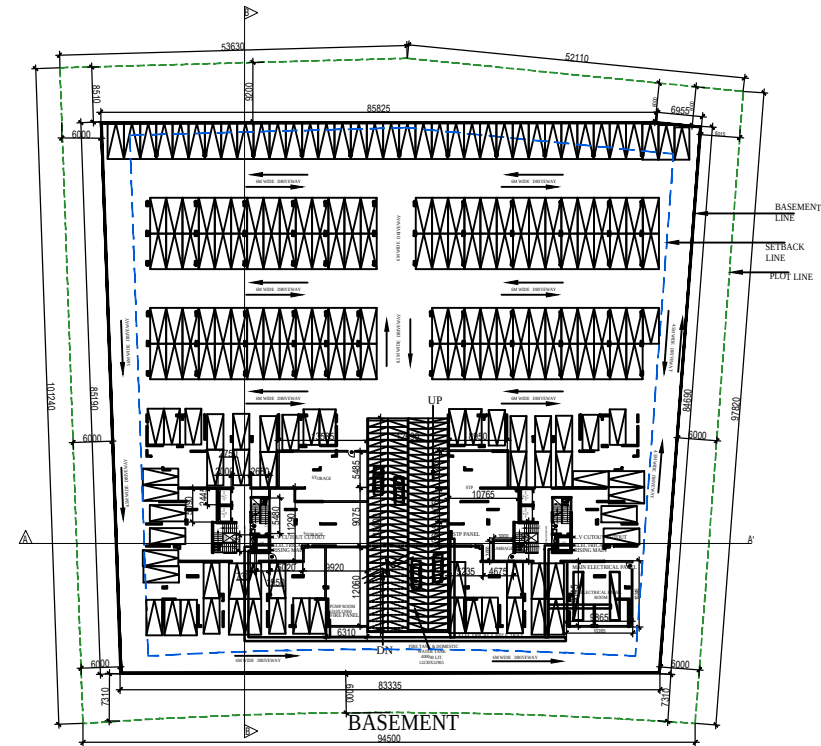

PROJECT PROPOSED HOUSING AT PLOT NO.-GH04 TECH ZONE -IV SPORT CITY FOR IRISH INFRASTRUCTURE	
ARCHITECTS A PLUS DESIGN ASSOCIATES. J-16, SECTOR-41 NOIDA - 201303, Tel.: 9625775674 email : aplusdesignassociates@gmail.com	
Scale : N.T.S	
ARCHITECT'S SIGNATURE 	OWNER'S SIGNATURE
KAILASH AGGARWAL ARCHITECT (CA-36-10069) J-16, Sector-41, Noida	For Irish Infrastructure Pvt. Ltd.
Drawing Title:- ELECTRICAL LAYOUT PLAN	
Drawing No:-	