


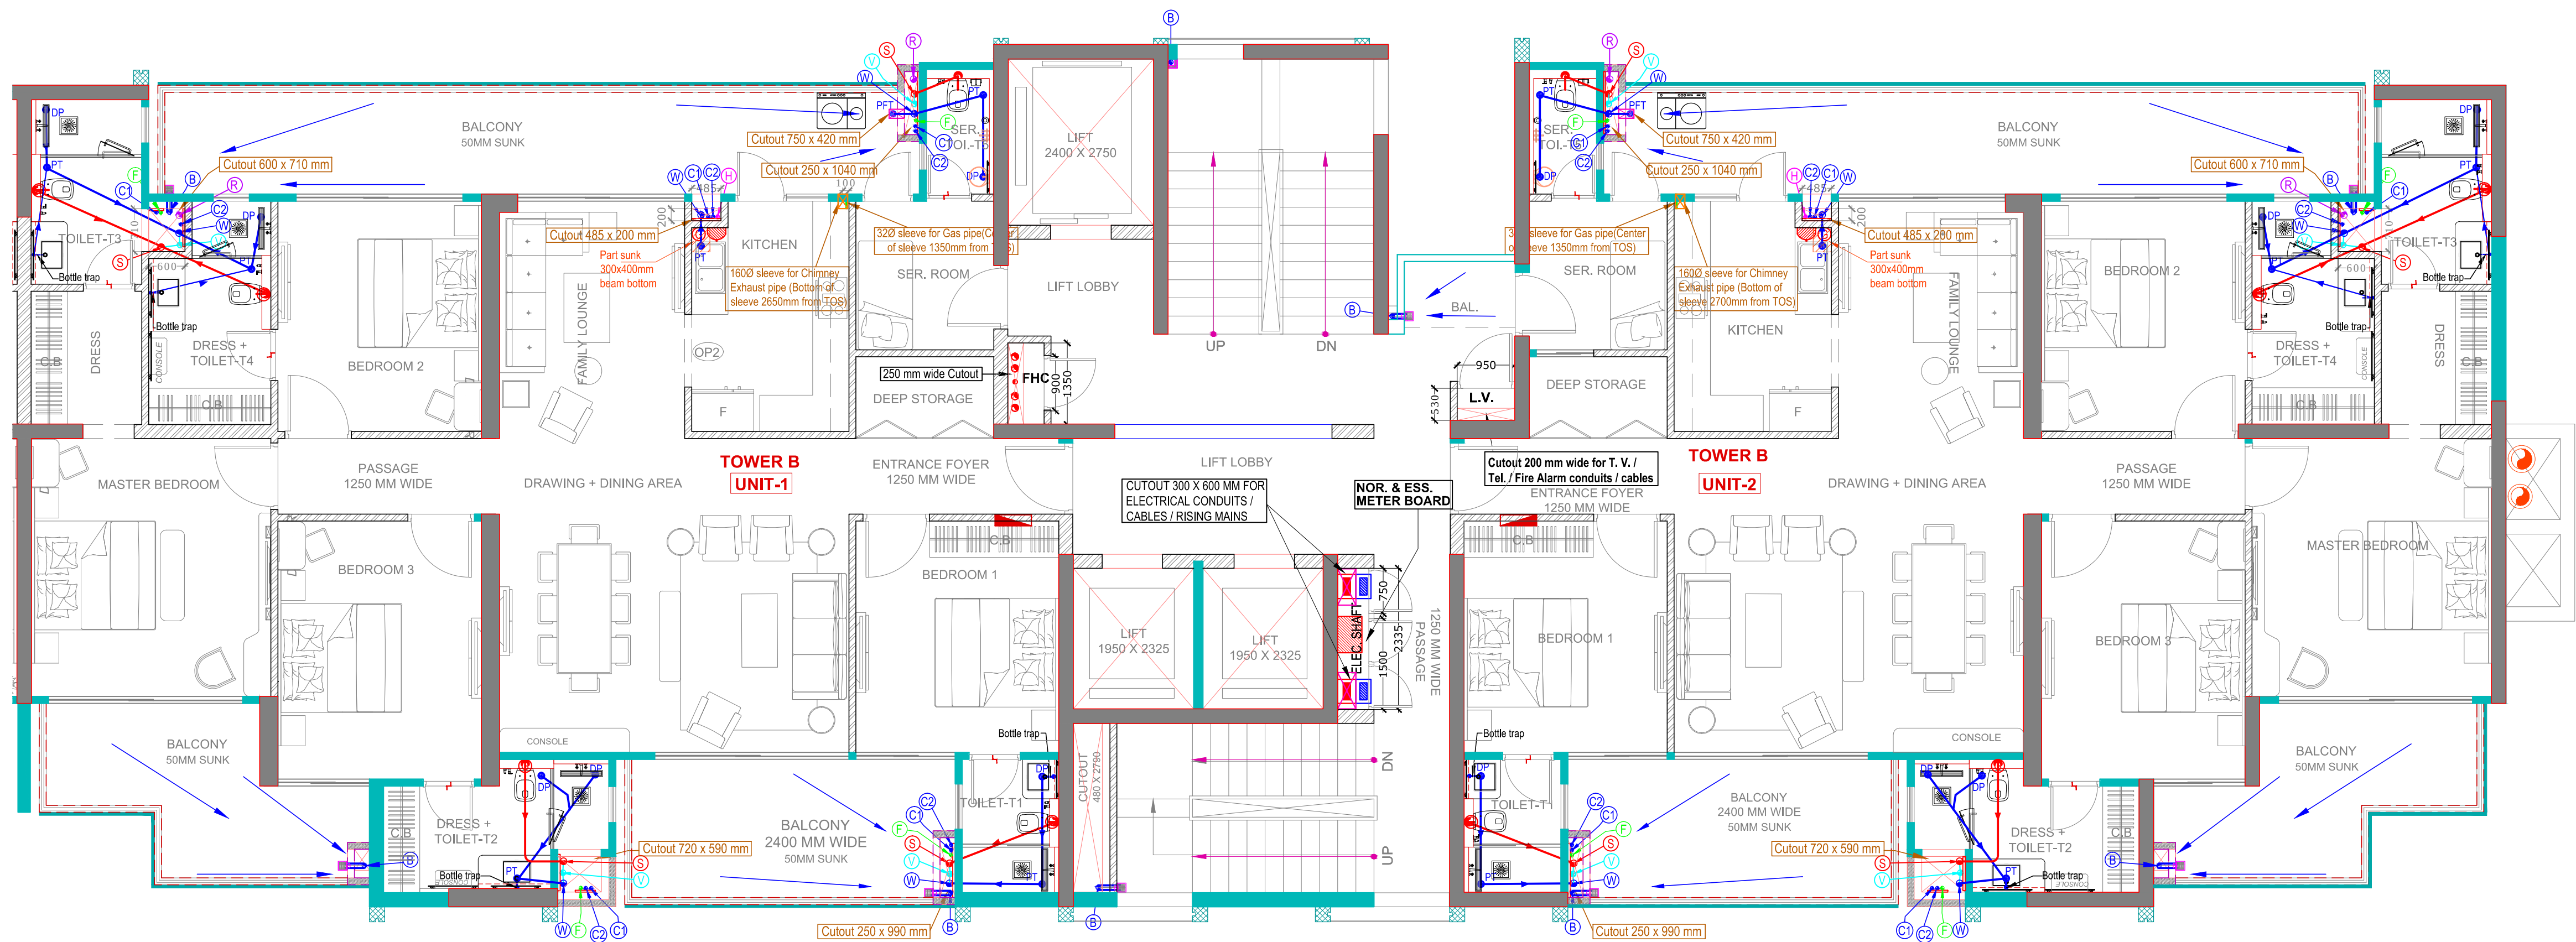

LEGEND : (Plumbing)		
S. No.	SYMBOL	DESCRIPTION
1.		1100 SOIL AND VENT PIPE
2.		1100 WASTE AND VENT PIPE
3.		1100 RAIN WATER PIPE
4.		750 BALCONY / CORRIDOR DRAIN PIPE
5.		750 ANTI SIPHONAGE PIPE
6.		DOMESTIC WATER SUPPLY DROP FROM TANK TO TOILET / KITCHEN FOR ALL FLOOR EXCEPT TOP THREE FLOOR
7.		DOMESTIC WATER SUPPLY DROP FROM TANK TO TOILET / KITCHEN FOR TOP THREE FLOOR ONLY
8.		HOT WATER SUPPLY PIPE (FROM SOLAR SYSTEM)
9.		RECYCLED WATER SUPPLY DROP FROM O.H.T. TO W.C.
10.		GEYSER
11.		WATER PURIFIER
12.		HEALTH SPRAY WITH ANGLE VALVE
13.		MIXTURE & SHOWER
14.		WASHING MACHINE
15.		DRAIN POINT
16.		PLAIN FLOOR TRAP - 6" deep (50 mm water seal)
17.		MULTI FLOOR TRAP - 6" deep (50 mm water seal)
18.		P TRAP (110 X 110 MM) (50 mm water seal)
19.		EUROPEAN W. C. (Wall Hung Type W.C.)
20.		WASH BASIN
21.		DOUBLE BOWLED SINK WITH DRAIN BOARD
22.		
23.		
24.		

rev. no.	date	revision

project
PROPOSED GROUP HOUSING
AT PLOT NO.GH-03A, SECTOR-16B,
GREATER NOIDA, U.P.

title
WASTE DISPOSAL / PLUMBING DRAWING

subtitle
TYPICAL FLOOR PLAN - TOWER - A & B

drawing released for
☐ APPROVAL ☒ SUBMISSION
☐ ADVANCE COPY ☐ CONSTRUCTION

drg. no. GIH / 22B01 / P-02 drawn by Chhinder Pal

scale 1 : 65 designed by Badri Vishal

date 09.05.2023 checked by Anand Havella

architects
modarchindia
architects interior designers & planners
studio: 1st floor, B-99, sector-63, Noida -201301, U.P.
phone: 01120 4206253

services consultant
Consummate Engineering Services (P) Ltd.

Noida Office : B - 67, Sector - 67, Noida - 201 301
Lko. Office : R 006, Rohas Plumeria, Gomti Nagar, Lucknow
Tel : (0120) 2303500 (30 Lines)
e mail : mail@cespi.in, website : www.cespi.in

