


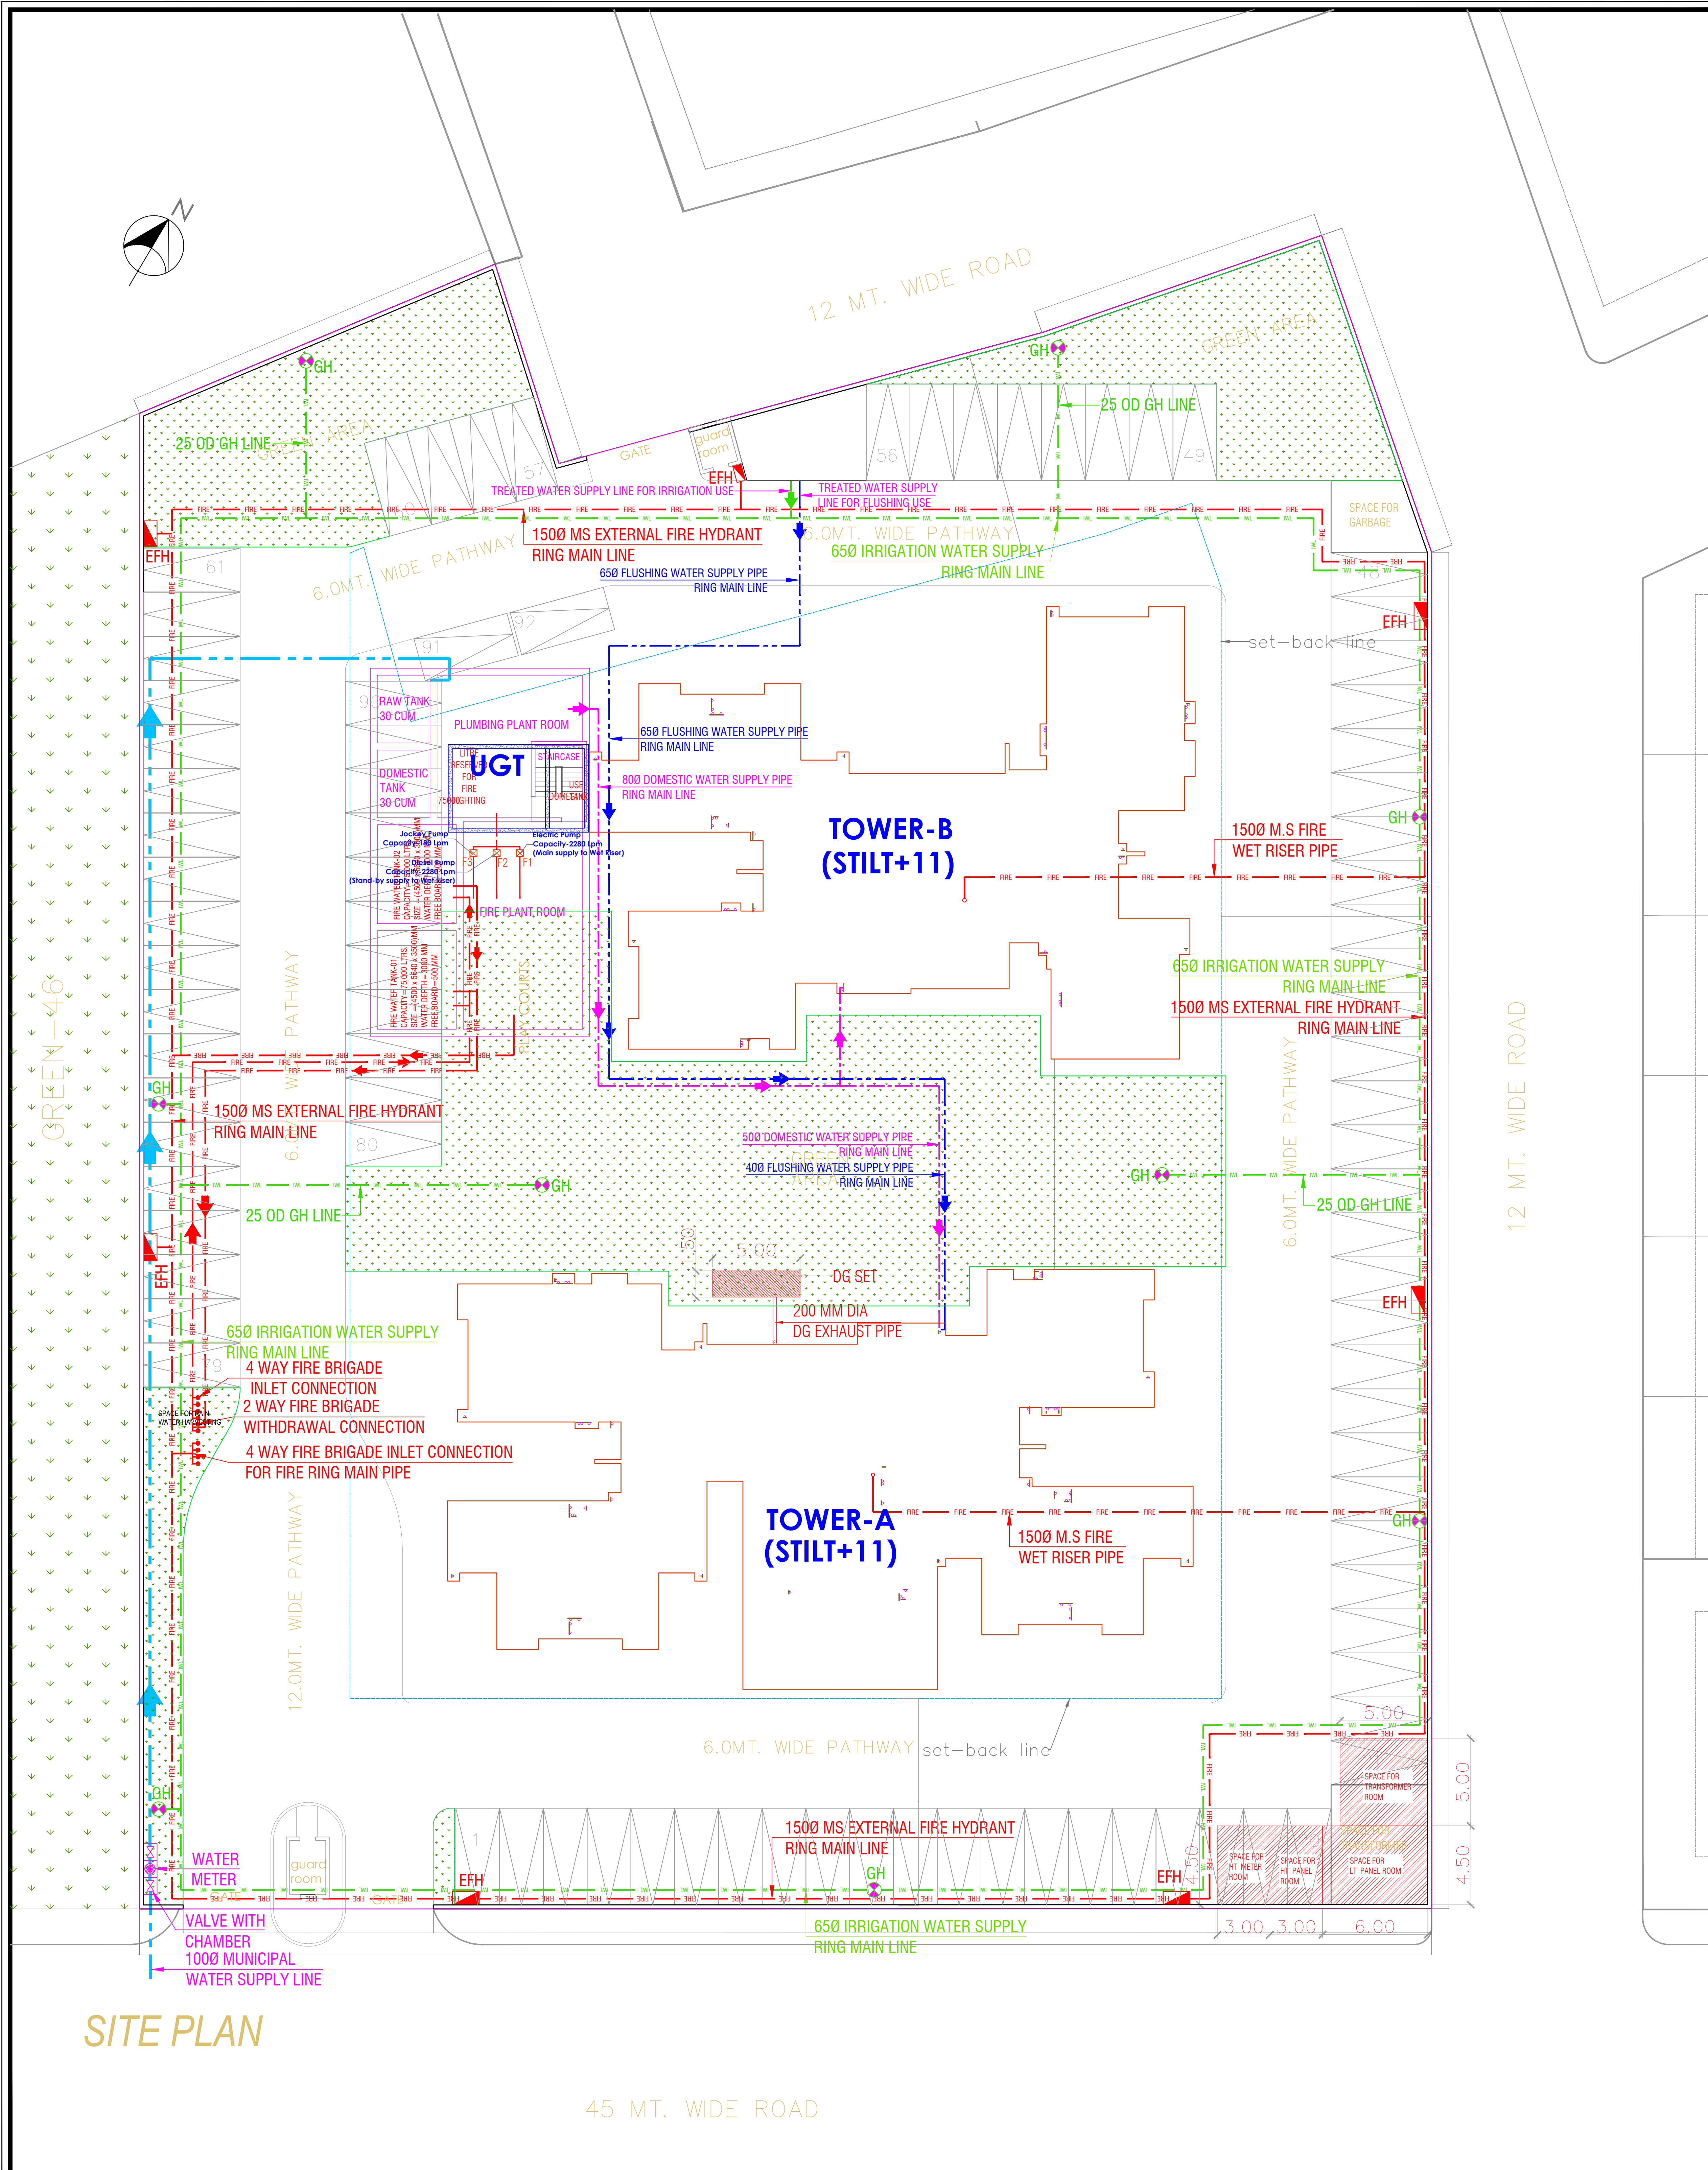

SITE PLAN

PLUMBING LEGEND :

	SEWER MANHOLE WITH 560Ø S.F.R.C. MANHOLE COVER.
	STORM WATER MANHOLE WITH 560Ø S.F.R.C. PERFORATED MANHOLE COVER.
	CATCH BASIN (450 x 450) MM WITH PERFORATED MANHOLE COVER
	CATCH BASIN (600 x 600) MM WITH PERFORATED MANHOLE COVER
	STORM WATER MANHOLE (900 x 800) MM WITH PERFORATED MANHOLE COVER.
	SEWER MANHOLE (600 x 600) MM
	SEWER MANHOLE (900 x 800) MM
	GULLY TRAP (300 x 300) MM
	EXTERNAL SW SEWER LINE (DIA AS / DESIGN CHART)
	EXTERNAL RCC STORM WATER LINE (DIA AS / DESIGN CHART)

PLUMBING LEGEND :

	1500 DI MUNICIPAL WATER SUPPLY LINE
	TUBE WALL WATER SUPPLY LINE
	GARDEN IRRIGATION WATER SUPPLY LINE
	EXTERNAL MS FIRE HYDRANT LINE (DIA MENTION IN LAYOUT)
	EXTERNAL FIRE HYDRANT (750 x 600 x 250) MM
	GARDEN HYDRANT WITH CHAMBER (300x300) MM
	RECHARGE PIT (2000 X 4000) MM.
	DESILTING CHAMBER (1000 x 2000) MM
	WATER METER WITH CHAMBER
	BUTTERFLY VALVE WITH CHAMBER
	NON RETURN VALVE (NRV) WITH CHAMBER

SPECIAL NOTES :

- ALL DIMENSIONS ON THIS DRAWING ARE IN MM.
- ONLY WRITTEN DIMENSIONS ARE TO BE FOLLOWED. DRAWINGS SHOULD NOT BE SCALED UNDER ANY CIRCUMSTANCES.
- ALL MEASUREMENTS MUST BE CHECKED AND VERIFIED BY THE CONTRACTORS PRIOR TO EXECUTION OF WORK AT THE SITE.
- THIS DRAWING IS TO BE READ IN CONJUNCTION WITH ALL RELEVANT STRUCTURAL, SERVICES & FACILITY PLANNING DRAWINGS.
- ARCHITECTURAL DRAWINGS ARE TO BE FOLLOWED FOR THE LOCATION OF ALL STRUCTURAL MEMBERS & MASONRY WALLS. FOR SIZES & REINFORCEMENT DETAILS OF STRUCTURAL MEMBERS RELEVANT STRUCTURAL DRAWINGS ARE TO BE REFERRED.
- ANY DISCREPANCIES BETWEEN ARCHITECTURAL, STRUCTURAL AND SERVICES DRAWINGS MUST BE BROUGHT TO THE NOTICE OF THE ARCHITECTS IMMEDIATELY & PRIOR TO EXECUTION AT SITE.
- CO-ORDINATION WITH THE SERVICES SUCH AS HVAC, PLUMBING & ELECTRICAL ETC. IS THE RESPONSIBILITY OF THE CONTRACTORS.
- ALL MASONRY WALLS SHOULD BE ALIGNED WITH THE COLUMNS AS INDICATED ON THE PLAN IRRESPECTIVE OF THE POSITION AS CALCULATED WITH THE DIMENSIONING.
- FOR DETAILS, REFER RELEVANT LARGE SCALE DETAIL DRGS. AS INDICATED.

ISSUES

No.	date	BY	Description	NO. OF PRINTS

DRAWING STAGE :

SUBMISSION DRAWING

PROJECT :
PROPOSED GROUP HOUSING (G.H.-01) AT
INTEGRATED HOUSING SCHEME ELDECO
CITY AT LUCKNOW-HARDOI BYE
PASS,SITAPUR ROAD, LUCKNOW.

PROMOTER:
ELDECO HOUSING & INDUSTRIES (P) LTD.

ARCHITECTS :

MEP SERVICES

PARADISE CONSULTANTS
PLOT NO. 96, BASEMENT, JASOLA VIHAR
POCKET-1 NEAR LIVING STYLE MALL
LANDLINE +91-11-29943601, 26943216
NEW DELHI - 110025
E-mail: paradiseconsultants@gmail.com
website: www.paradiseconsultants.com

DRAWING TITLE :
SITE PLAN
WATER SUPPLY LAYOUT

scale : 1:200 (A1) drawn by : VIKRAM
date : 05/04/2021 checked by: ANIL
project no : approved by : NAFEEES
drawing no :

PL-PC-EH-WS-103

REVISION RO