


PLOT BH - 301 TO BH - 329

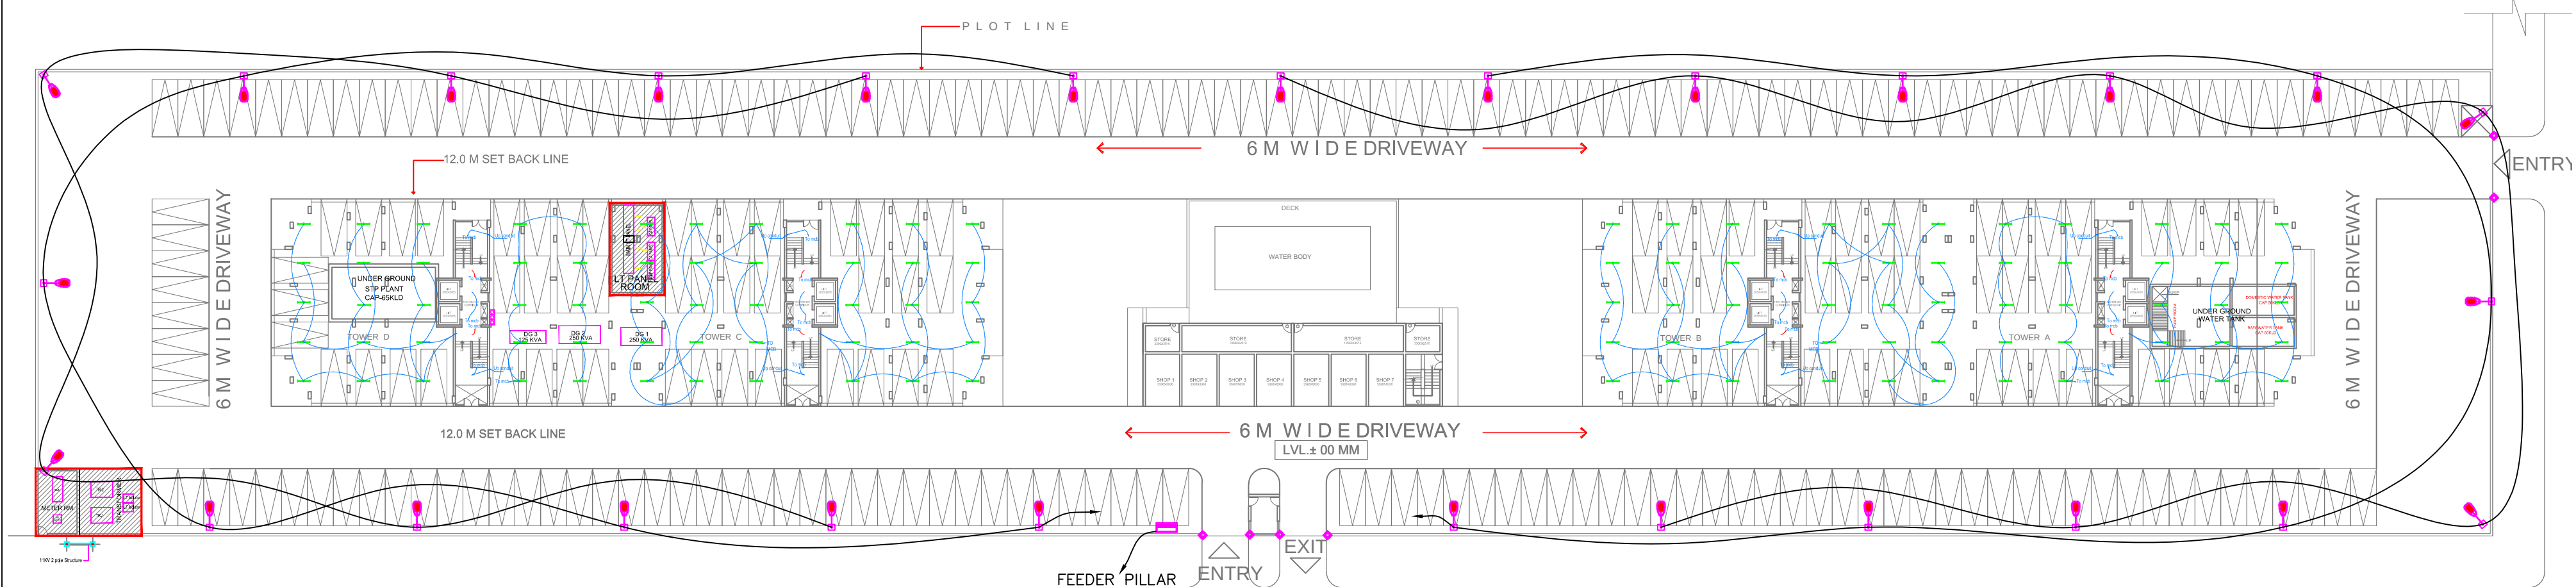

ELECTRICAL EQUIPMENT PLAN

LEGEND		
SYMBOL	TYPE	Count.
	9Mtr.POLE LIGHT FIXTURE	31
	GATE LIGHT FIXTURE	06
	FEEDER PILLAR	01

REVISED SUBMISSION DRAWING	
PROJECT :	
PROPOSED GROUP HOUSING BUILDING PLAN OF PLOT NO. GH-A (GH-6 TO GH-13) AT INDUSTRIAL AREA TALANAGARI, HOUSING SECTOR, ALIGARH, U.P.	
CLIENT :	
OZONE PROMOTERS PVT. LTD. B-2/16, MOHAN COOPERATIVE INDL. ESTATE, BEHIND BADARPUR METRO STATION, NEW DELHI - 110044.	
SHEET TITLE :	
SITE PLAN ELECTRICAL LAYOUT PLAN	
DATE :	DRG.NO: SD-102
SCALE : 1:300	NORTH:
ARCHITECTS:	
SPACE DESIGN GROUP W-139, FF, Greater Kailash- I, New Delhi 48 PHONE :011-29240732, 41631265, 29233752 email : spacedesigngroup@rediffmail.com	