


LEGEND - SEWERAGE

SYMBOL	DESCRIPTION
GL	GROUND LEVEL
IL	INVERT LEVEL
CL	CONNECTION LEVEL
	GROUND LEVEL INVERT LEVEL
	CONNECTING CHAMBER 600X600
	SEWER LINE MAN HOLE 1000X1200
	SEWER LINE MAN HOLE 1200X1200
	2500 SEWERAGE PIPE
	3000 SEWERAGE PIPE
	4000 SEWERAGE PIPE
	TRUNK SEWER 12000

PROP. CATTLE COLONY

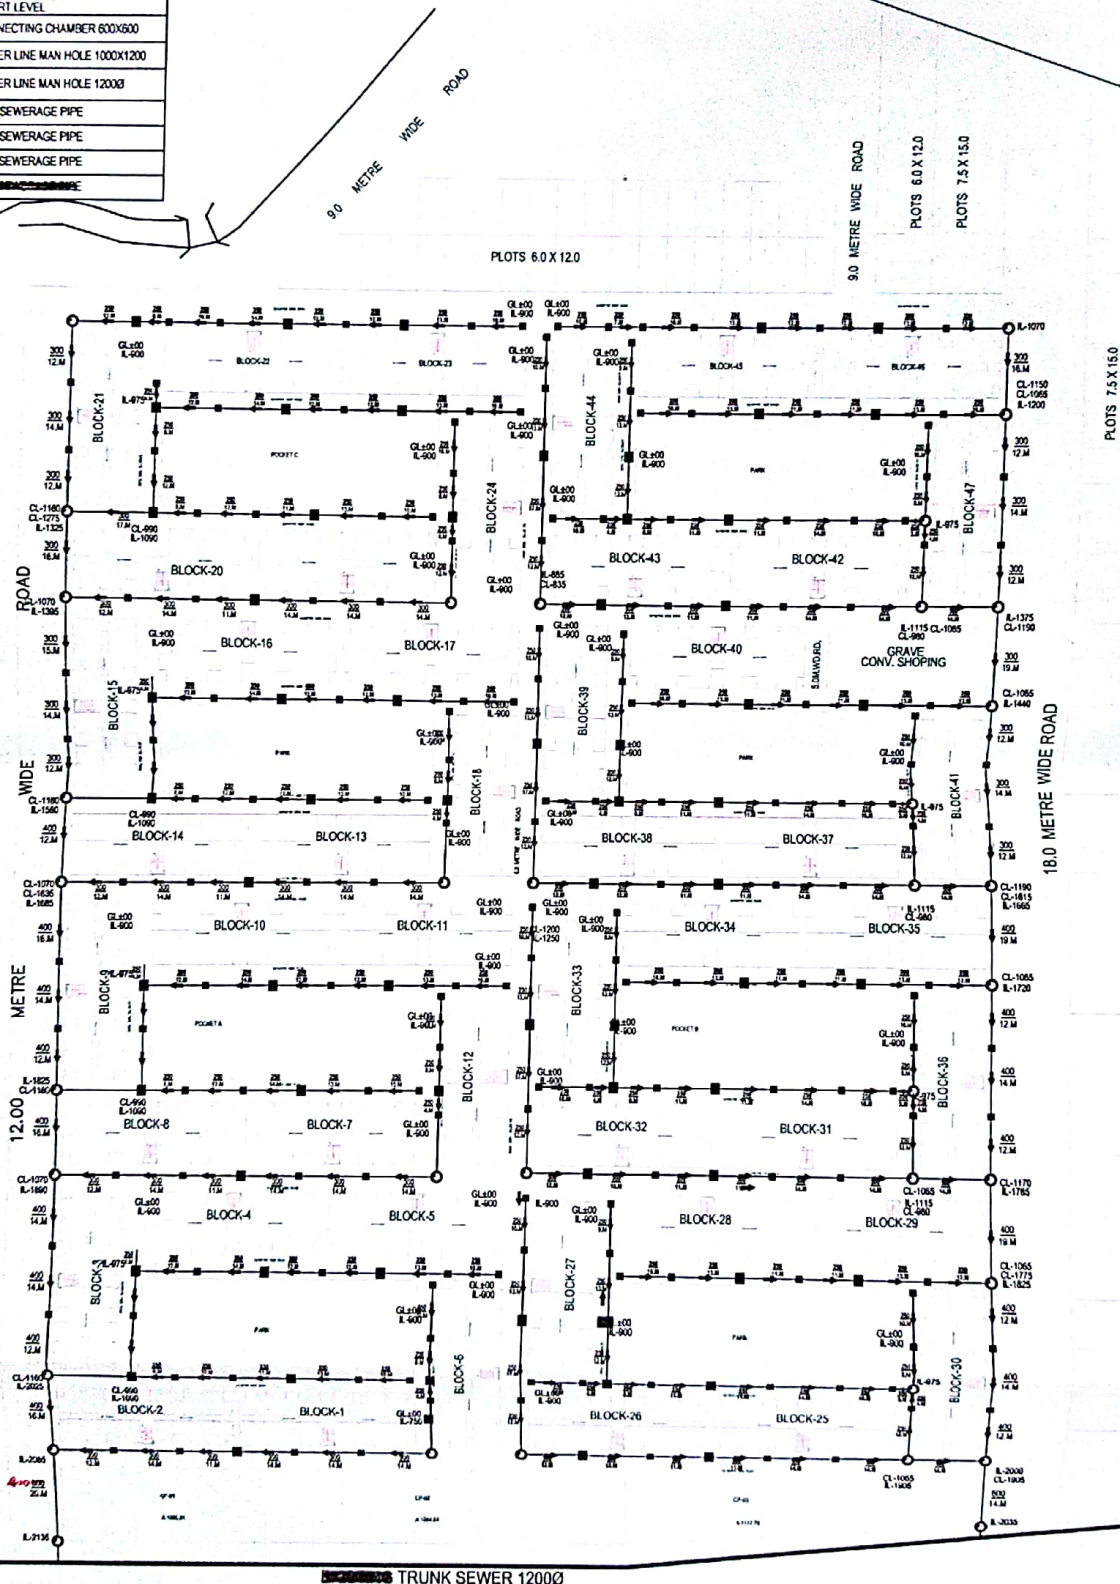

PROJECT:-	DRAWING TITLE:-	Drg. No.	Scale	Drawn by	Services Consultant :	ARCHITECTURAL CONSULTANTS -
PRADHANMANTRI-AWAS-BASANTKUNJ	SITE PLAN OF SEWERAGE LAYOUT	PL-01	A2-150	AMIT	SHAH PANT	ARCH DOT CREATION
			Date	Checked By		
			SEP/2019	M. PANT		