



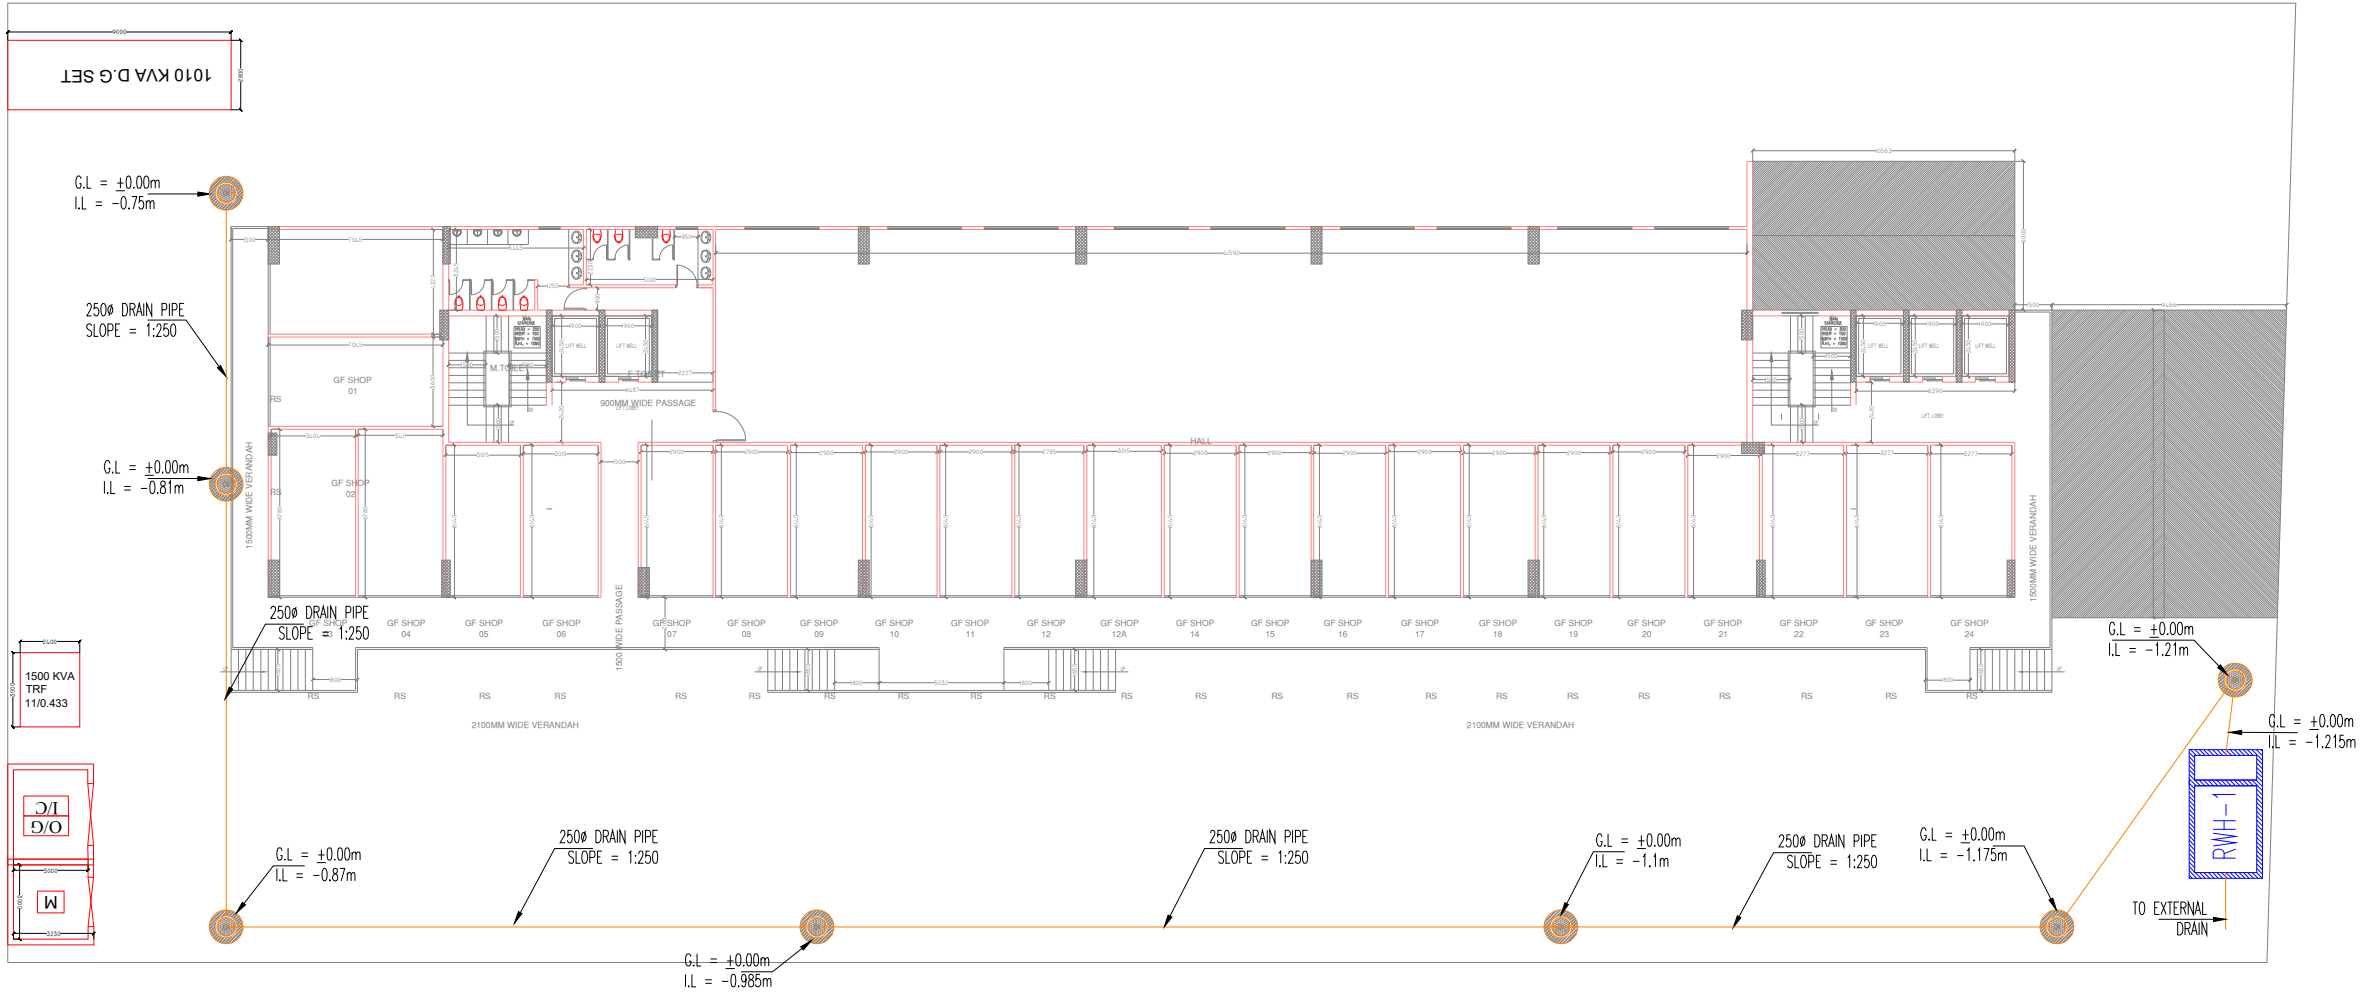

GROUND FLOOR PLAN

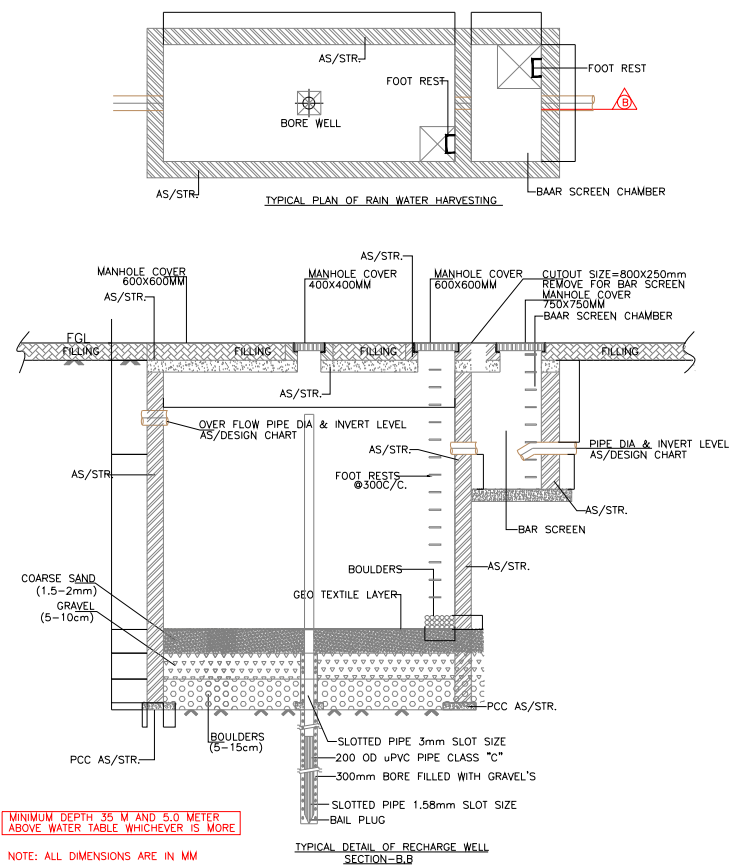

| LEGENDS FOR DRAINAGE SYSTEM:- |                            |
|-------------------------------|----------------------------|
|                               | DOMESTIC WATER SUPPLY PIPE |
|                               | DOMESTIC WATER SUPPLY PIPE |
|                               | DRAINAGE MANHOLE           |
|                               | RAIN WATER HARVESTING PIT  |

- NOTES**
- THIS DRAWING IS THE PROPERTY OF SINGLA ARCHITECTS AND ASSOCIATES AND IS NOT TO BE USED FOR ANY PURPOSE OTHER THAN FOR WHICH IT IS ISSUED WITHOUT PERMISSION OF ITS PRINCIPALS.
  - THIS DRAWING IS TO BE READ IN CONJUNCTION WITH OTHER RELEVANT ARCHITECTURAL, STRUCTURAL AND OTHER SERVICES CONSULTANTS DRAWING. IT SHALL BE THE DEEMED RESPONSIBILITY OF THE CONTRACTOR/FABRICATOR TO BRING IN TO NOTICE OF ARCHITECTS IF ANY DISCREPANCY WITHIN OR BETWEEN THE DRAWINGS PRIOR TO CONSTRUCTION.
  - ALL WRITTEN DIMENSIONS ARE TO BE FOLLOWED AND THE DRAWING IS NOT TO BE SCALES.

**KEY PLAN**

**LEGEND**

| COPY | REV. | DATE | DESCRIPTION |
|------|------|------|-------------|
|      |      |      |             |
|      |      |      |             |
|      |      |      |             |

**PROJECT**

**CLIENT**

**ARCHITECTS**

**SINGLA ARCHITECTS & ASSOCIATES**  
EROS MARKET PLACE, PLOT NO- 02, SHOP - 87 1ST. FLOOR  
SHAKTI KHAND - 2, INDIRAPURAM, GHAZIABAD (U.P.)  
Mob: 97199845  
e-mail: singla33@gmail.com

**MEP Consultant:**  
**WeDESIGN Associates**  
"Engineered for perfection"  
Email: we.design.associates@gmail.com  
Mob: 9999288126, 9999288407, 9882244995

**DRAWING TITLE**

**HOTEL**  
**EXTERNAL SERVICES LAYOUT PLAN**

| SCALE         | DATE       | DEALT BY |
|---------------|------------|----------|
| AS SPECIFIED  | 14.09.2023 | VIHOR    |
| APPROVED BY   |            |          |
| GAURAV SINGLA |            |          |
| DRG.NO.       |            |          |