

मथुरा-वृन्दावन विकास प्राधिकरण 99 वीं बोर्ड बैठक दिनांक 08.11.2023 के मद्द सख्या 5/99 पर आशिक संशोधन के साथ मानचित्र स्वीकृत किया गया।

SANCTION MAP NO. :- MVDA/LD/21-22/0725
DATE :- 04/08/2022

90 वीं बोर्ड बैठक मद्द सख्या 4/90,
22/07/2021 को सैद्धान्तिक स्वीकृति प्रदान की गयी

THIS DRAWING IS THE PROPERTY OF THE DCPL
AND SHALL NOT BE COPIED OR USED IN ANY
MANNER WITHOUT PRIOR PERMISSION.

REVISIONS OF DRAWINGS

MARK	DATE	DESCRIPTION

Note:- Building Bye-Laws 2008
(as Amended 2011,2016 & 2023) to be Followed

ARCHITECT CONSULTANT

DERA Consultants Pvt. Ltd.
30B, GEETA ENCLAVE, KRISHNA NAGAR, MATHURA
281004 Tel : +91-8909871654, Email : office@dera.co.in

PROJECT TITLE

PROPOSED LAYOUT "GOVIND VIHAR AWASIYA YOUNA
MAUZA JAINT ON KHASRA NO. 233, 236, 739MII,
741,743, 744MI,744MI,745,746,748MI,748MI,754MI,
754MI,767,771,772,774,775 TEH. & DISTT. MATHURA.

DRAWING TITLE

ELECTRICAL LINE LAYOUT PLAN

DWG NO.:-

MTR/GOVIND/LAYOUT/SERVICE_ 01

SCALE:- SHEET SIZE A1 SHEET NO.- 02/01

SURVEYOR:-

AUTHORIZED SIGNATORY OF ALL LAND OWNER:-

Mr. Ashutosh Singh CONSULTANT & SURVEYED BY:- SIGN


DERA CONSULTANT Pvt.Ltd SURVEY CHECKED BY:- SIGN

AE. SUNIL KUMAR AGRAWAL BOUNDARY DEMARKED & SAZRA SUPERIMPOSED BY:- SIGN

R.I. HARSWARUP GAUTAM SIGN

A.E. E.E. T.P.

SECRETARY VICE CHAIRMAN

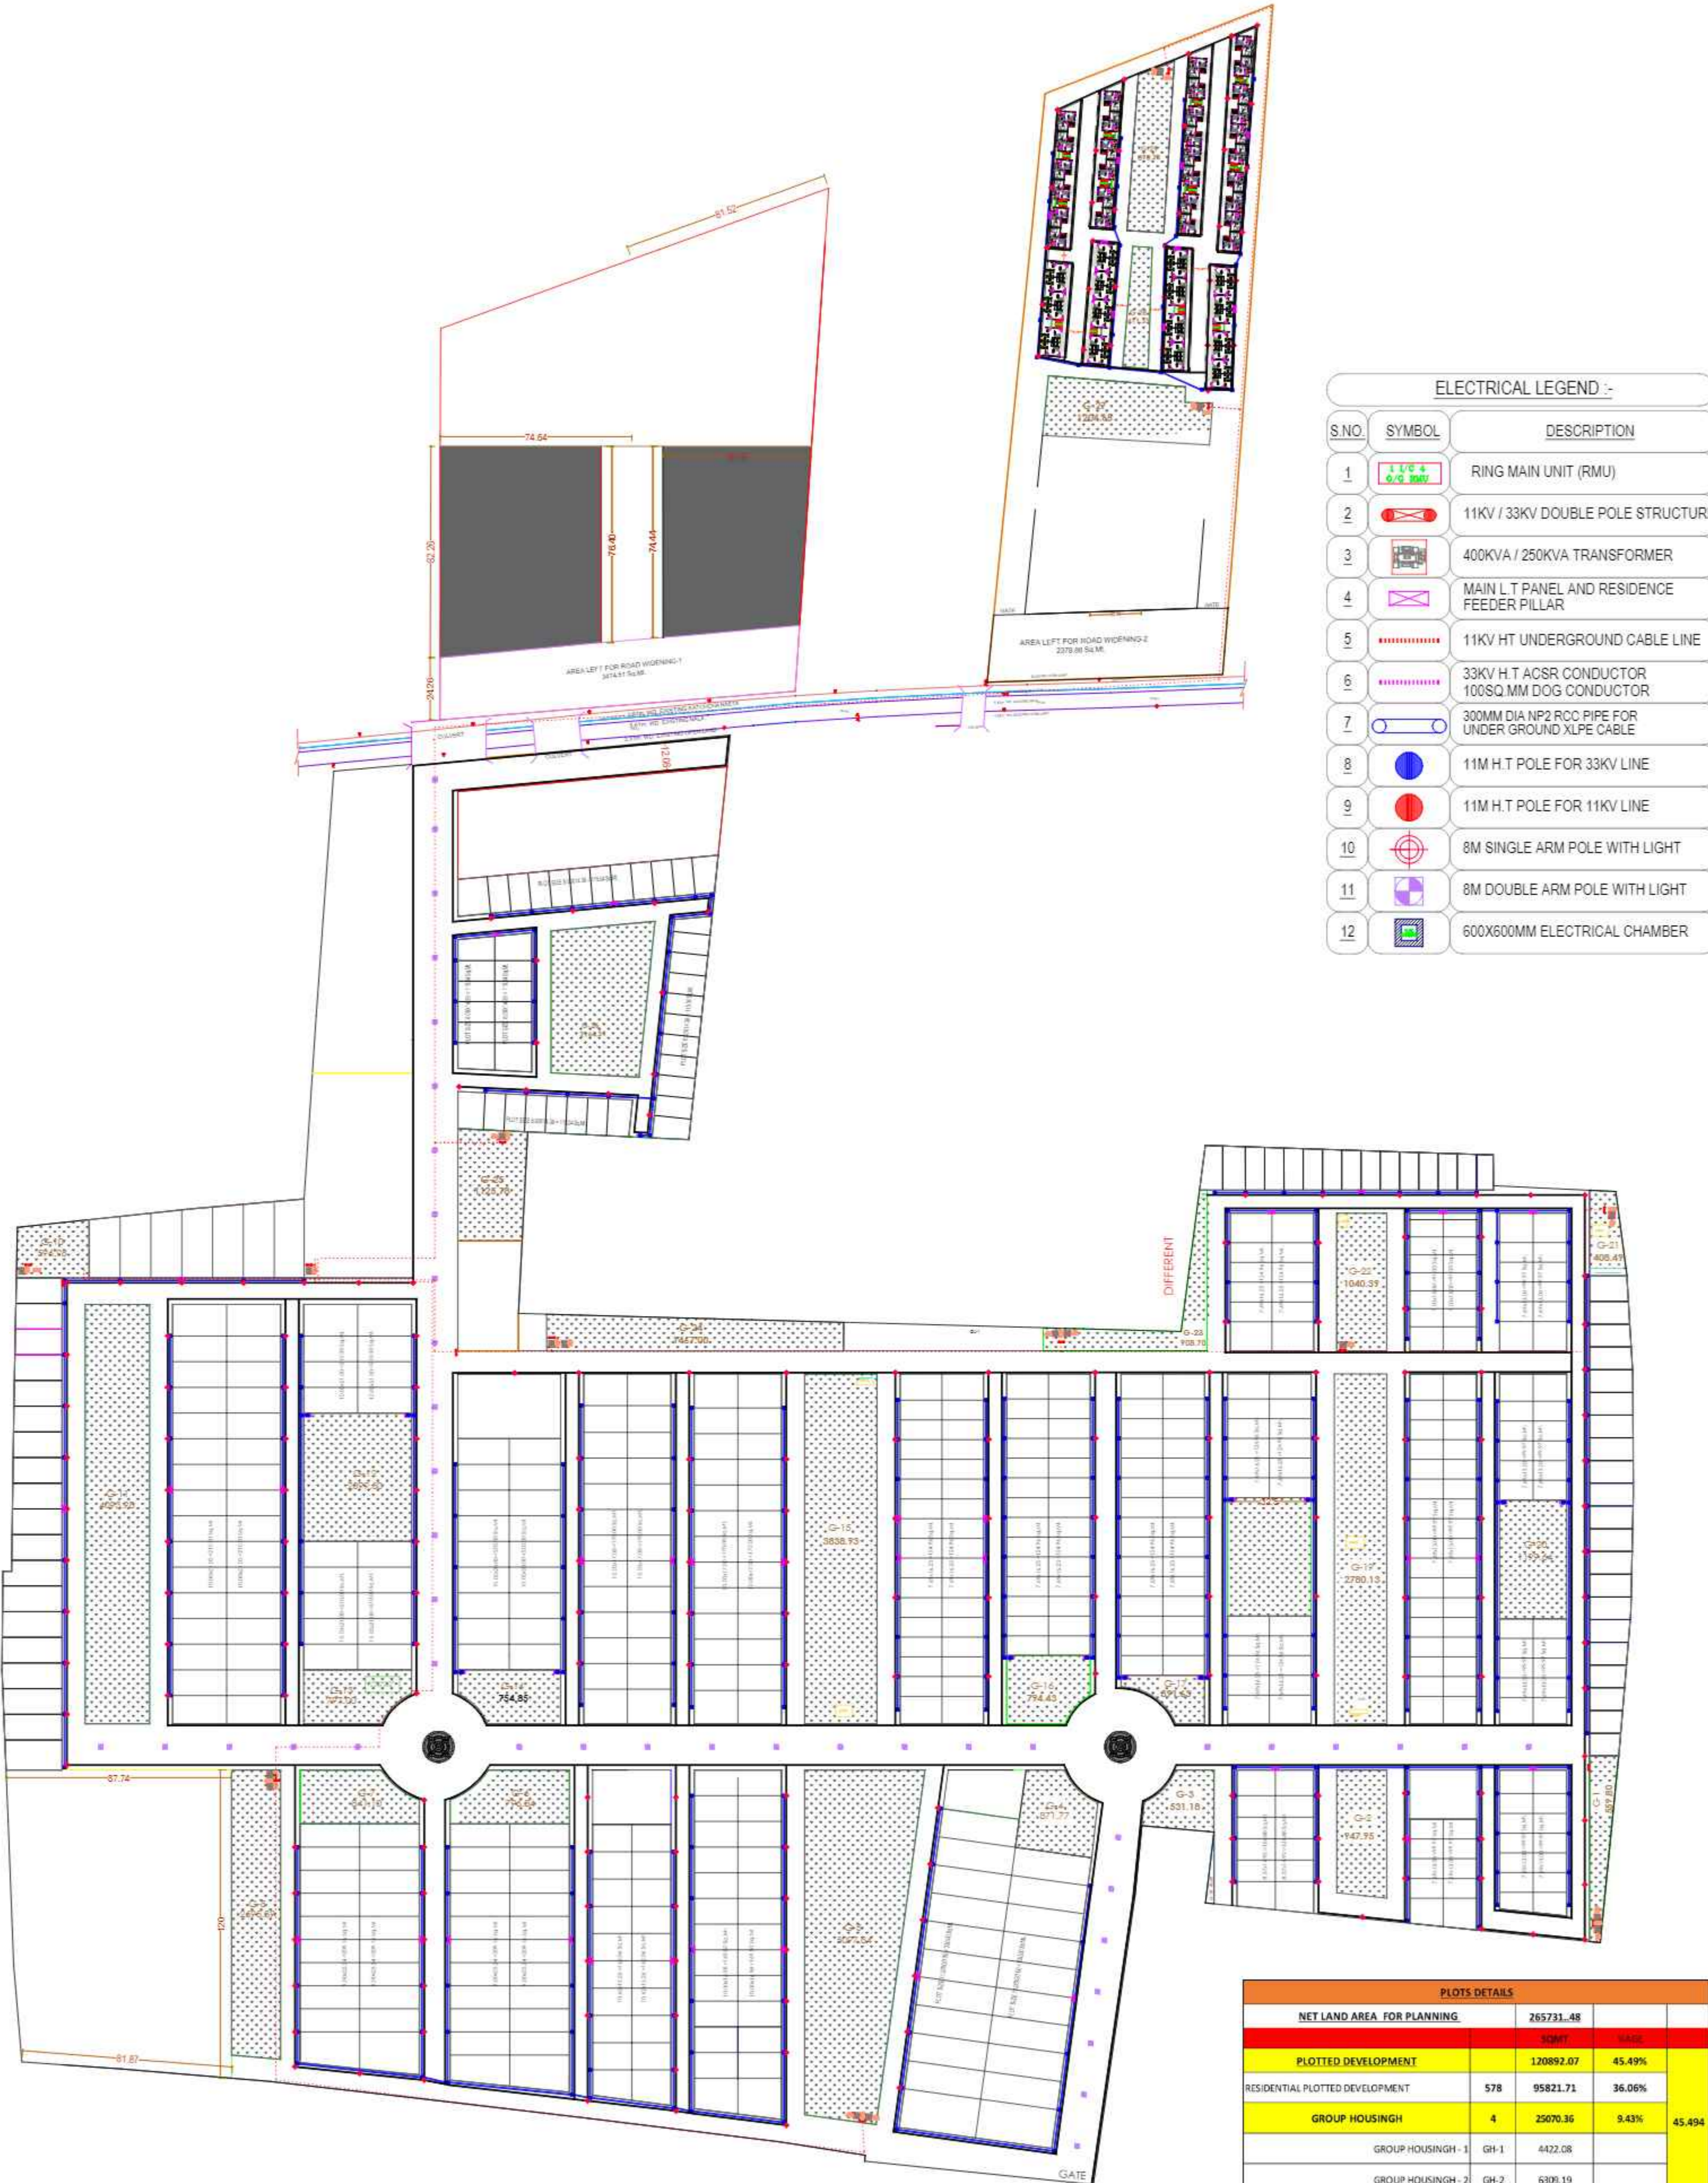

ELECTRICAL LEGEND :-

S.NO.	SYMBOL	DESCRIPTION
1	[Symbol]	RING MAIN UNIT (RMU)
2	[Symbol]	11KV / 33KV DOUBLE POLE STRUCTURE
3	[Symbol]	400KVA / 250KVA TRANSFORMER
4	[Symbol]	MAIN L T PANEL AND RESIDENCE FEEDER PILLAR
5	[Symbol]	11KV HT UNDERGROUND CABLE LINE
6	[Symbol]	33KV H.T ACSR CONDUCTOR 100SQ.MM DCG CONDUCTOR
7	[Symbol]	300MM DIA NP2 RCC PIPE FOR UNDER GROUND XLPE CABLE
8	[Symbol]	11M H.T POLE FOR 33KV LINE
9	[Symbol]	11M H.T POLE FOR 11KV LINE
10	[Symbol]	8M SINGLE ARM POLE WITH LIGHT
11	[Symbol]	8M DOUBLE ARM POLE WITH LIGHT
12	[Symbol]	600X600MM ELECTRICAL CHAMBER

PLOTS DETAILS

NET LAND AREA FOR PLANNING	265731.48	
PLOTTED DEVELOPMENT	120892.07	45.49%
RESIDENTIAL PLOTTED DEVELOPMENT	578	95821.71 36.06%
GROUP HOUSING	4	25070.36 9.43%
GROUP HOUSING-1	GH-1	4422.08
GROUP HOUSING-2	GH-2	6309.19
GROUP HOUSING-3	GH-3	4402.78
GROUP HOUSING-4	GH-4	9936.31
ACADEMIC FACILITIES	5	8179.90 3.08%
LAND FOR INTER COLLEGE	1	4091.59
LAND FOR HIGH SCHOOL	1	2000.41
LAND FOR NURSERY SCHOOL -2	1	556.07
LAND FOR NURSERY SCHOOL -3	1	498.42
LAND FOR NURSING HOME	1	3321.41
COMMERCIAL AREA	3	12495.03 4.70%
COMMERCIAL-1	1	3521.30
COMMERCIAL-3	1	4000.45
COMMERCIAL-4	1	4973.28
CONVINIENT SHOP AREA	1	245.96 0.20%
CS-1	1	245.96
SALEABLE LAND AREA		
SALEABLE LAND AREA INCLUDING COMMERCIAL, RESIDENTIAL, NURSING HOME, SCHOOL, COLLEGE, CONVINIENT SHOPS, GROUP HOUSING		141812.96 53.37%

Signature
Arch. Mayank Singh
1111, 1112, 1113, 2579,