



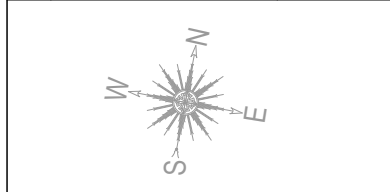


SECOND FLOOR PLAN ELECTRICAL PLAN

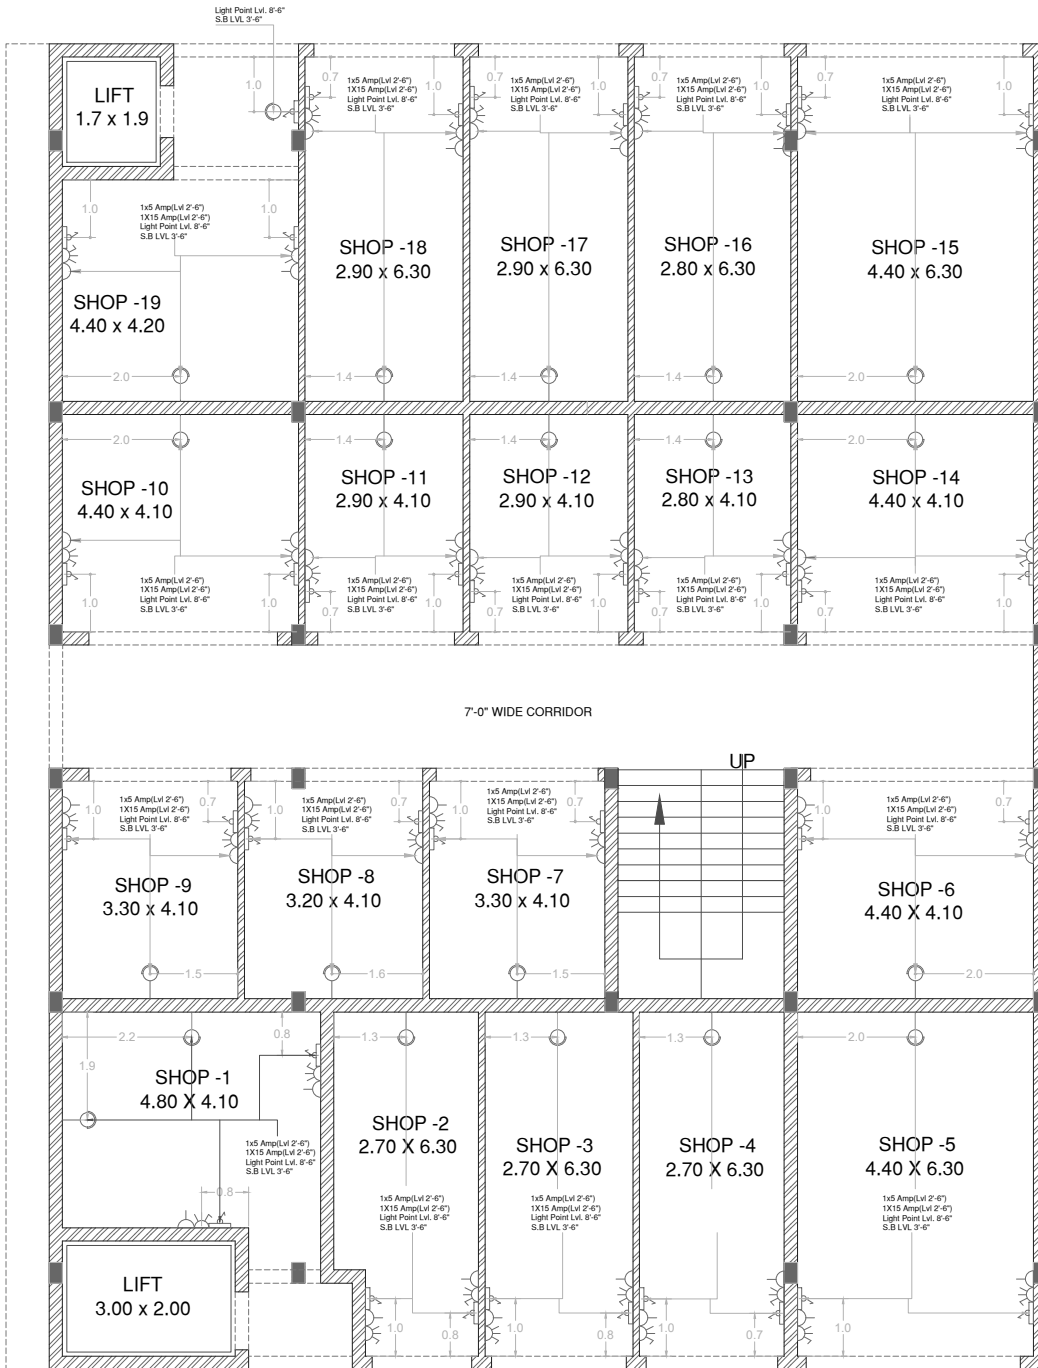

PROJECT	
COMMERCIAL	
DRAWING TITLE	
SECOND FLOOR ELECTRICAL PLAN	
DEALT BY	
ROHIT SINGH	
DATE - 23-05-2024	REVISION NO. - 0
SCALE	DWG NO-01
NTS	
JANUS DESIGNS	
NEAR GANPATI PLAZA, RAILWAY ROAD, HAPUR Ph:07417857758,09997563895. EMAIL: Jatinsgoel@gmail.com WEB: www.janusdesigns.in	



GROUND FLOOR PLAN ELECTRICAL PLAN

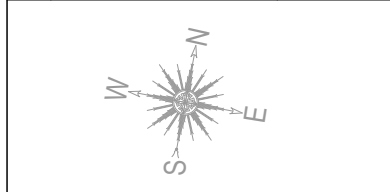

PROJECT
COMMERCIAL


DRAWING TITLE
GROUND FLOOR ELECTRICAL PLAN

DEALT BY
ROHIT SINGH


DATE - 23-05-2024 **REVISION NO.** - 0

SCALE **DWG NO.**-01


JANUS DESIGNS
NEAR GANPATI PLAZA, RAILWAY ROAD, HAPUR
Ph:07417857758,09997563895.
EMAIL: Jatinsgoel@gmail.com
WEB: www.janusdesigns.in

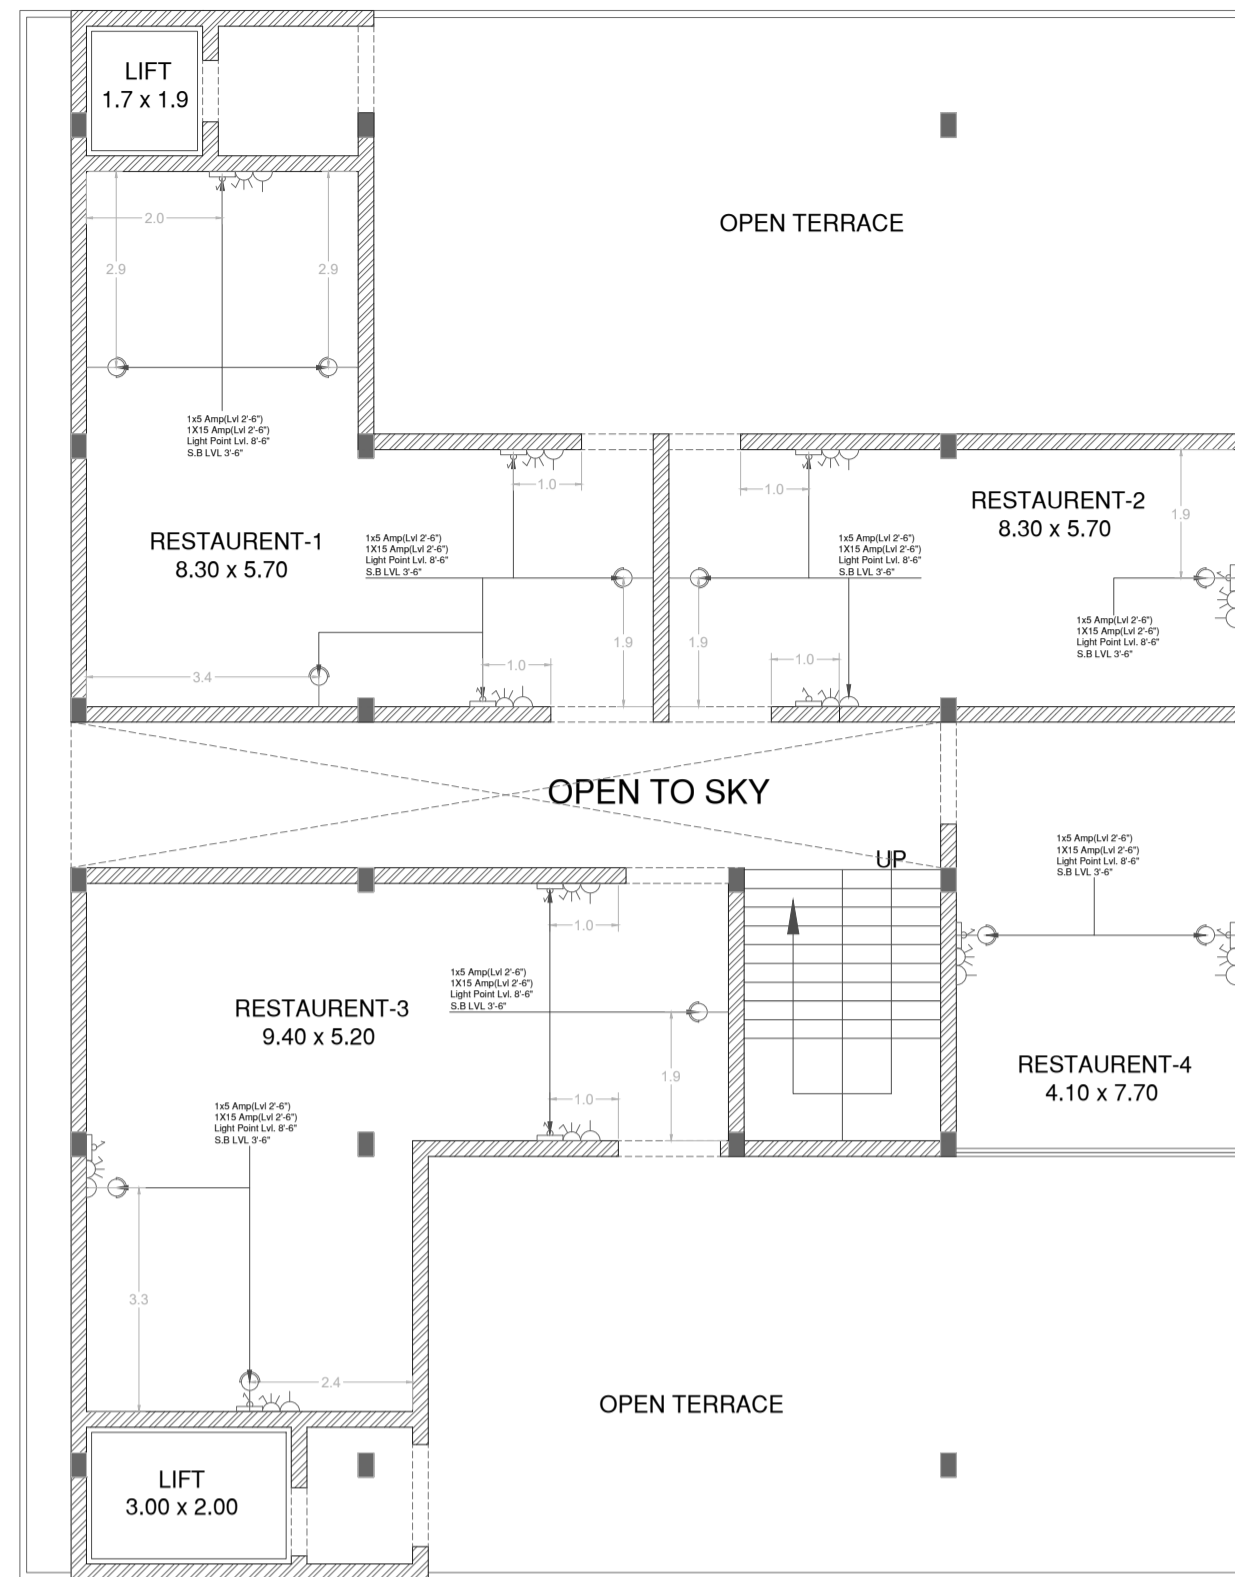


THIRD FLOOR PLAN
ELECTRICAL PLAN

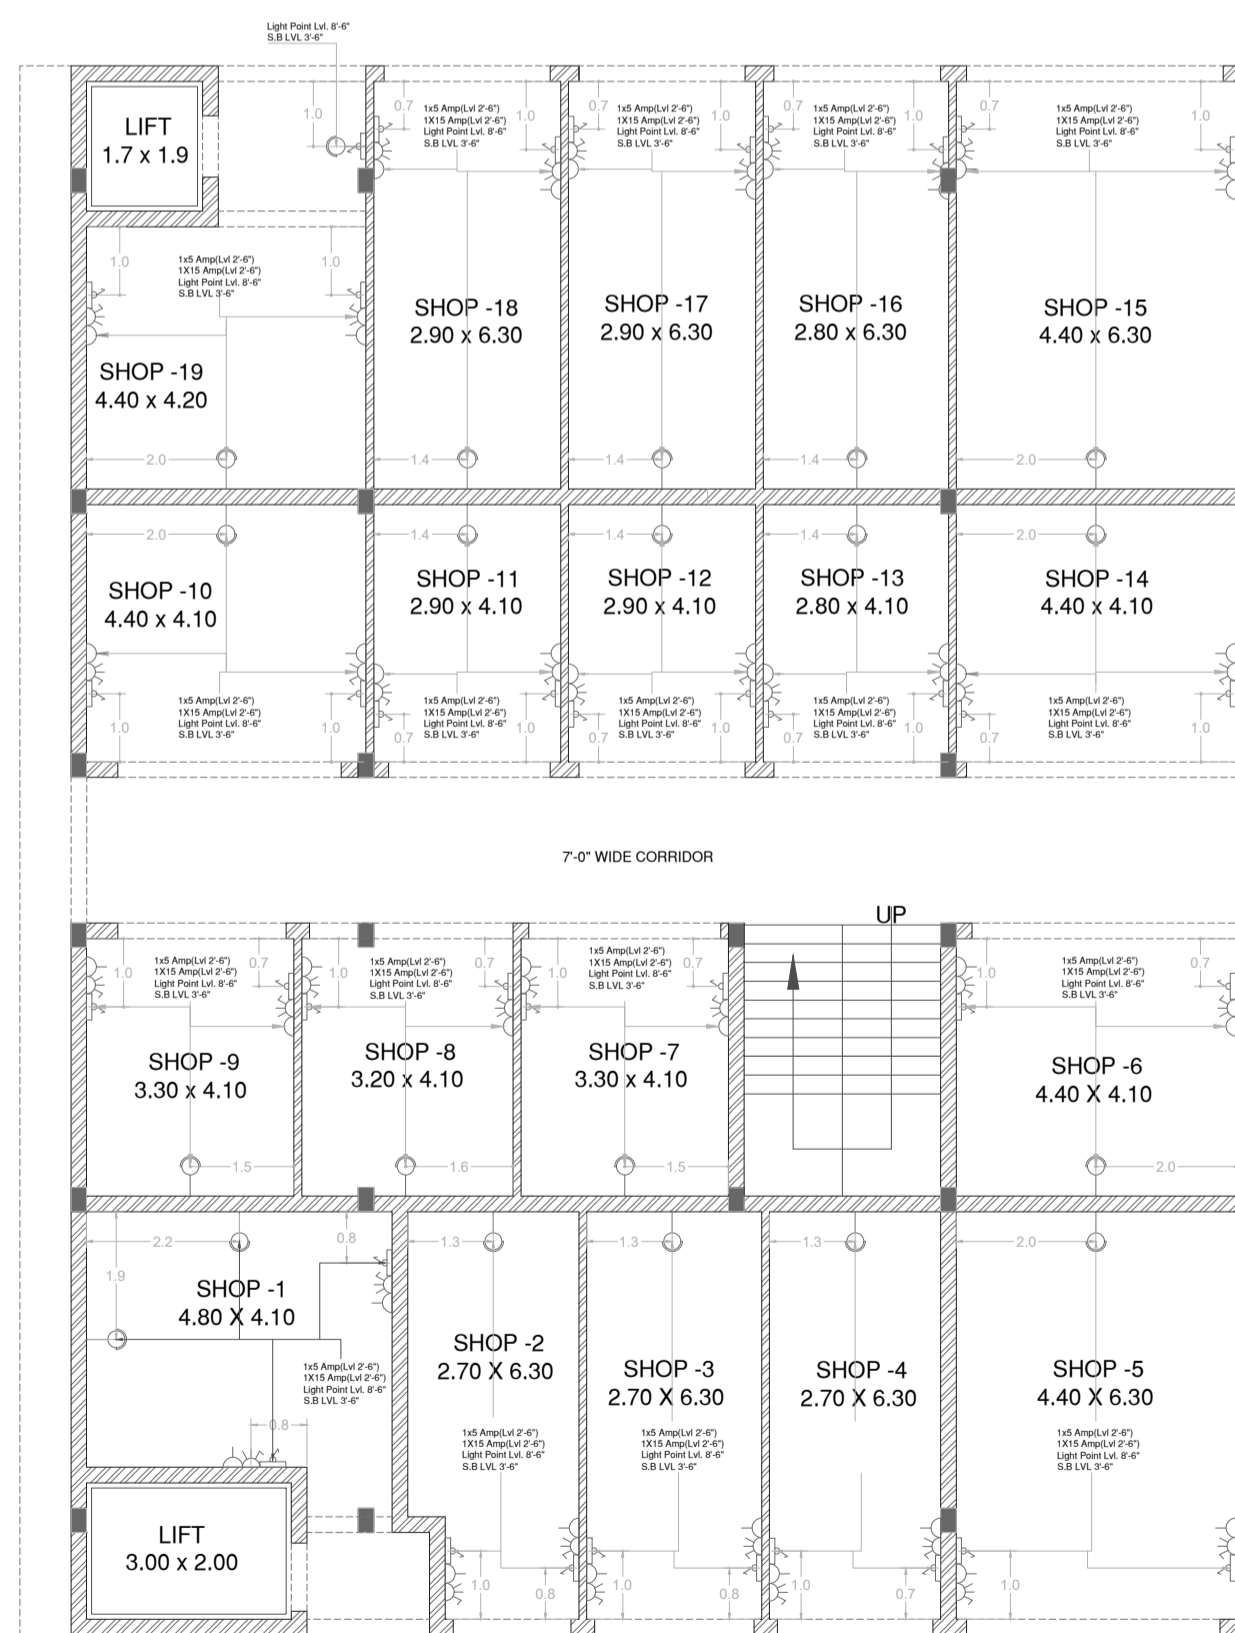

GROUND FLOOR PLAN
ELECTRICAL PLAN

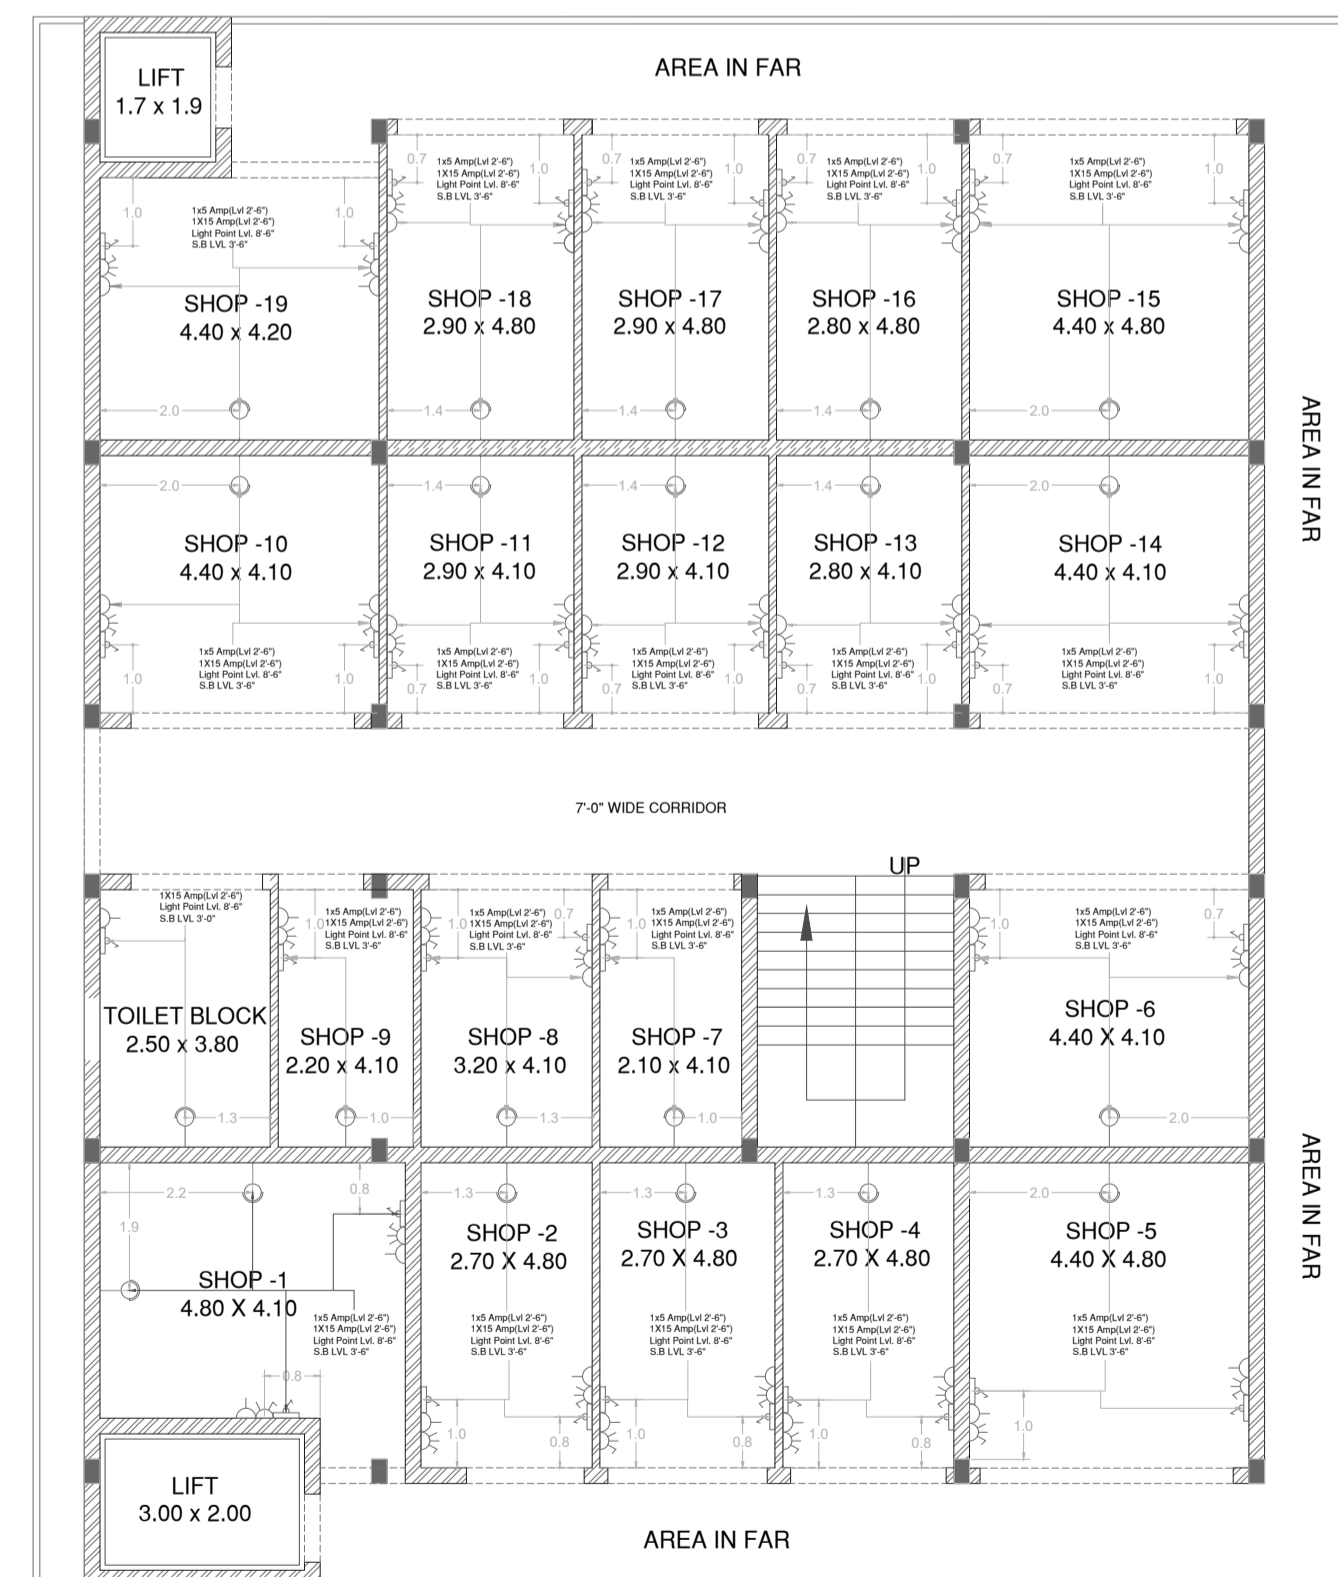

FIRST FLOOR PLAN
ELECTRICAL PLAN

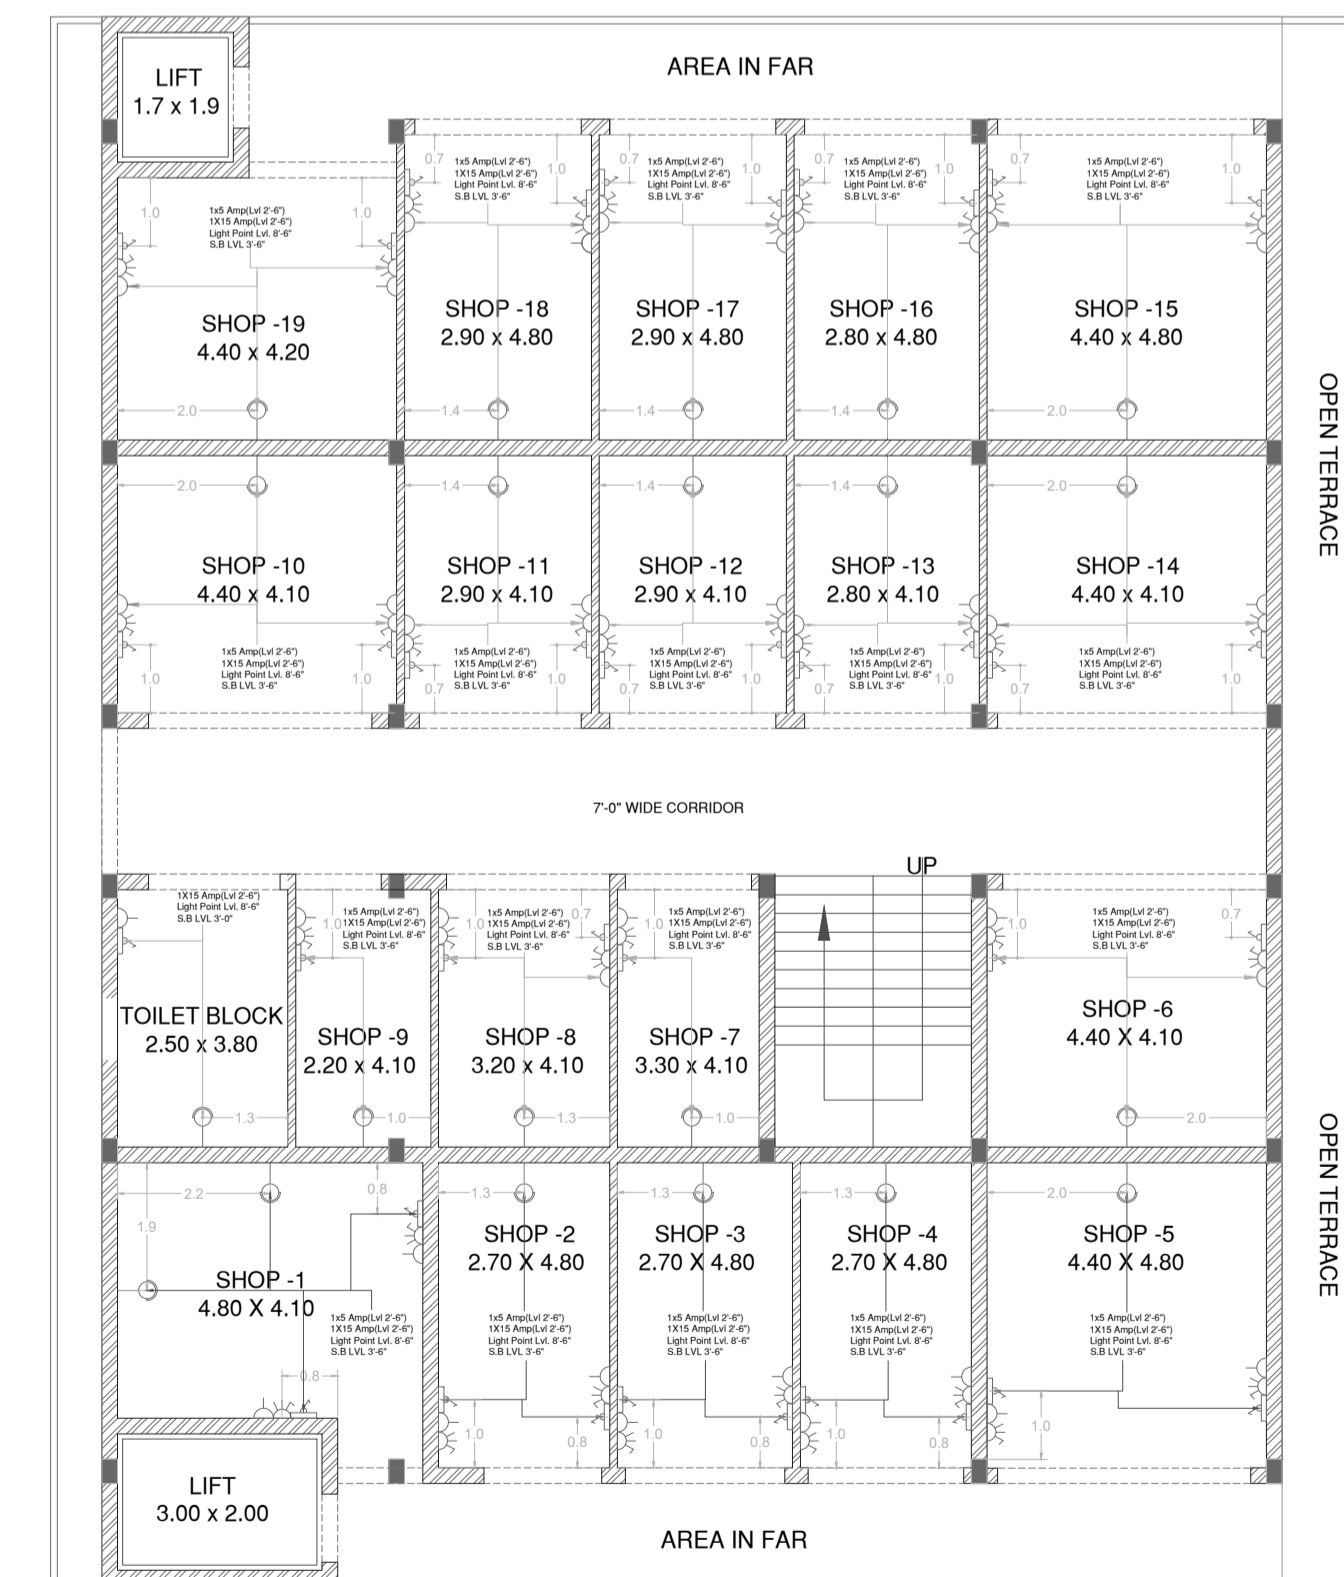

SECOND FLOOR PLAN
ELECTRICAL PLAN

PROJECT

COMMERCIAL

DRAWING TITLE

DEALT BY

ROHIT SINGH

DATE - 24-05-2024

REVISION NO. - 0

SCALE

DWG NO-01


NTS

JANUS DESIGNS

NEAR GANPATI PLAZA, RAILWAY ROAD, HAPUR
Ph:07417857758,09997563895.
EMAIL: Jatinsgoel@gmail.com
WEB: www.janusdesigns.in



FIRST FLOOR PLAN ELECTRICAL PLAN

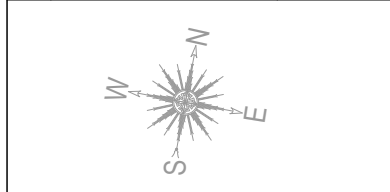

PROJECT	
COMMERCIAL	
DRAWING TITLE	
FIRST FLOOR ELECTRICAL PLAN	
DEALT BY	
ROHIT SINGH	
DATE - 23-05-2024	REVISION NO. - 0
SCALE	DWG NO-01
NTS	
JANUS DESIGNS	
NEAR GANPATI PLAZA, RAILWAY ROAD, HAPUR Ph:07417857758,09997563895. EMAIL: Jatinsgoel@gmail.com WEB: www.janusdesigns.in	