



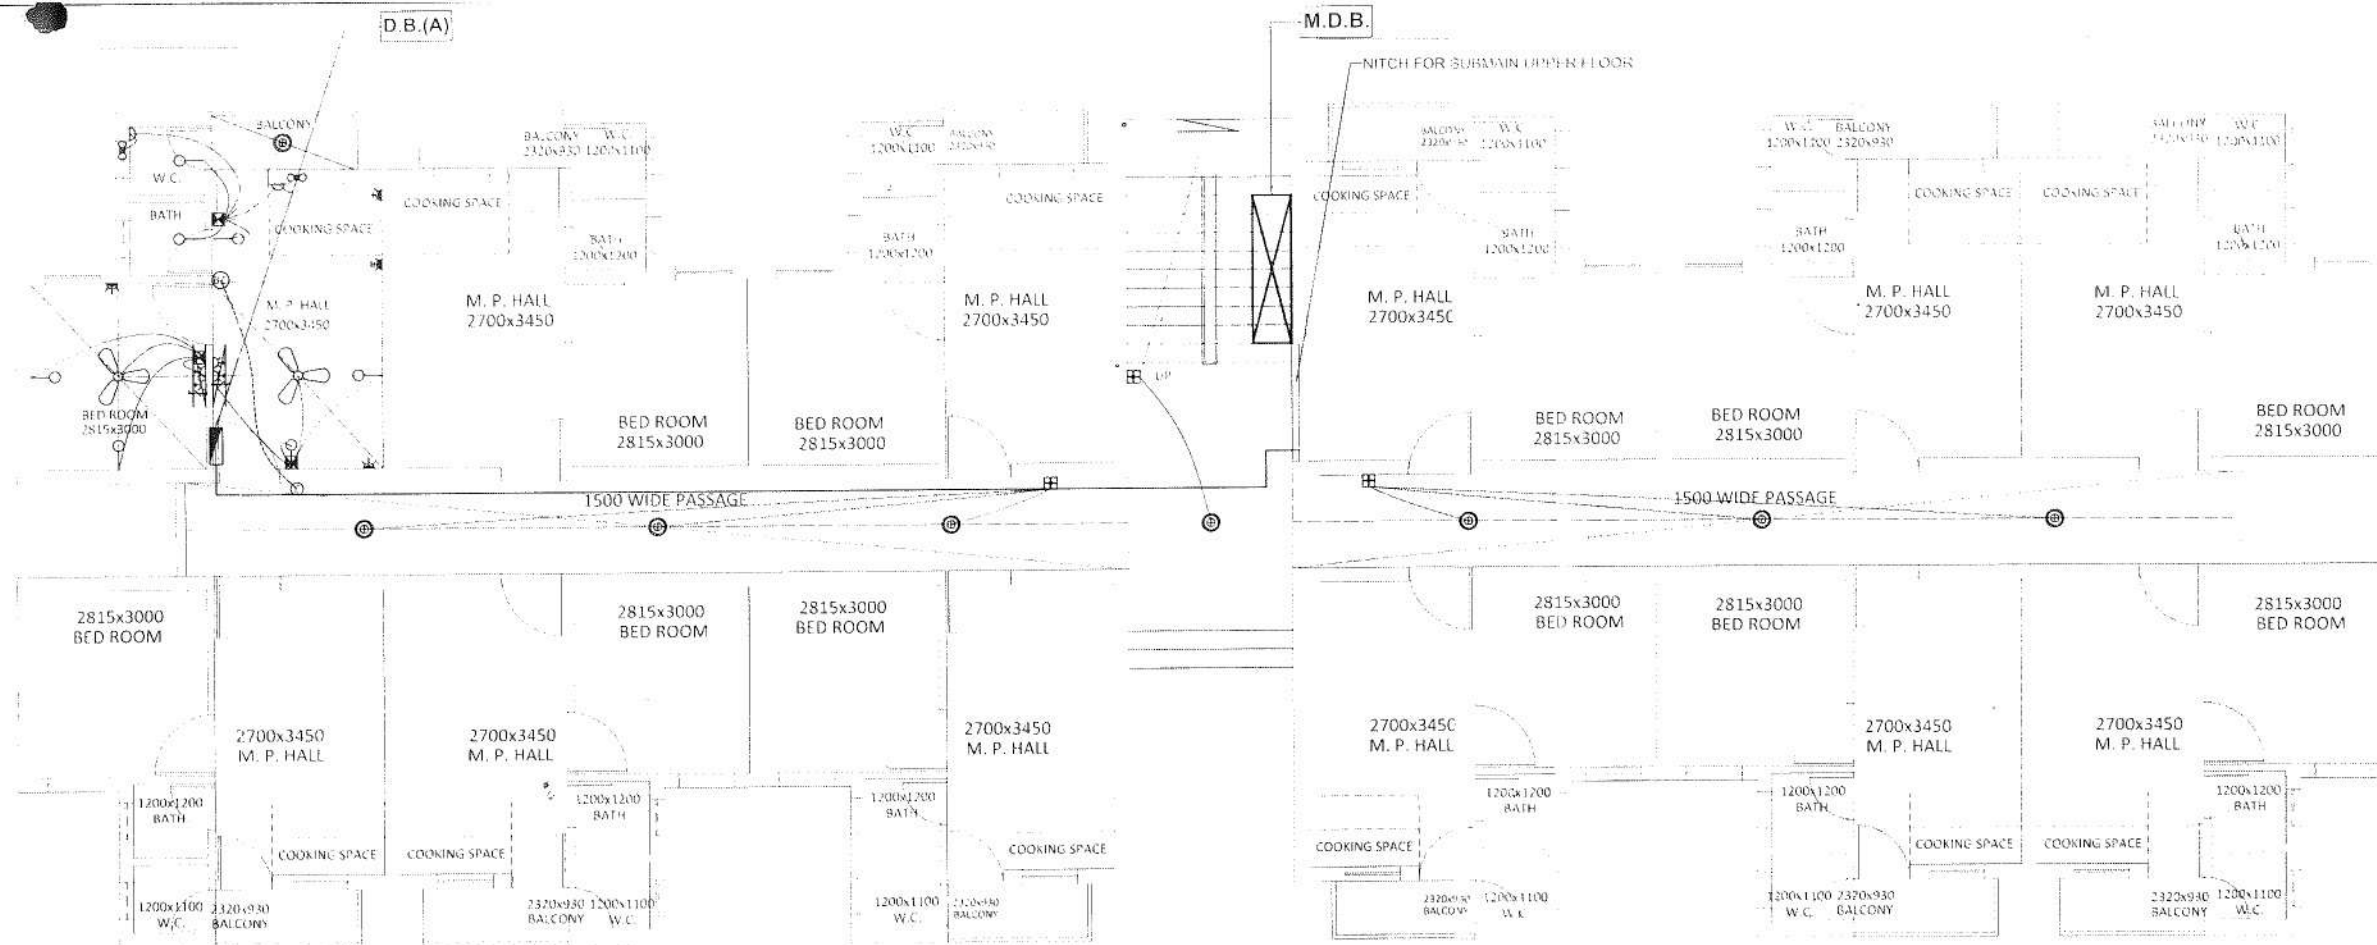

TYPICAL FLOOR PLAN (BLOCK AREA 440.70 SQ.M.) (G+3)

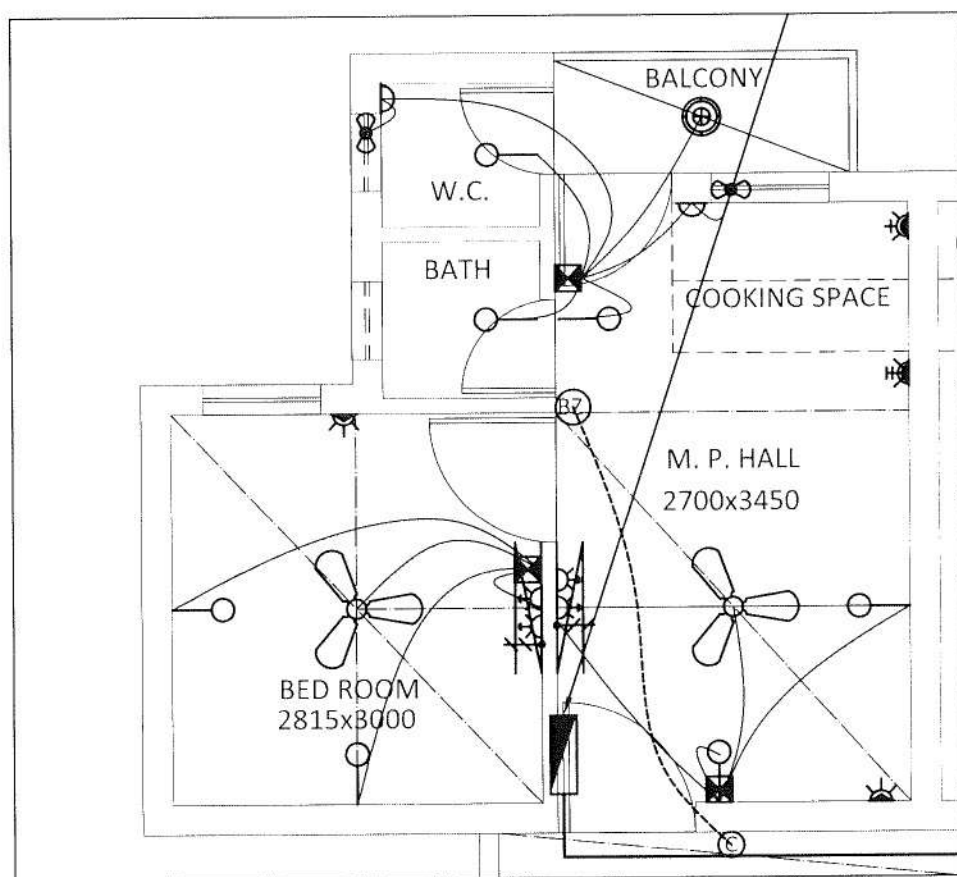

BLOW- UP

LEGEND:-ELECTRICAL

S.NO.	SYMBOL	DESCRIPTION	POSITION
1	⊕	1x22 W LED TUBE LIGHT POINT	2450
2	⊕	WALL MOUNTED BRACKET LIGHT POINT	2450
3	⊕	CEILING LIGHT POINT	ON CEILING
4	⊕	SWITCH BOARD WITH SA SWITCH SOCKET	1200
5	⊕	SWITCH BOARD WITHOUT SA SWITCH SOCKET	1200
6	⊕	5 AMP PLUG POINT	1200
7	⊕	5 AMP PLUG POINT	900
8	⊕	5 AMP PLUG POINT WITHOUT SWITCH	2250
9	⊕	5/15 AMP POWER POINT	300
10	⊕	5/15 AMP POWER POINT	1500
11	⊕	5/15 AMP POWER POINT	1200
12	⊕	CEILING FAN	ON CEILING
13	⊕	EXHAUST FAN	IN WIN/VE
14	⊕	CALL BELL	1200
15	⊕	BZZZAR	2400
16	⊕	TELEVISION POINT	900
17	⊕	DISTRIBUTION BOARD	1500 (TOP OF D.B.)
18	⊕	INDICATES CONTROLLING OF LIGHT/FAN FROM SWITCH BOARD	
19	⊕	SUBMAIN CONDUIT	

CLIENT :-
LUCKNOW DEVELOPMENT AUTHORITY

BUILDING :-
RESIDENCE

DRG. TITLE :-
ELECTRICAL DETAIL

NOTES :-
1. ALL DIMENSIONS ARE IN MM.
2. WRITTEN DIMENSION IS TO BE FOLLOWED, DRAWING NOT BE SCALED.
3. THIS DRG. IS THE PROPERTY OF M/S ARCH DOT CREATION ARCHITECTS & INTERIOR DESIGNERS. THIS DRAWING IS NOT TO BE REPRODUCED OR COPIED BEFORE THE PRIOR PERMISSION OF THE ARCHITECT.
4. ANY DISCREPANCY IN THE DRAWING IS TO BE BROUGHT TO THE NOTICE OF THE ARCHITECT BEFORE EXECUTION.

KEY PLAN :-

DATE :-
DEC.-2018

DRG. NO. :-

DEALT BY :-

NORTH :-

CHECKED BY :-

ARCHITECT :-
SHUBHENDRA BAJPAI

ARCHITECTURAL CONSULTANTS :-
ARCH DOT CREATION
(LUCKNOW OFFICE):
719/7TH FLOOR, CYBER HEIGHT VIBHUTI KHAND,
GOMTI NAGAR, LUCKNOW.
Ph. 2770562, 9415021936.
e mail add. adcreation1@yahoo.co.in
(GHAZIYABAD OFFICE):
2160 2161, RAMANO MAHAGUN, MASCOI,
CROSSING REPUBLIC GHAZIYABAD
Ph. : 0120 4217977, 09871599836
e mail add. adcreation2@yahoo.co.in