


ELECTRICAL LEGEND

SL.NO	SYMBOL	DESCRIPTION
1.		CEILING FAN
2.		WALL FAN
3.		TUBE LIGHT PONT
4.		CEILING LED POINT
5.		5A SWITCH WITH SOCKET
6.		15A SWITCH WITH SOCKET
7.		SWITCH BOARD
8.		SPLIT AC (1 TON)
9.		SPLIT AC (1.5 TON)
10.		SPLIT AC (2 TON)
11.		AC POINT
12.		EXHAUST FAN
13.		STREET LIGHT
14.		WALL LAMP
15.		GEYSER
16.		TELEPHONE POINT
17.		CCTV CAMERA
18.		CAMERA DVR
19.		DISTRIBUTION BOARD
20.		MAIN DISTRIBUTION BOARD
21.		METRE
22.		MINIATURE CIRCUIT BREAKER
23.		KWH METRE
24.		SUB-DISTRIBUTION BOARD
25.		TRANSFORMER (450 KW)

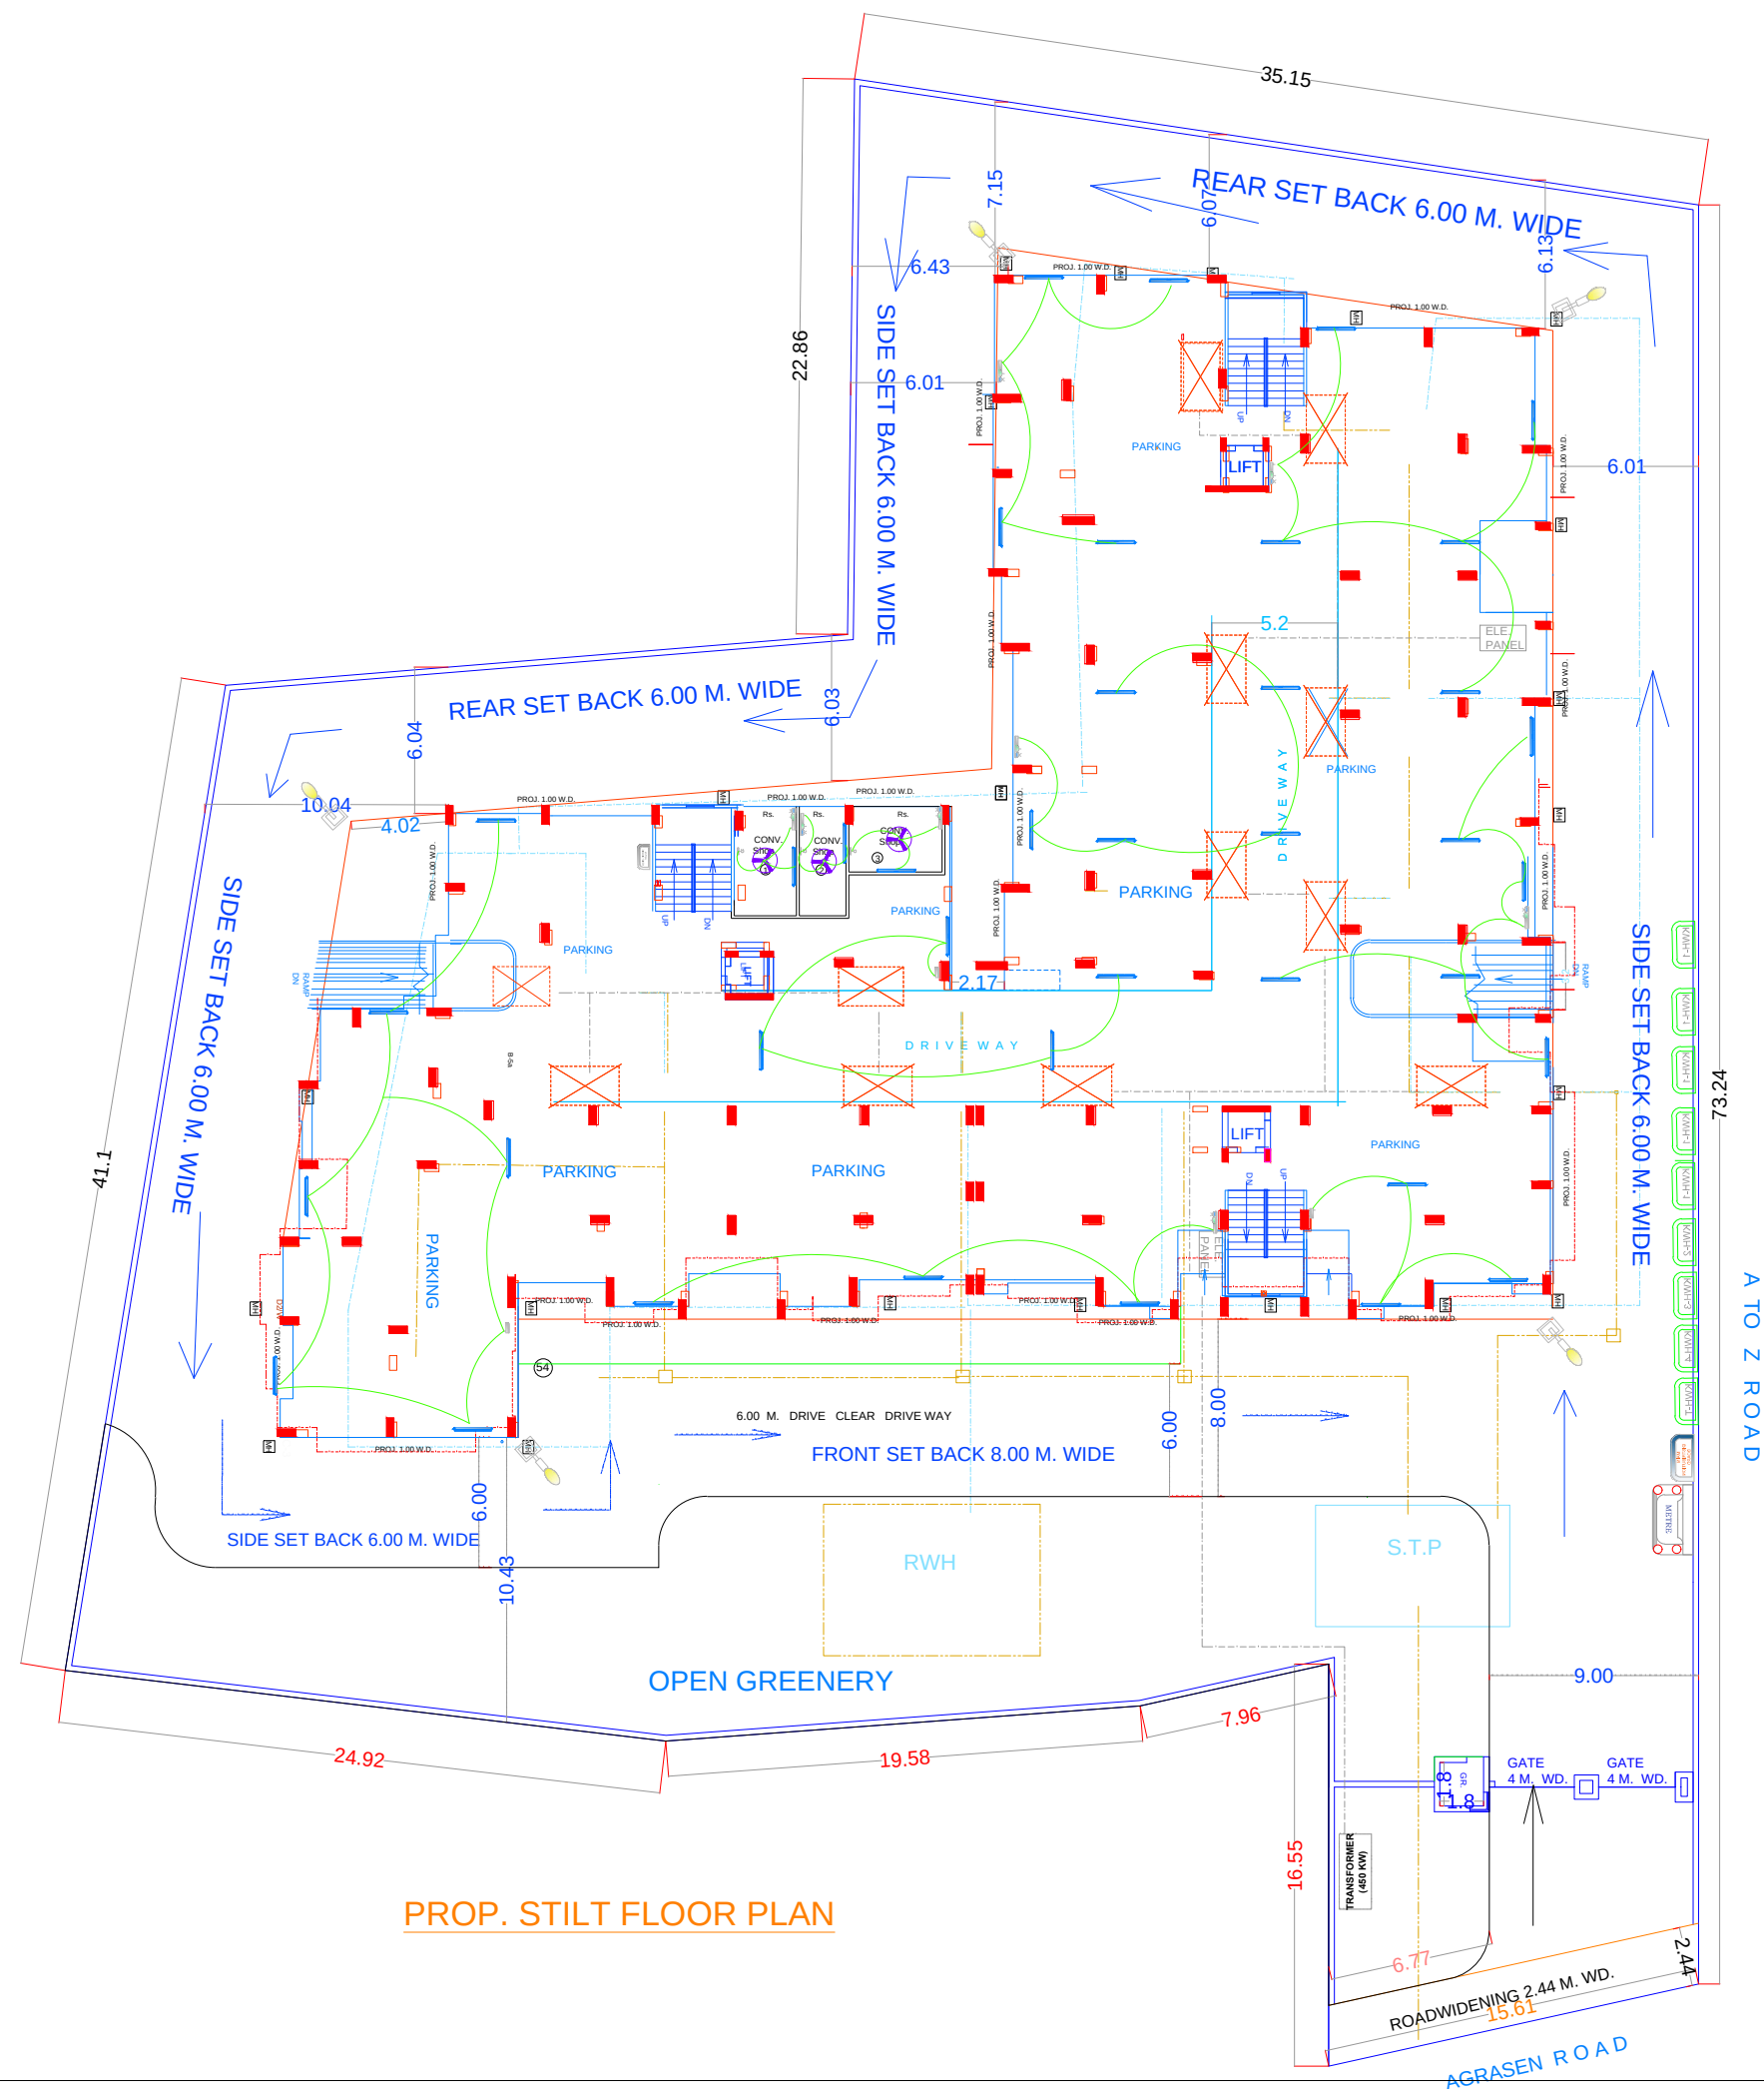

PROP. STILT FLOOR PLAN

THIS DRAWING IS THE PROPERTY AND COPY RIGHT OF BUILDWELL CONSULTING ENGINEERS AND THE SAME SHALL NOT BE COPIED OR USED IN ANY WAY WITHOUT THEIR WRITTEN PERMISSION.

PROJECT:

EXIST. (UNDER CONS.) & PROP. RESIDENTIAL BUILDING PLAN FOR
GREEN HEIGHT
M/s. D. S. BUILDERS & DEVELOPER'S
AT- LAXMAN VIHAR MUZAFFAR NAGAR
Partner Mr. DEVENDRA KUMAR S/o Mr. ATAR SINGH
VILL.- JARODA, MUZAFFAR NAGAR.
SITE. At- KHASRA NO - 194 M, MAHA RAJA AGGARSAN MARG ,
VILL. SAHAWLI MUZAFFAR NAGAR

DESCRIPTION

ARCHITECT:



BUILDWELL
CONSULTING ENGINEERS
Regd. Office: A-49, Abul Fazal Enclave-II, Near
Jamia, Okhla, New Delhi-110025
E-mail : info@bwce.in
Phone. : +91-11-29943124

DRAWING TITLE:

**ELECTRICAL FIXTURE OF STILT
FLOOR PLAN**

DEALT BY

MOHD SUHAIL

DATE

24-09-2021

SCALE

NTS

DESIGNED BY

ER.NOOR MOHD

DRAWING NO.

F FT-003

REVISION

0