


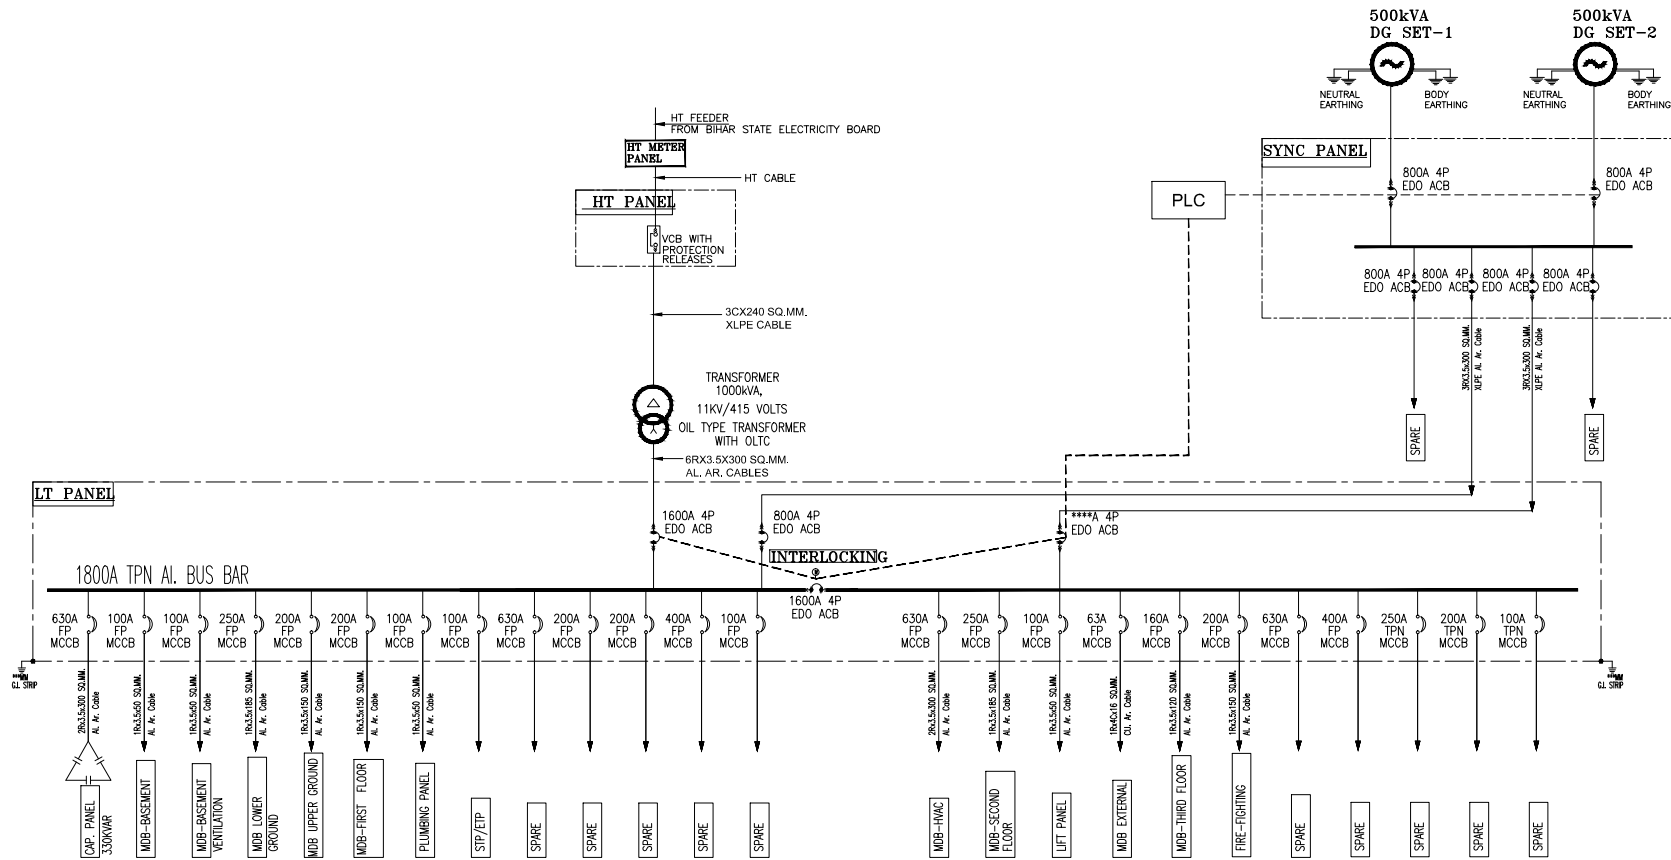

NOTE:- ALL DIMENSION ARE IN MM

OWNER:-
M/S SAI FORTUNE DEVELOPERS PRIVATE LIMITED AT
J-3/196, DDA FLATS, KALKAJI, DELHI-110010.

ARCHITECT'S SIGNATURE :-

OWNER'S SIGNATURE :-

PROJECT :-
PROPOSED THE COMMERCIAL/MULTIPLEX/RESIDENTIAL
HOUSING AT SARAI KUDIYA, STATION ROAD,
BULANDSHAHR, U.P-203001

PROJECT CONSULTANTS :-
HOLISTICS URBAN INNOVATIONS PVT. LTD.
PLANNING & ARCHITECTURE RPI & RPI ACTIVITIES
DESIGN & ENERGY SERVICES BUILDING TECH. SERVICES,
THE COORDINATOR, TOWER-4A-1, SEC-6, GATE NO. 201, 98T
PH. - 0120-4507777 FAX- 0120-4507789



ELECTRICAL CONSULTANTS :-

NATURE OF DRAWING:-
SINGLE LINE DIAGRAM

DRG. NO. EL-02 DATE NORTH ->

SCALE N.T.S.

CONCEPTUAL SLD

DRG. TITLE SLD

REVISIONS
A 0 0 0 2