

NOTES

- DIAMETER OF PIPE MENTIONED IN THE DRAWING IS NOMINAL BORE ONLY
- ALL WORKS SHALL BE CARRIED OUT AS PER RELEVANT I.S. CODES
- PRESSURE RELEASE VALVE SHALL BE PROVIDED AT EVERY 4TH FLOOR
- IN CASE OF ANY CONFUSION, THE MATTER BE REPORTED TO THE CONSULTANT BEFORE EXECUTION

Booster pump is required for the 13th floor

SR.No REVISION No. DATE REMARK

CLINT

U.P. AWAS EVAM VIKAS PARISHAD


PROJECT

EVEREST ENCLAVE SEC-13, GROUP HOUSING AT VINDAVAN SCHEME, LUCKNOW

DATE

DETAIL OF PLUMBING

DOMESTIC WATER TANK

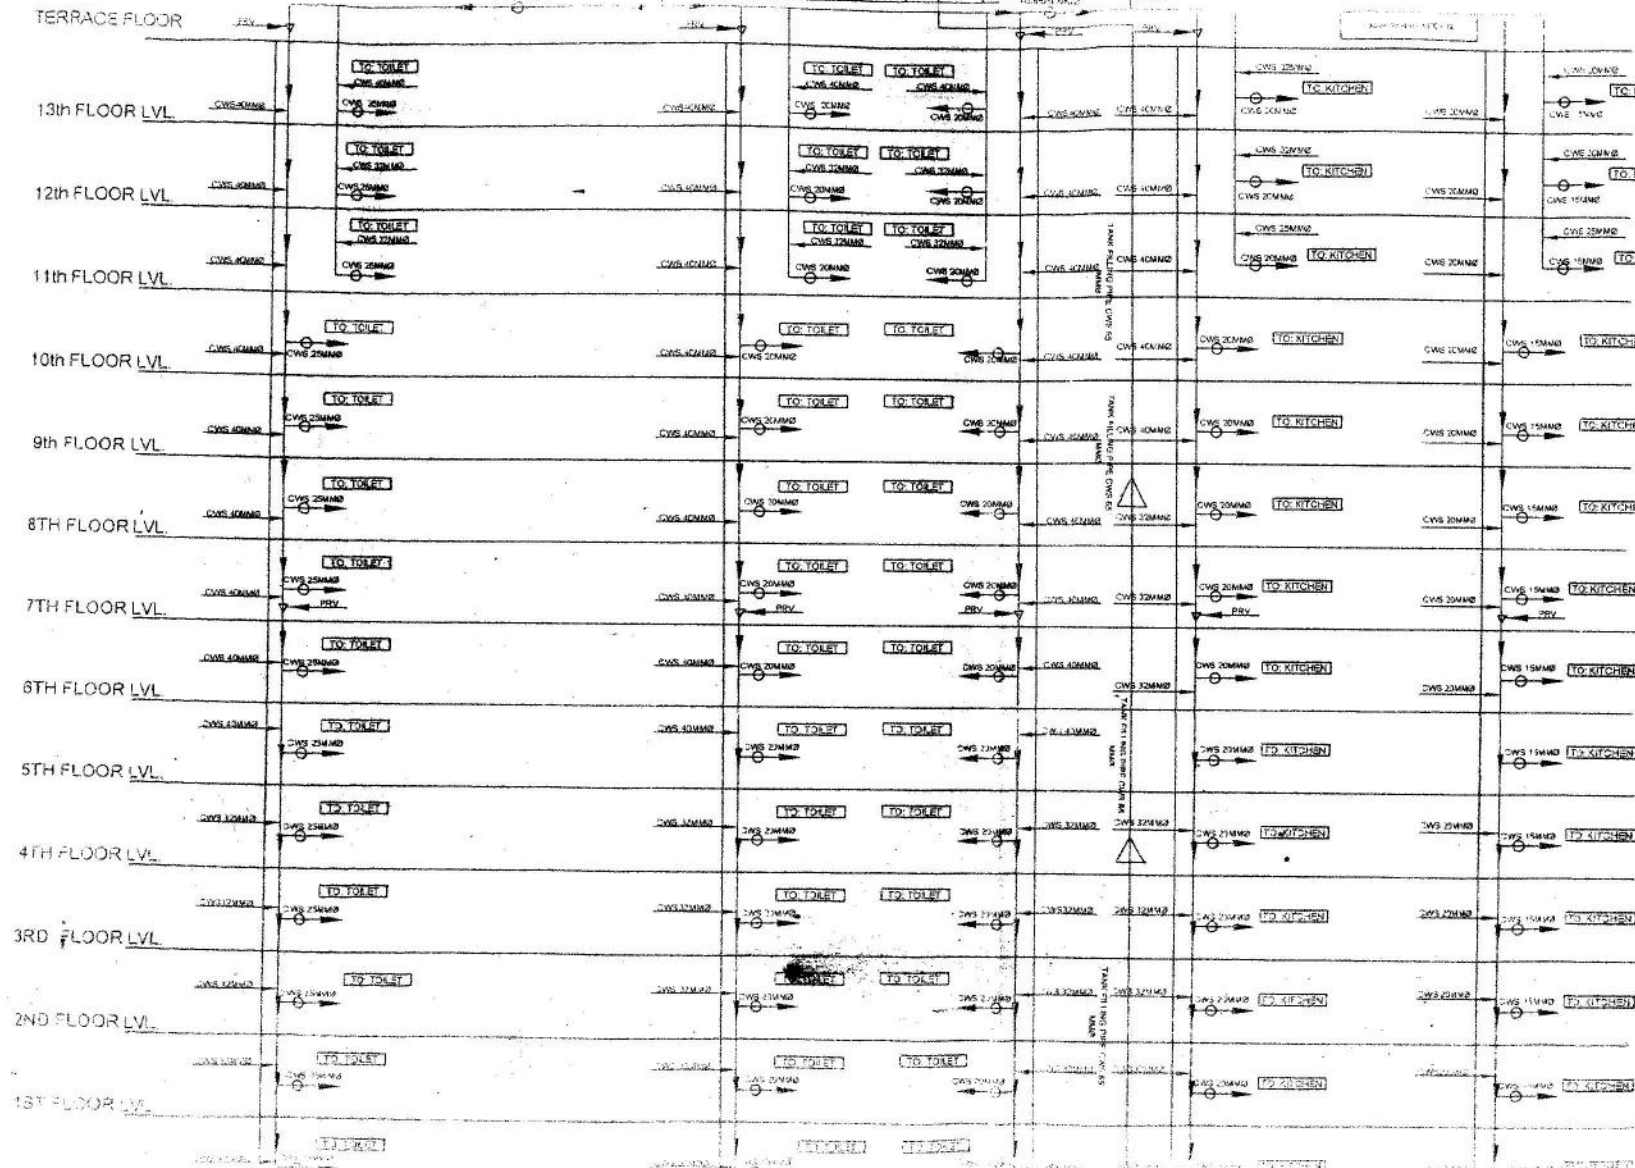

NOTES

1. DIAMETER OF PIPE MENTIONED IN THE DRAWING IS NOMINAL BORE ONLY.
2. ALL WORKS SHALL BE CARRIED OUT AS PER RELEVANT I.S. CODE.
3. PRESSURE RELEASE VALVE SHALL BE PROVIDED AT EVERY 7TH FLOOR.
4. IN CASE OF ANY CONFUSION, THE MATTER BE REPORTED TO THE CONSULTANT BEFORE EXECUTION.
5. *Booster pump is required for the top floors.*

SR No	REVISION No
CLINT:	REMARKS:
U.P. AWAS EVAM VIKAS PARISHAD	
PROJECT	
EVEREST ENCLAVE SEC-18, GROUP HOUSING AT VRINDAVAN SCHEME, LUCKNOW	
DRG TITLE	
DETAIL OF PLUMBING	
DRAWN BY	DATE
CHECKED BY	SCALE

PLUMBING PLAN FOR AS BLOCK (B1 - B2)