

PROPOSED GROUP HOUSING ON NAZUL PLOT NO.26-C(PART) CIVIL STATION, PRESENTLY NUMBERED AS 26-C/1, 26-C/3 & 26-C/4, NASIBPUR BAKHTIARA (MAUZA) CHIKATPUR, PARGANA & TAHSIL SADAR, DISTRICT ALLAHABAD.

GM CONSULTANTS & ENGINEERS
ELECTRICAL CONSULTANTS
LD-29, PITAMPURA, NEW DELHI-110088
TEL. : 27313622, 27318502
E-Mail: contact@gmncorp.com

SYM.	DESCRIPTION	LIGHT & FAN FIXTURES
480°	480° CEILING FAN	480° 1200MM SWEEP HAVELLS MAKE
14W	14W LED TUBE LIGHT	14W LUMING-HAVELLS MAKE MODEL NO.4-HESGPRV10015
50W	50W CHANDLER	AS PER SELECTION
15 W	15 W LED LIGHT SURFACE TYPE	AS PER SELECTION
10 W	10 W SURFACE LED	10W LUMING-HAVELLS MAKE MODEL NO.4-HESGPRV10015
15 W	15 W SURFACE LED	15W PLUTO PANEL-HAVELLS MAKE MODEL NO.4-HESGPRV10015
9W	9W LED MIRROR LIGHT	9W LUMING-HAVELLS MAKE MODEL NO.4-HESGPRV10015
EXHAUST	EXHAUST FAN	VENTIL_AIRBOX_HAVELLS MAKE
15W	15W BRACKET LIGHT	AS PER SELECTION
10W	10W BULK HEAD	AS PER SELECTION
WALL	WALL FAN	AS PER SELECTION

LEGEND-ELEC	LVL. IN MM (BOTTOM OF PLATE)
DISTRIBUTION BOARD	+1200
ROCKET-OUTLET 6A WITH SWITCH	+1200 General Points +1200-Road Side (In Parity/Kitchen)
ROCKET-OUTLET 16A WITH SWITCH	+1200 General Points +1200-Road Side (In Parity/Kitchen)
ROCKET-OUTLET 20A WITH SWITCH FOR GEYSER	+1800
ROCKET-OUTLET 25A WITH SWITCH FOR AC	+300
6A SWITCH BOARD	+1000
DATA POINT	+300
TV POINT	+1200
TELEPHONE POINT	+300
TELEPHONE TAG BLOCK	+2200
BELL	+2200
BELL PUSH	+1200

NOTE: THIS PROPOSAL CONFIRMS WITH THE STANDARDS OF "UPVIDHI 2008" and "MAHAYOJANA 2021"


Drawing Title
SUBMISSION DRAWING
ELECTRICAL PLAN

OWNERS:
MR. A.Q. KHAN
MR. SALEEM IQBAL SHERVANI
M/S SHERVANI INDUSTRIAL SYNDICATE LIMITED

Drg. No. 01/04
SITE PLAN

Scale 1 : 200


Date 06 FEB' 2020

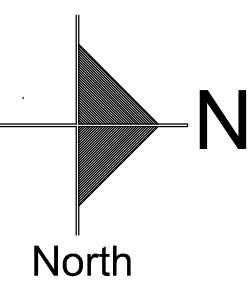


ARCHITECT SIGN.

Architect
MANISH GUJRAL
(B. Arch, F.I.V.)
TARANA NASEER
(B.Arch, M.Plan)
Architects and Interior Designers


52/ 25 B MUIR ROAD, ALLAHABAD

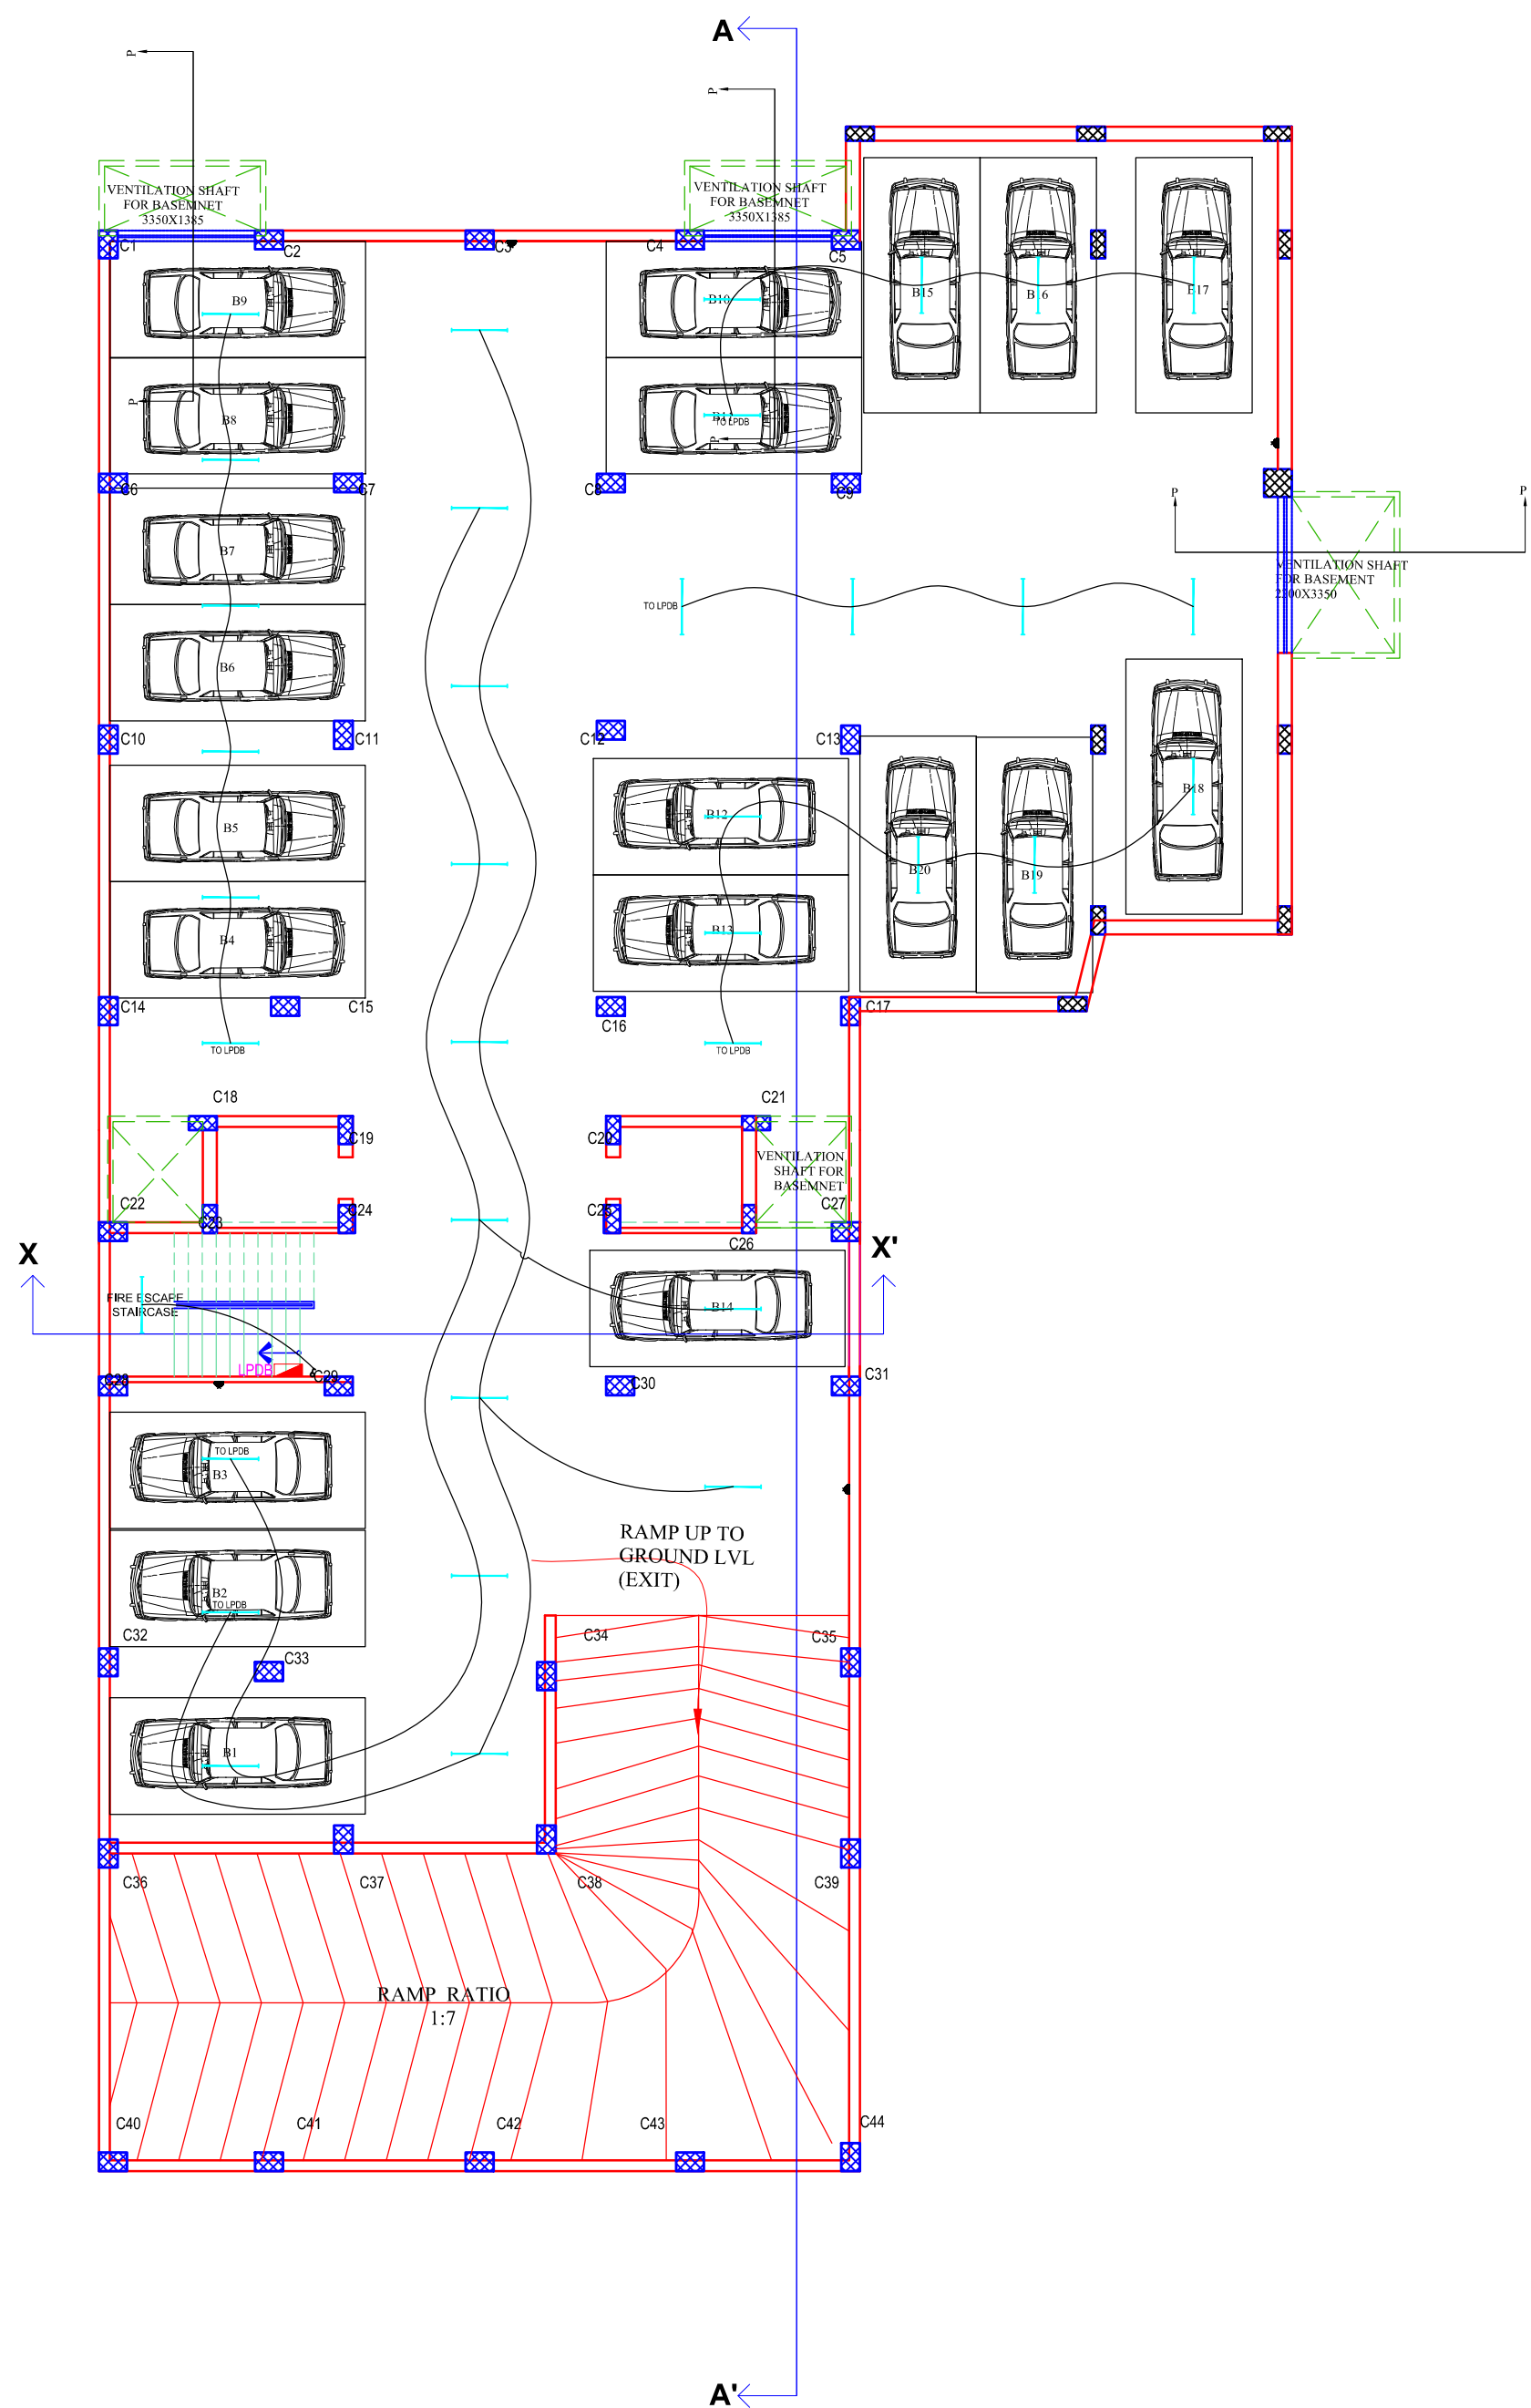

BASEMENT PLAN

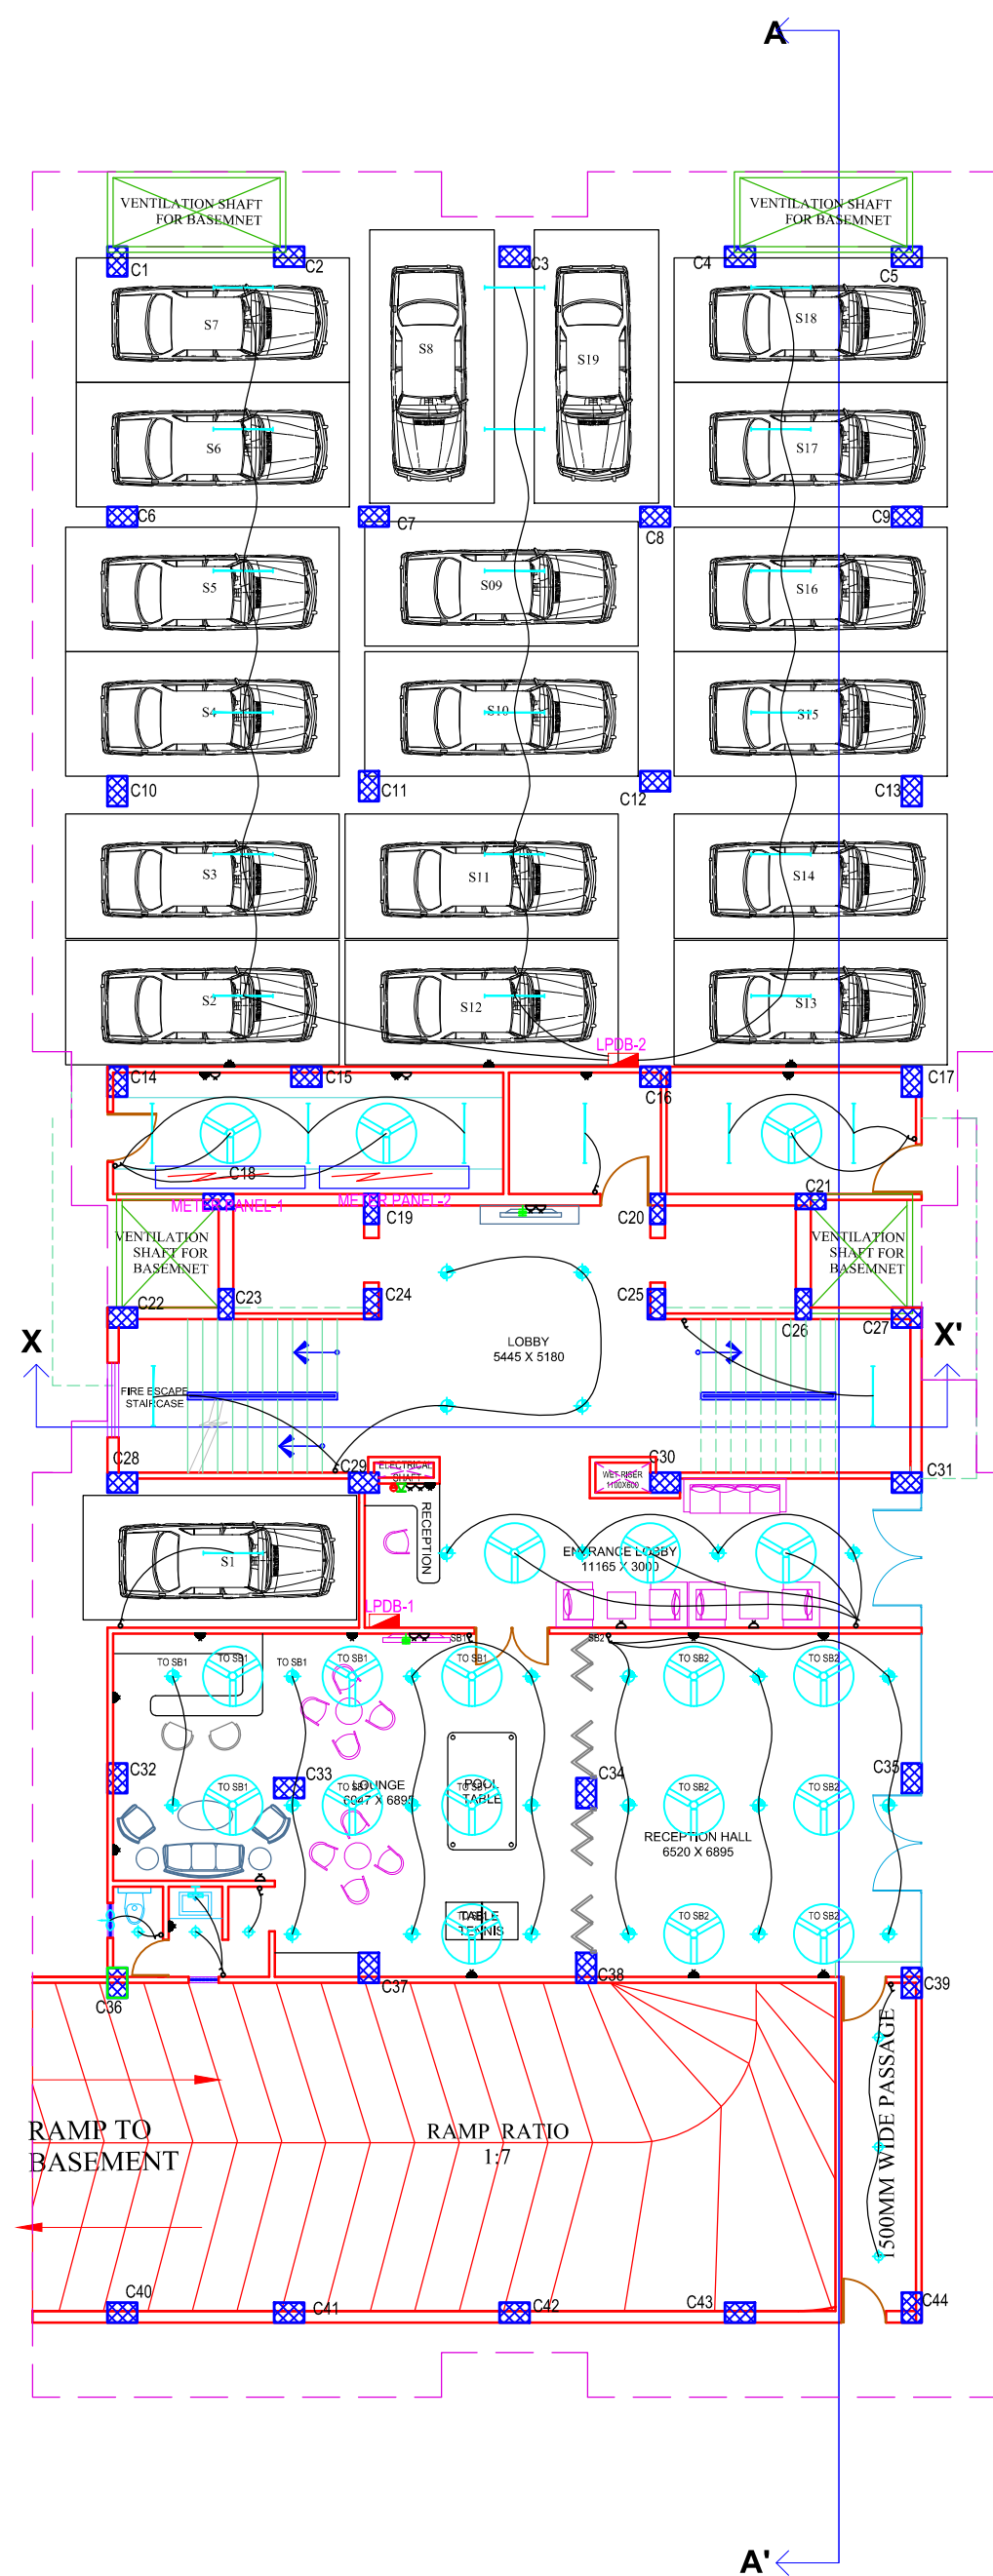

STILT PLAN

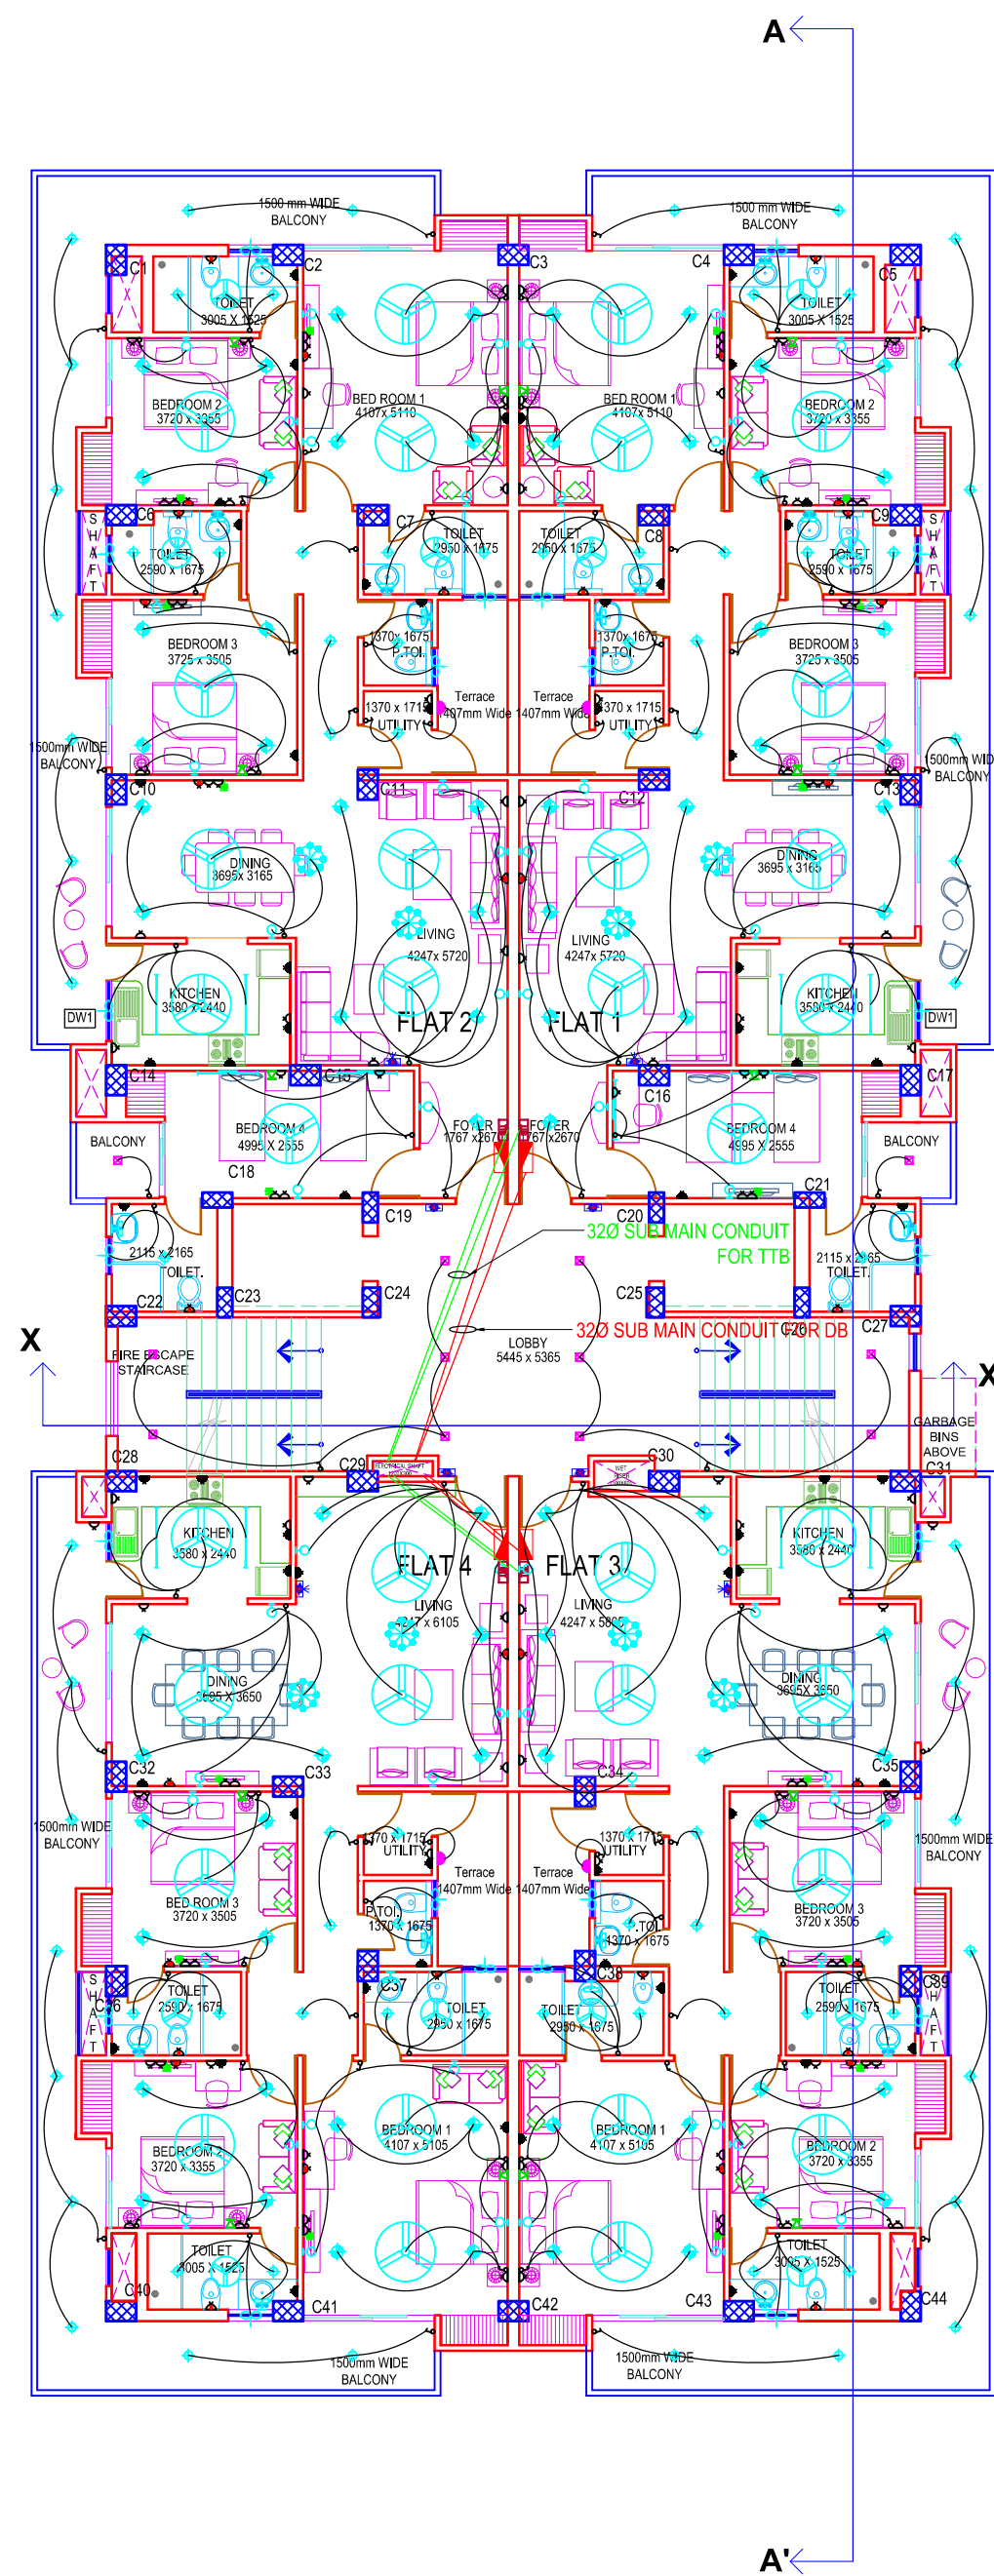

FIRST FLOOR PLAN