
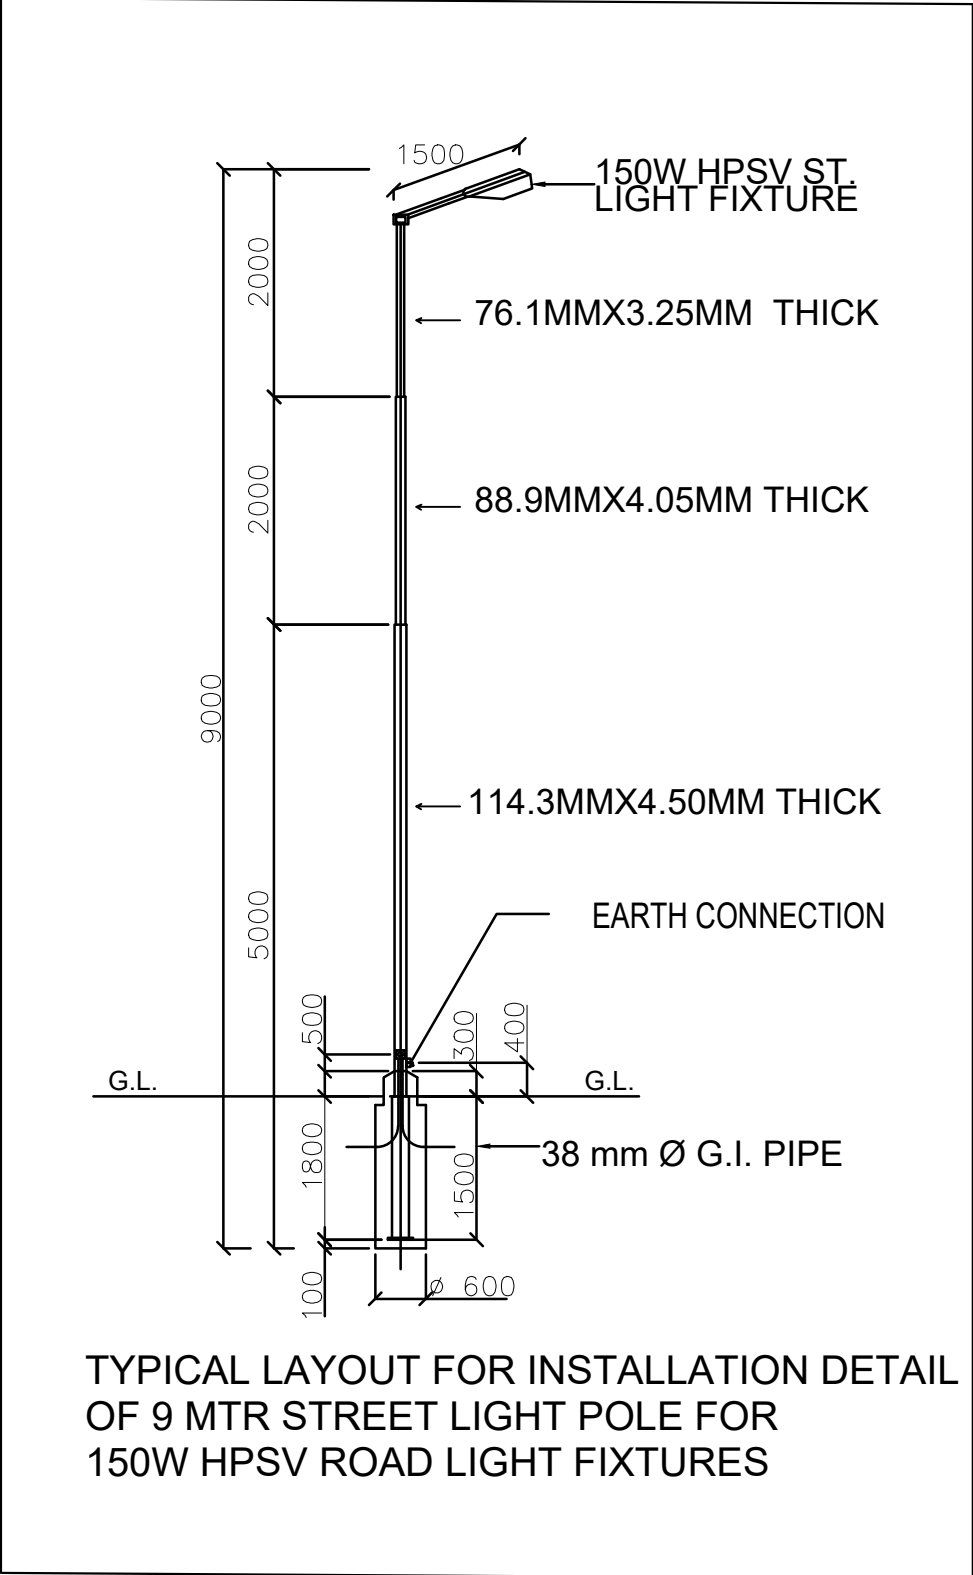
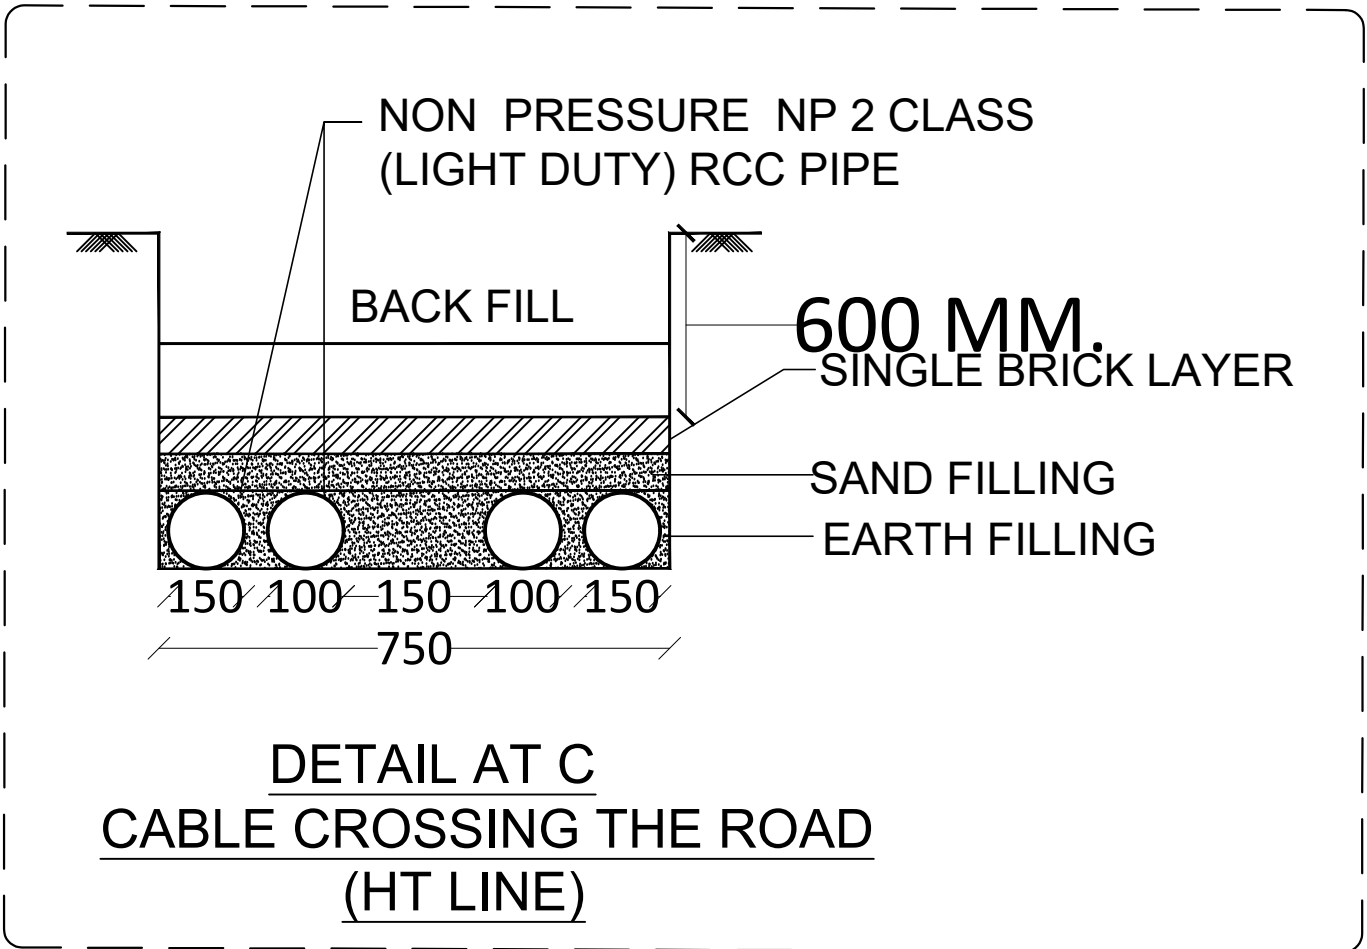
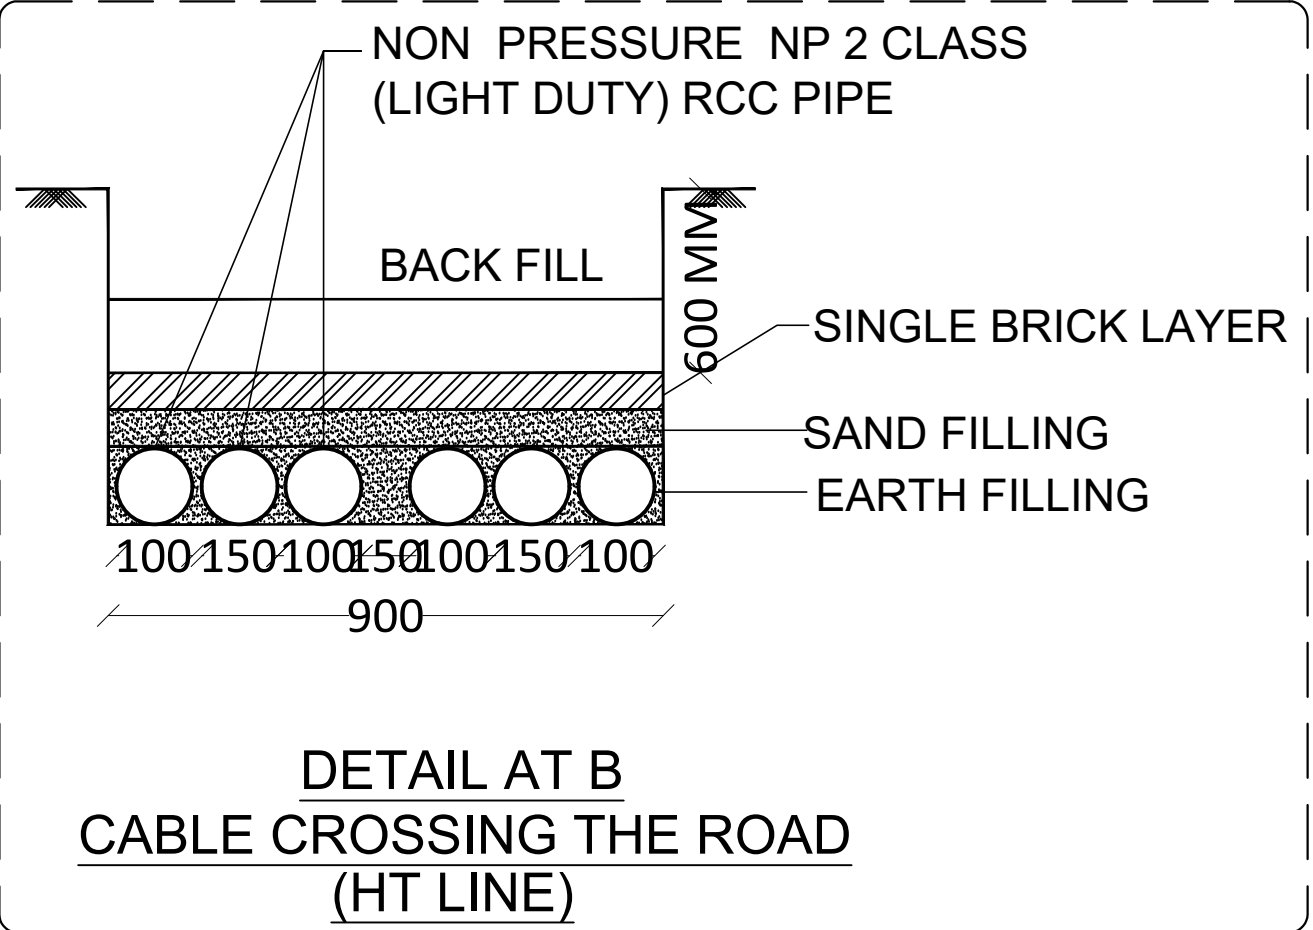
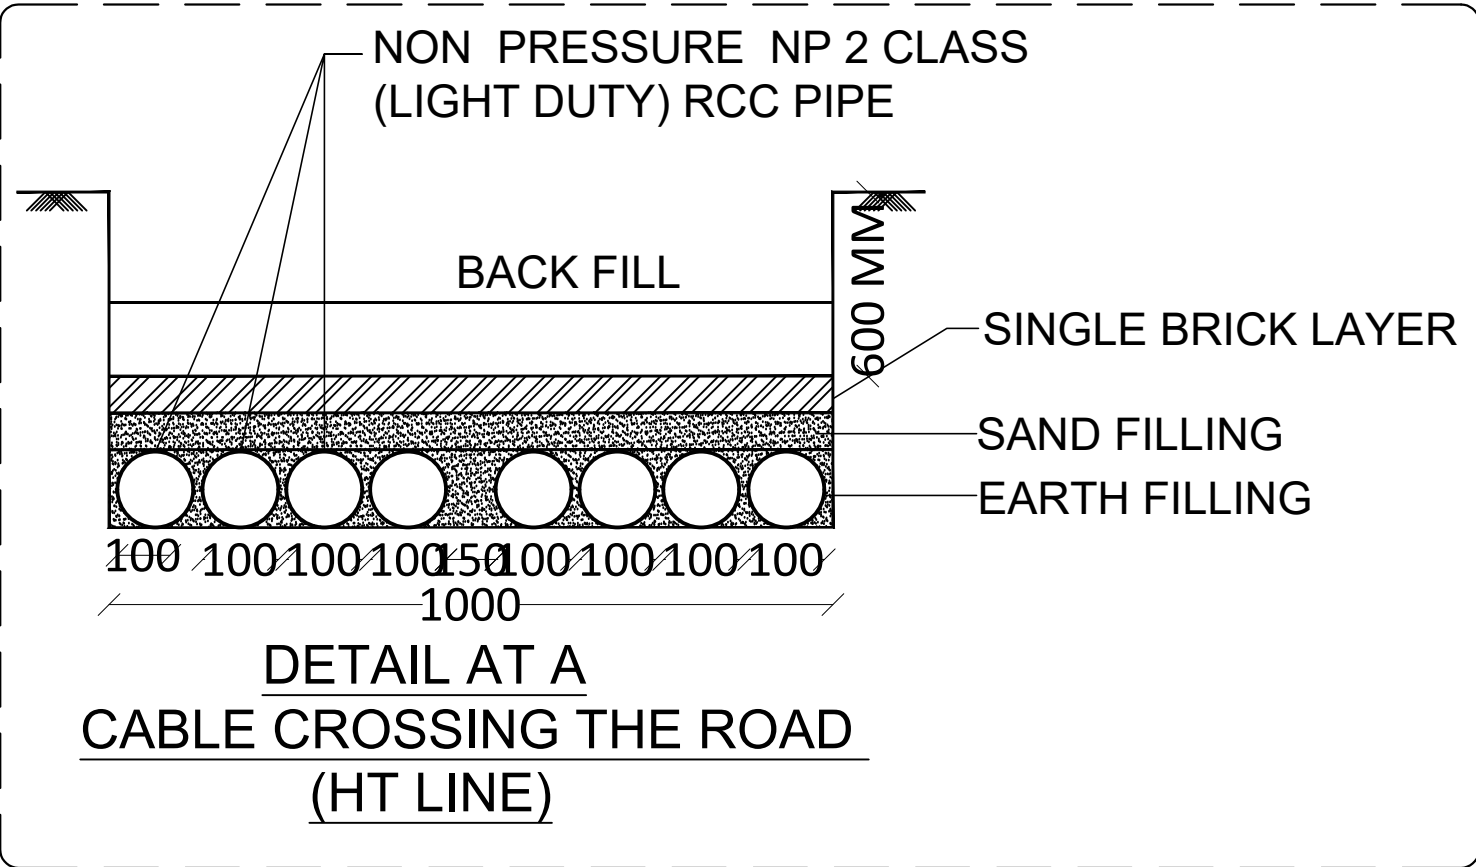


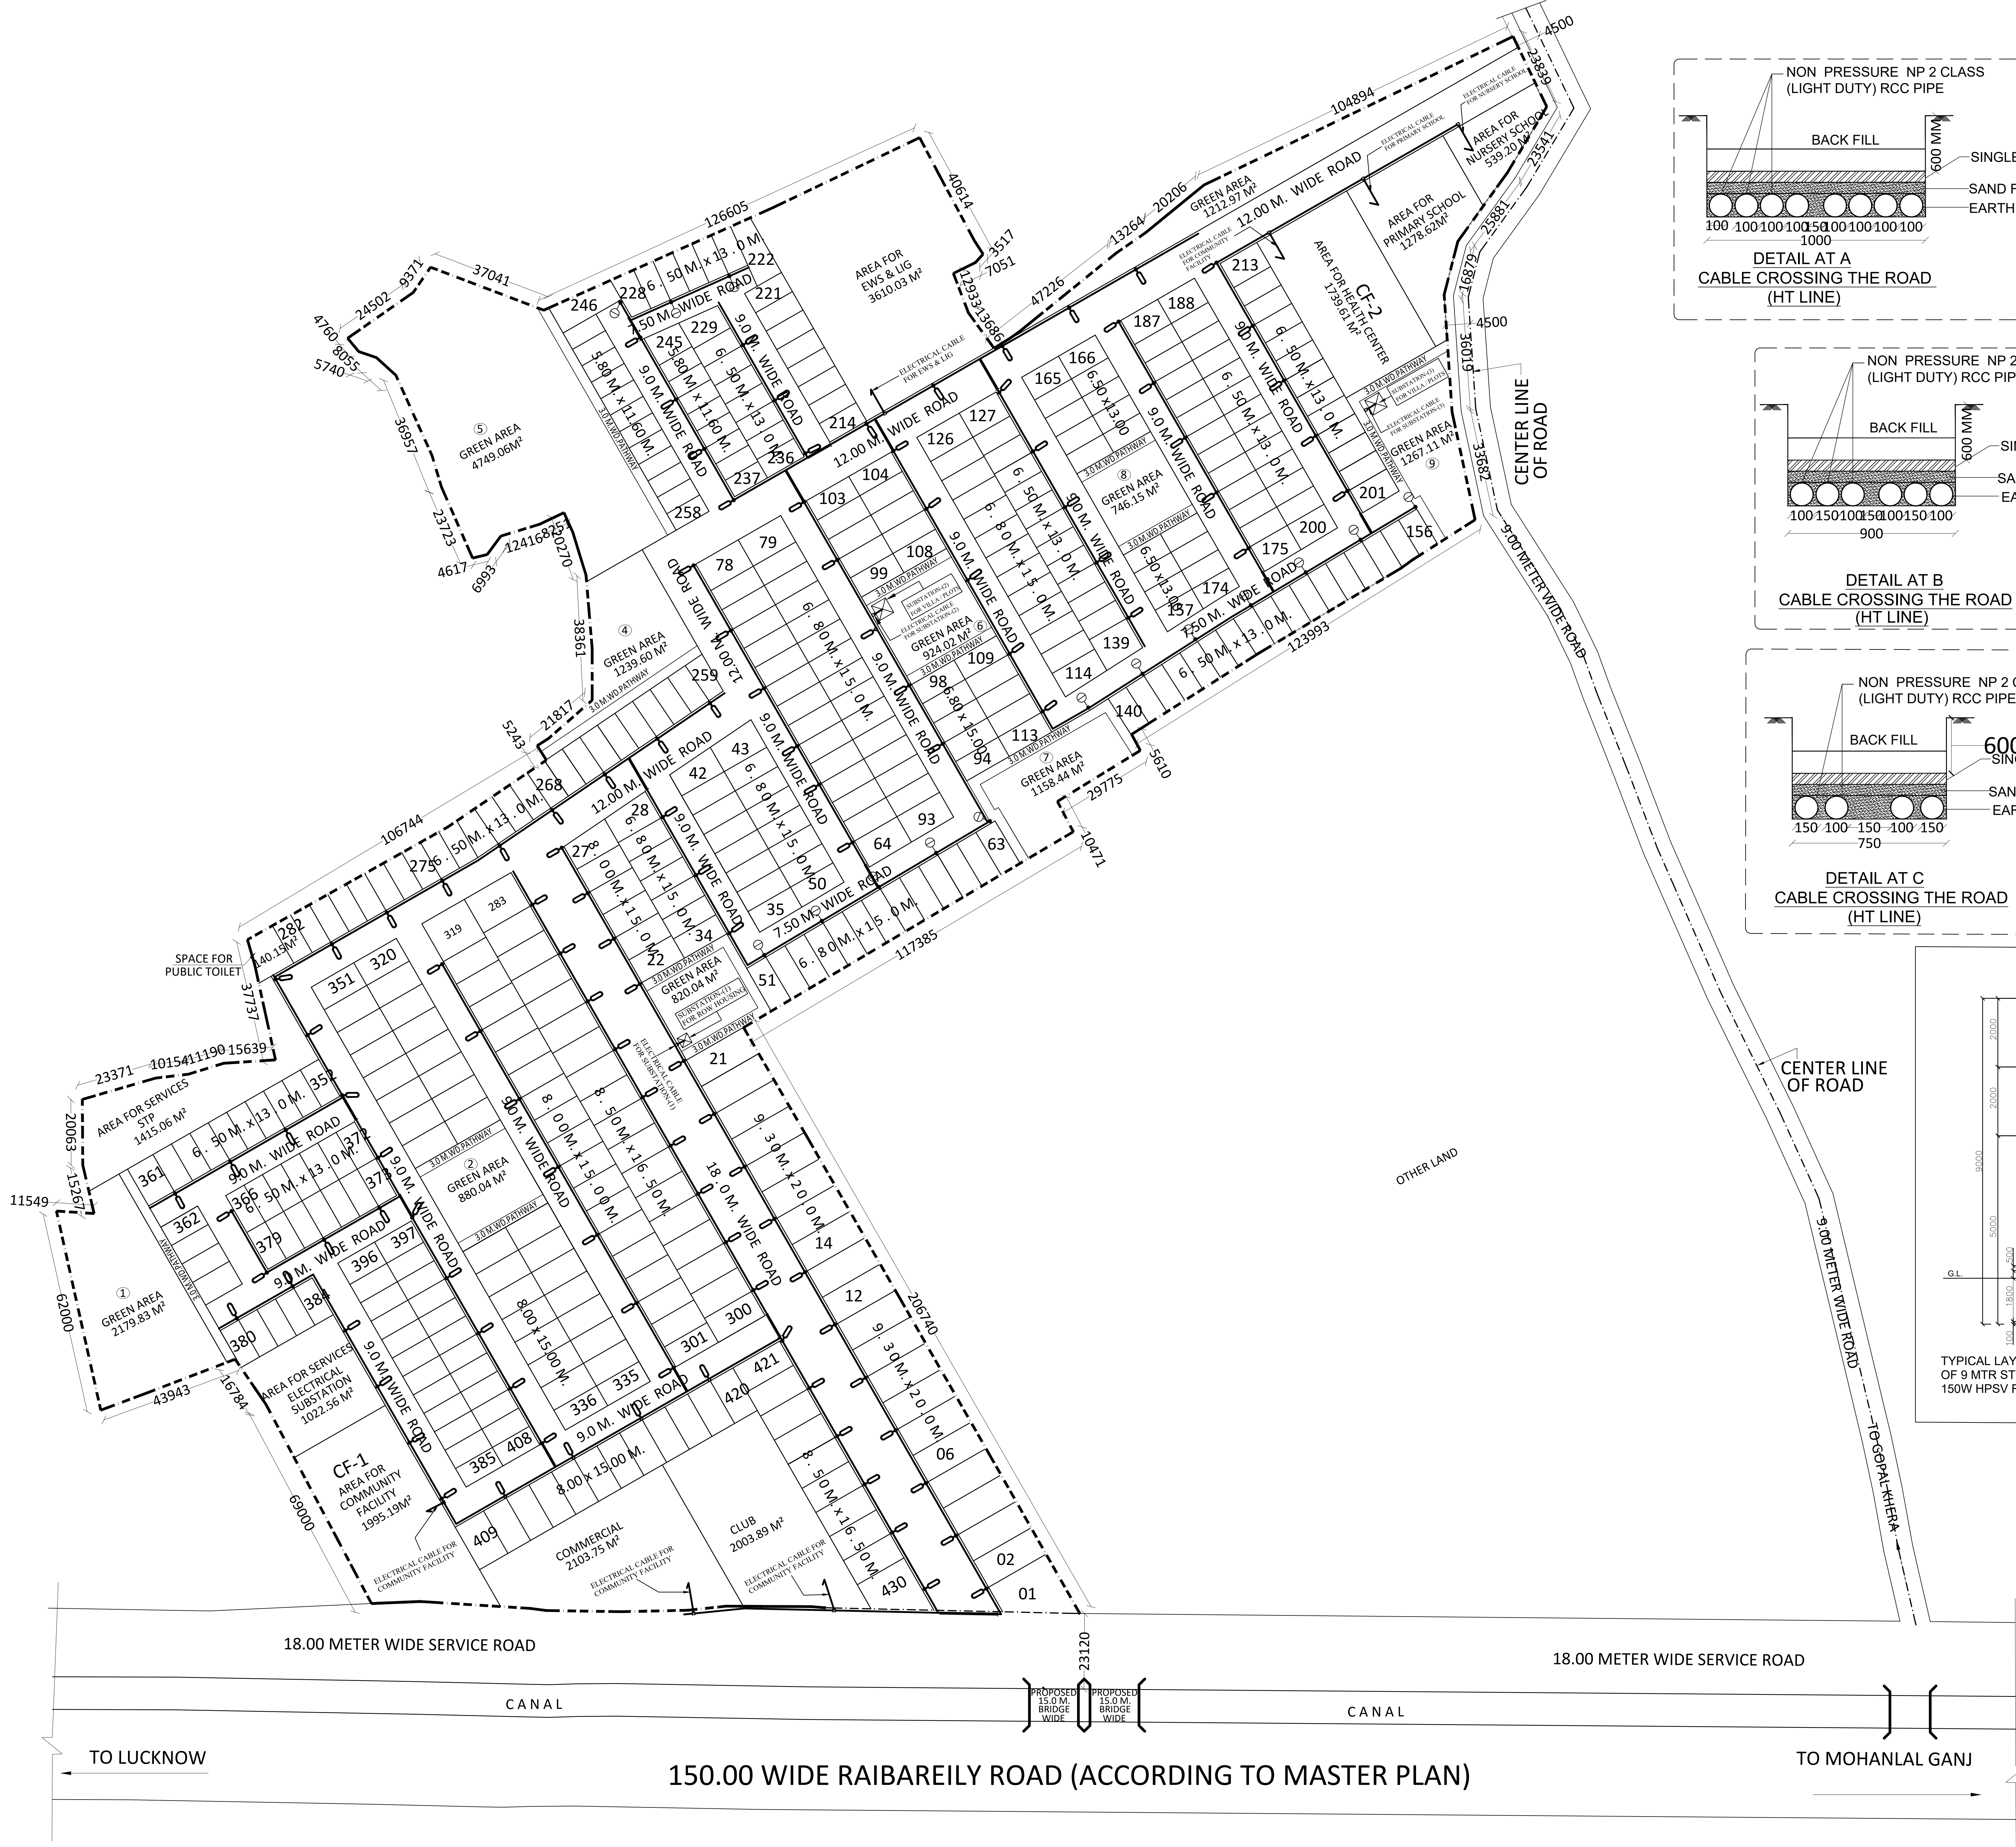

PROJECT:
PROPOSED INTEGRATED TOWN SHIP
FOR
M/S OMEGA INFRABUILD PVT. LTD.
AT
GOPAL KHERA, PURSENI, TEHSIL-
MOHAN LAL GANJ, RAIBAREILY ROAD,
LUCKNOW

CLIENT :-

LEGEND:- ELECTRICAL SYSTEM

SL.	SYMBOL	DESCRIPTION
1.		ELECTRICAL SUBSTATION
2.		UNDER GROUND AR. AL. CABLE
3.		9.0 METER HIGH GALVANIZED OCTAGONAL POLE SUITABLE FOR 1NOS.-1x150 W HPSV LAMP
4.		7.0 METER HIGH GALVANIZED OCTAGONAL POLE SUITABLE FOR 1NOS.-1x150 W HPSV LAMP
5.		RCC Hume Pipe

ELECTRICAL LAYOUT PLAN

SCALE: 1:1000	DRG. NO.: 2/5	
DRN BY: BHUWAN	NORTH 	CHECKED BY:
DATE: JUNE - 2019		M. PANT

OWNER SIGNATURE

ARCHITECT SIGNATURE

ALL THE INFORMATION REGARDING THE LAND & ITS SURROUNDING IS PROVIDED BY THE OWNER.
ARCHITECT SHALL NOT BE RESPONSIBLE FOR ANY KIND OF DISCREPANCY REGARDING LAND INFORMATION.

ARCHITECT

PUNIT SRIVASTAV
VASTULIPI
ARCHITECTS & INTERIOR DESIGNERS
VASTU SHAstra CONSULTANTS
5/171, VIRAM KHAND, GOMTI NAGAR, LUCKNOW
PH. NO. - 9415418151, 9935590999
email - vastulipi@gmail.com
website - www.vastulipi.com

SHAH & PANT
CONSULTING ENGINEERS (P) LTD.
AN ISO 9001:2008 COMPANY

Building services Consultant, Soil & foundation Experts, Highway Engineering
1, 4th Floor, HALWASIYA COURT, HAZRATGANJ, LUCKNOW (U.P.)
Tele. No. : 0522-2230625, Fax : 0522-2230625, Cell : 9839013280, 9415027719
Email : shah_pant@yahoo.co.in, Web : www.shahpantconsultingengineers.com