


PROJECT:  
  
PROPOSED RAJVANSH RESIDENCY GROUP  
HOUSING FOR RAJVANSH ESTATES PVT.  
LTD. AT KHASRA NO. - 1578, GRAM-  
AURANGABAD KHALSA WARD - RAJA  
BIJALI PASI, LUCKNOW

LEGEND:- (electrical)		
S.NO.	SYMBOL	DESCRIPTION
1		1x40W FLUORESCENT TUBE LIGHT FIXTURE (CEILING)
2		2x11W CFL TYPE CEILING LIGHT (SURFACE)
3		LIGHT POINT
4		BRACKET LIGHT
5		5/15 AMP POWER POINT
6		DISTRIBUTION BOARD
7		SWITCH BOARD
8		INDICATES CONTROLLING OF LIGHT/FAN FROM SWITCH BOARD
9		L.D.B. LIGHTING DISTRIBUTION BOARD
10		SUBMAIN CONDUIT FROM L.T. PANEL TO L.D.B./D.B.
11		SUBMAIN CONDUIT FROM L.T. PANEL TO P.D.B.
12		
13		

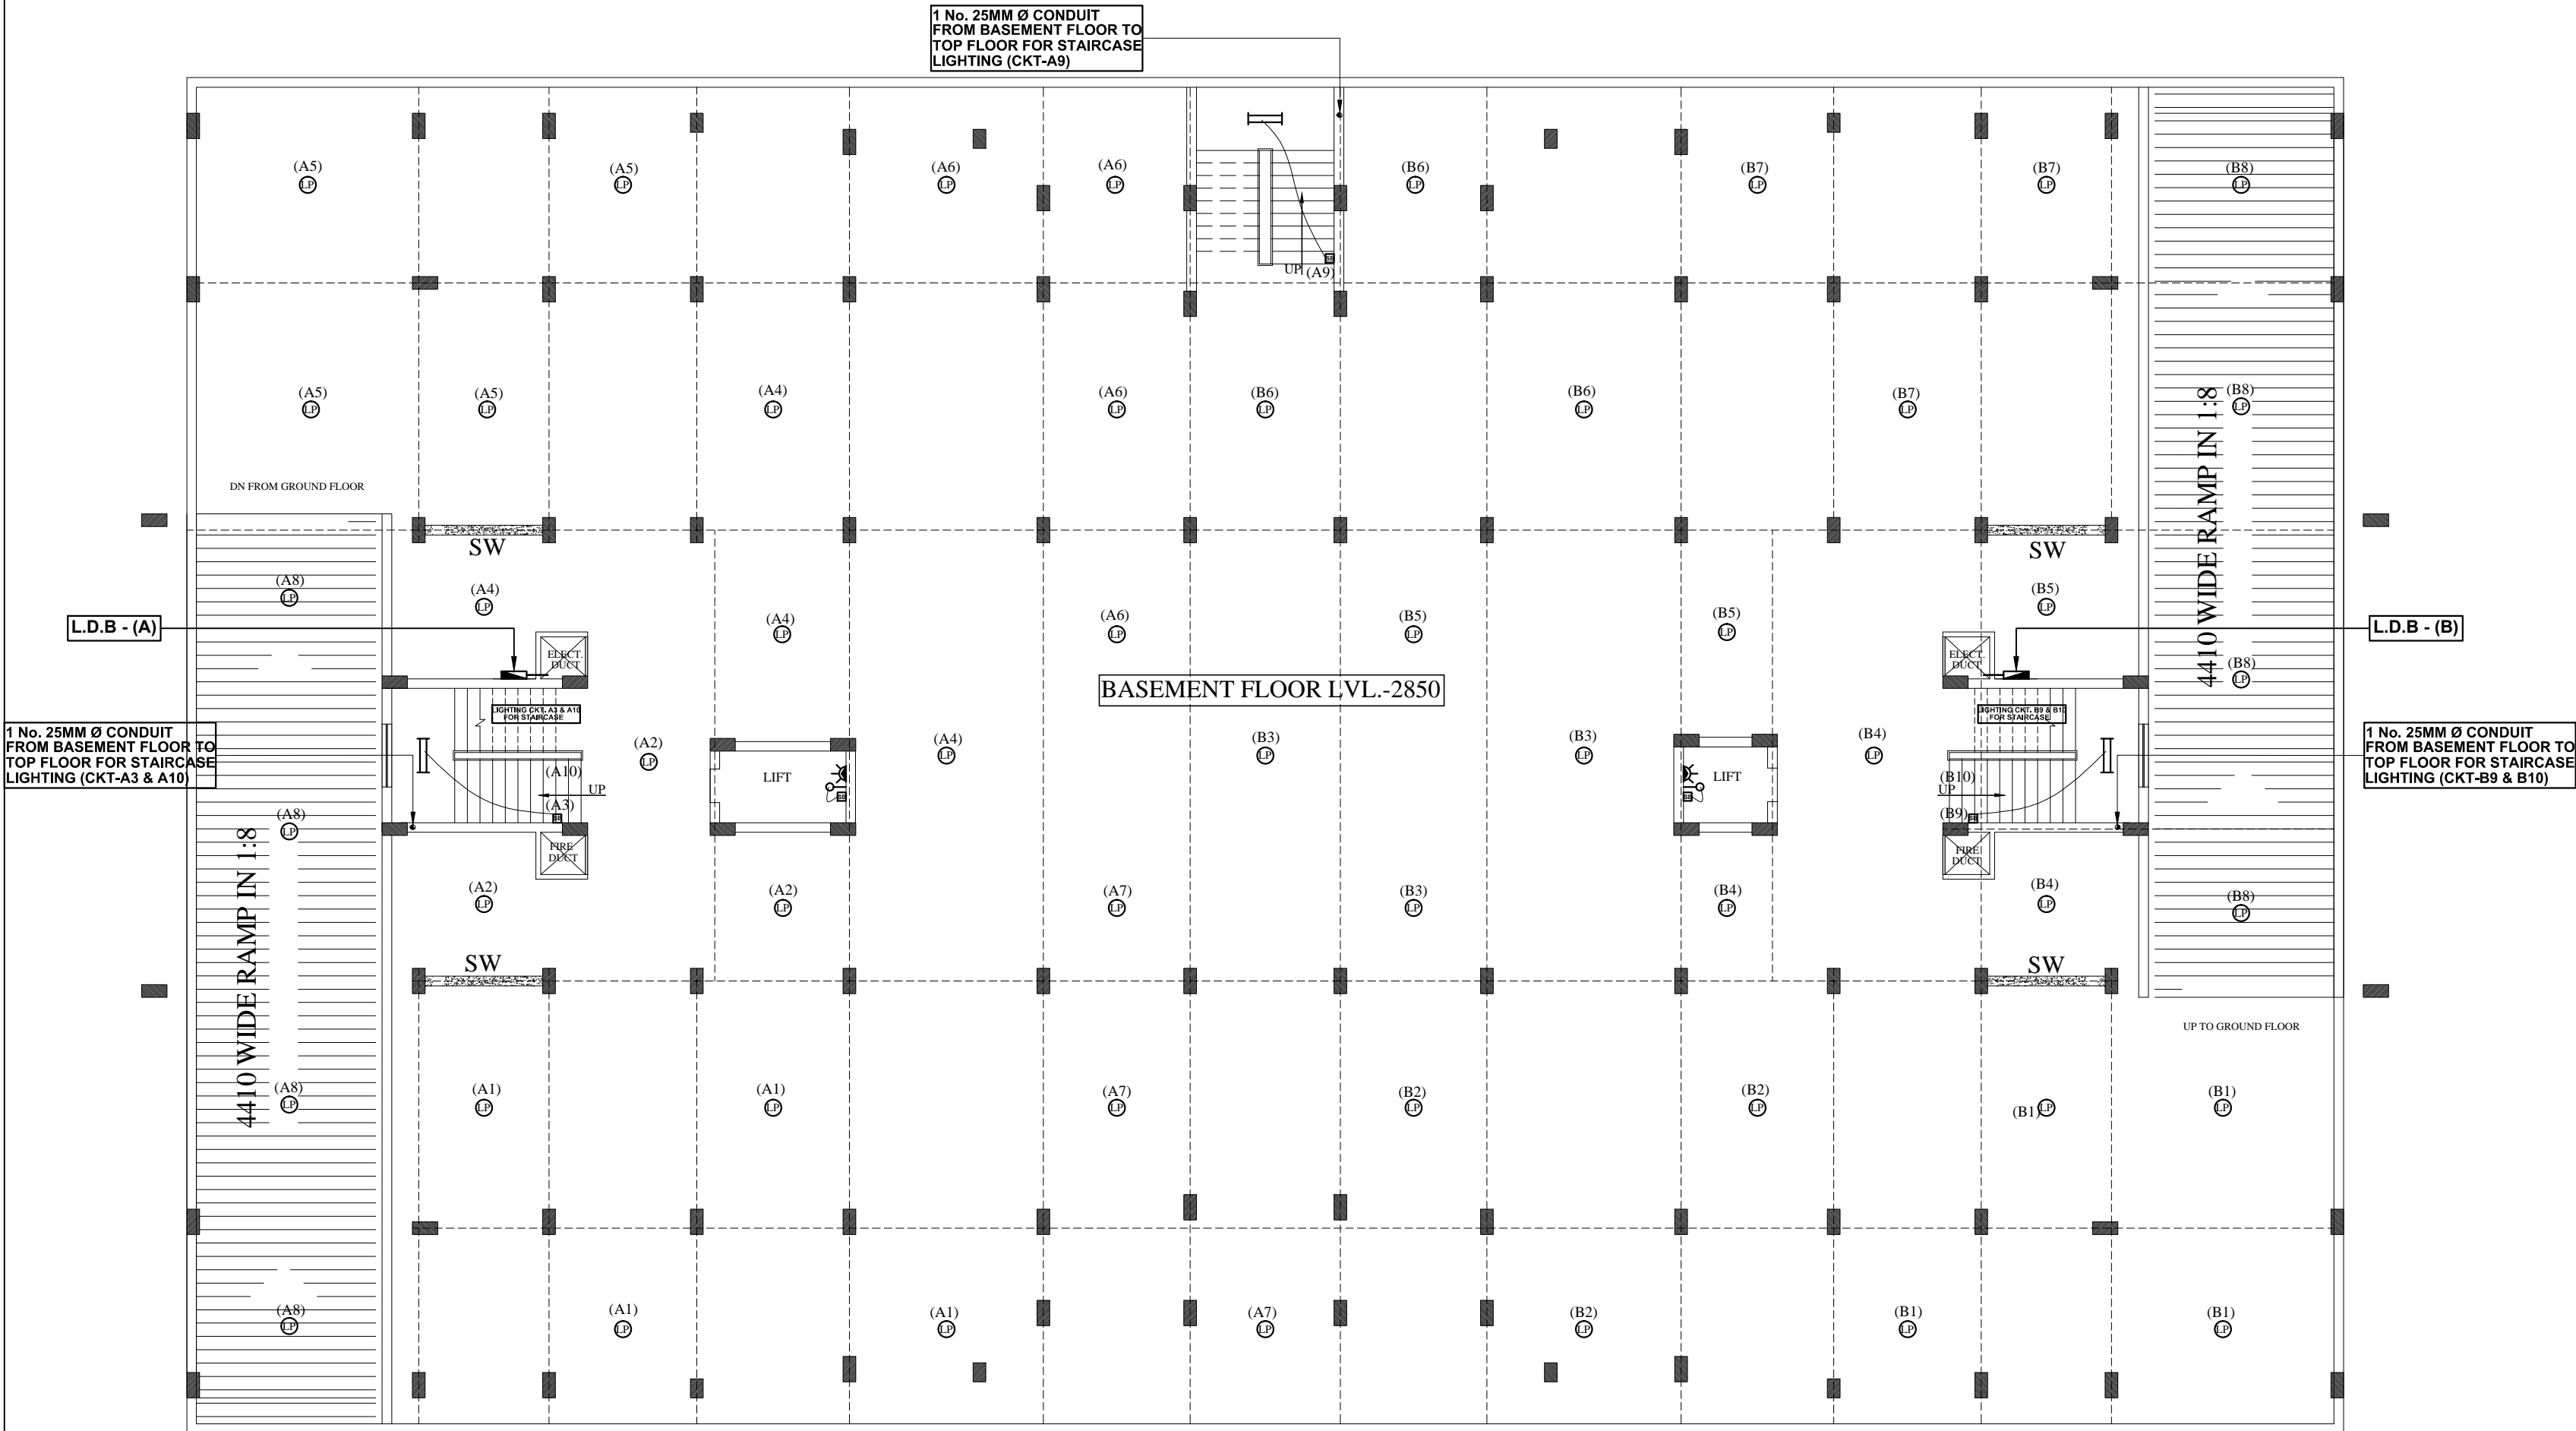

BASEMENT FLOOR PLAN

BLOCK-A  
BASEMENT FLOOR PLAN

PROPOSED RAJVANSH RESIDENCY GROUP  
HOUSING FOR RAJVANSH ESTATES PVT.  
LTD. AT KHASRA NO. - 1578, GRAM-  
AURANGABAD KHALSA WARD - RAJA  
BIJALI PASI, LUCKNOW

SUB. TITLE:  
  
BLOCK-A

DRG. TITLE:  
  
BASEMENT FLOOR PLAN  
(ELECTRICAL)

SCALE:	1:100	DRG. NO.:	BLOCK-A/SEE-01
DRN BY:	JITENDRA	CHECKED BY:	
DATE:	DEC.-2013		O.P.SHAH

ARCHITECTS:



PUNIT SRIVASTAV  
**VASTULIPI**  
ARCHITECTS & INTERIOR DESIGNERS  
5/171, VIRAM KHAND, GOMTI NAGAR  
LUCKNOW  
PH. NO.- 9415418151, 9935590999  
email: vastulipi@rediffmail.com  
website: www.vastulipi.com

Services Consultant :  
**SHAH AND PANT CONSULTING  
ENGINEERS PVT. LTD**  
AN ISO 9001:2008 COMPANY  
1, Fourth Floor, Halwasiya Court Building,  
Hazratganj, Lucknow-226001  
Ph. No.: 0522 - 2230625  
email : shah\_pant@yahoo.co.in