

PROJECT:

PROPOSED RAJVANSH RESIDENCY GROUP
HOUSING FOR RAJVANSH ESTATES PVT.
LTD. AT KHASRA NO. - 1578, GRAM-
AURANGABAD KHALSA WARD - RAJA
BIJALI PASI, LUCKNOW

LEGEND - (electrical)

S.NO	SYMBOL	DESCRIPTION	POSITION
1		1x40W FLUORESCENT TUBE LIGHT FIXTURE (SURFACE)	2550
2		1x40W FLUORESCENT TUBE LIGHT FIXTURE (CEILING)	ON CEILING
3		1x28W CFL WALL MOUNTED LIGHT FIXTURE	2550
4		2x11W CFL TYPE CEILING LIGHT	ON CEILING
5		MIRROR LIGHT	1850
6		SWITCH BOARD	1200
7		5-AMP PLUG POINT	200
8		5-AMP PLUG POINT	2250
9		5/15-AMP POWER POINT	200
10		5/15-AMP POWER POINT	1100 P-300 ABOVE PLATFORM
11		5/15-AMP POWER POINT FOR DYSER	SOCKET-1800 SWITCH-1750
12		T.V. ANTENNA POINT	200
13		6 AMP SP MCB	
14		20/32-AMP MCB(A.C.POINT)	200
15		CEILING FAN	ON CEILING
16		EXHAUST FAN	IN WINWEN.
17		TELEPHONE / INTERCOM SOCKET	200
18		CHANDELIER LIGHT	ON CEILING
19		CALL BELL	1200
20		BUZZAR	2400
21		INDICATES CONTROLLING OF LIGHT/FAN FROM SWITCH BOARD	
22		DISTRIBUTION BOARD	1800 (TOP OF D.B.)
23		SUBMAIN CONDUIT FROM L.T. PANEL TO L.D.B./D.B.	
24		SUBMAIN CONDUIT FROM L.T. PANEL TO P.D.B.	

SUB. TITLE:

BLOCK-A

DRG. TITLE:

TYPICAL FLOOR PLAN
(ELECTRICAL)

SCALE:

1:100

DRN BY:

JITENDRA

DATE:

DEC.-2013

ARCHITECTS:



PUNIT SRIVASTAV

VASTULIPI

ARCHITECTS & INTERIOR DESIGNERS

5/171, VIRAM KHAND, GOMTI NAGAR

LUCKNOW

PH. NO. - 9415418151, 9935590999

email: vastulipi@rediffmail.com

website: www.vastulipi.com

Services Consultant :

SHAH AND PANT CONSULTING
ENGINEERS PVT. LTD


AN ISO 9001:2008 COMPANY

1, Fourth Floor, Halwasiya Court Building,

Hazratganj, Lucknow-226001

Ph. No.: 0522 - 2230625

email : shah_pant@yahoo.co.in

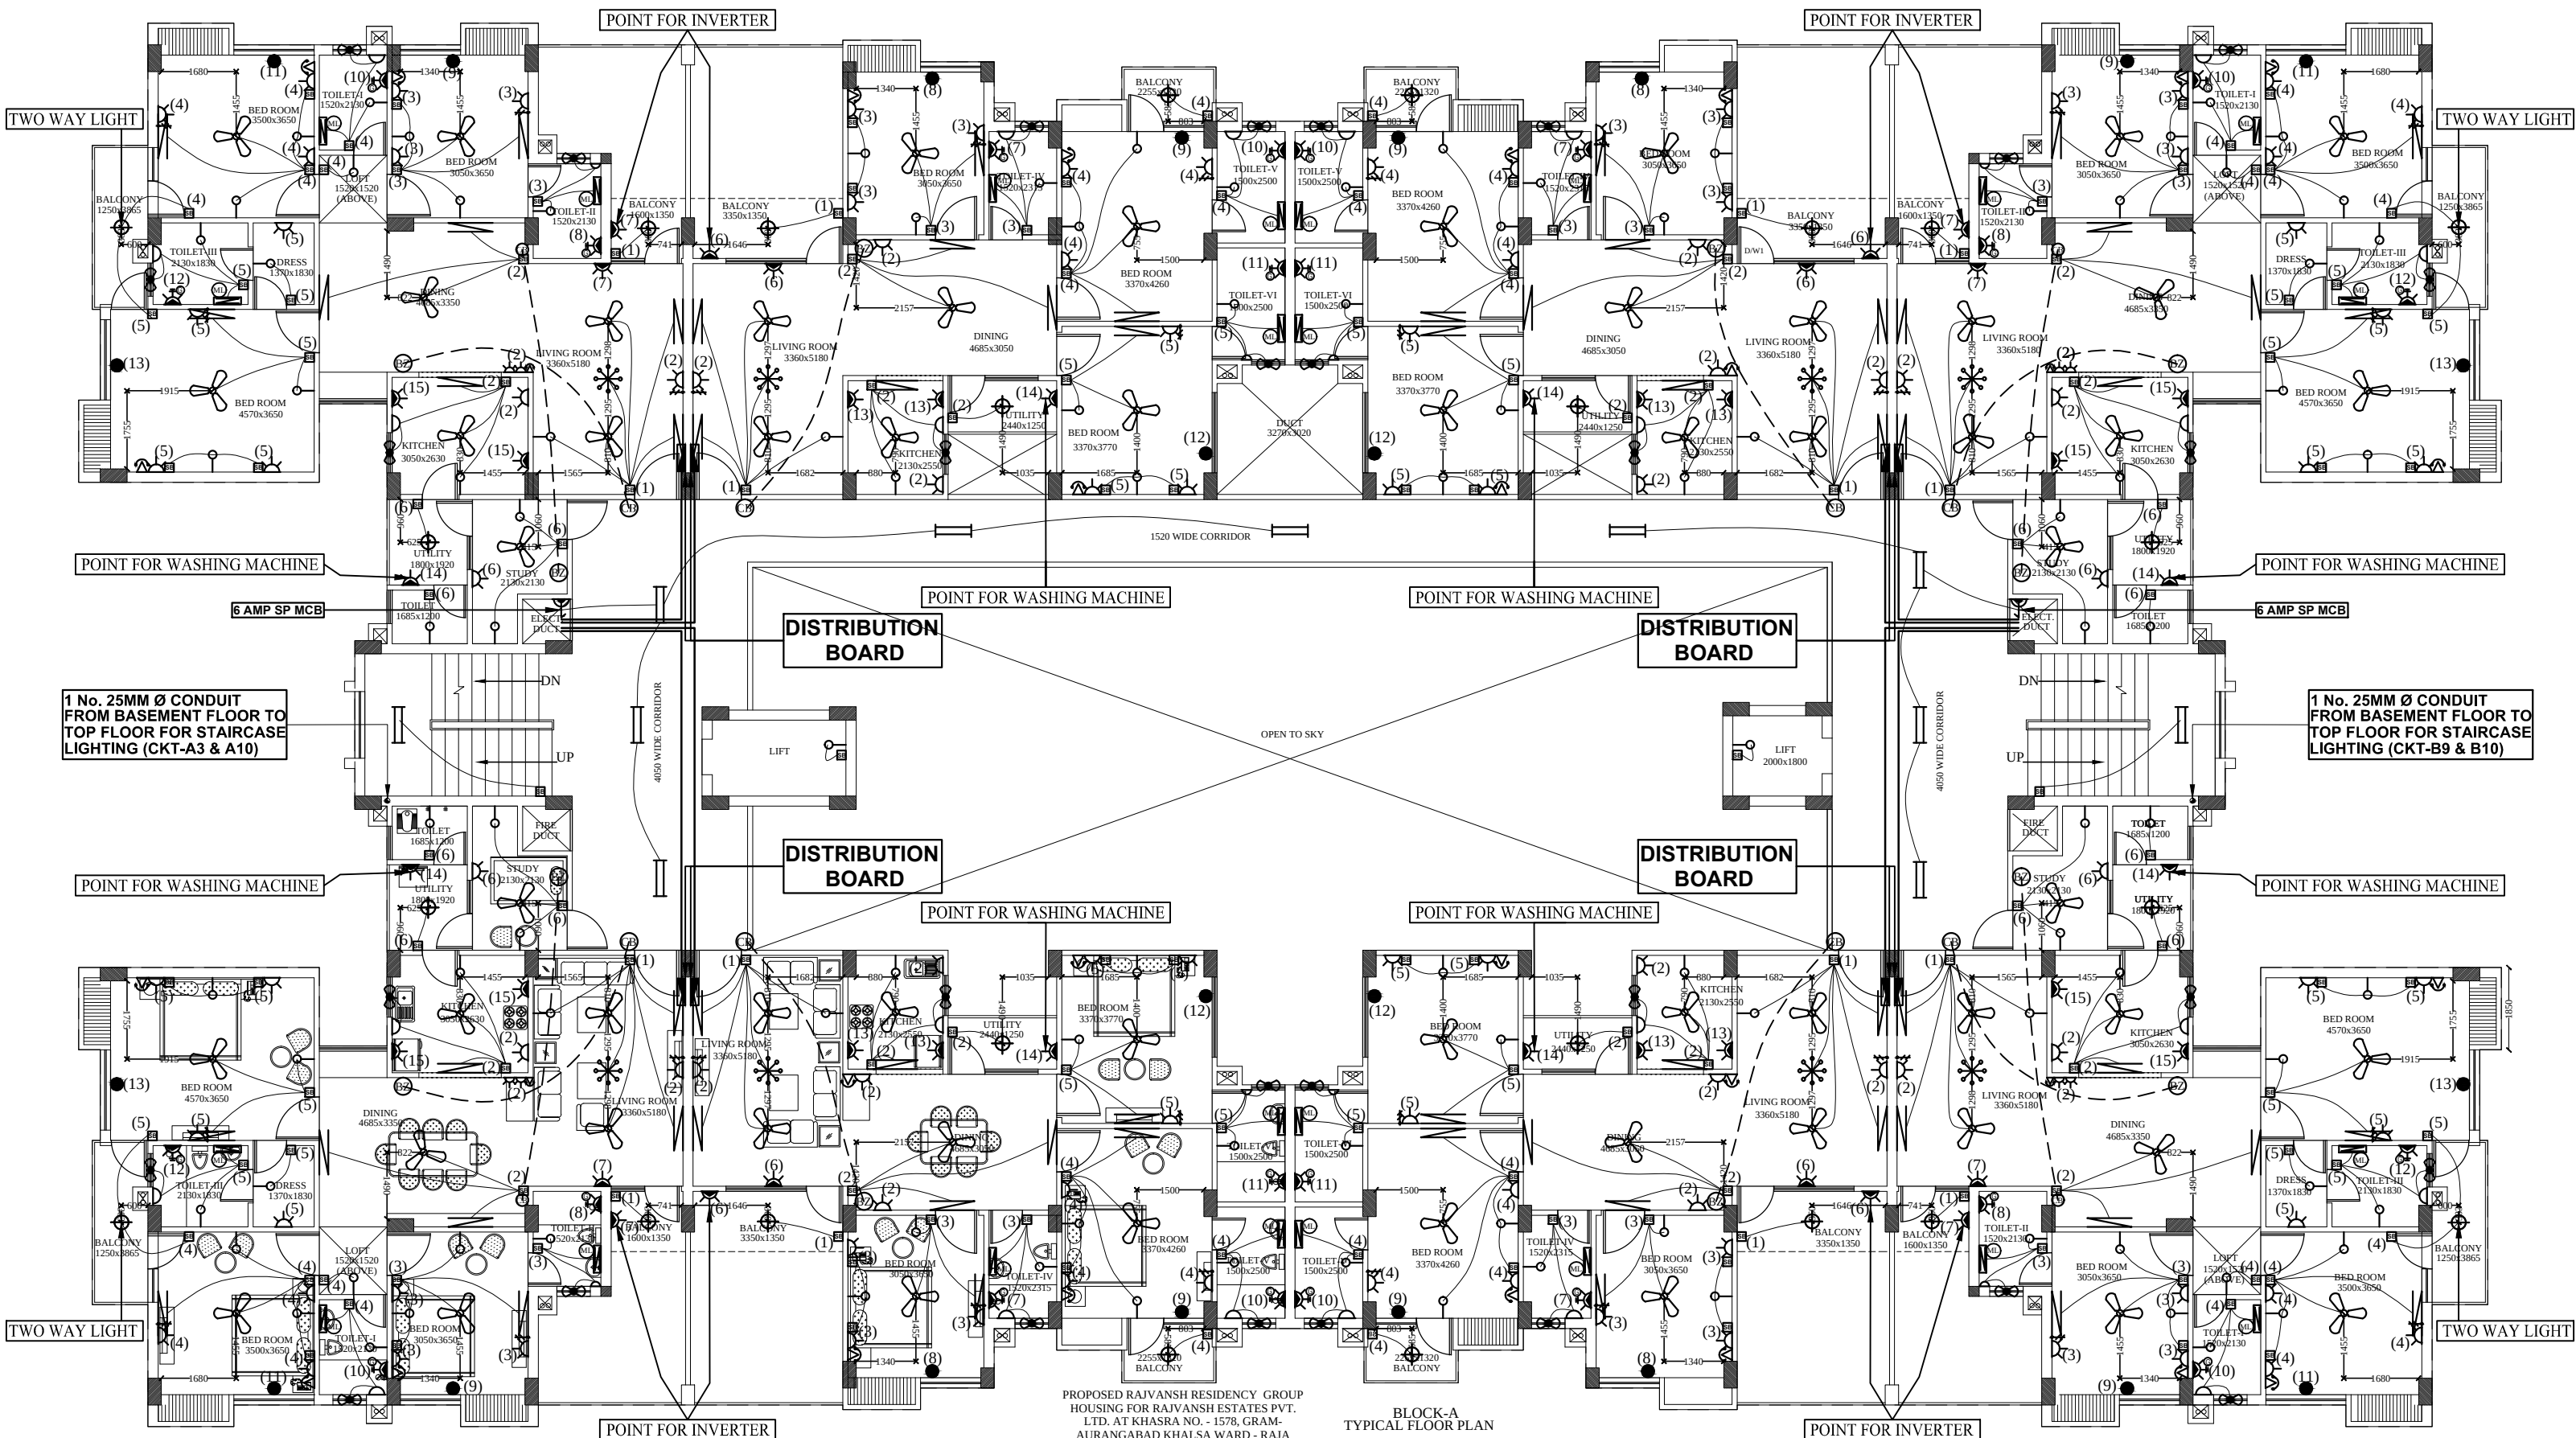

TYPICAL FLOOR PLAN