


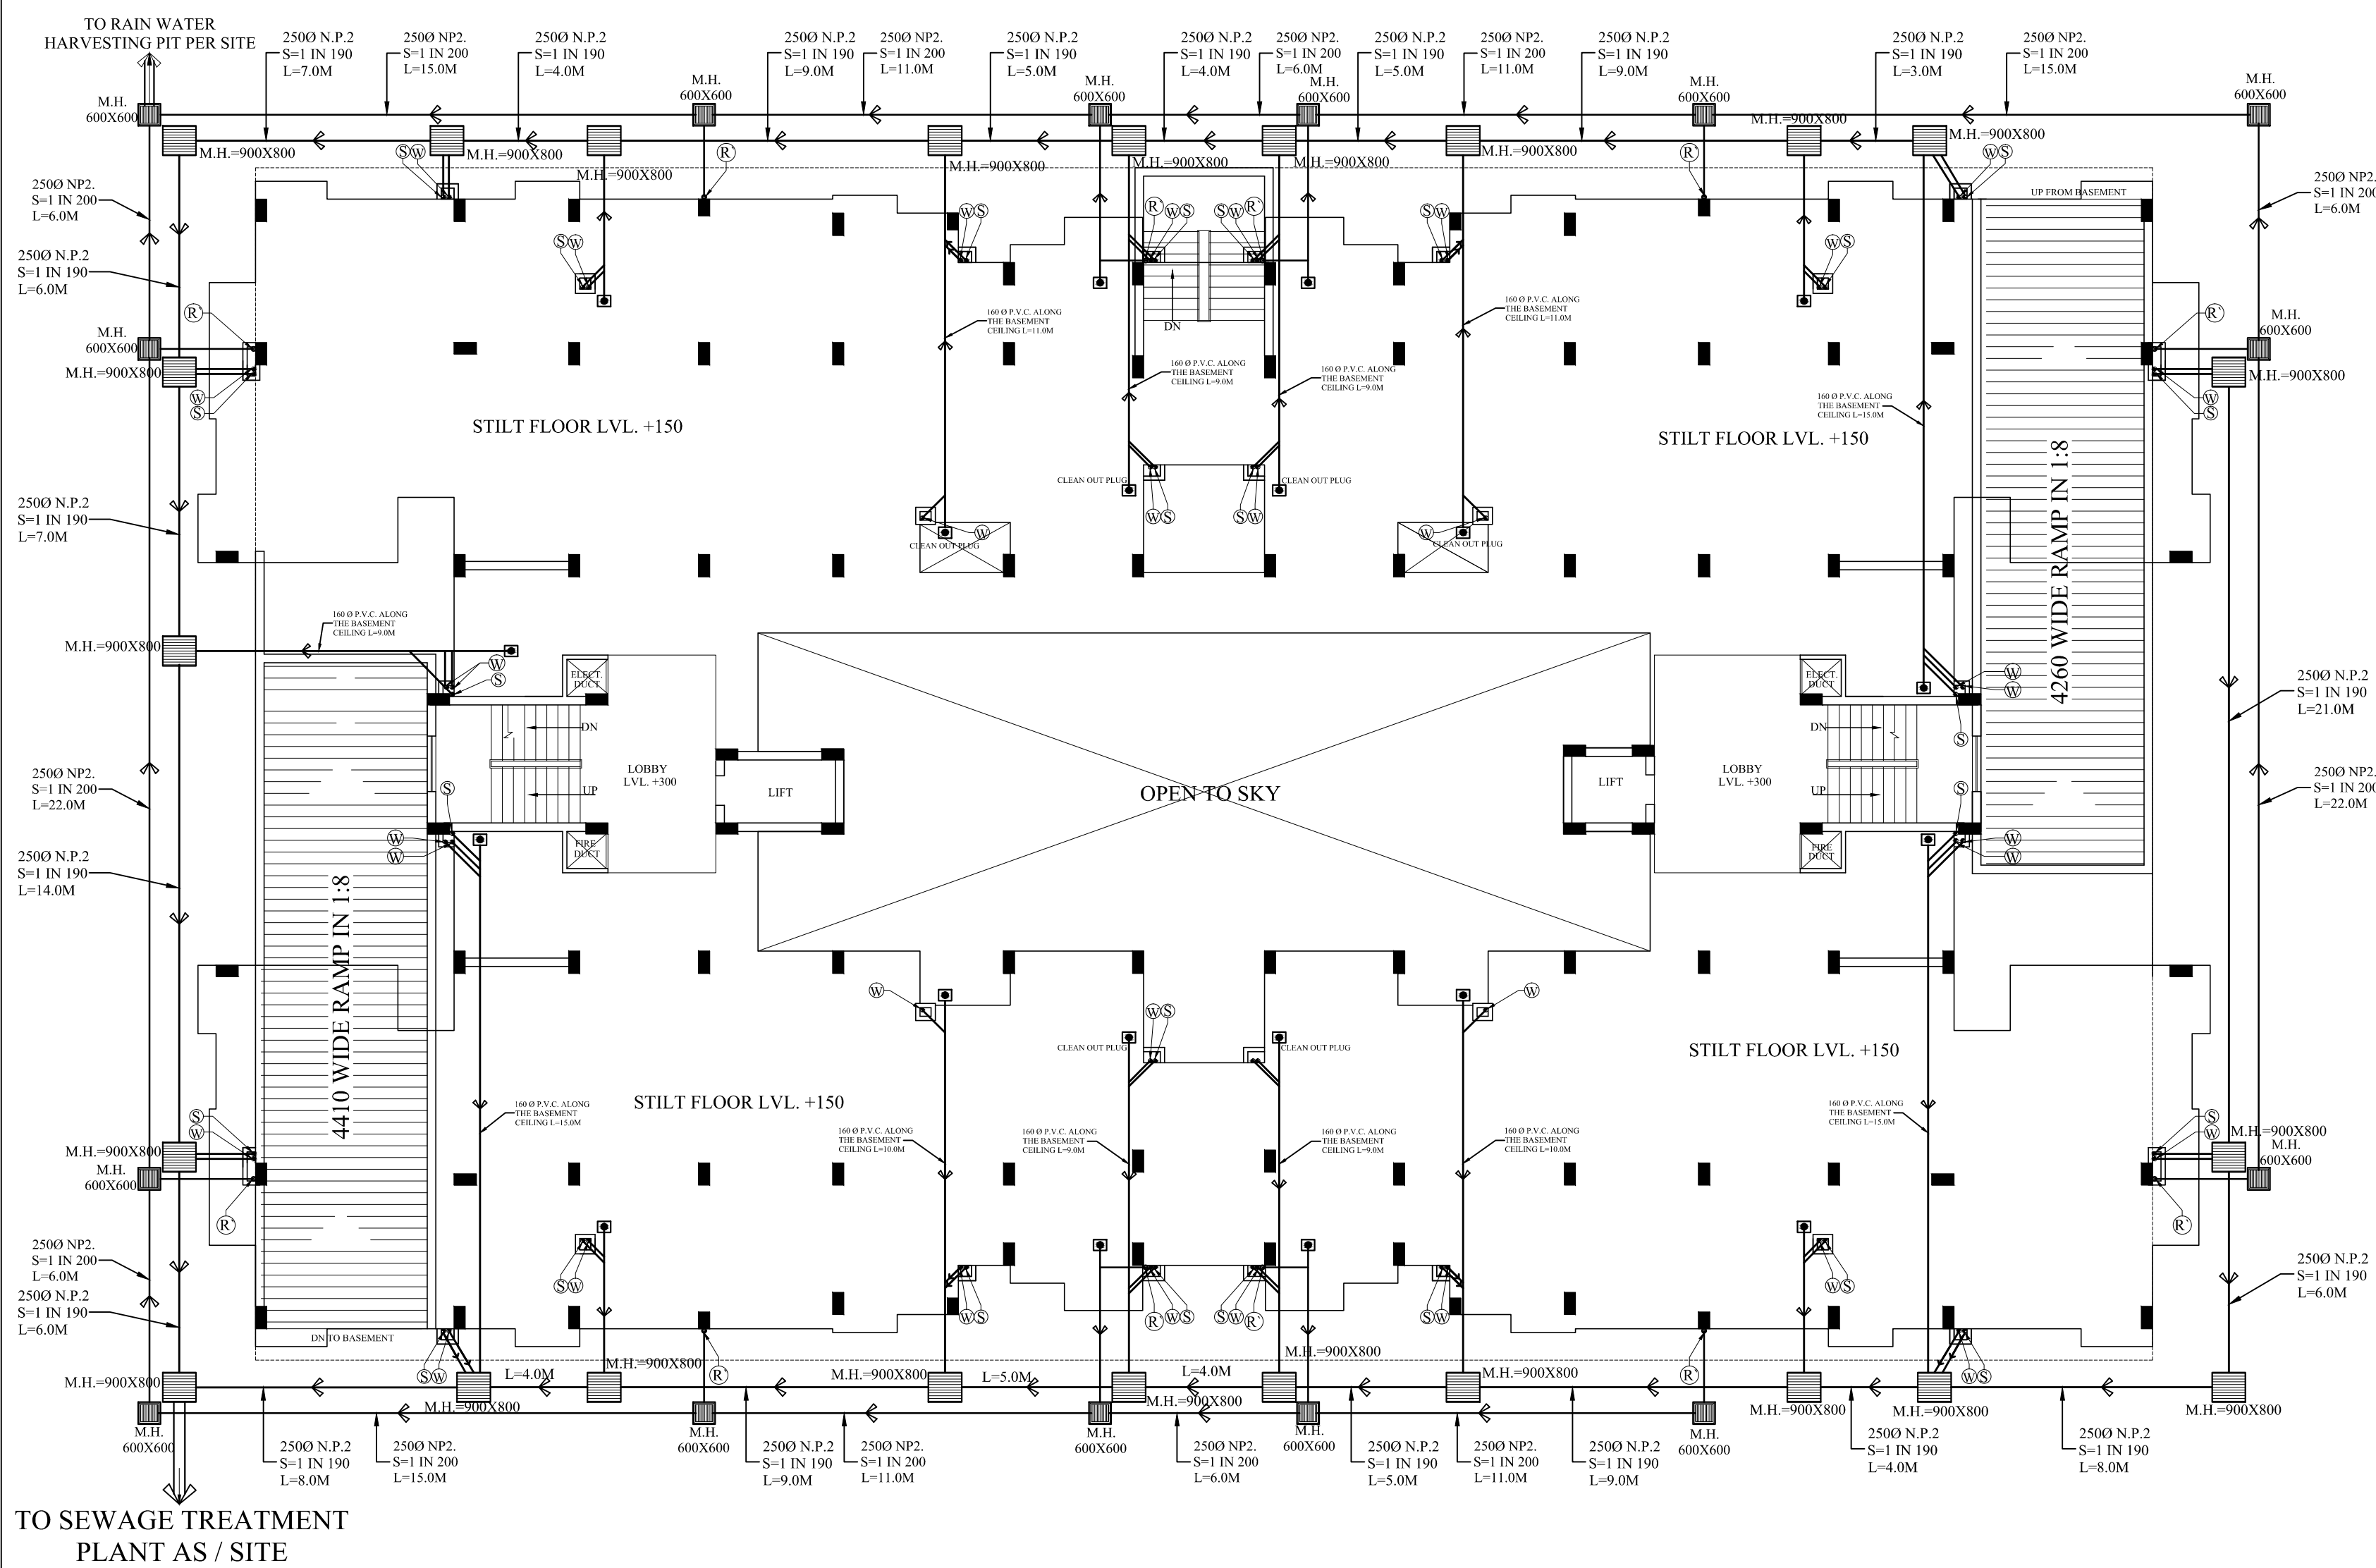

TO SEWAGE TREATMENT
PLANT AS / SITE

PROJECT:
**PROPOSED RAJVANSH RESIDENCY
GROUP HOUSING FOR
RAJVANSH ESTATES PVT. LTD.
KHASRA NO. - 1578 GRAM-
AURANGABAD KHALSA WARD -
RAJA BIJALI PASI LUCKNOW**

LEGEND:- SEWERAGE

SL.	SYMBOL	DESCRIPTION
1.	G.L.	GROUND LEVEL
2.	I.L.	INVERT LEVEL
3.	C.L.	CONNECTION LEVEL
4.	1500	INTERNAL DIAMETER OF PIPE (IN mm.)
5.	[Symbol]	SEWER LINE MAN HOLE 900X800
6.	[Symbol]	GROUND LEVEL INVERT LEVEL
7.	L=8.0	LENGTH OF PIPE
8.	[Symbol]	RAIN WATER HARVESTING SYSTEM
9.	[Symbol]	OVER FLOW CONNECTION (200 Ø)
10.	[Symbol]	DRAIN LINE
11.	[Symbol]	RWH TANK IN LAWN
12.	[Symbol]	WATER SUPPLY LINE
13.	[Symbol]	GATE VALVE
14.	[Symbol]	250 Ø N.P.2. S=1 IN 190

SUB. TITLE:
BLOCK-A STILT FLOOR PLAN

DRG. TITLE:
PLUMBING SERVICES

SCALE: 1:100	DRG. NO.: BLOCK A/SEP-02
DRN BY: BHUWAN	CHECKED BY:
DATE: SEPT-2013	M. PANT

ARCHITECTS:

**PUNIT SRIVASTAV
VASTULIPI**
ARCHITECTS & INTERIOR DESIGNERS
VASTU SHASTRA CONSULTANTS
5/171, VIRAM KHAND, GOMTI NAGAR, LUCKNOW
PH. NO.- 9415418151, 9935590999
email - vastulipi@rediffmail.com
website - www.vastulipi.com

Services Consultant :

SHAH & PANT
CONSULTING ENGINEERS (P) LTD.
AN ISO 9001-2008 COMPANY
1, 4th Floor, HALWASIYA COURT, HAZRATGANI, LUCKNOW (U.P.)
Tele. No. : 0522-2230625, Fax : 0522-2230625, Cell : 9839013280, 9415027719
Email : shah_pant@yahoo.co.in, Web : www.shahpantconsultingengineers.com