

PROJECT:

PROPOSED RAJVANSH RESIDENCY GROUP
HOUSING FOR RAJVANSH ESTATES PVT.
LTD. AT KHASRA NO. - 1578, GRAM-
AURANGABAD KHALSA WARD - RAJA
BIJALI PASI, LUCKNOW

LEGEND:- (electrical)		
S.NO.	SYMBOL	DESCRIPTION
1		1x40W FLUORESCENT TUBE LIGHT FIXTURE (CEILING)
2		2x11W CFL TYPE CEILING LIGHT (SURFACE)
3		LIGHT POINT
4		BRACKET LIGHT
5		5/15 AMP POWER POINT
6		DISTRIBUTION BOARD
7		SWITCH BOARD
8		INDICATES CONTROLLING OF LIGHT/FAN FROM SWITCH BOARD
9		L.D.B. LIGHTING DISTRIBUTION BOARD
10		SUBMAIN CONDUIT FROM L.T. PANEL TO L.D.B./D.B.
11		SUBMAIN CONDUIT FROM L.T. PANEL TO P.D.B.
12		
13		

SUB. TITLE:

BLOCK-A

DRG. TITLE:

STILT FLOOR PLAN
(ELECTRICAL)


SCALE:	1:100	DRG. NO.:	BLOCK-A/SEE-02
DRN BY:	JITENDRA	CHECKED BY:	
DATE:	DEC.-2013		O.P.SHAH

ARCHITECTS:



PUNIT SRIVASTAV
VASTULIPI
ARCHITECTS & INTERIOR DESIGNERS
5/171, VIRAM KHAND, GOMTI NAGAR
LUCKNOW
PH. NO.- 9415418151, 9935590999
email: vastulipi@rediffmail.com
website: www.vastulipi.com

Services Consultant :
SHAH AND PANT CONSULTING ENGINEERS PVT. LTD
AN ISO 9001:2008 COMPANY
1, Fourth Floor, Halwasiya Court Building,
Hazratganj, Lucknow-226001
Ph. No.: 0522 - 2230625
email : shah_pant@yahoo.co.in

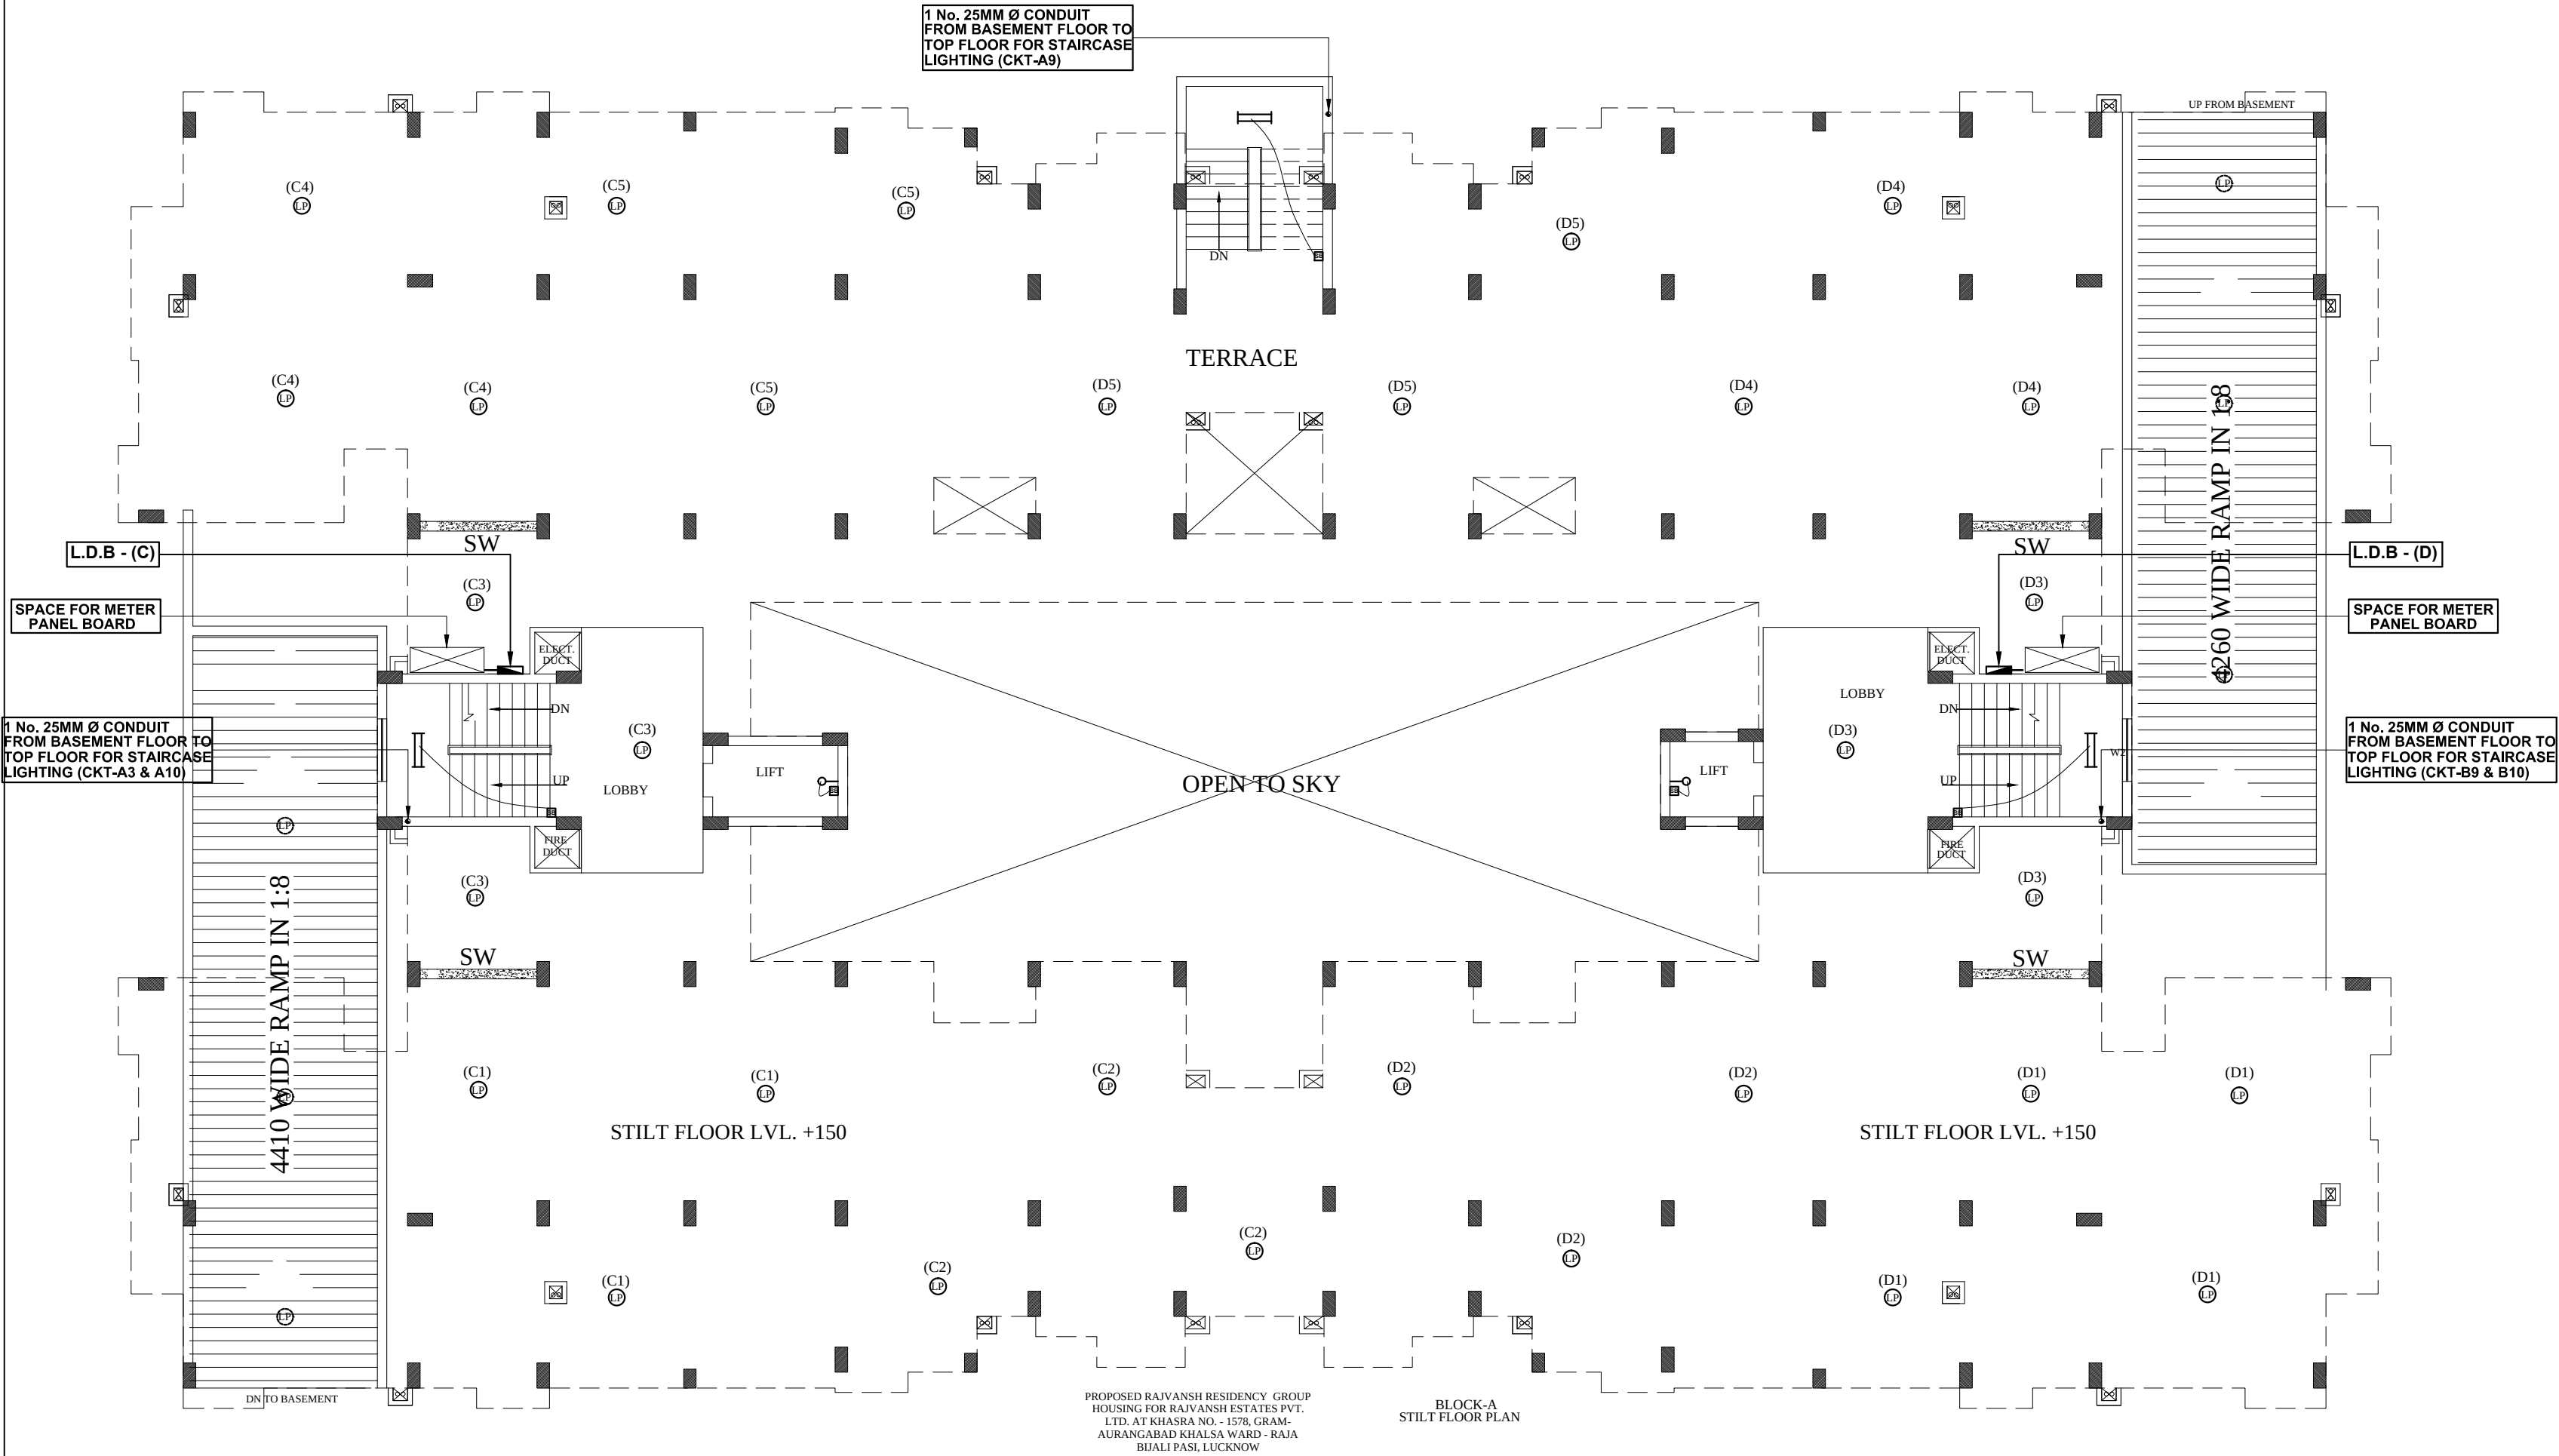

STILT FLOOR PLAN