

FIRE EXTINGUISHERS COMPRISING OF
a) 4.5 Kg. Co2 type fire extinguishers
I.S.I marked.
b) 4.5 Kg. D.C.P. type fire extinguishers
I.S.I marked.
c) 9 litres capacity water type Co2
(Gas pressure) fire extinguishers
complete with bracket, Bolts and initial
charge as per IS 940.-


PROJECT:
PROPOSED RAJVANSH RESIDENCY
GROUP HOUSING FOR
RAJVANSH ESTATES PVT. LTD.
KHASRA NO. - 1578 GRAM-
AURANGABAD KHALSA WARD -
RAJA BIJALI PASI LUCKNOW

LEGEND:- (sanitary)

S.NO.	SYMBOL	DESCRIPTION
1.	(R)	110 ØP.V.C. RAIN WATER PIPE
2.	(R')	160Ø P.V.C. RAIN WATER PIPE
3.	(S)	110 Ø P.V.C. SOIL AND VENT PIPE
4.	(W)	110 Ø P.V.C. WASTE AND VENT PIPE
5.	(Q)	WATER SUPPLY PIPE (C.P.V.C.)
6.	—	C.P.V.C PIPE FOR WATER SUPPLY
7.	— —	GATE VALVE
8.	M.H.	MAN HOLE
9.	F.T.	FLOOR TRAP
10.	G.T.	GULLY TRAP
11.	A.T.	ABLUTION TAP

THE FIXTURES HEIGHT SHALL BE AS FOLLOWS

- a) WALL MIXTURE (FOR BATHING) 1050 M.M.
b) SHOWER 2000 M.M.
c) ABLUTION TAP / HEALTH SPRAY 250 M.M.
(FOR W.C.)
d) ANGLE VALVE (FOR WASH BASIN) 500 M.M.
e) WASH BASIN (TOP OF RIM) 850 M.M.
f) KITCHEN TAP / MIXTURE TABLE TOP /1050
M.M.
g) ANGLE VALVE (FOR GEYSER) 1650 M.M. / OR
AS SPECIFIED

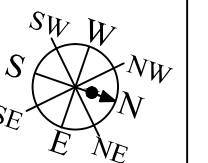

SUB. TITLE:
BLOCK-A TYPICAL FLOOR PLAN
(1st, IIInd, IIIrd, IVth, Vth, VIth, VIIth & VIIIth)

DRG. TITLE:
PLUMBING SERVICES


SCALE: 1:100
DRN BY: BHUWAN
DATE: SEPT-2013
DRG. NO.: BLOCK A/SEP-03
CHECKED BY:
M. PANT

ARCHITECTS:

PUNIT SRIVASTAV
VASTULIPI
ARCHITECTS & INTERIOR DESIGNERS
VASTU SHASTRA CONSULTANTS
5/171, VIRAM KHAND, GOMTI NAGAR, LUCKNOW
PH. NO.- 9415418151, 9935590999
email - vastulipi@rediffmail.com
website - www.vastulipi.com

Services Consultant :

SHAH & PANT
CONSULTING ENGINEERS (P) LTD.
AN ISO 9001:2008 COMPANY
1, 4th Floor, HALWASIYA COURT, HAZRATGANJ, LUCKNOW (U.P.)
Tele. No. : 0522-2230625, Fax : 0522-2230625, Cell : 9839013280, 9415027719
Email : shah_pant@yahoo.co.in, Web : www.shahpantconsultingengineers.com

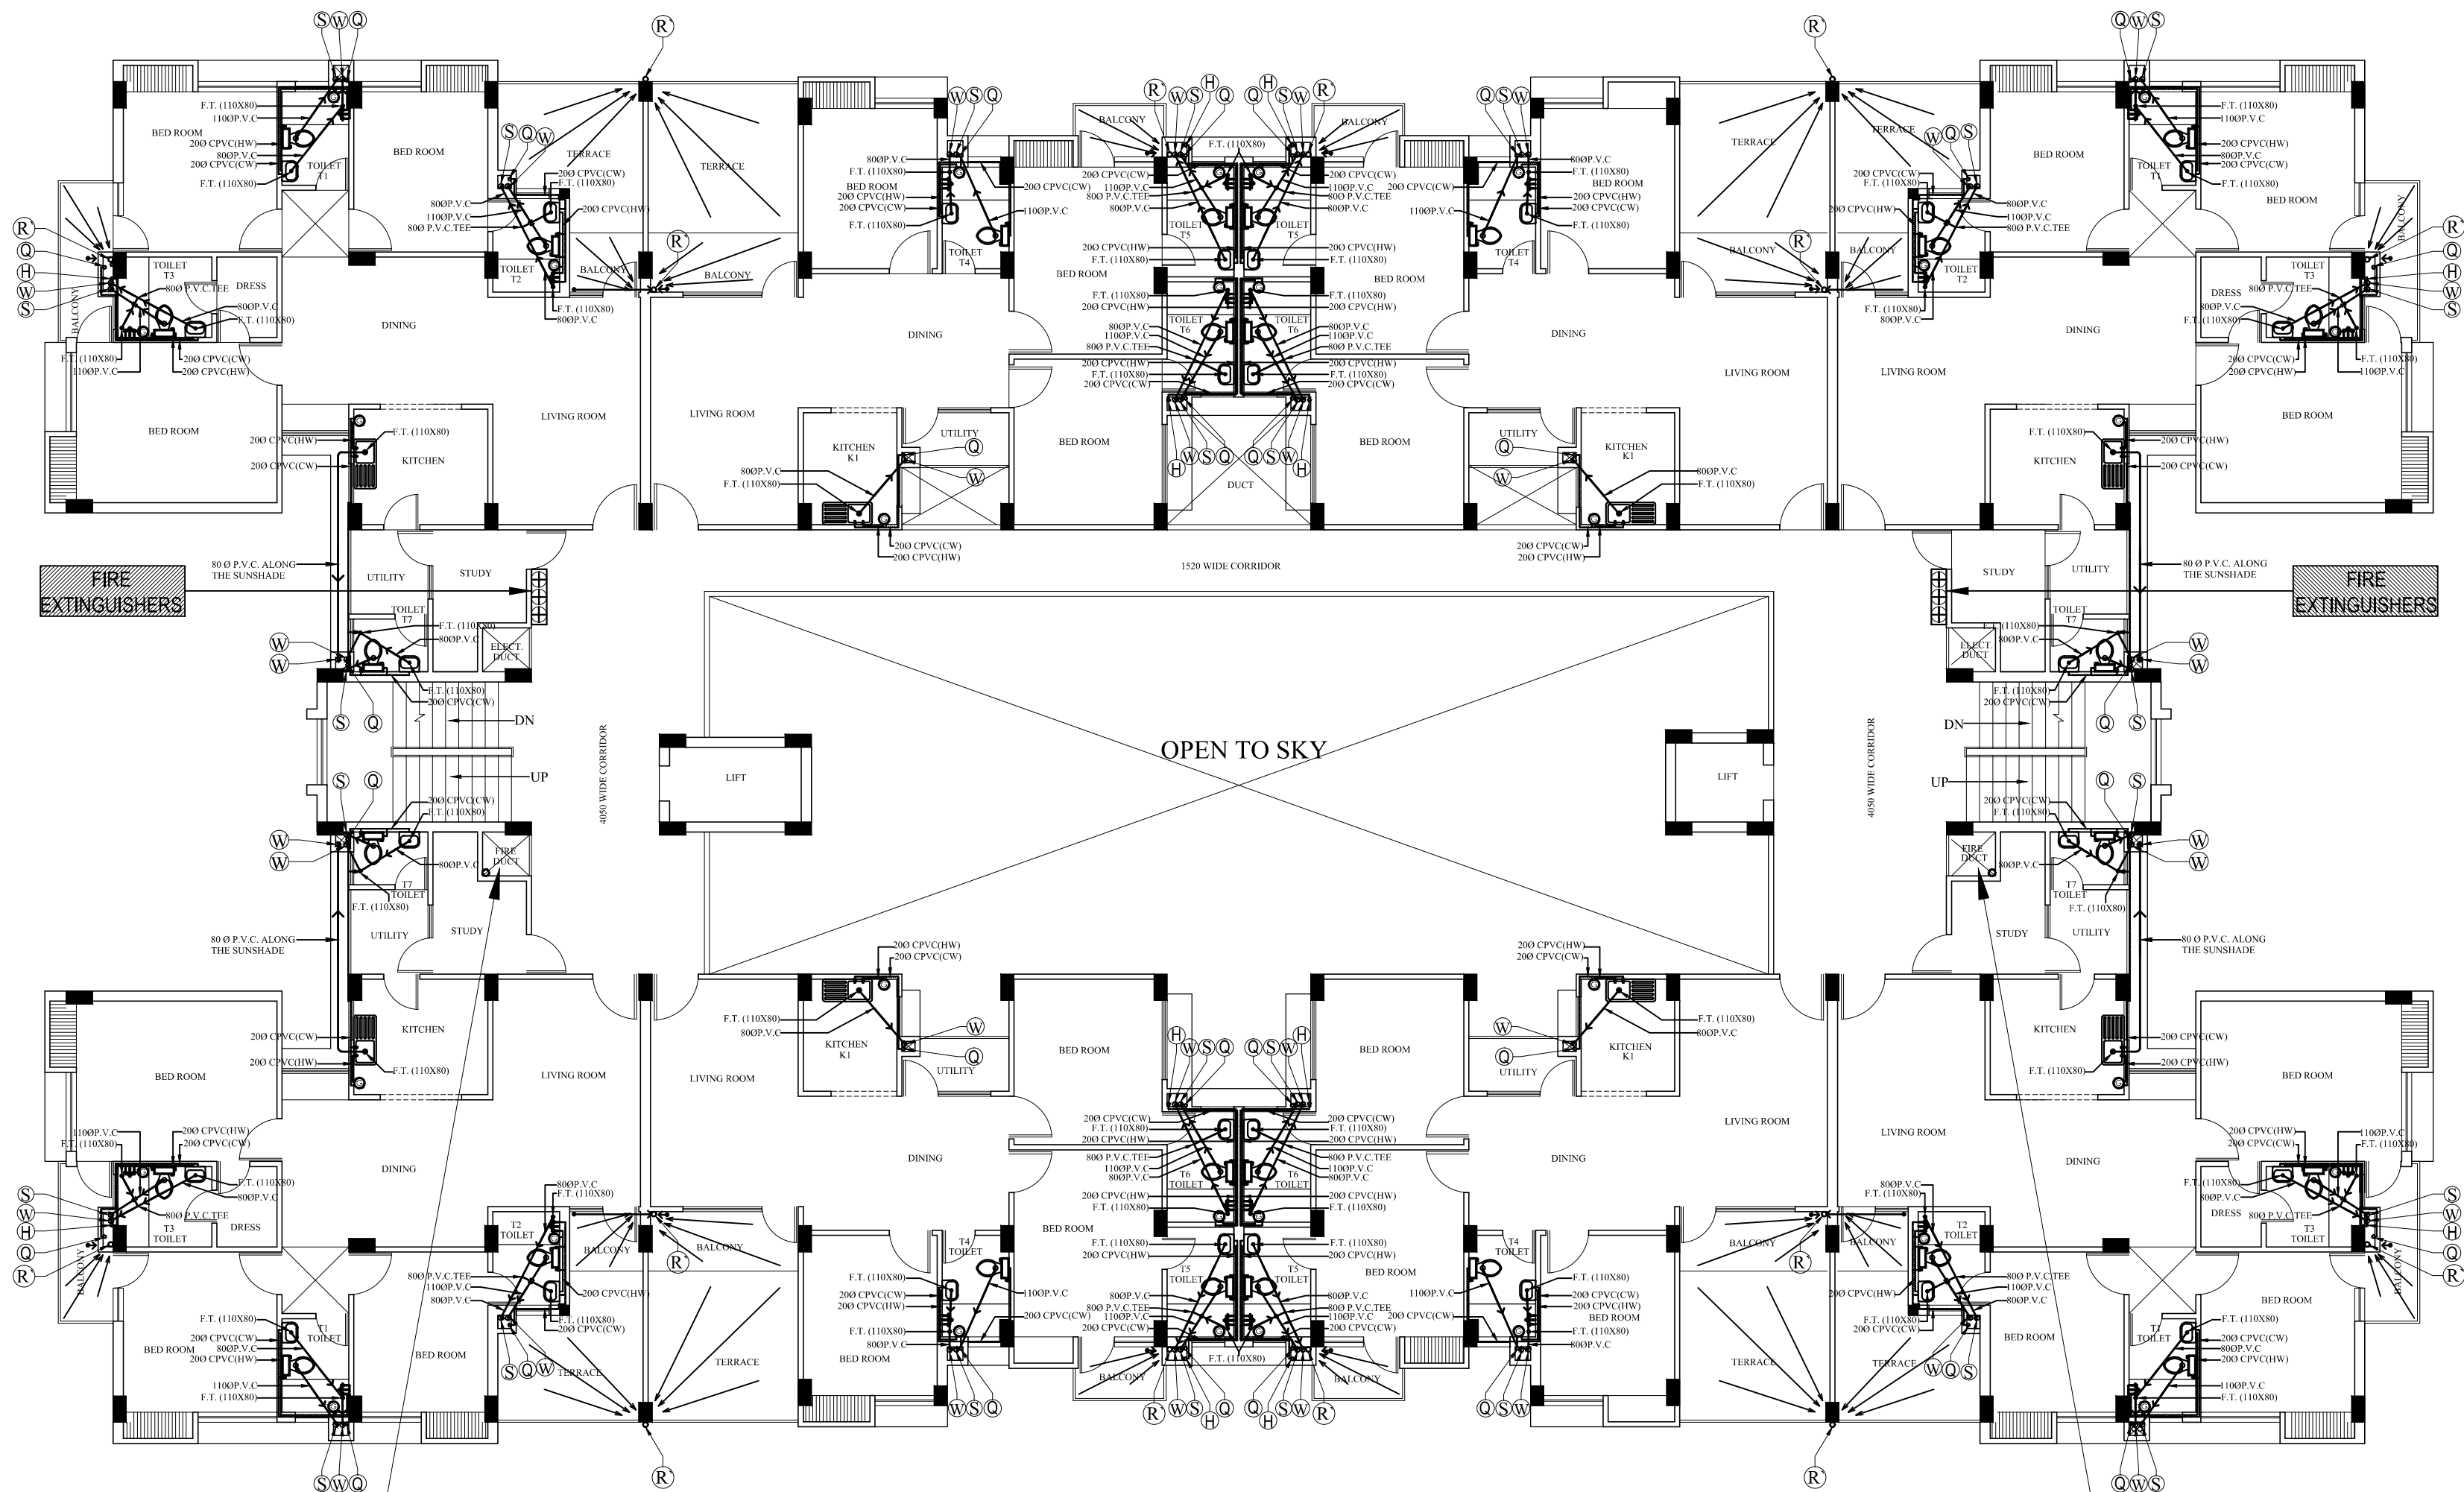

SPACE FOR DOWN COMER

- FIRE HYDRANT
100 MM. DIA FIRE FIGHTING DOWN COMER
WITH FOLLOWINGS:-
a) 63 MM. DIA. SINGLE HEADED HYDRANT VALVE
b) ONE NOS. 20 MM. DIA 30 METER LONG HOSE REEL
c) TWO NOS. 63 MM. DIA 15 METER LONG FIRE HOSE
PIPES
d) ONE NOS. BRANCH PIPE

LEGEND:-
50 MM. DIA FLOOR DRAIN
IN ALL BALCONYS

SPACE FOR DOWN COMER

- FIRE HYDRANT
100 MM. DIA FIRE FIGHTING DOWN COMER
WITH FOLLOWINGS:-
a) 63 MM. DIA. SINGLE HEADED HYDRANT VALVE
b) ONE NOS. 20 MM. DIA 30 METER LONG HOSE REEL
c) TWO NOS. 63 MM. DIA 15 METER LONG FIRE HOSE
PIPES
d) ONE NOS. BRANCH PIPE