


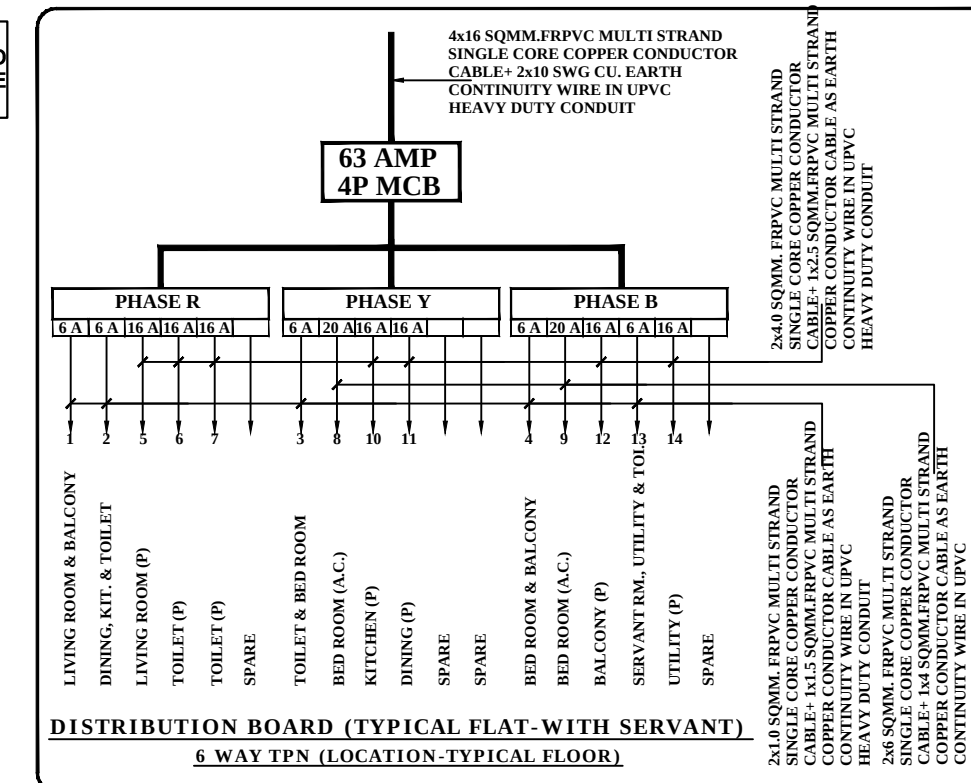

PRODUCED BY AN AUTODESK EDUCATIONAL PRODUCT



LEGEND - (electrical)			
S.NO	SYMBOL	DESCRIPTION	POSITION
1		1x40W FLUORESCENT TUBE LIGHT FIXTURE (SURFACE)	2550
2		1x40W FLUORESCENT TUBE LIGHT FIXTURE (CEILING)	ON CEILING
3		1x26W CFL WALL MOUNTED LIGHT FIXTURE	2550
4		2x11W CFL TYPE CEILING LIGHT	ON CEILING
5		MIRROR LIGHT	1850
6		SWITCH BOARD	1200
7		5 -AMP PLUG POINT	200
8		5 -AMP PLUG POINT	2250
9		5/15 -AMP POWER POINT	200
10		5/15 -AMP POWER POINT	1100 or 300 ABOVE PLATFORM
11		5/15 -AMP POWER POINT FOR GYSER	SOCKET-1850 SWITCH-1100
12		T.V. ANTENNA POINT	200
13		6 AMP SP MCB	
14		20/32 -AMP MCB (A.C. POINT)	200
15		CEILING FAN	ON CEILING
16		EXHAUST FAN	IN WIN/VEN.
17		TELEPHONE / INTERCOM SOCKET	200
18		CHANDELIER LIGHT	ON CEILING
19		CALL BELL	1200
20		BUZZAR	2400
21		INDICATES CONTROLLING OF LIGHT/FAN FROM SWITCH BOARD.	
22		DISTRIBUTION BOARD	1800 (TOP OF D.B.)
23		SUBMAIN CONDUIT FROM L.T. PANEL TO L.D.B./D.B.	
24		SUBMAIN CONDUIT FROM L.T. PANEL TO P.D.B.	

SUB. TITLE:

GROUP HOUSING - (BLOCK-B)

DRG. TITLE:
TYPICAL FLOOR PLAN
(ELECTRICAL)

ASSISTANT ENG. :

SCALE: 1:100	DRG. NO.: <u>BLOCK-B-/SEE-02</u>
DRN BY: JITENDRA	CHECKED BY:
DATE: DEC.-2013	O.P.SHAH

ARCHITECTURAL CONSULTANTS :-



VASTULIPI

ARCHITECTS & INTERIOR DESIGNERS

VASTU SHASTRA CONSULTANTS

5/171, VIRAM KHAND, GOMTI NAGAR, LUCKNOW

PH. NO.- 9415448151, 9935590999

email - vastulipi@rediffmail.com

website - www.vastulipi.com

Services Consultant :
SHAH AND PANT CONSULTING
ENGINEERS PVT. LTD
AN ISO 9001:2008 COMPANY
1, Fourth Floor, Halwasiya Court Building,
Hazratganj, Lucknow-226001
Ph. No.: 0522 - 2230625
email : shah_pant@yahoo.co.in