



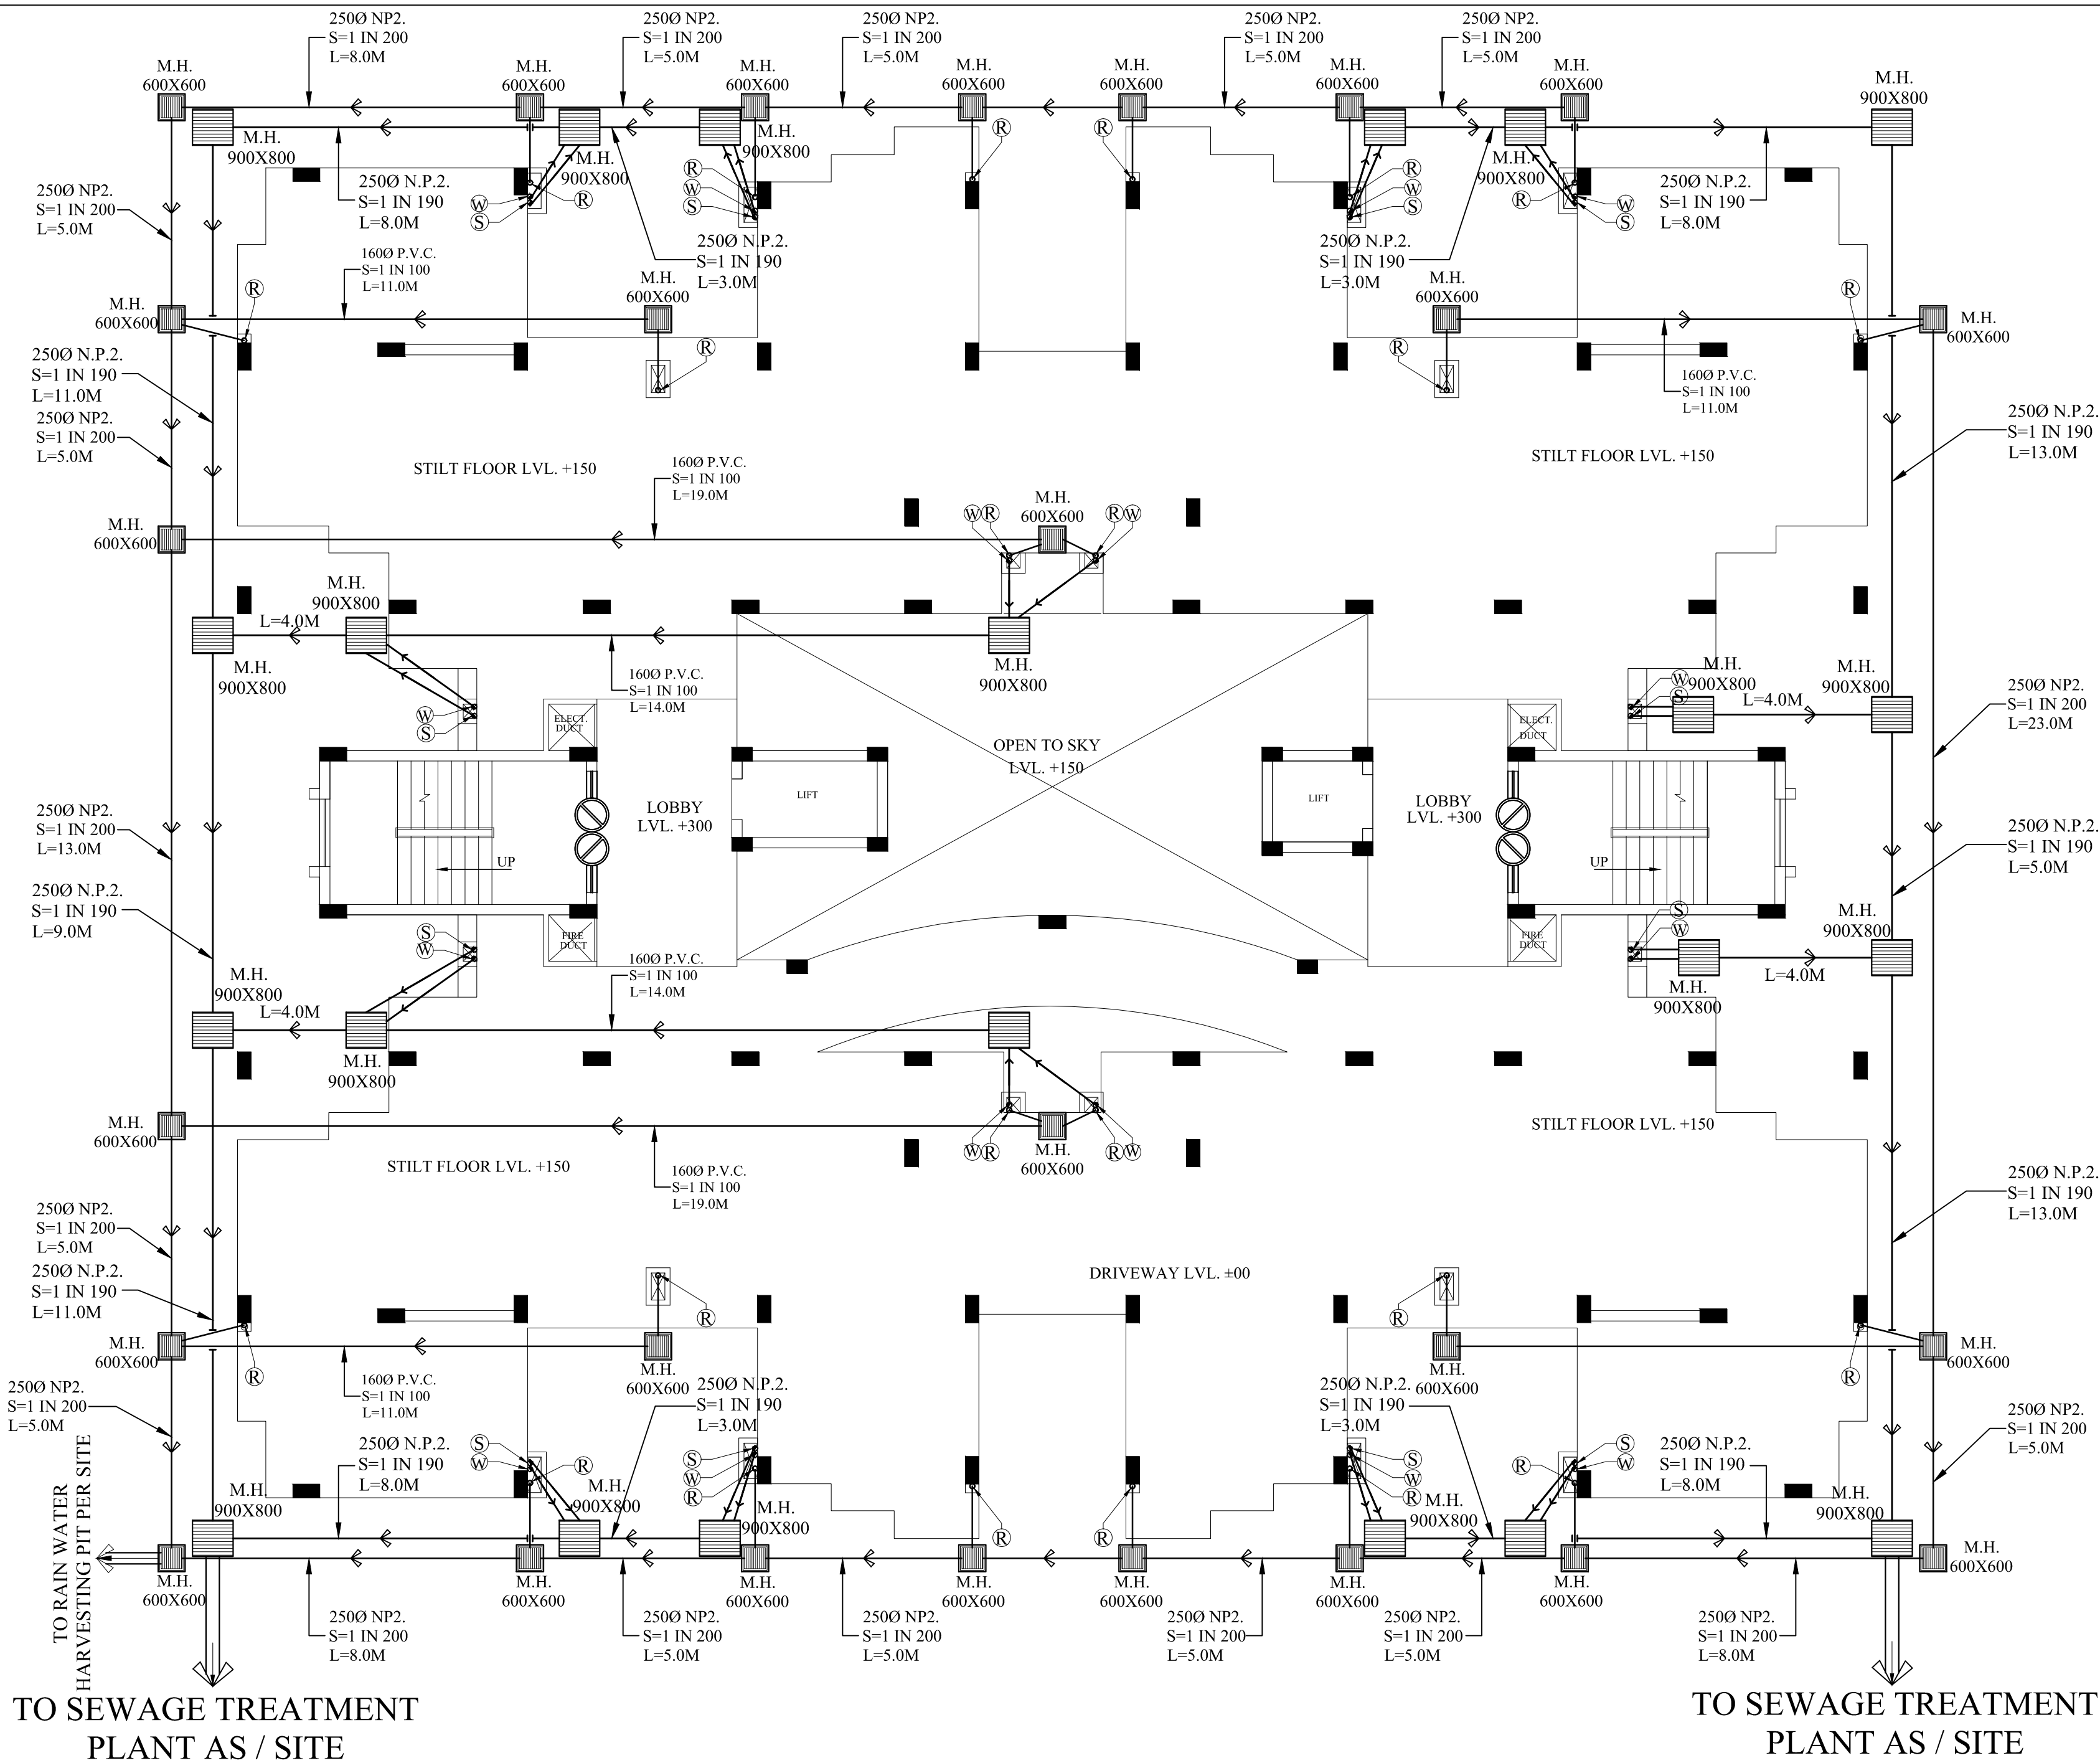

PROJECT:
PROPOSED RAJVANSH RESIDENCY
GROUP HOUSING FOR
RAJVANSH ESTATES PVT. LTD.
KHASRA NO. - 1578 GRAM-
AURANGABAD KHALSA WARD -
RAJA BIJALI PASI LUCKNOW

LEGEND:- SEWERAGE		
SL.	SYMBOL	DESCRIPTION
1.	G.L.	GROUND LEVEL
2.	I.L.	INVERT LEVEL
3.	C.L.	CONNECTION LEVEL
4.	150Ø	INTERNAL DIAMETER OF PIPE (IN mm.)
5.		SEWER LINE MAN HOLE 900X800
6.		GROUND LEVEL INVERT LEVEL
7.	L=8.0	LENGTH OF PIPE
8.		RAIN WATER HARVESTING SYSTEM
9.		OVER FLOW CONNECTION (200 Ø)
10.		DRAIN LINE
11.		RWH TANK IN LAWN
12.		WATER SUPPLY LINE
13.		GATE VALVE
14.		250 Ø N.P.2, S=1 IN 190

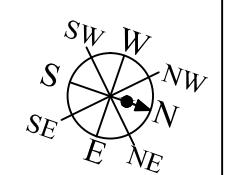

SUB. TITLE:
BLOCK-B STILT FLOOR PLAN

DRG. TITLE:
PLUMBING SERVICES

SCALE:	1:100	DRG. NO.:	BLOCK B/SEP-02
DRN BY:	BHUWAN	CHECKED BY:	
DATE:	SEPT-2013		M. PANT

ARCHITECTS:

PUNIT SRIVASTAV
VASTULIPI
ARCHITECTS & INTERIOR DESIGNERS
VASTU SHASTRA CONSULTANTS
5/171, VIRAM KHAND, GOMTI NAGAR, LUCKNOW
PH. NO.- 9415418151, 9935590999
email - vastulipi@rediffmail.com
website - www.vastulipi.com

Services Consultant :

SHAH & PANT
CONSULTING ENGINEERS (P) LTD.
AN ISO 9001:2008 COMPANY
1, 4th Floor, HALWASIYA COURT, HAZRATGANJ, LUCKNOW (U.P.)
Tele. No. : 0522-2230625, Fax : 0522-2230625, Cell : 9839013280, 9415027719
Email : shah_pant@yahoo.co.in, Web : www.shahpantconsultingengineers.com