


PROJECT:
PROPOSED RAJVANSH RESIDENCY
GROUP HOUSING FOR
RAJVANSH ESTATES PVT. LTD.
KHASRA NO. - 1578 GRAM-
AURANGABAD KHALSA WARD -
RAJA BIJALI PASI LUCKNOW

LEGEND:- (sanitary)

S.NO.	SYMBOL	DESCRIPTION
1.	(R)	110 Ø P.V.C. RAIN WATER PIPE
2.	(R')	160 Ø P.V.C. RAIN WATER PIPE
3.	(S)	110 Ø P.V.C. SOIL AND VENT PIPE
4.	(W)	110 Ø P.V.C. WASTE AND VENT PIPE
5.	(Q)	WATER SUPPLY PIPE (C.P.V.C.)
6.	—	C.P.V.C PIPE FOR WATER SUPPLY
7.	⌞	GATE VALVE
8.	M.H.	MAN HOLE
9.	F.T.	FLOOR TRAP
10.	G.T.	GULLY TRAP
11.	A.T.	ABLUTION TAP

THE FIXTURES HEIGHT SHALL BE AS FOLLOWS

- | | |
|---|-----------------------------|
| a) WALL MIXTURE (FOR BATHING) | 1050 M.M. |
| b) SHOWER | 2000 M.M. |
| c) ABLUTION TAP / HEALTH SPRAY (FOR W.C.) | 250 M.M. |
| d) ANGLE VALVE (FOR WASH BASIN) | 500 M.M. |
| e) WASH BASIN (TOP OF RIM) | 850 M.M. |
| f) KITCHEN TAP / MIXTURE | TABLE TOP / 1050 M.M. |
| g) ANGLE VALVE (FOR GEYSER) | 1650 M.M. / OR AS SPECIFIED |

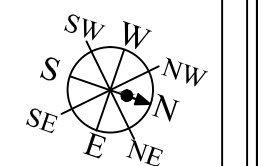

SUB. TITLE:
BLOCK-B TYPICAL FLOOR PLAN
(G+8TH FLOOR PLAN)

DRG. TITLE:
PLUMBING SERVICES


SCALE:	1:100	DRG. NO.:	BLOCK B/SEP-01
DRN BY:	BHUWAN	CHECKED BY:	
DATE:	SEPT-2013		M. PANT

ARCHITECTS:

PUNIT SRIVASTAV
VASTULIPI
ARCHITECTS & INTERIOR DESIGNERS
VASTU SHASTRA CONSULTANTS
5/171, VIRAM KHAND, GOMTI NAGAR, LUCKNOW
PH. NO. - 9415418151, 9935590999
email - vastulipi@rediffmail.com
website - www.vastulipi.com

Services Consultant :

SHAH & PANT
CONSULTING ENGINEERS (P) LTD.
AN ISO 9001:2008 COMPANY
1, 4th Floor, HALWASIYA COURT, HAZRATGANI, LUCKNOW (U.P.)
Tele. No. : 0522-2230625, Fax : 0522-2230625, Cell : 9839013280, 9415027719
Email : shah_pant@yahoo.co.in, Web : www.shahpantconsultingengineers.com

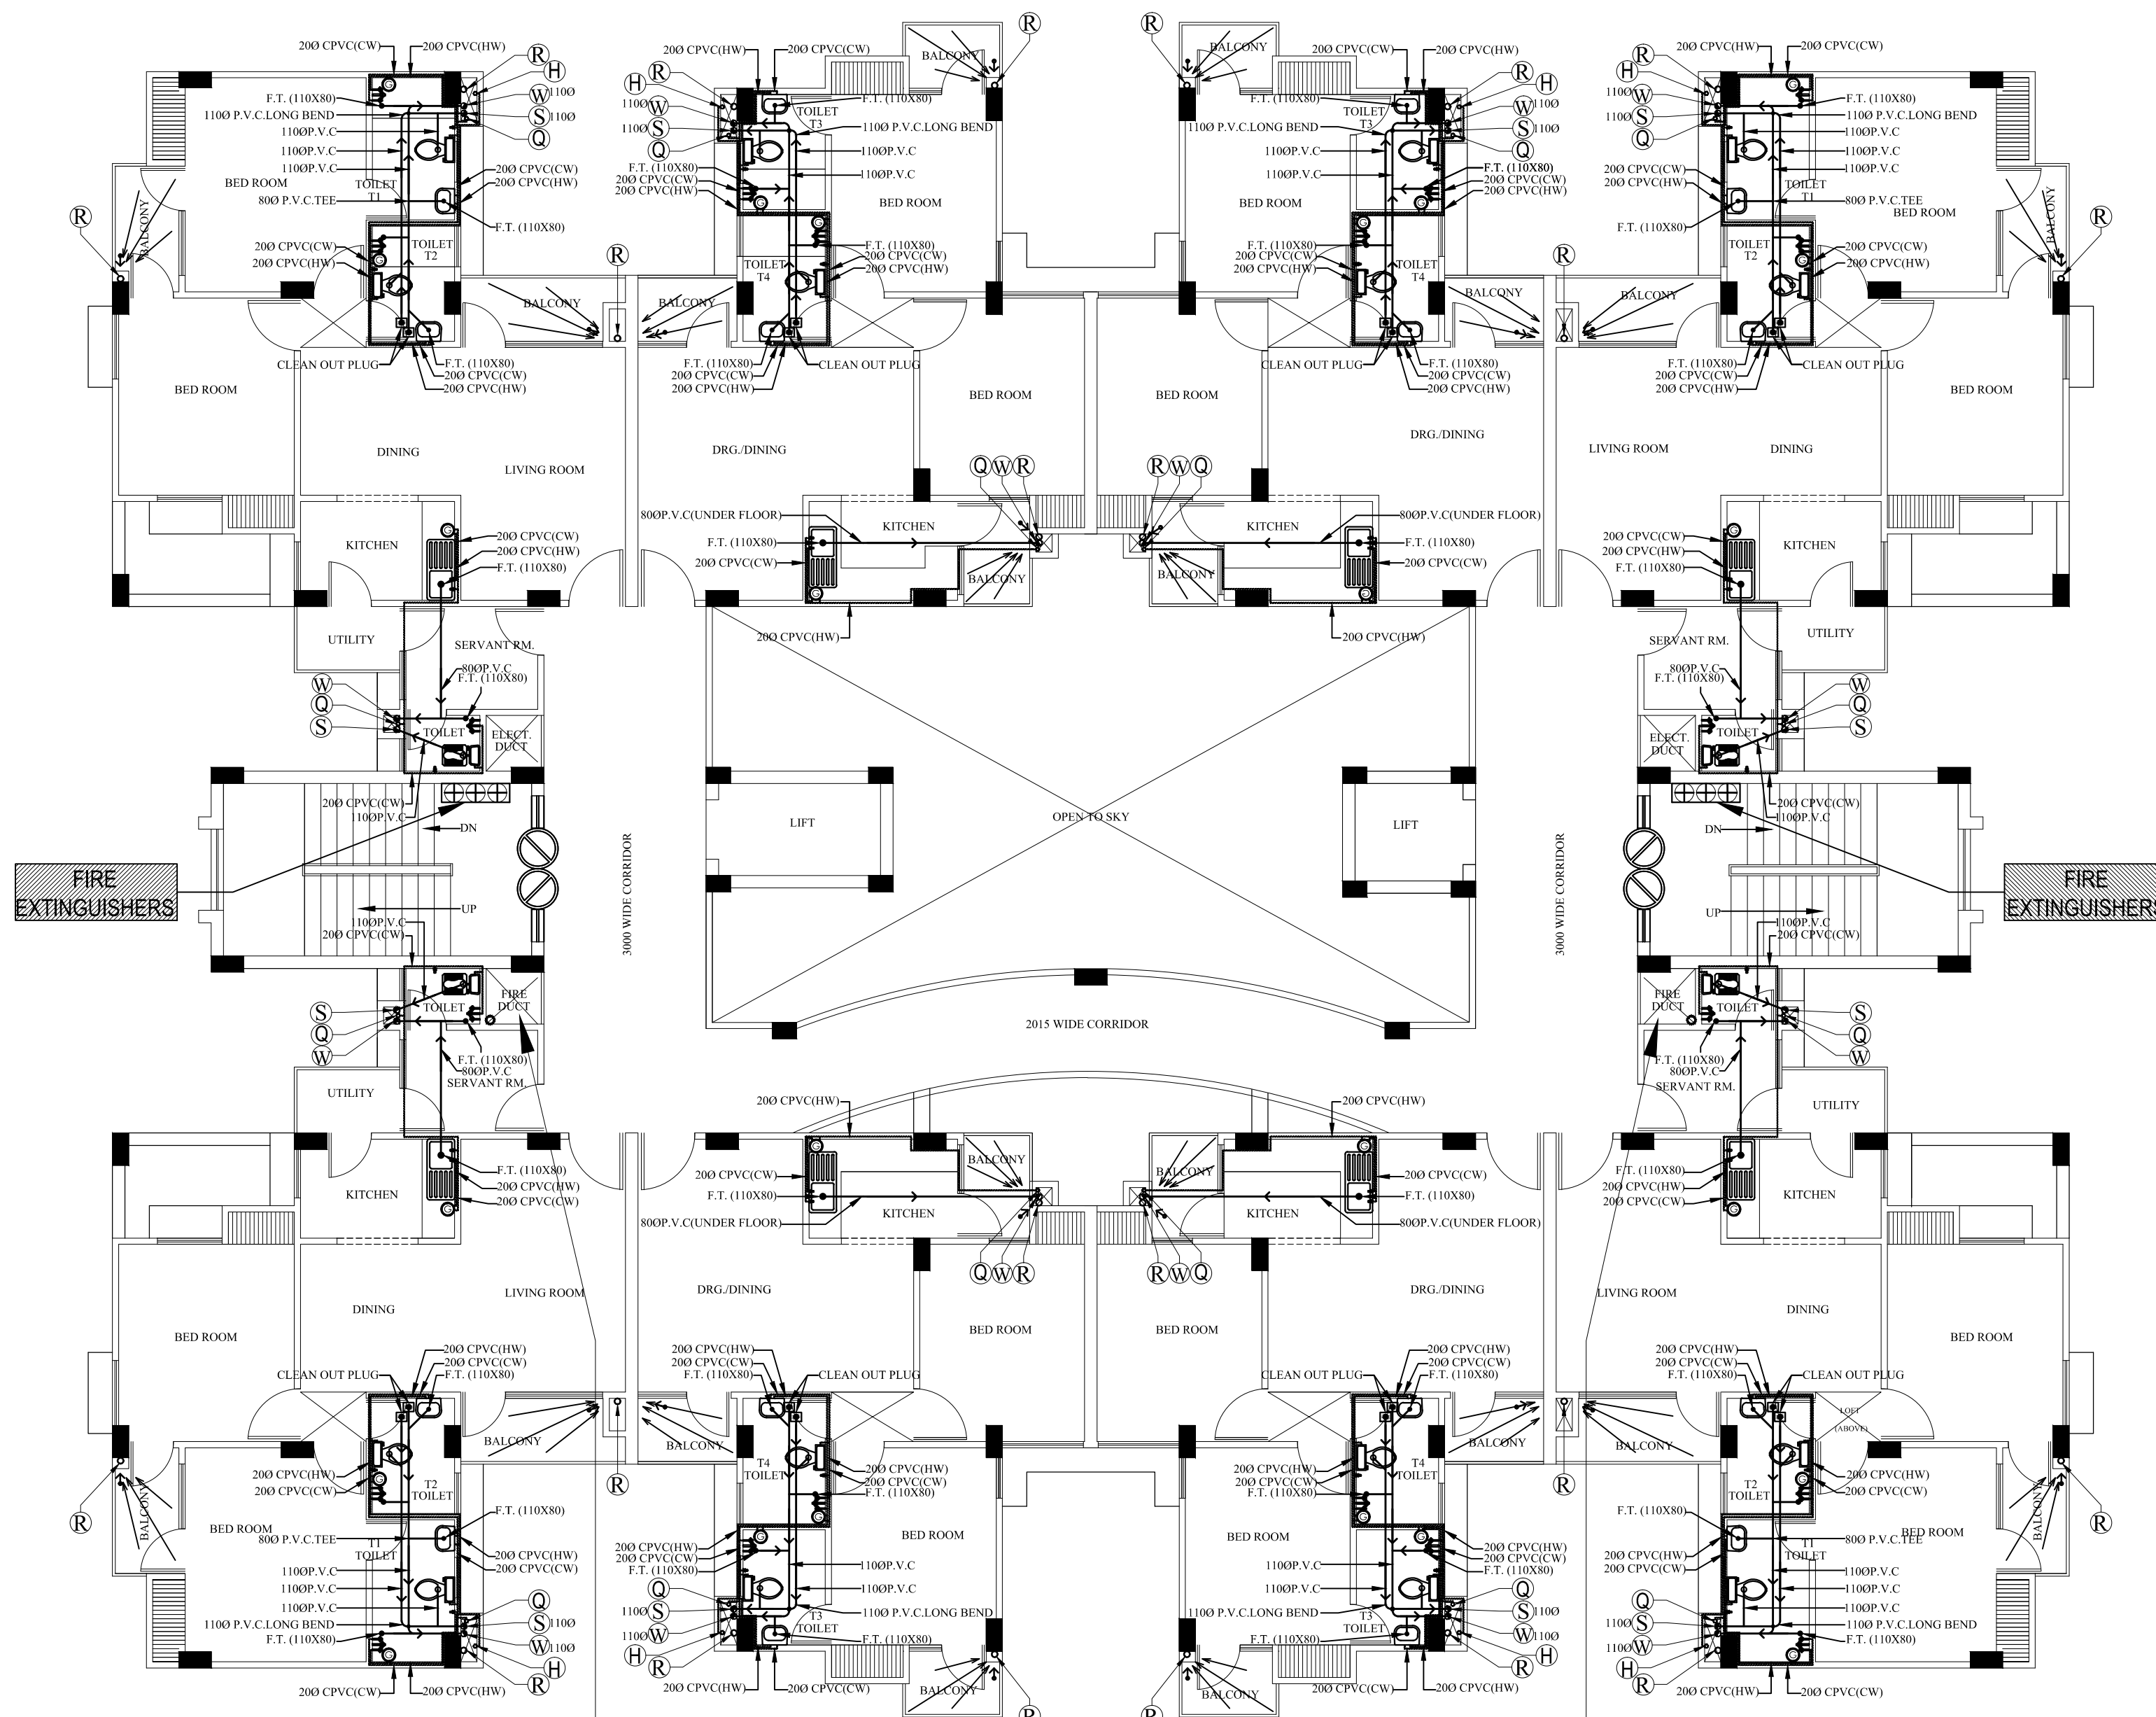

SPACE FOR DOWN COMER

FIRE HYDRANT
100 MM. DIA FIRE FIGHTING DOWN COMER
WITH FOLLOWINGS:-
a) 63 MM. DIA. SINGLE HEADED HYDRANT VALVE.
b) ONE NOS. 20 MM. DIA 30 METER LONG HOSE REEL
c) TWO NOS. 63 MM. DIA 15 METER LONG FIRE HOSE PIPES
d) ONE NOS. BRANCH PIPE

FIRE EXTINGUISHERS COMPRISING OF

-  a) 4.5 Kg. Co2 type fire extinguishers
I.S.I marked.
b) 4.5 Kg. D.C.P. type fire extinguishers
I.S.I marked.
c) 9 litres capacity water type Co2
(Gas pressure) fire extinguishers
complete with bracket, Bolts and initial
charge as per IS 940.--

LEGEND:-
50 MM. DIA FLOOR DRAIN
IN ALL BALCONYS

SPACE FOR DOWN COMER

FIRE HYDRANT
100 MM. DIA FIRE FIGHTING DOWN COMER
WITH FOLLOWINGS:-
a) 63 MM. DIA. SINGLE HEADED HYDRANT VALVE.
b) ONE NOS. 20 MM. DIA 30 METER LONG HOSE REEL
c) TWO NOS. 63 MM. DIA 15 METER LONG FIRE HOSE PIPES
d) ONE NOS. BRANCH PIPE