
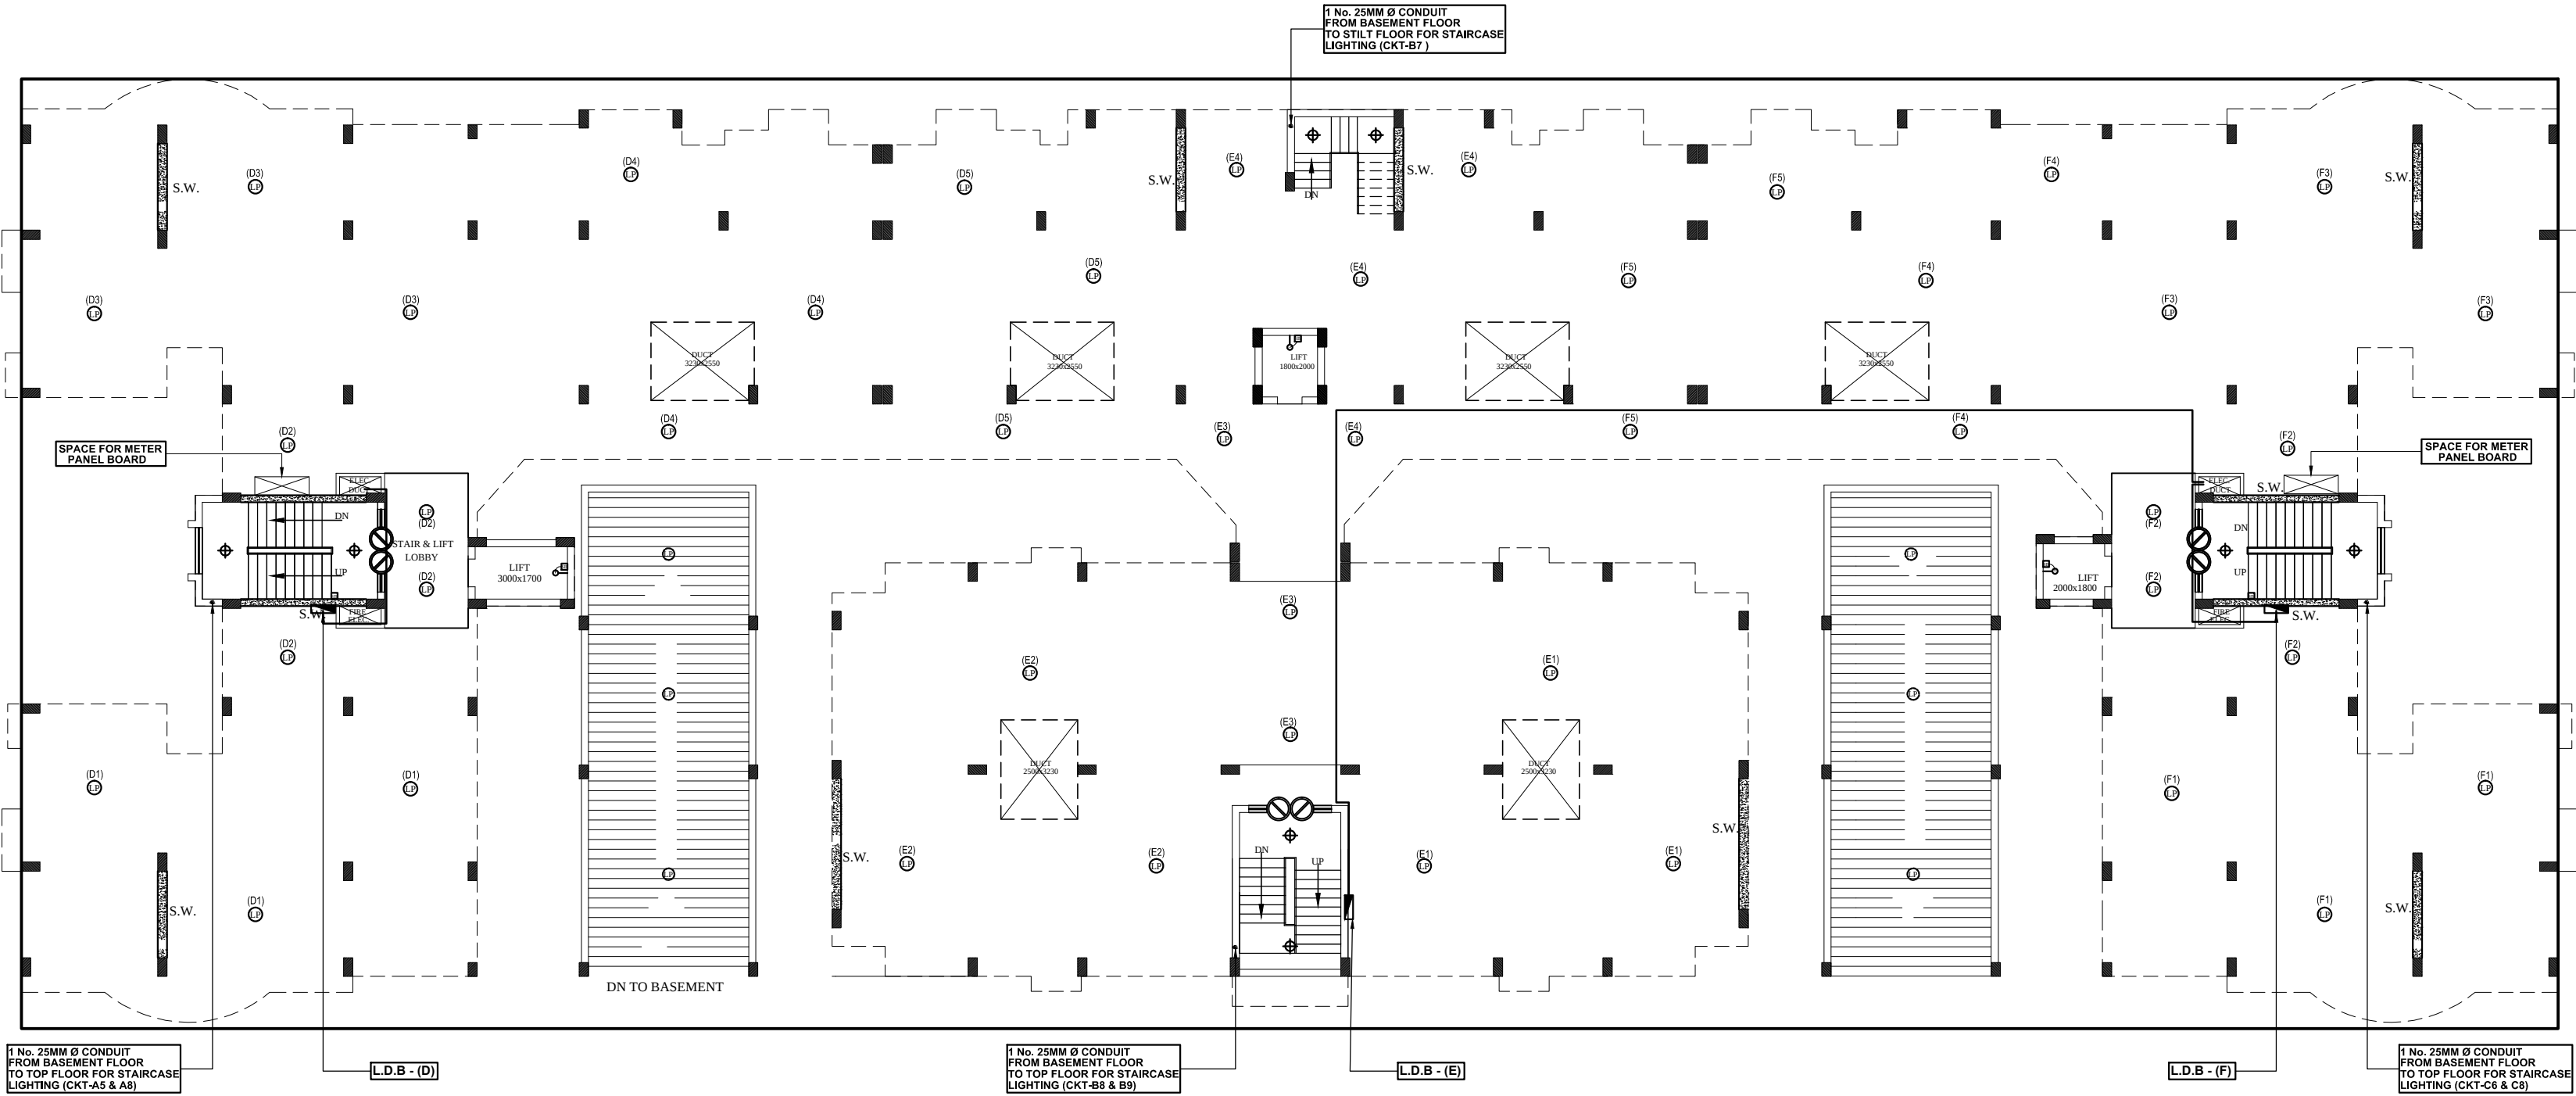


LEGEND:- (electrical)		
S.NO.	SYMBOL	DESCRIPTION
1		1x28W T5 TUBE LIGHT FIXTURE(SURFACE)
2		2x11W CFL TYPE CEILING LIGHT (SURFACE)
3		LIGHT POINT
4		BRACKET LIGHT
5		5/15 AMP POWER POINT
6		DISTRIBUTION BOARD
7		SWITCH BOARD
8		INDICATES CONTROLLING OF LIGHT/FAN FROM SWITCH BOARD
9		L.D.B. LIGHTING DISTRIBUTION BOARD
10		SUBMAIN CONDUIT FROM L.T. PANEL TO L.D.B./D.B.
11		
12		
13		

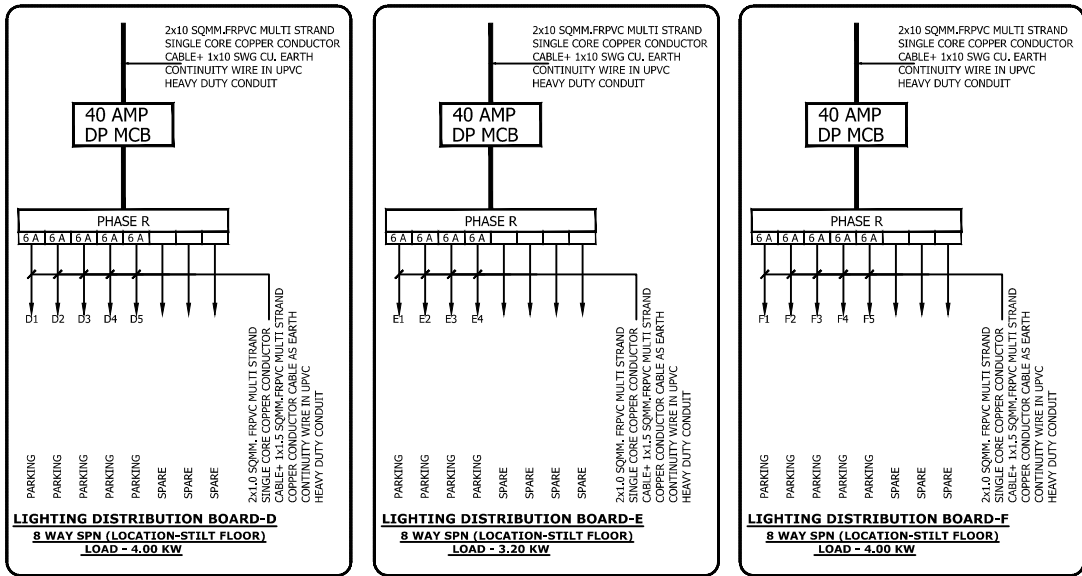

STILT FLOOR PLAN

PROJECT: PROPOSED RAJVANSH ESTATES PVT. LTD. KHASRA NO. - 1578 GRAM- AURANGABAD KHALSA WARD - RAJA BIJALI PASI LUCKNOW	CLIENT :-	PROJECT MANAGER:	ARCHITECTURAL CONSULTANTS :-	Services Consultant :-
DRG. TITLE:- STILT FLOOR PLAN (ELECTRICAL)	SUB. TITLE: BLOCK-C	SCALE: 1:100 DRN BY: JITENDRA DATE: DEC.-2013	DRG. NO.: BLOCK-C./SEE-02 CHECKED BY: O.P.SHAH	 SHAH & PANT CONSULTING ENGINEERS (P) LTD. AN ISO 9001-2008 COMPANY (Building Services Consultant, Soil & foundation Experts, Highway Engineering) 1, 4th Floor, HALWASIYA COURT, HAZRATGANJ, LUCKNOW (U.P.) Tele. No. : 0522-2230625, Fax : 0522-2230625, Cell : 9839013280, 9415027719 Email : shah_pant@yahoo.co.in, Web : www.shahpantconsultingengineers.com