


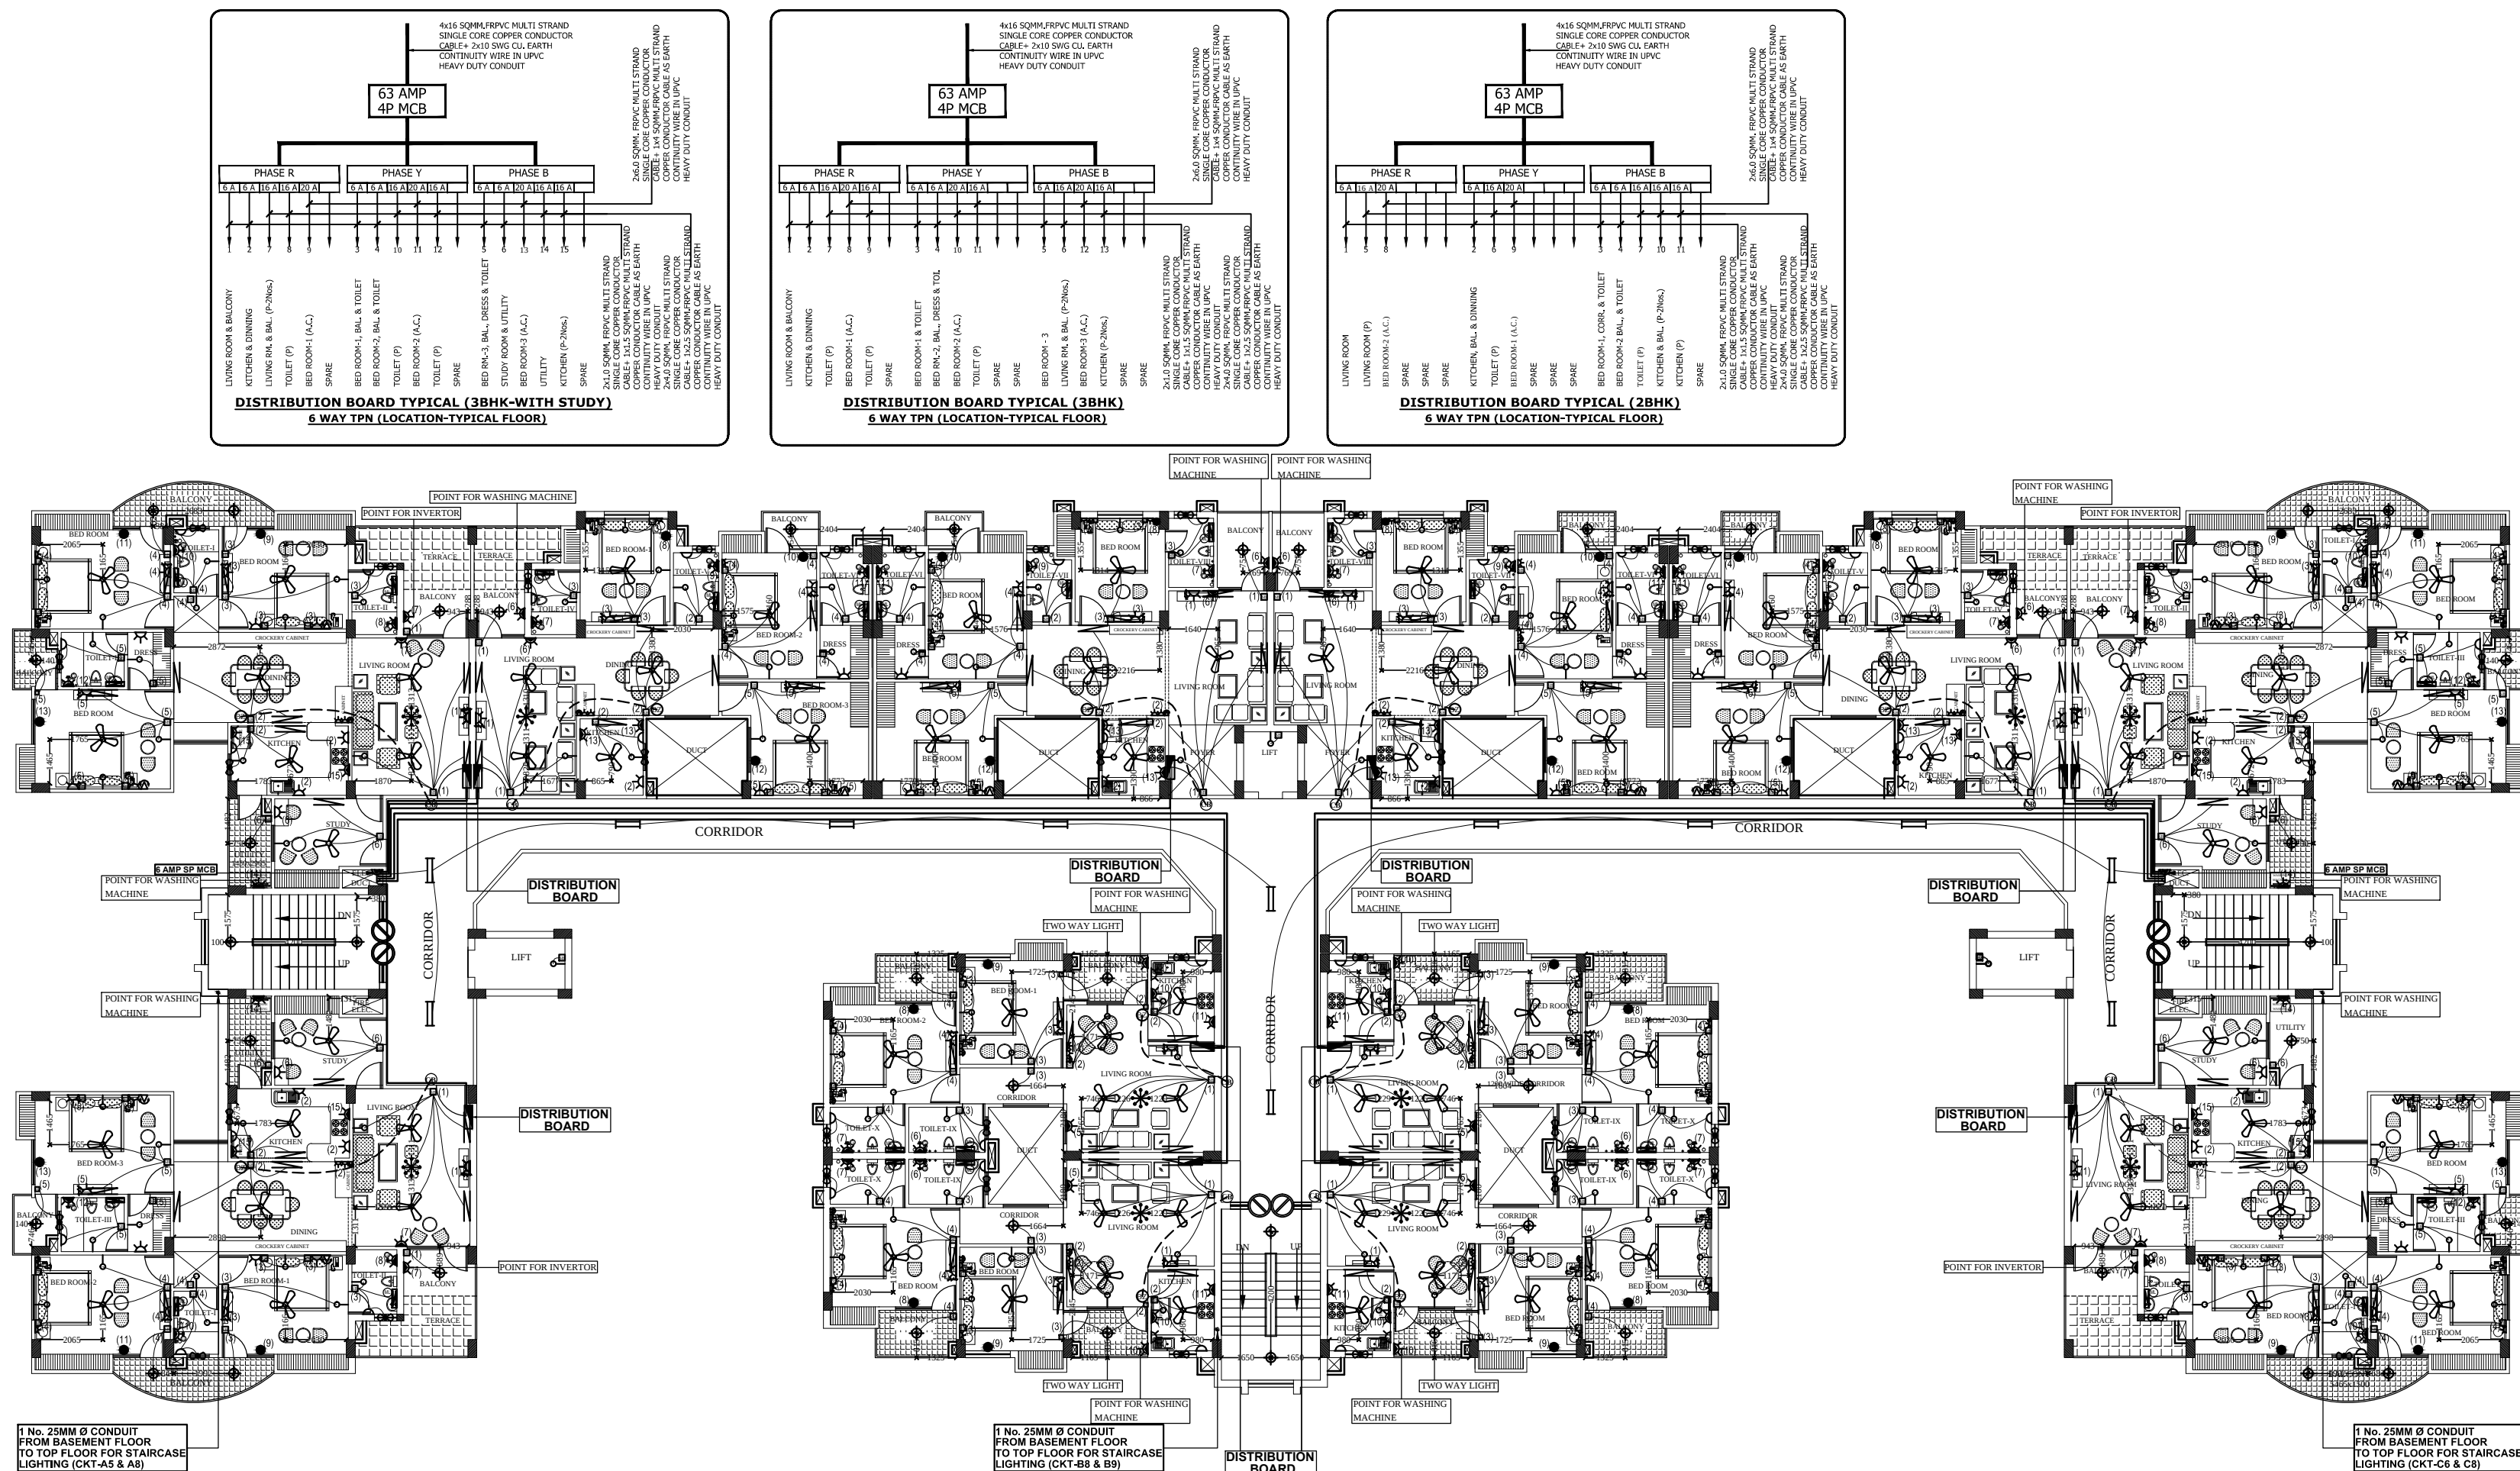

LEGEND- (electrical)			
S.NO	SYMBOL	DESCRIPTION	POSITION
1		1x40W FLUORESCENT TUBE LIGHT FIXTURE (SURFACE)	2550
2		1x40W FLUORESCENT TUBE LIGHT FIXTURE (CEILING)	ON CEILING
3		1x26W CFL WALL MOUNTED LIGHT FIXTURE	2550
4		2x11W CFL TYPE CEILING LIGHT	ON CEILING
5		MIRROR LIGHT	1850
6		SWITCH BOARD	1200
7		5-AMP PLUG POINT	200
8		5-AMP PLUG POINT	2250
9		5/15-AMP POWER POINT	200
10		5/15-AMP POWER POINT	1100 or 300 ABOVE PLATFORM
11		5/15-AMP POWER POINT FOR GYSER	SOCKET-1850 SWITCH-1100
12		T.V. ANTENNA POINT	200
13		6 AMP SP MCB	
14		20/32-AMP MCB(A.C.POINT)	200
15		CEILING FAN	ON CEILING
16		EXHAUST FAN	IN WIN/VEN.
17		TELEPHONE / INTERCOM SOCKET	200
18		CHANDELIER LIGHT	ON CEILING
19		CALL BELL	1200
20		BUZZAR	2400
21		INDICATES CONTROLLING OF LIGHT/FAN FROM SWITCH BOARD.	
22		DISTRIBUTION BOARD	1800 (TOP OF D.B.)
23		SUBMAIN CONDUIT FROM L.T. PANEL TO L.D.B./D.B.	
24		SUBMAIN CONDUIT FROM L.T. PANEL TO P.D.B.	

TYPICAL FLOOR PLAN

PROJECT: PROPOSED
RAJVANSH ESTATES PVT. LTD.
KHASRA NO. - 1578
GRAM- AURANGABAD KHALSA
WARD - RAJA BIJALI PASI LUCKNOW

DRG. TITLE:-

TYPICAL FLOOR PLAN
(ELECTRICAL)

CLIENT :-

SUB. TITLE:

BLOCK-C

PROJECT MANAGER:

SCALE:

1:100

DRN BY:

JITENDRA

DATE:

DEC.-2013

DRG. NO.:

BLOCK-C./SEE-03

CHECKED BY:

O.P.SHAH

ARCHITECTURAL CONSULTANTS :-

PUNIT SRIVASTAV
VASTULIPI
ARCHITECTS & INTERIOR DESIGNERS
5/171, VIRAM KHAND, GOMTI NAGAR
LUCKNOW
PH. NO.- 9415418151, 9935590999
email: vastulipi@gmail.com
website: www.vastulipi.com

Services Consultant :-

SHAH & PANT
CONSULTING ENGINEERS (P) LTD.
AN ISO 9001-2008 COMPANY
(Building Services Consultant, Soil & Foundation Experts, Highway Engineering)
1, 4th Floor, HALWASIYA COURT, HAZRATGANJ, LUCKNOW (U.P.)
Tele. No. : 0522-2230625, Fax : 0522-2230625, Cell : 9839013280, 9415027719
Email : shah_pant@yahoo.co.in, Web : www.shahpantconsultingengineers.com