

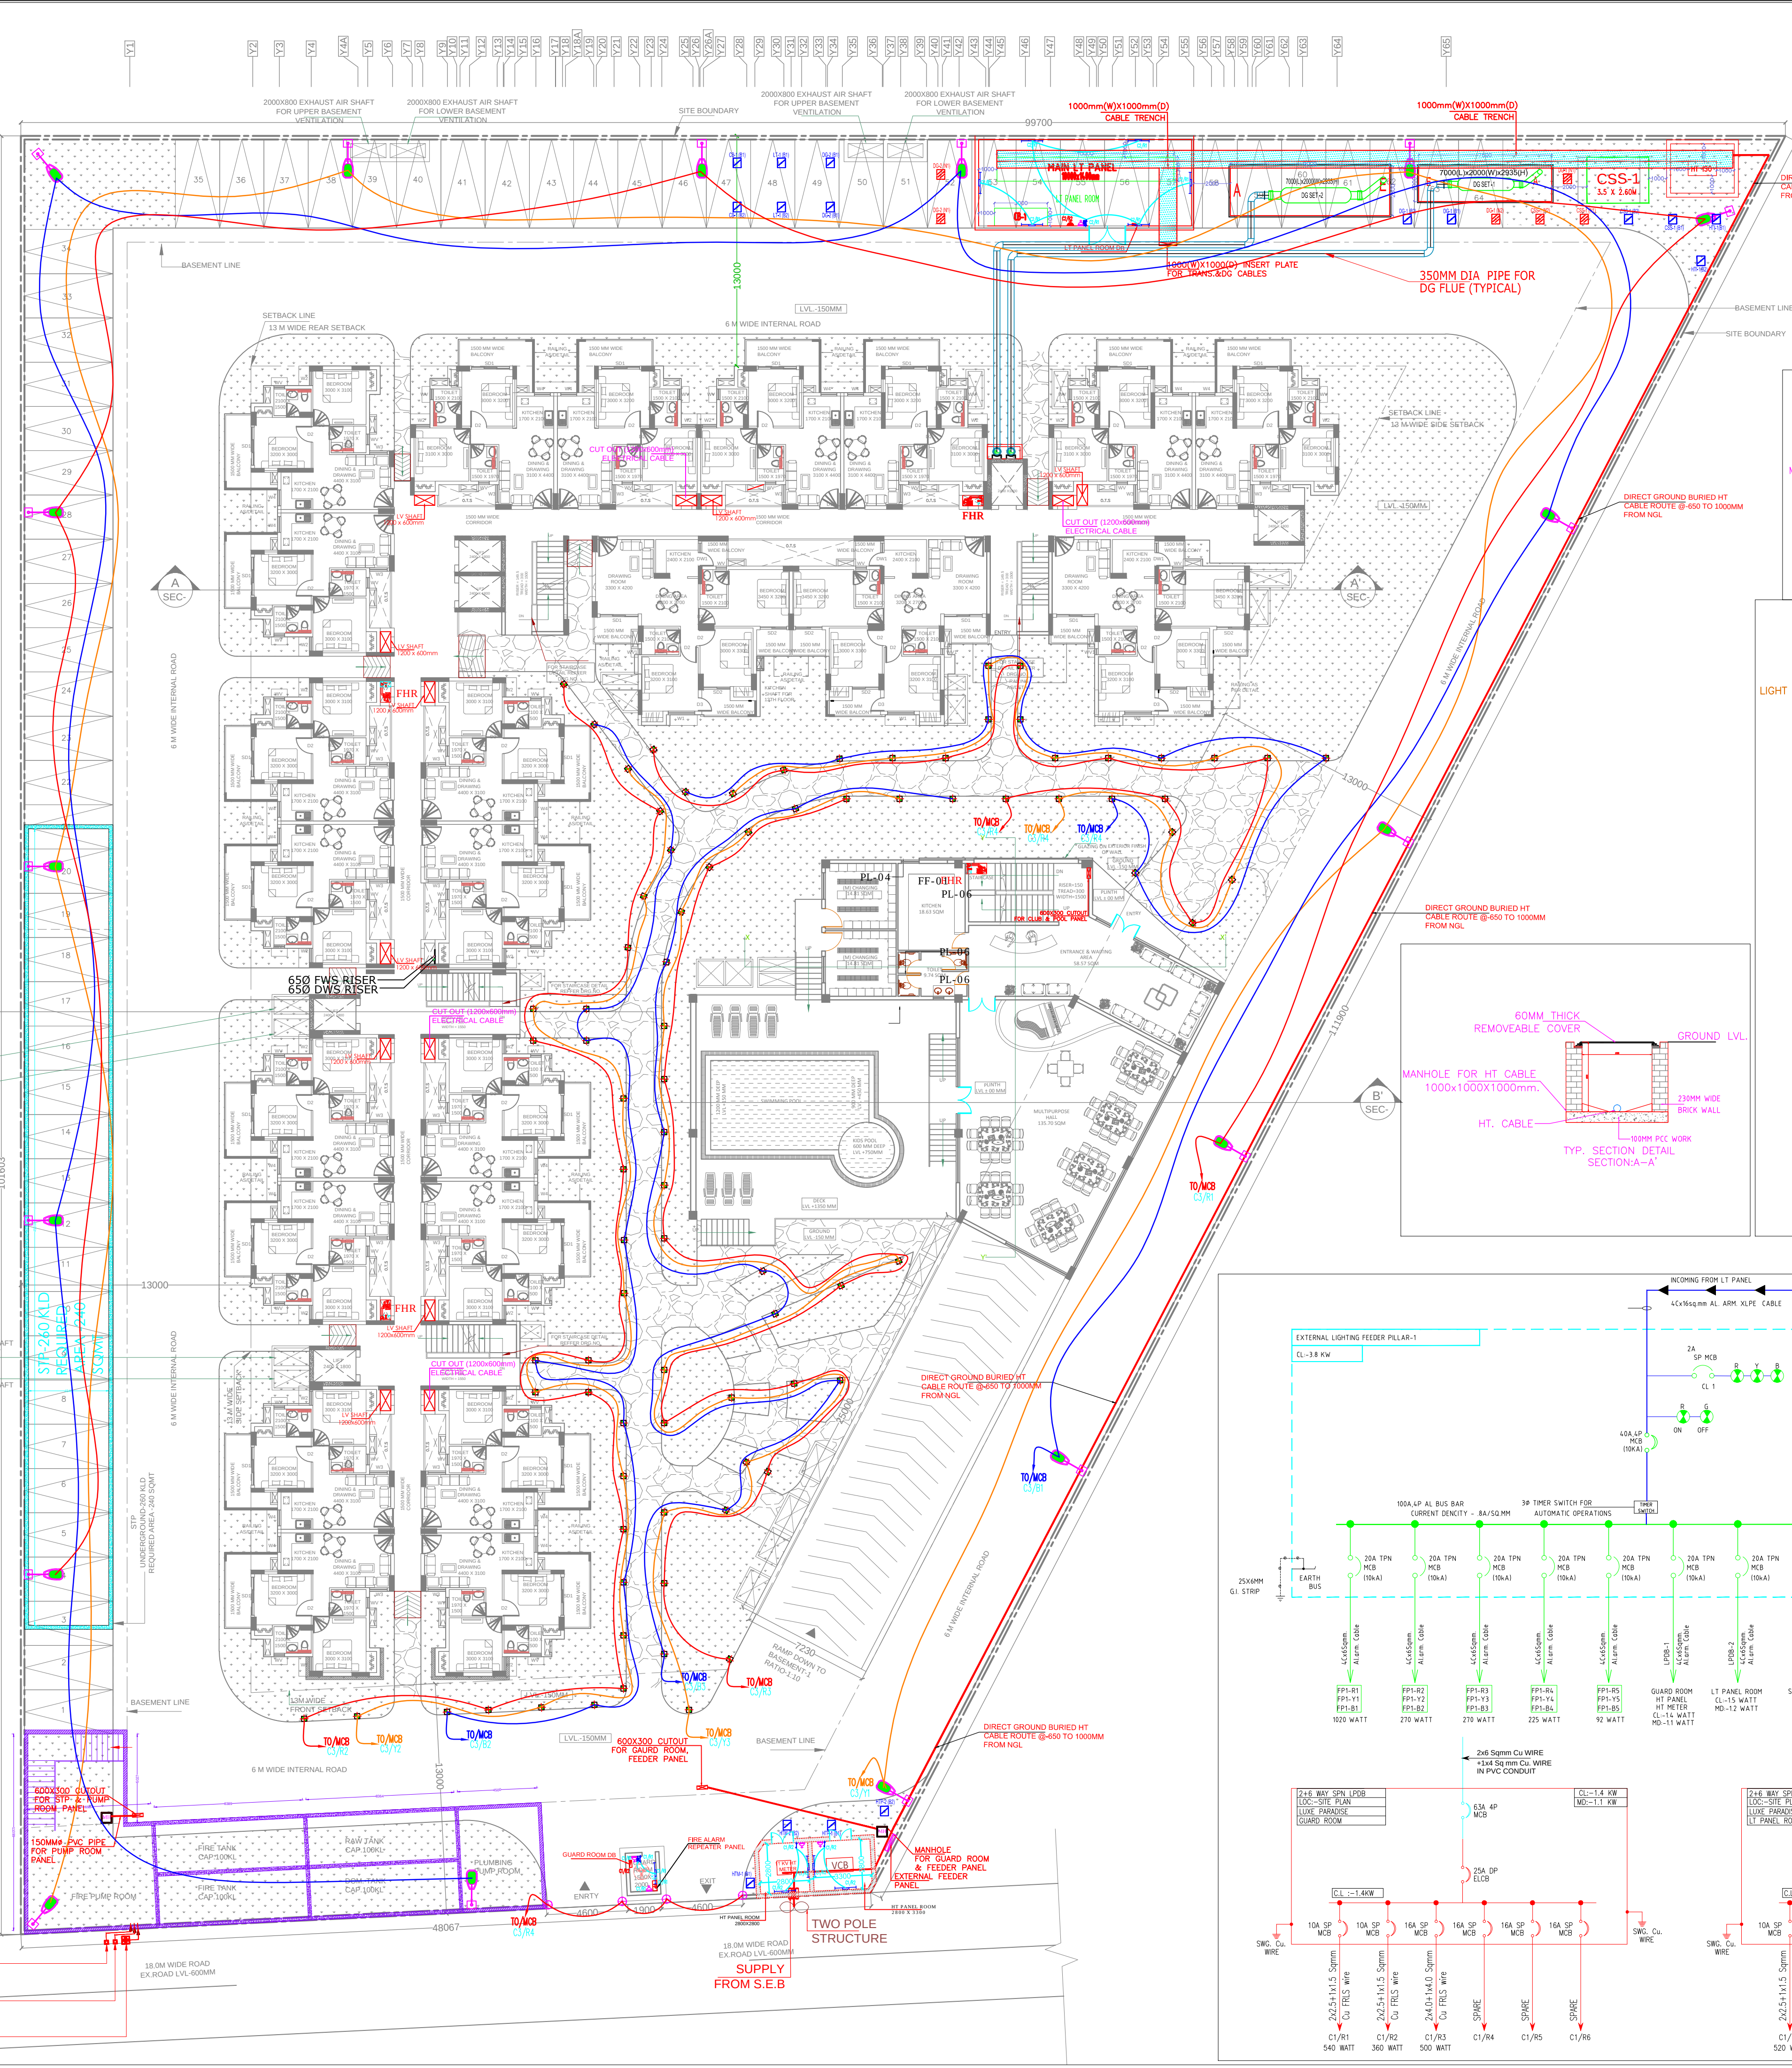
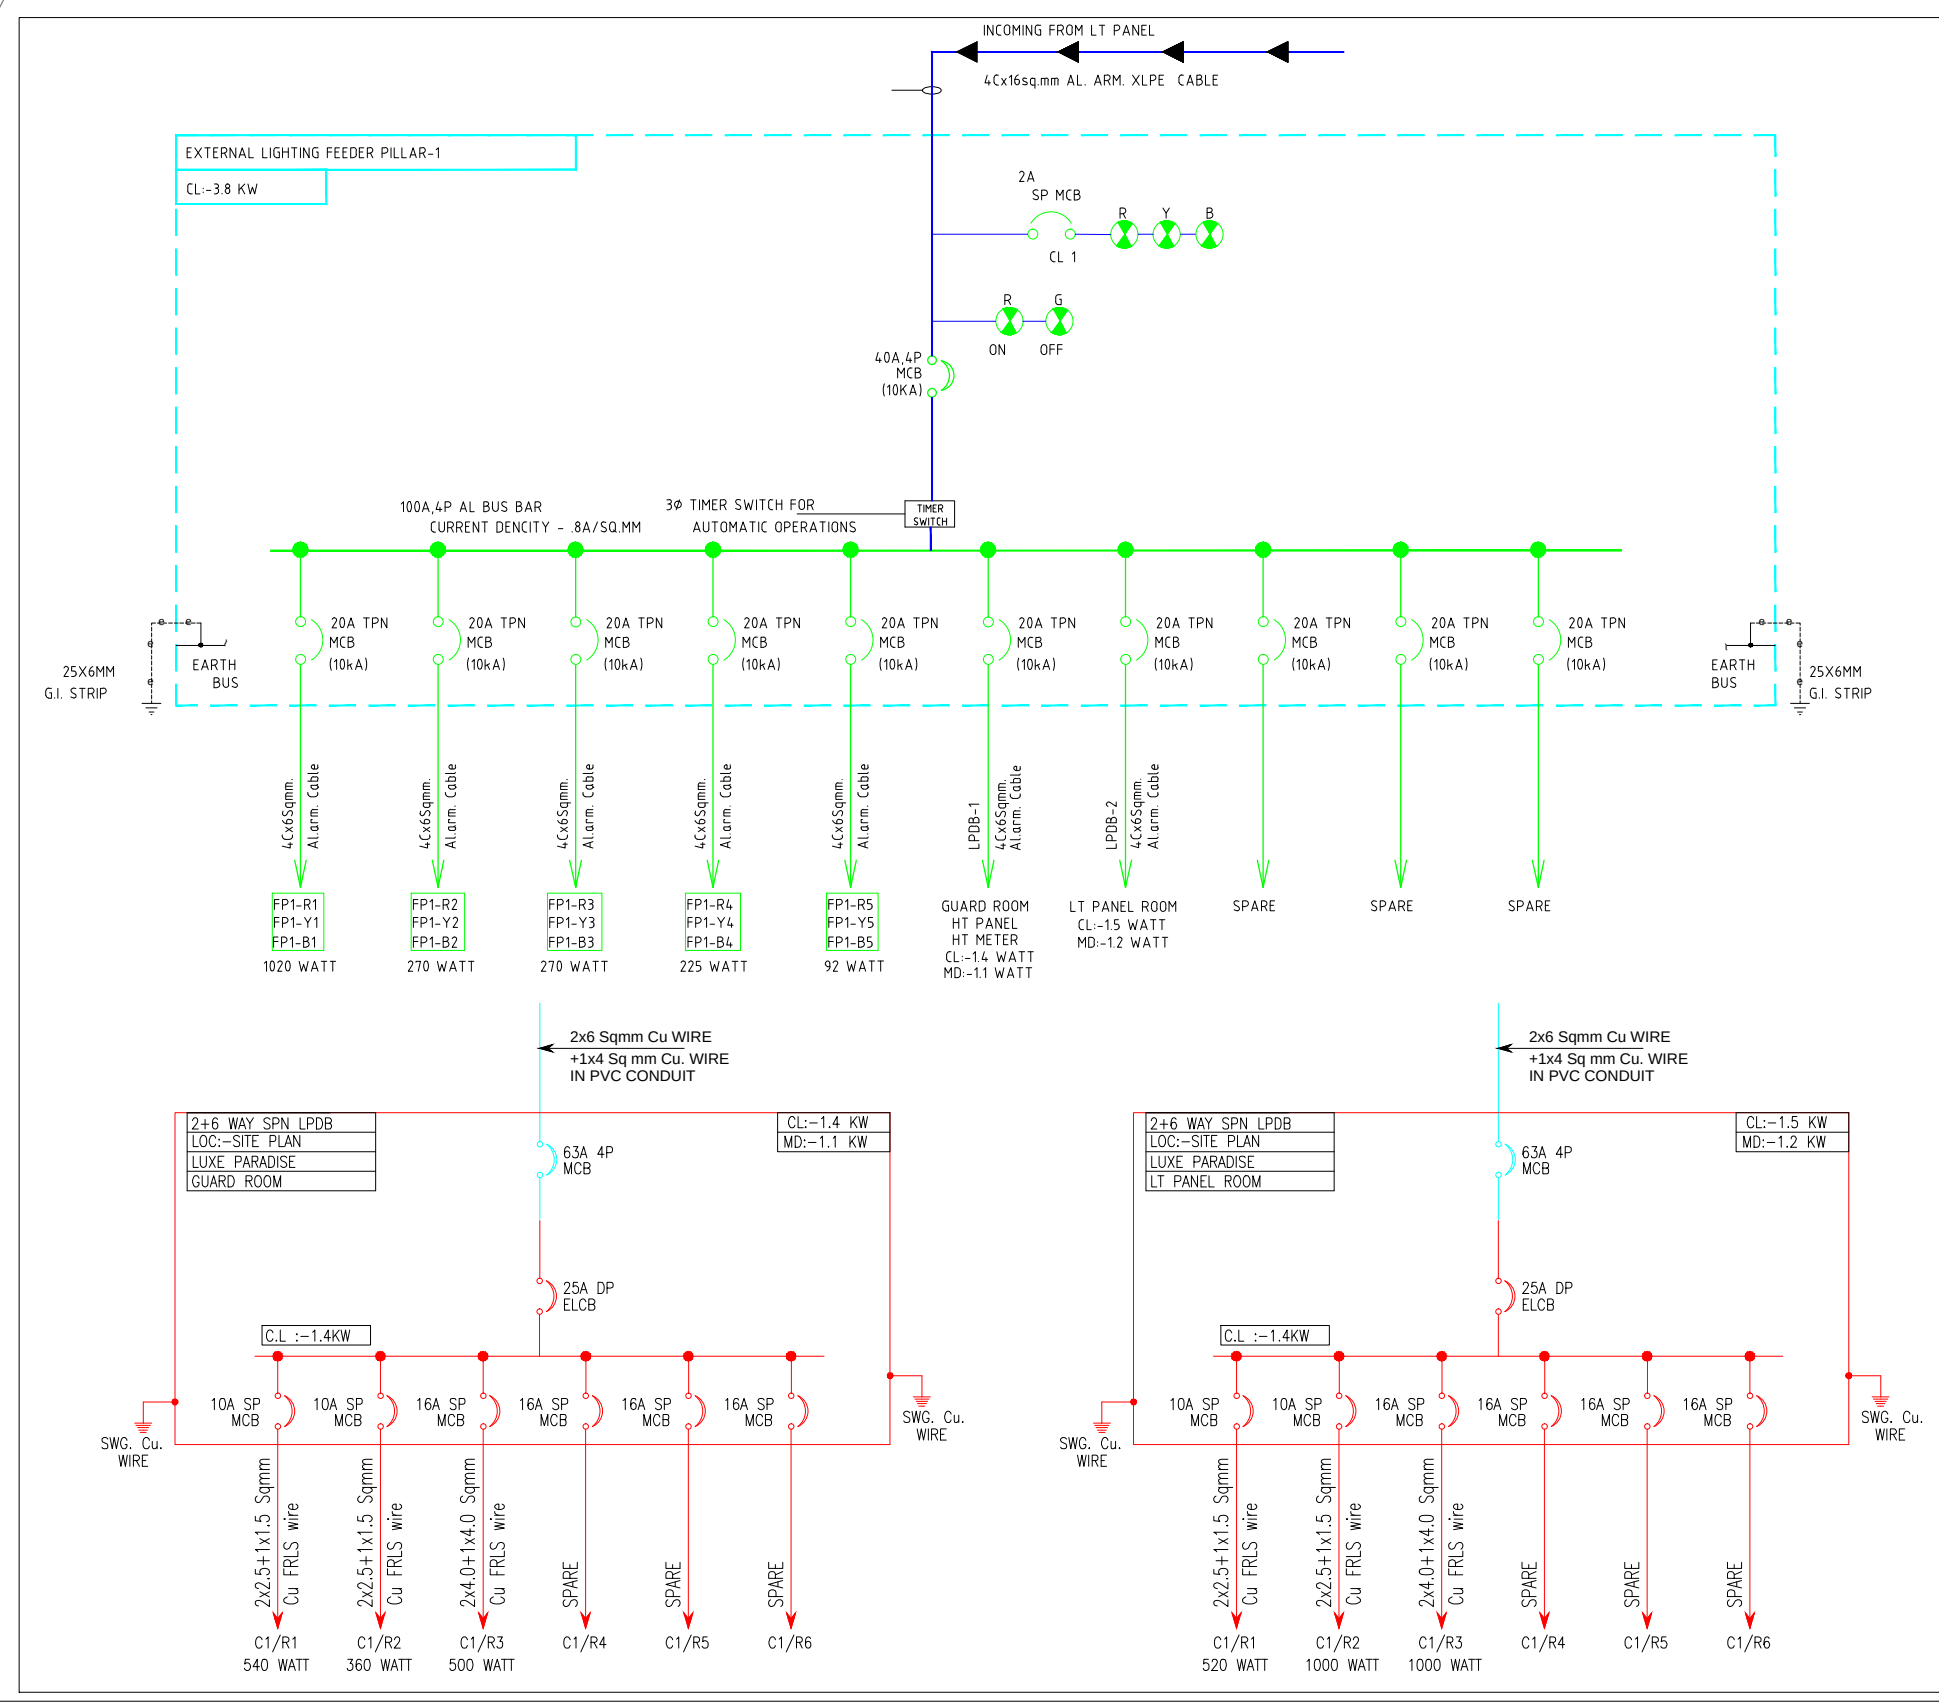


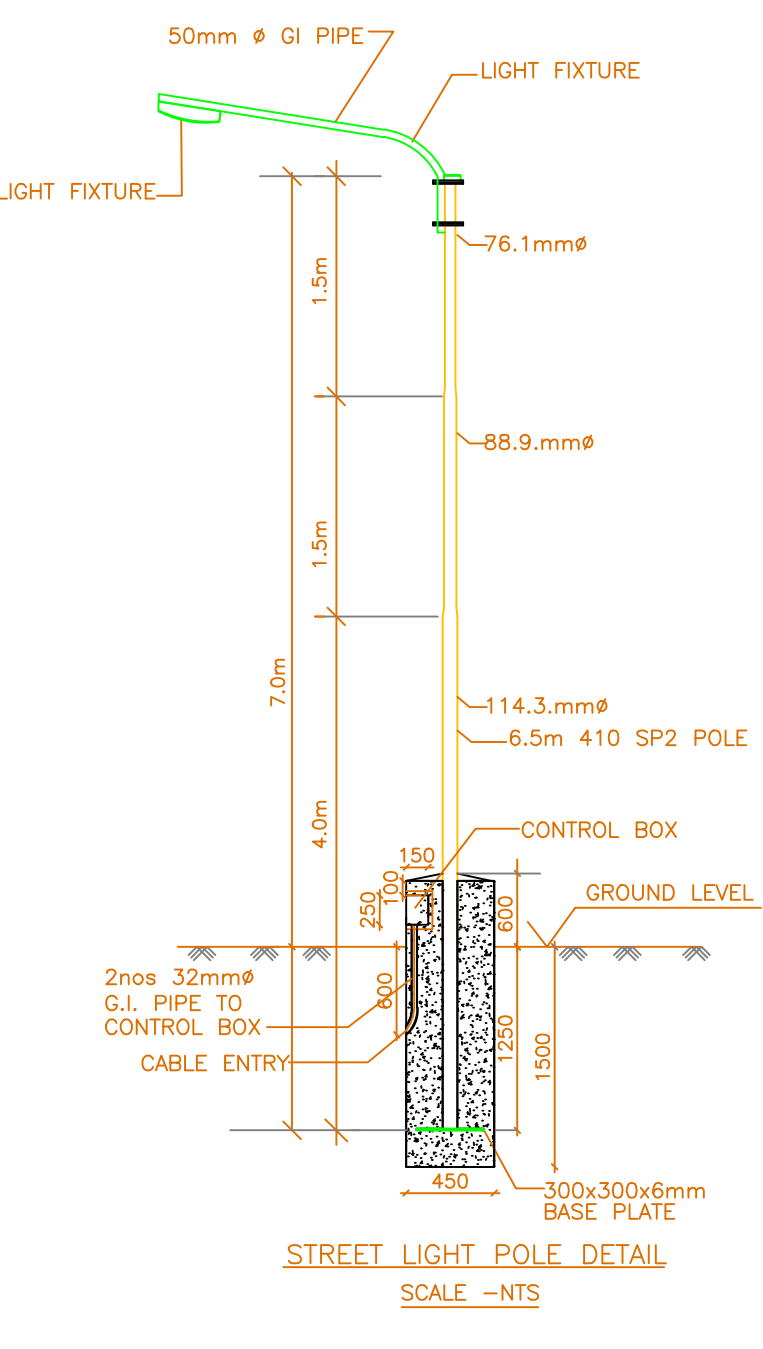

LEGEND :-	
SYMBOL	TYPE
	23W GATE LIGHT
	60W (7mt.) SINGLE ARM POLE
	9W (0.8mt.) BOLLARD LIGHT
	EXTERNAL LOOPING
	BODY EARTH PIT
	NEUTRAL EARTH PIT
	CABLE TRENCH
	BURIED CABLE

LEGEND :-		HEIGHT FROM FIN. FLR. LVL.
SYMBOL	TYPE	
	6A SWITCH BOARD (NORMAL)	1050mm FFL
	FAN REGULATOR	1050mm FFL
	6A LIGHT PLUG	200mm FFL
	6A LIGHT PLUG	1050mm FFL
	40W LED T5 LIGHT	2300mm FFL
	CEILING FAN	IN CEILING
	16AMP POWER POINT	200mm FFL
	TELEPHONE POINT	200mm FFL
	DISTRIBUTION BOARD	1550mm FFL

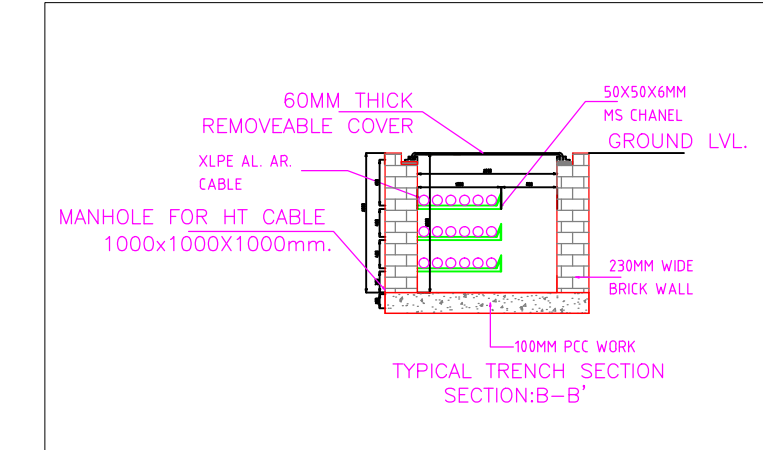

Rev. No.	Date	Description	Drawn	Checked
R-05	05-04-17	REVISED AS PER LATEST ARCH. DWG.	D.S.	S.K.
R-04	27-03-17	REVISED AS PER LATEST ARCH. DWG.	D.S.	S.K.
R-03	18-03-17	REVISED AS PER LATEST ARCH. DWG.	D.S.	S.K.
R-02	23-02-17	REVISED AS PER LATEST ARCH. DWG.	D.S.	S.K.
R-01	20-01-17	REVISED AS PER LATEST ARCH. DWG.	D.S.	S.K.
R-00	15-12-16	REVISED AS PER LATEST ARCH. DWG.	D.S.	S.K.

MEP CONSULTANT :-

SK.INNOVATION ENGINEERING PVT.LTD.

Address:-C-15 Ground Floor, Jaipuria Apartment, Seemant Vihar, Kaushambi(Ghaziabad)
MOB.NO.:-9650901083,8468001800,9718536912. email:- info@skiepl.com
web:-www.skiepl.com

ARCHITECTS :-

NEXUSPLUS CONSULTANTS PVT.LTD
B-116 2ND FLOOR,SECTOR 50,NOIDA

OWNER:-

SHOBHIK GOYAL

PROJECT:-

LUXE PARADISE AT TAJNAGRI, AGRA

DRAWING TITLE:-

ELETRICAL LAYOUT SITE PLAN

STATUS:-

TENDER DRAWING

DRAWN BY	ENGINEER	CHECKED BY
D.S.	S.Kumar	K.S.
PROJECT CODE		SHEET SIZE & SCALE
		A0 1/200
DRAWING NO.	DATE	REVISION NO
SK/SG/HG/EL/01	30/05/2017	R-05