


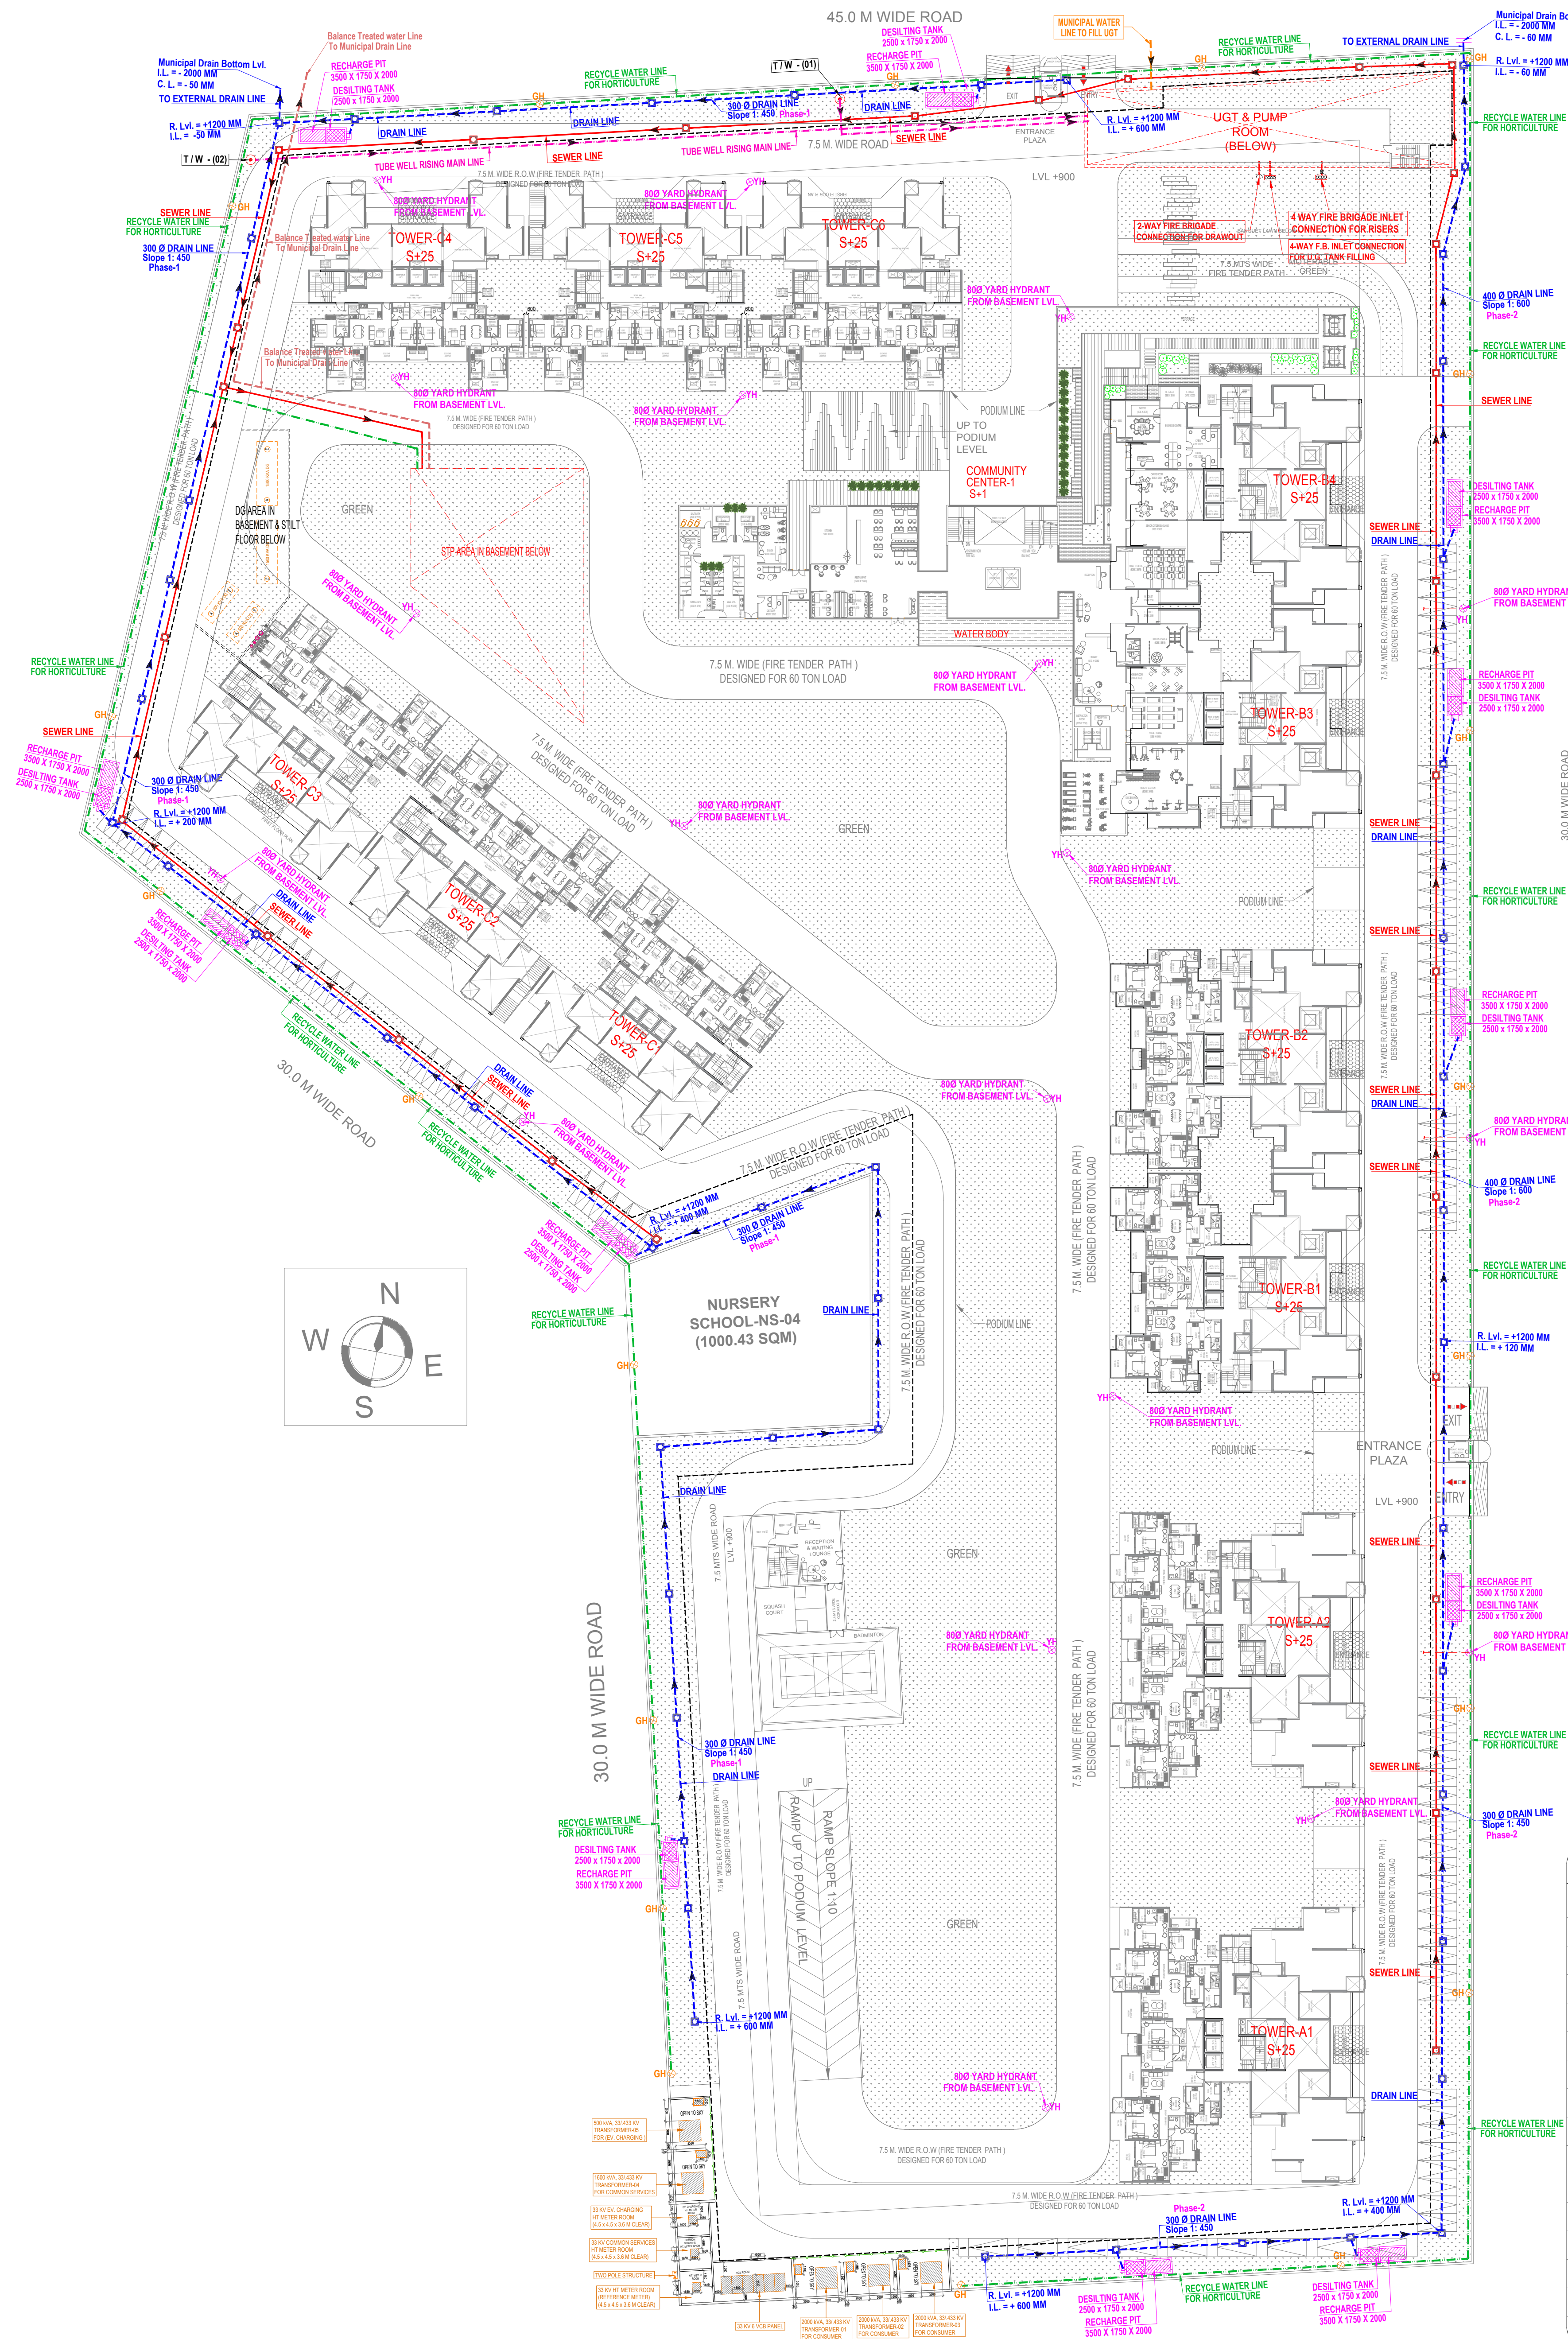

LEGEND :		
S. No.	SYMBOL	DESCRIPTION
1.	M.H.	MANHOLE
2.		SEWER LINE
3.		BYPASS SEWER LINE
4.	C.P.	CATCH PIT
5.		UNDER GROUND DRAIN
6.		RAIN WATER HARVESTING
7.		RECYCLED WATER SUPPLY PIPE LINE.
8.		RISING MAIN WATER PIPE LINE.
9.		MUNICIPAL WATER SUPPLY PIPE LINE.
10.		ISOLATING VALVE
11.		MASONRY CHAMBER FOR ISOLATING VALVE
12.		PROPOSED TUBE WELL
13.		BASEMENT LINE
14.	GH	GARDEN HYDRANT

LEGEND : FIRE SYSTEM		
S. No.	SYMBOL	DESCRIPTION
1.		FIRE LINE
2.	YH	YARD HYDRANT 63 M.M. DIA. SINGLE HEADED HYDRANT VALVE WITH 2 NOS. 15 M. LONG. 63 M.M. DIA. FIRE HOSE PIPE & 1 NO. BRANCH PIPE WITH NOZZLE
3.		FIRE BRIGADE CONNECTION
4.		BUTTERFLY VALVE
5.		NONRETURN VALVE (CHECK VALVE)
6.		ISOLATING VALVE WITH MASONRY CHAMBER

Project
PROPOSED GROUP HOUSING FOR
M/S AJAY REALCON INDIA LLP
AT PLOT NO. - P5 & P6, SECTOR - 22D
YAMUNA EXPRESS WAY, DISTRICT GAUTAM BUDDHA NAGAR (U.P.)

Title
DEVELOPMENT WORK SITE PLAN.
Subtitle
EXTERNAL COMBINED SERVICES

Drawing released for
☐ APPROVAL
☐ ADVANCE COPY
☒ SUBMISSION
☐ CONSTRUCTION

Drg. no.
ACE 11 / EX / S-05
Scale
1:500
Date
Sep. 2023

Drawn by
Kulwant
Designed by
R.K.
Checked by
Anand Havelia

Architects

B-421, N.F.C. Ph: +91-11-29218008
N.D-65, INDIA Ph: +91-11-45564768
architecture urban design
Member of IBCB
ISO - 9001 : 2000
interiors

Services Consultant
Consummate Engineering Services (P) Ltd.
Noida Office : B - 67, Sector - 67, Noida - 201 301
Tel : (0120) 6943500 (23 Lines)
Lko. Office : R 006, Rohtas Plumeria, Gomti Nagar, Lucknow
Tel : (0522) 4025902
e mail : mail@cespl.in, website : www.cespl.in