

SUBMISSION DRAWING

NORTH



SHEET NO.

LEGEND FOR SANITATION

- | | | |
|----|--------|---|
| 1. | F.T. | FLOOR TRAP WITH 150X150mm CUT OUT |
| 2. | F.D. | FLOOR DRAIN 150X150mm CUT OUT |
| 3. | U.T. | URINAL TRAP |
| 4. | (S.P.) | SOIL PIPE 110MMØ |
| 5. | (W.P.) | WASTE PIPE 110MMØ |
| 6. | C.O.P. | CLEAN OUT PLUG |
| 7. | P-TRAP | |
| 8. | | CUT OUT 100X100mm FOR WASH BASIN / URINAL |

LEGEND FOR PLUMBING

- | | | |
|-----|-----------|-----------------------|
| 1. | C.W.V. | COLD WATER VALVE |
| 2. | W.B. | WASH BASIN |
| 3. | B.T./H.F. | BIB TAP/HEALTH FAUCET |
| 4. | A.V. | ANGLE VALVE |
| 5. | B.V. | BALL VALVE |
| 6. | | COLD WATER SUPPLY |
| 7. | | FLUSHING WATER SUPPLY |
| 8. | S.F.V. | SENSOR FLUSH VALVE |
| 9. | | HOT WATER |
| 10. | | INDICATE RISE/DROP |

INTERNAL PLUMBING LAYOUT

PROJECT TITLE:

COMMERCIAL C9 AT EKANA SPORTZ CITY PVT.LTD

THIS IS TO CERTIFY THAT THIS BUILDING IS PROPOSED AS PER THE RULES & REGULATIONS OF MAHARAJA 2021.

SIGN OF LAND LORD.

SIGN OF ARCHITECT.




SCALE:- 1:200

DATE:- 16.09.2024

SHEET-A0



architectural consultant pvt. ltd.
architects, engineers, planner
landscape design, interior design, & value
Office:- 11th & 12th floor, Laxmi Vardan commercial complex at
patrakar puram crossing gomtinagar, lucknow,
Dist:- +91-522-2393123, 2394123, 4044123
Email id:- skyline@usahcc.com
ARCHITECTS :- SANJAY & VIJAY SINHA

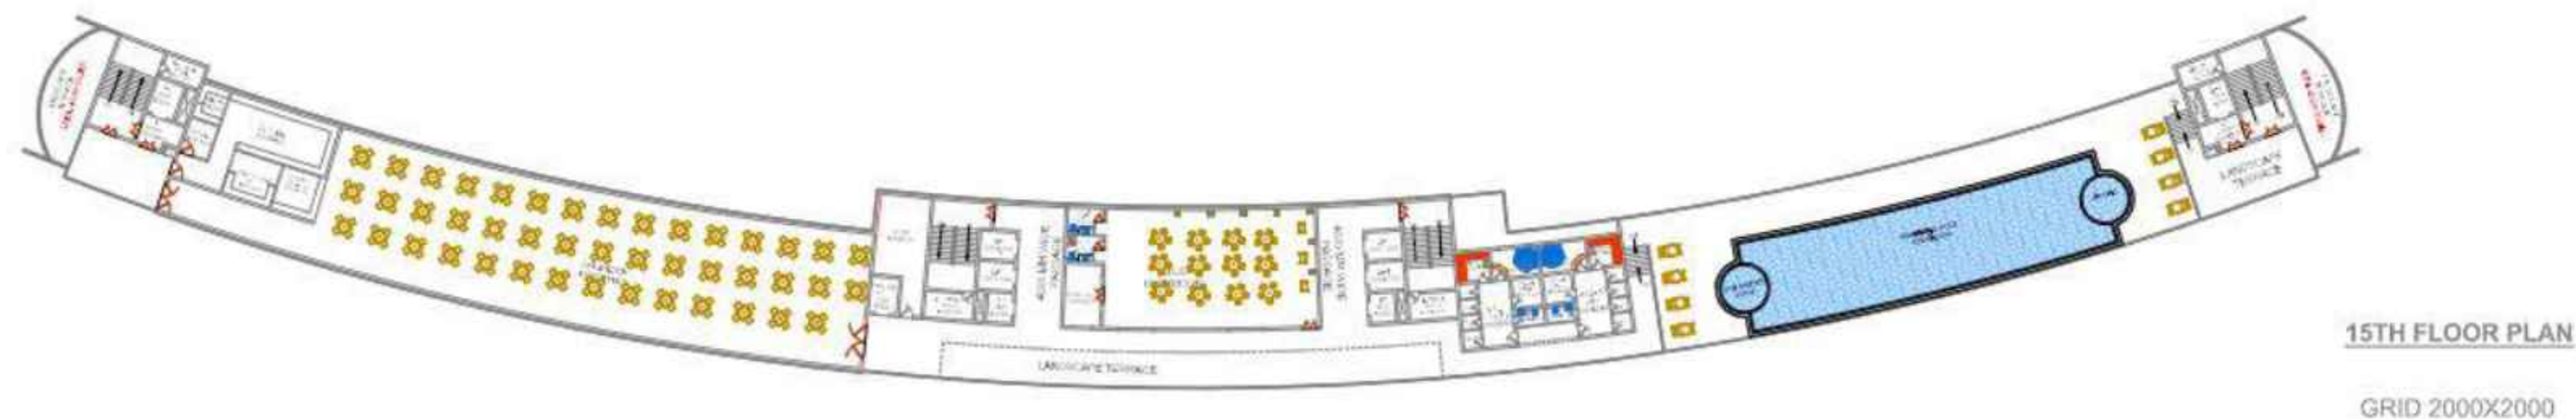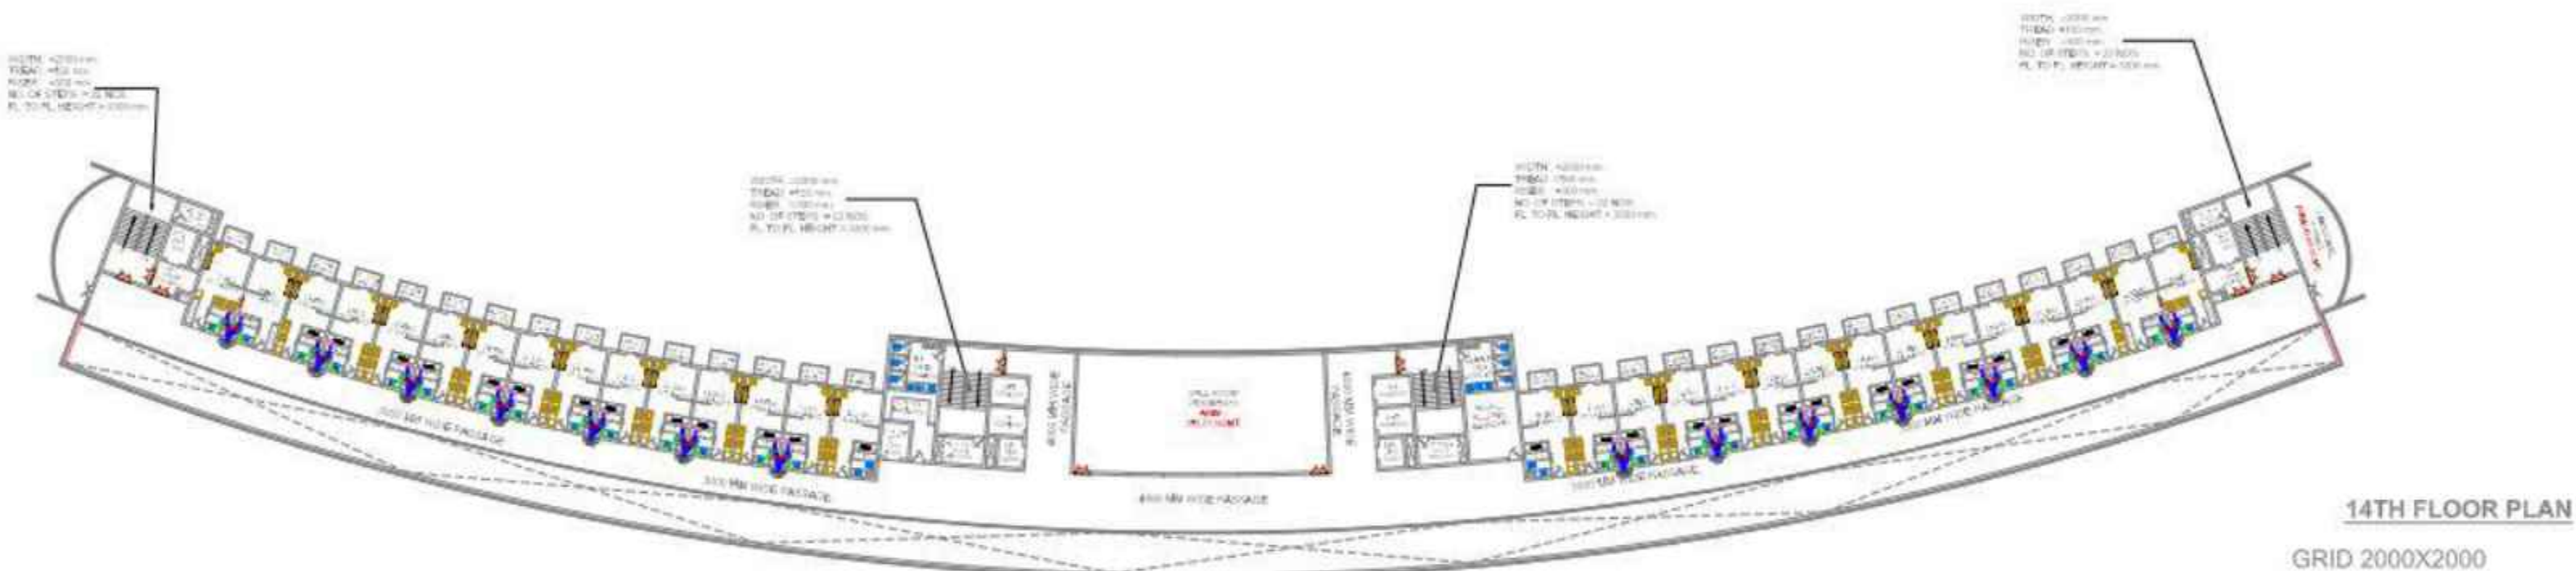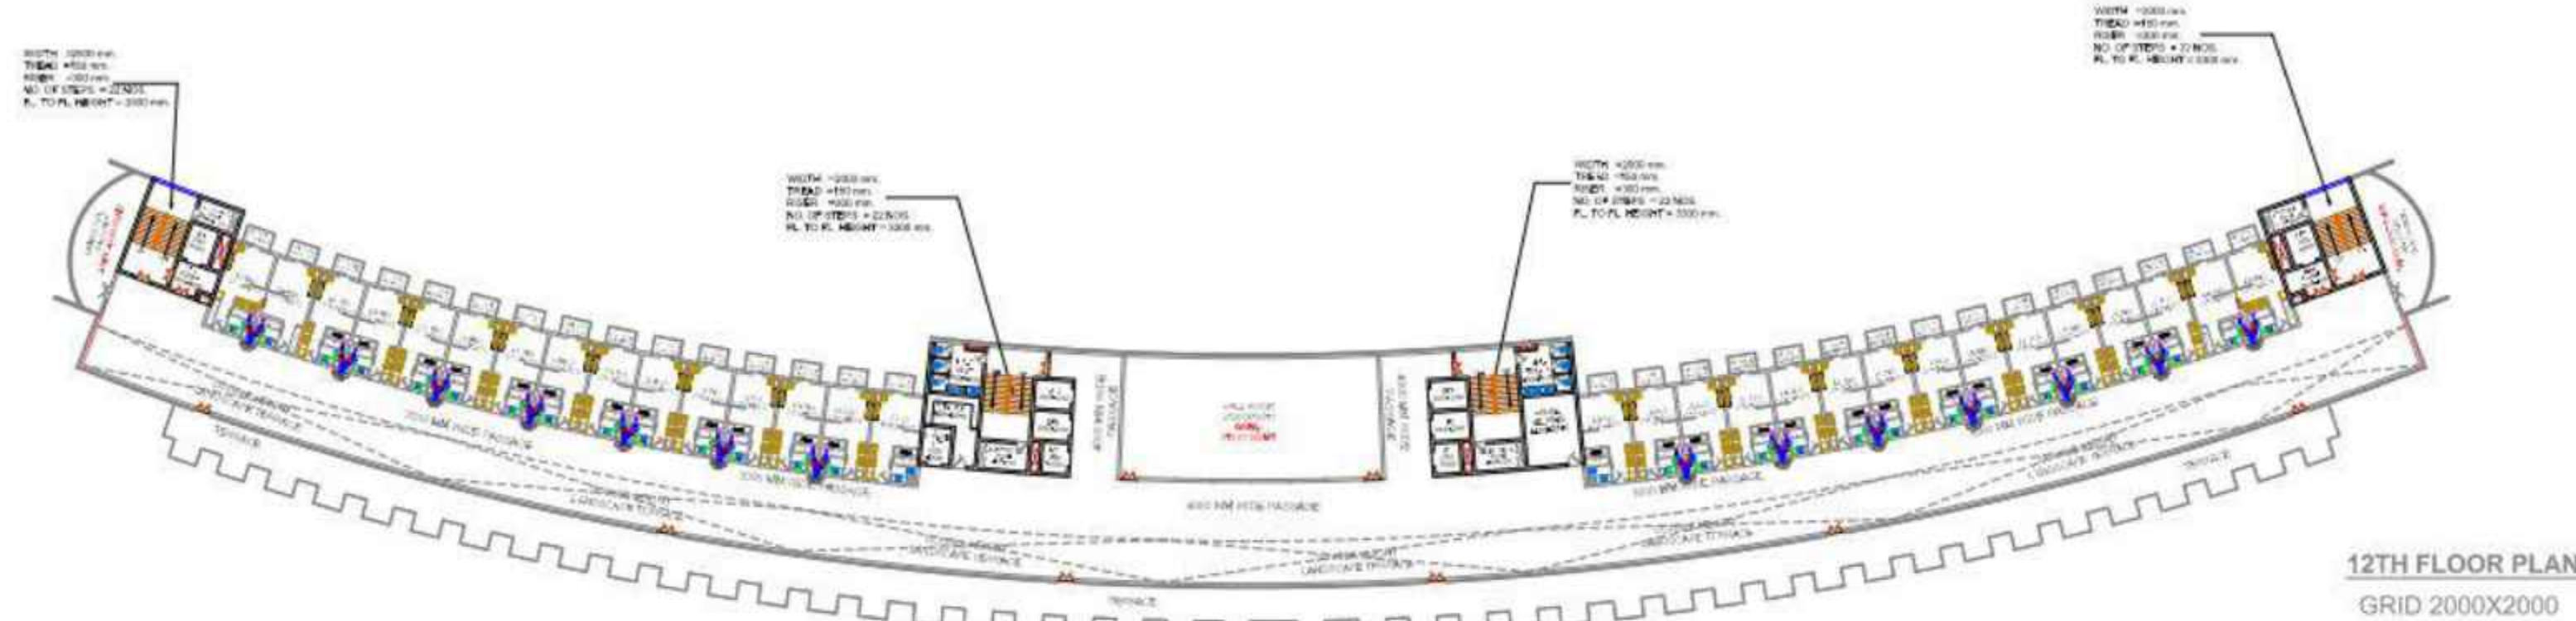

Legend For Vertical Pipes

- | | |
|---|--|
| 1 | 110Ø Soil Vent Pipe as per tender |
| 2 | 110Ø Waste Water/Vent Pipe as per tender |
| 3 | CWS DN. TAKE PIPE as per tender |
| 4 | FWS DN. TAKE PIPE as per tender |
| 5 | HWS DN. TAKE PIPE as per tender |

THIS DRAWING REPRESENTS ONLY A PLUMBING DETAIL FOR ARCHITECTURAL / STRUCTURAL AND OTHER SERVICES REFER RELEVANT DRAWINGS. PLEASE CO-ORDINATE THIS DRAWING WITH ALL OTHER RELEVANT DRAWINGS. F.T. MEANS DEEP SEAL 'P' TRAP WITH A PROVISION TO TAKE THE TRAP FITTINGS FOR CONNECTION TO WASHBASIN & SINK ETC. AS REQUIRED. LOCATION OF FLOOR TRAPS GIVEN IN THE DRAWINGS MAY CHANGE (L.S.) PER CONSTRUCTION AND ARCHITECTURAL REQUIREMENTS. TUBES IN THE TOILET SHALL BE KEPT CENTRALLY TOWARDS THE FLOOR TRAP FOR WATER SUPPLY DOWN TAKE PIPE REFER TERRACE PLUMBING DIAGRAM FOR INVERT LEVEL OF SHAWHOLE & OR REFER EXTERNAL SEWERAGE & DRAINAGE

NOTES:
1. ALL VERTICAL PIPES SHALL BE SUPPLY PROVIDED, VERTICAL AND SERVICE LEVEL PIPES SHALL BE USED AS PER SPECIFICATION.
2. ALL OF FITTINGS ARE AS PER SPECIFICATION AND SHALL BE USED AS PER SPECIFICATION.
3. ALL OF FITTINGS ARE AS PER SPECIFICATION AND SHALL BE USED AS PER SPECIFICATION.
4. THIS DRAWING SHALL BE READ IN CONJUNCTION WITH RELEVANT ARCHITECTURAL DRAWINGS.
5. EXISTING WASH BASIN, TOILET, SINK, URINAL, SINKING AND EXISTING DRAINAGE.
6. THIS DRAWING SHALL NOT BE USED FOR ANY OTHER PURPOSES WITHOUT THE WRITTEN PERMISSION OF THE ARCHITECT.
7. ALL PIPES SHALL BE PROVIDED TESTED AS PER TOWARDS PRACTICE AND ALL DETAILS SHALL BE PROVIDED.

SUBMISSION DRAWING

NORTH

SHEET NO.



LEGEND FOR SANITATION

1.	F.T.	FLOOR TRAP WITH 150X150mm CUT OUT
2.	F.D.	FLOOR DRAIN 150X150mm CUT OUT
3.	U.T.	URINAL TRAP
4.	(S.P.)	SOIL PIPE 110MMØ
5.	(W.P.)	WASTE PIPE 110MMØ
6.	C.O.P.	CLEAN OUT PLUG
7.	P-TRAP	P-TRAP
8.		CUT OUT 100X100mm FOR WASH BASIN / URINAL

LEGEND FOR PLUMBING

1.	C.W.V.	COLD WATER VALVE
2.	W.B.	WASH BASIN
3.	B.T./H.F.	BIB TAP/HEALTH FAUCET
4.	A.V.	ANGLE VALVE
5.	B.V.	BALL VALVE
6.		COLD WATER SUPPLY
7.		FLUSHING WATER SUPPLY
8.	S.F.V.	SENSOR FLUSH VALVE
9.		HOT WATER
10.		INDICATE RISE/DROP

INTERNAL PLUMBING LAYOUT

COMMERCIAL C9 AT EKANA SPORTZ CITY PVT.LTD


THIS IS TO CERTIFY THAT THIS BUILDING IS PROPOSED AS PER THE RULES & REGULATIONS OF MAHARASHTRA 2021.

SIGN OF ARCHITECT.

DATE:- 16.09.2024



architectural consultant pvt. ltd.
architects, engineers, planner
landscape design, interior design, & valuer
Office:- 1st & 11th floor laxmi vardan commercial complex at
patrakar puram crossing gomtinagar, lucknow,
Dial :- +91-522-2393123, 2394123, 4044123
Email id:- skyline@usahcc.com
ARCHITECTS :- SANJAY & VIJAY SINHA

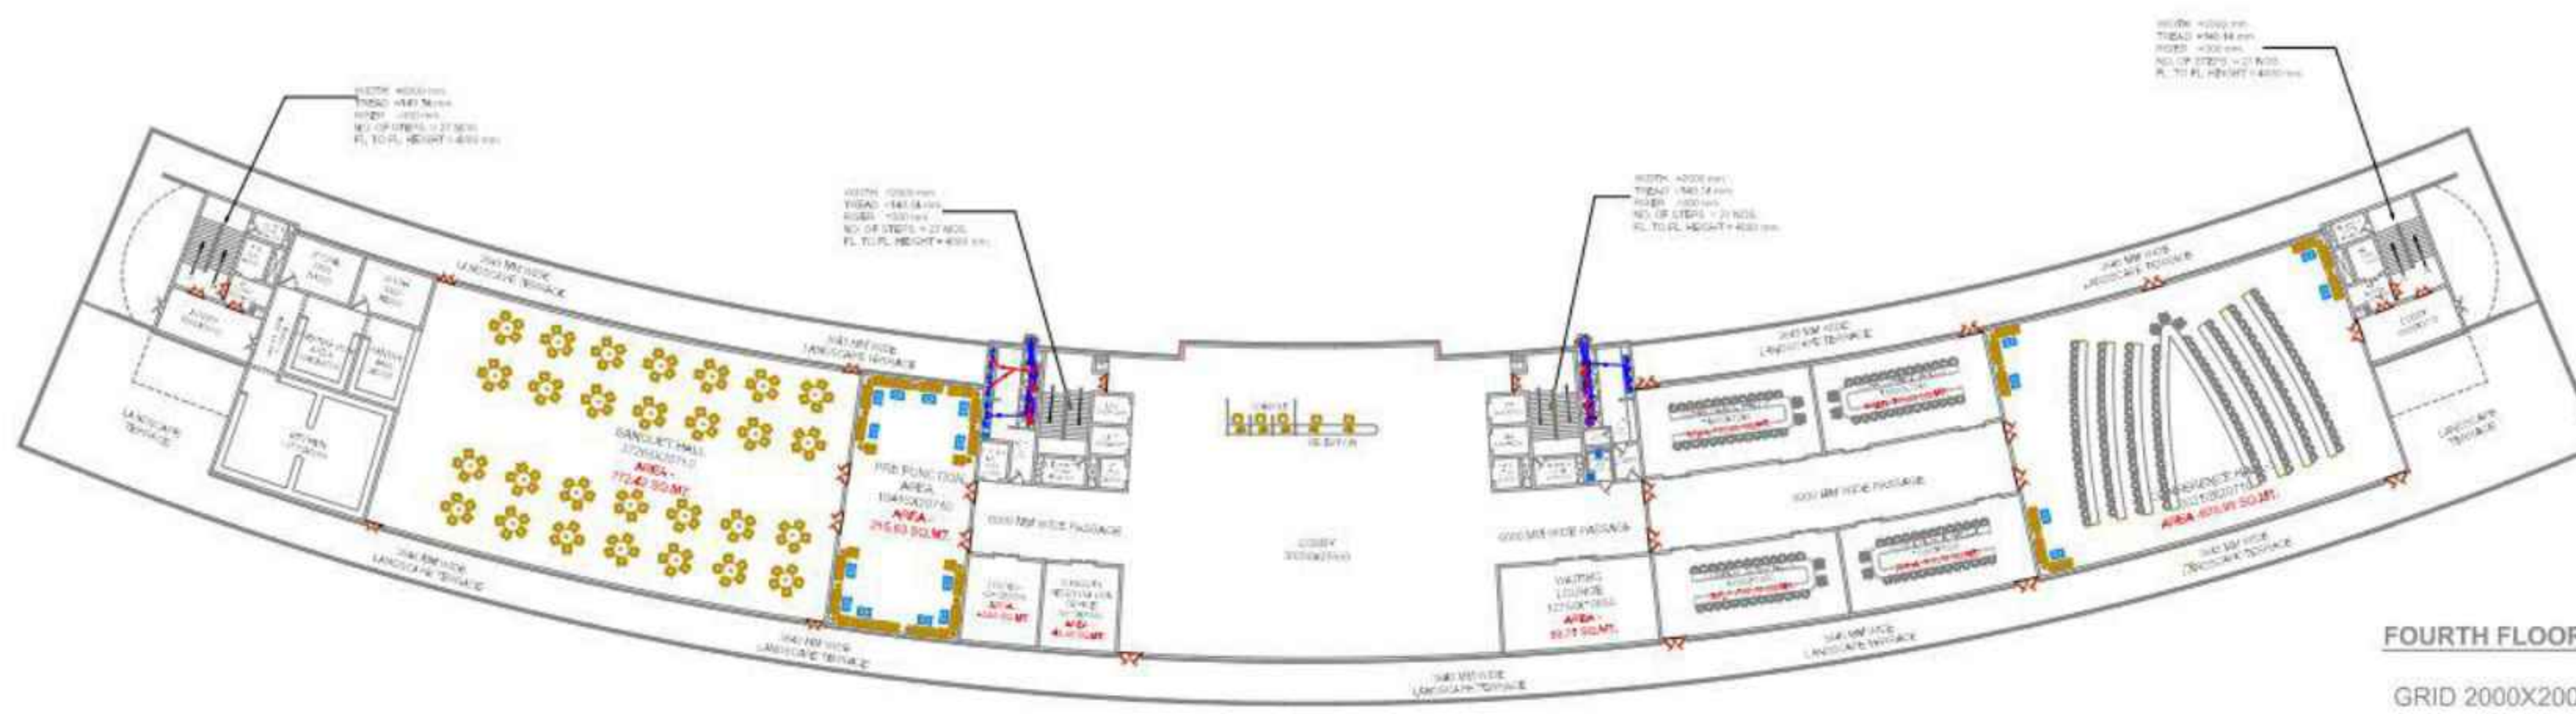

Legend For Vertical Pipes

- 110Ø Soil Vent Pipe as per tender
- 110Ø Waste Water/Vent Pipe as per tender
- CWS DN. TAKE PIPE as per tender
- FWS DN. TAKE PIPE as per tender
- HWS DN. TAKE PIPE as per tender

THIS DRAWING REPRESENTS ONLY A PLUMBING DETAIL, FOR ARCHITECTURAL / STRUCTURAL AND OTHER SERVICES REFER RELEVANT DRAWINGS.
PLEASE CO-ORDINATE THIS DRAWING WITH ALL OTHER RELEVANT DRAWINGS.
F.T. MEANS DEEP SEAL 'P' TRAP WITH A PROVISION TO TAKE THE INLET FITTINGS FOR CONNECTION TO WASHBASIN & SINK ETC AS REQUIRED.
LOCATION OF FLOOR TRAPS GIVEN IN THE DRAWINGS MAY CHANGE ILLAS PER CONDITION AND ARCHITECTURAL REQUIREMENTS.
SLOPS IN THE TOILET SHALL BE KEPT GENERALLY TOWARDS THE FLOOR TRAP FOR WATER SUPPLY DOWN TAKE PIPE REFER TERRACE PLUMBING DIAGRAM.
FOR RISE/LEVEL OF MANHOLE & OR REFER EXTERNAL SEWERAGE & DRAINAGE

1. ALL INTERNAL FRESH WATER SUPPLY, FRESH, VERTICAL AND TERRACE LEVEL PIPES SHALL BE USED AS PER SPECIFICATION.
2. ALL OF FITTINGS LIKE ANGLE VALVES, BALL VALVES, AND TAPS SHALL BE FIXED WITH WALL PLUGS AT THE CORNER OF TUBS OR AS SHOWN IN EXTERNAL ARCHITECTURAL DRAWINGS.
3. THIS DRAWING SHALL BE READ IN CONJUNCTION WITH RELEVANT ARCHITECTURAL, DRAINAGE, EXTERNAL WATER SUPPLY, TERRACE LEVEL WATER FLOWING AND EXTERNAL TERRACE DRAINAGE.
4. THIS DRAWING SHALL NOT BE SCALED AND NOTED OTHERWISE TO BE FOLLOWED.
5. ALL PIPES SHALL BE PROPERLY SLOPED AS PER COMPANY PRACTICE AND ALL DEFECTS SHALL BE RECTIFIED.

SUBMISSION DRAWING

NORTH



SHEET NO.

2

LEGEND FOR SANITATION

- | | | |
|----|---|-----------------------------------|
| 1. | F.T. | FLOOR TRAP WITH 150X150mm CUT OUT |
| 2. | F.D. | FLOOR DRAIN 150X150mm CUT OUT |
| 3. | U.T. | URINAL TRAP |
| 4. | (S.P.) | SOIL PIPE 110MMØ |
| 5. | (W.P.) | WASTE PIPE 110MMØ |
| 6. | C.O.P. | CLEAN OUT PLUG |
| 7. | P-TRAP | P-TRAP |
| 8. | CUT OUT 100X100mm FOR WASH BASIN / URINAL | |

LEGEND FOR PLUMBING

- | | | |
|-----|----------|-----------------------|
| 1. | C.W.V. | COLD WATER VALVE |
| 2. | W.B. | WASH BASIN |
| 3. | B.T./H.F | BIB TAP/HEALTH FAUCET |
| 4. | A.V. | ANGLE VALVE |
| 5. | B.V. | BALL VALVE |
| 6. | | COLD WATER SUPPLY |
| 7. | | FLUSHING WATER SUPPLY |
| 8. | S.F.V. | SENSOR FLUSH VALVE |
| 9. | | HOT WATER |
| 10. | | INDICATE RISE/DROP |

INTERNAL PLUMBING LAYOUT

PROJECT TITLE:

COMMERCIAL C9 AT EKANA SPORTZ CITY PVT.LTD

THIS IS TO CERTIFY THAT THIS BUILDING IS PROPOSED AS PER THE RULES & REGULATIONS OF MAHARASHTRA 2021.

SIGN OF LAND LORD.


SIGN OF ARCHITECT.

SCALE:- 1:200
SHEET-A0


DATE:- 16.09.2024



architectural consultant pvt. ltd.
architects, engineers, planner
landscape design, interior design, & valuer
Office:- 1st & 2nd floor laxmi vardan commercial complex at
patrakar puram crossing gomtinagar, lucknow,
Dial :- +91-522-2393123, 2394123, 4044123
Email Id:- skyline@usahcc.com
ARCHITECTS :- SANJAY & VIJAY SINHA

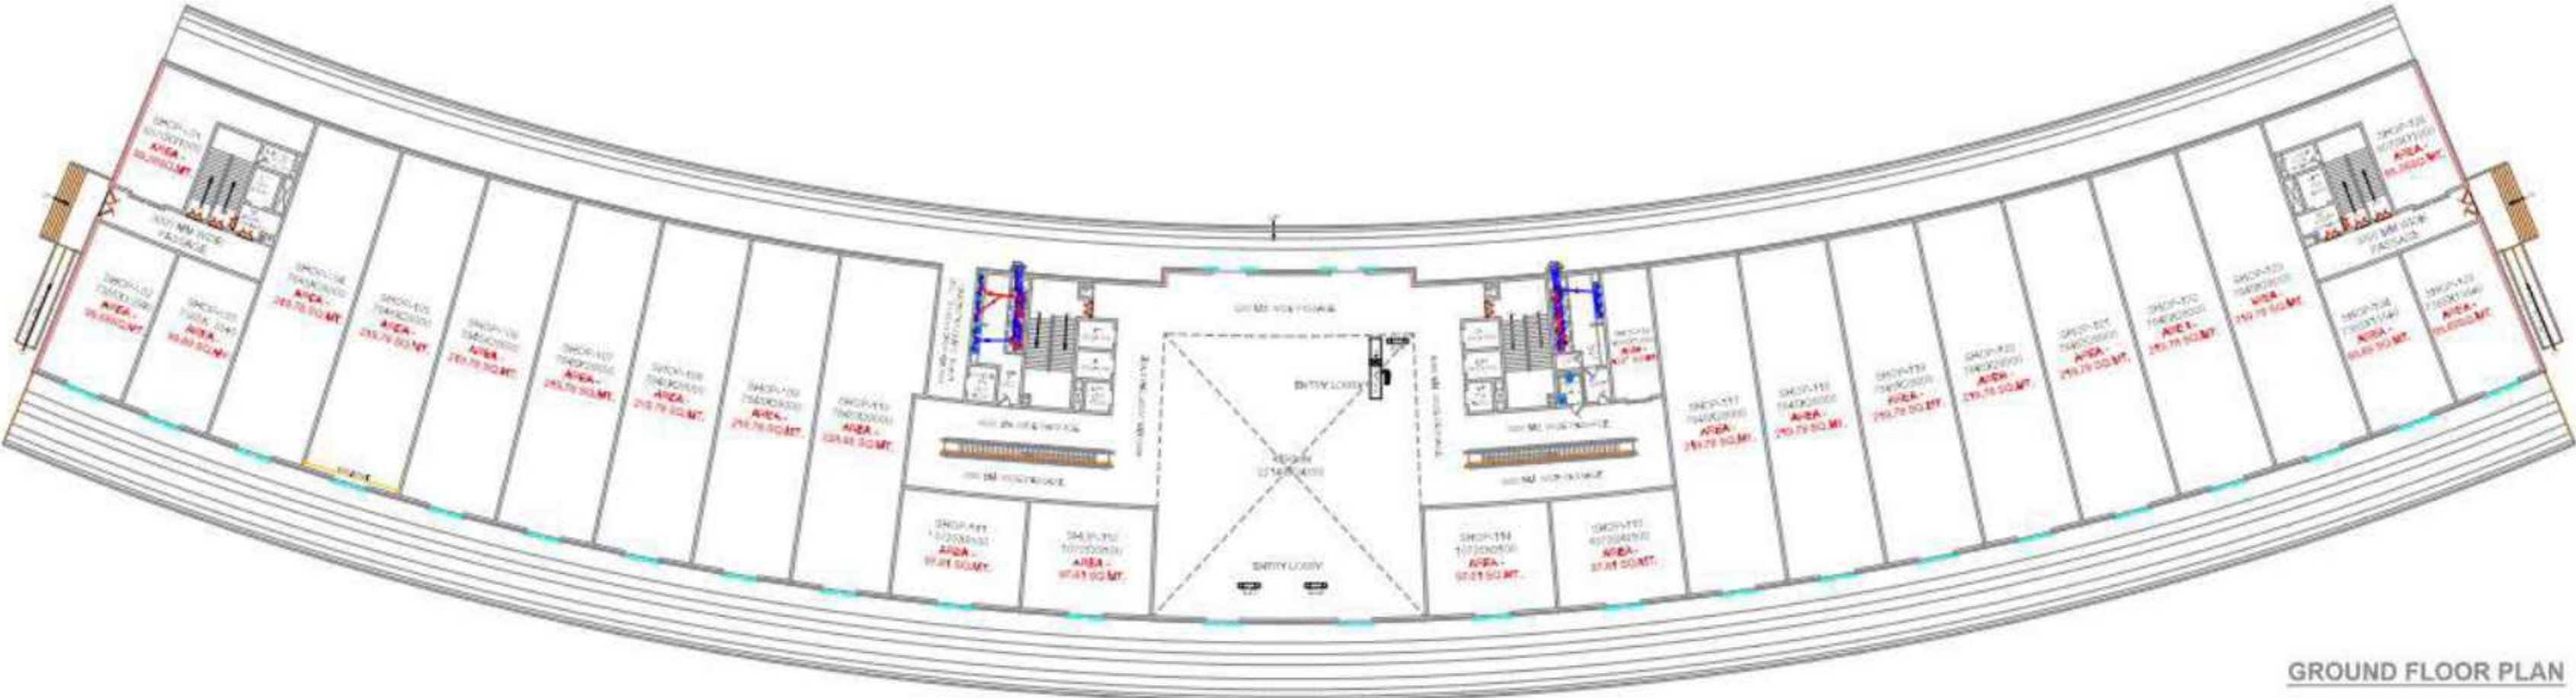

GRID 2000X2000

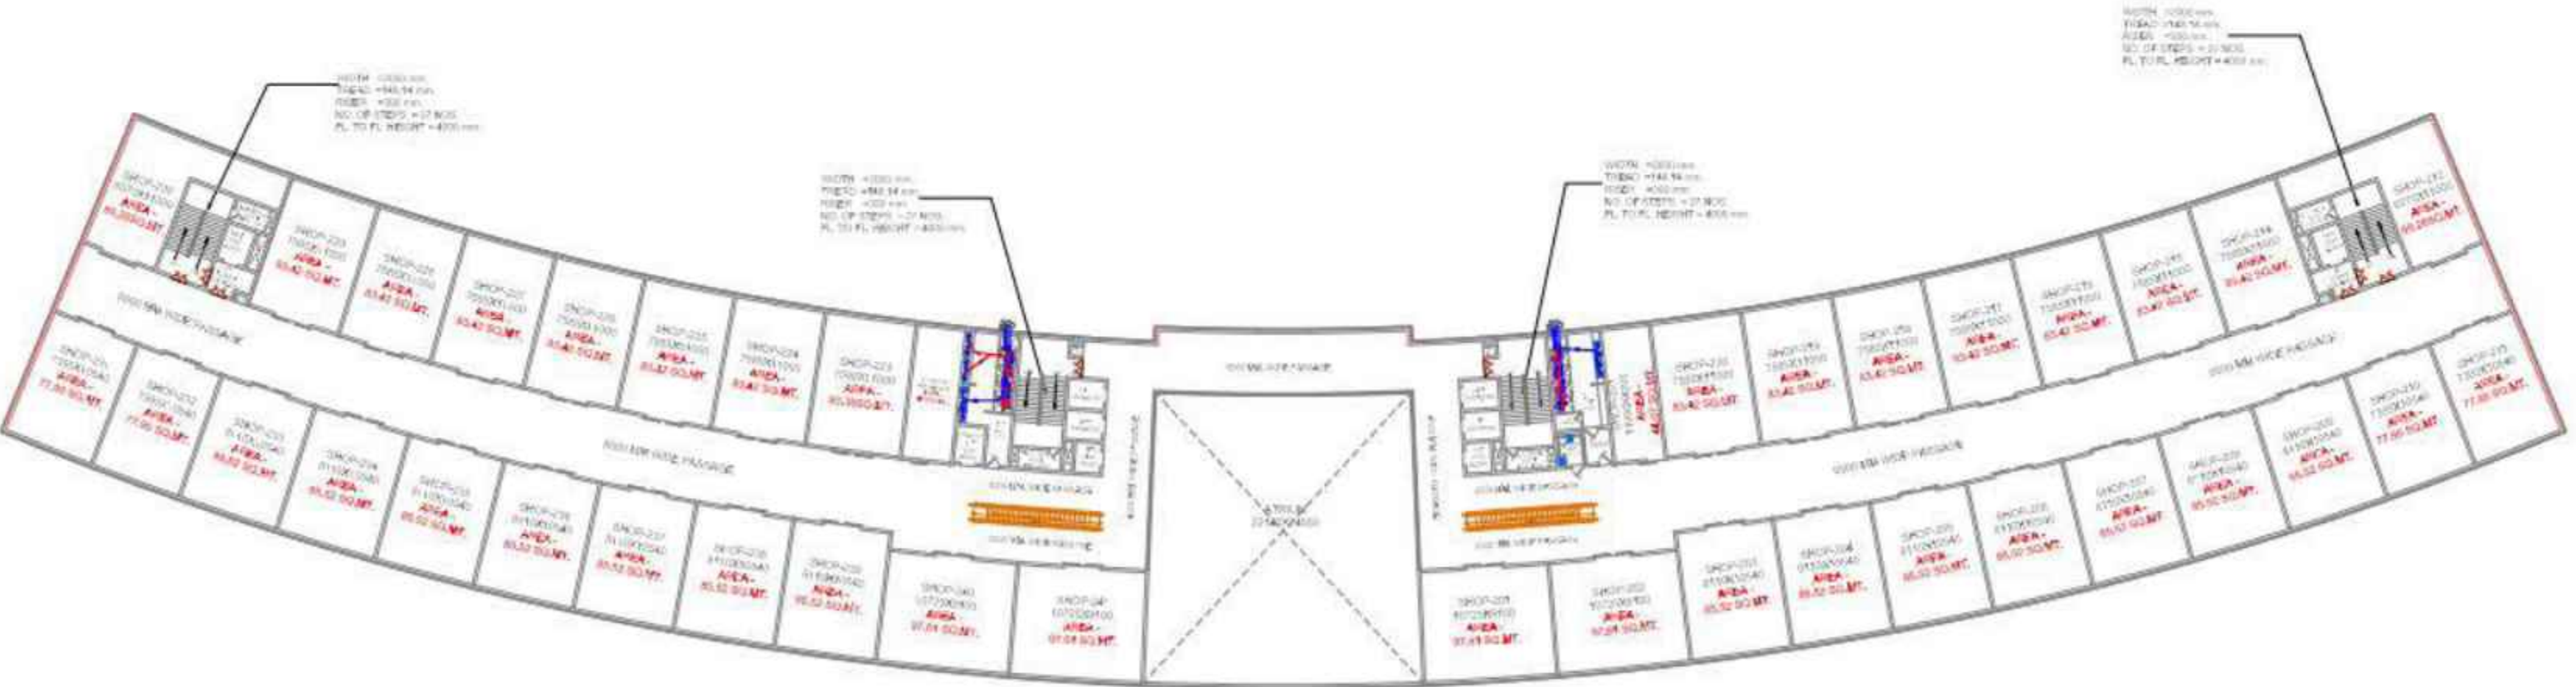

GRID 2000X2000

Legend For Vertical Pipes

- | | |
|---|--|
| 1 | 110Ø Soil Vent Pipe as per tender |
| 2 | 110Ø Waste Water/Vent Pipe as per tender |
| 3 | CWS DN. TAKE PIPE as per tender |
| 4 | FWS DN. TAKE PIPE as per tender |
| 5 | HWS DN. TAKE PIPE as per tender |

THIS DRAWING REPRESENTS ONLY A PLUMBING DETAIL, FOR ARCHITECTURAL / STRUCTURAL AND OTHER SERVICES REFER RELEVANT DRAWINGS. PLEASE CO-ORDINATE THIS DRAWING WITH ALL OTHER RELEVANT DRAWINGS. F.T. MEANS DEEP SEAL 'P' TRAP WITH A PROVISION TO TAKE THE INLET FITTINGS FOR CONNECTION TO WASHBASIN & SINK ETC. AS REQUIRED. LOCATION OF FLOOR TRAPS GIVEN IN THE DRAWINGS MAY CHANGE LLAS PER CONDITION AND ARCHITECTURAL REQUIREMENTS. SLOPS IN THE TOILET SHALL BE KEPT GENERALLY TOWARDS THE FLOOR TRAP FOR WATER SUPPLY DOWN TAKE PIPE REFER TERRACE PLUMBING DIAGRAM. FOR RISE/LEVEL OF MANHOLE & CH. REFER EXTERNAL SEWERAGE & DRAINAGE

1. ALL INTERNAL POTABLE WATER SUPPLY, FRESH, VENTILATED AND TANKAGE LEVEL PIPES SHALL BE USED AS PER SPECIFICATIONS. 2. ALL OF FITTINGS LIKE, VALVES, WELDS, AND TAPS SHALL BE MADE WITH WALL FLANGED AT THE CORNER OF TUBES OR AS SHOWN IN EXTERNAL ARCHITECTURAL TUBING DRAWING. 3. THIS DRAWING SHALL BE READ IN CONJUNCTION WITH RELEVANT ARCHITECTURAL, CIVIL, ELECTRICAL, WATER SUPPLY, TANKAGE LEVEL, WATER PUMPING AND EXTERNAL TANKAGE DRAWINGS. 4. THIS DRAWING SHALL NOT BE SCALED AND NOTED OTHERWISE TO BE FOLLOWED. 5. ALL PIPELINES SHALL BE PROPERLY SLOTTED AS PER COMPANY PRACTICE AND ALL DEFECTS SHALL BE RECTIFIED.

SUBMISSION DRAWING

NORTH

SHEET NO.



LEGEND FOR SANITATION

1. F.T. FLOOR TRAP WITH 150X150mm CUT OUT
2. F.D. FLOOR DRAIN 150X150mm CUT OUT
3. U.T. URINAL TRAP
4. (S.P.)SOIL PIPE 110MMØ
5. (W.P.)WASTE PIPE 110MMØ
6. C.O.P. CLEAN OUT PLUG
7. P-TRAP
8. CUT OUT 100X100mm FOR WASH BASIN / URINAL

LEGEND FOR PLUMBING

1. C.W.V. COLD WATER VALVE
2. W.B. WASH BASIN
3. B.T./H.F. BIB TAP/HEALTH FAUCET
4. A.V. ANGLE VALVE
5. B.V. BALL VALVE
6. COLD WATER SUPPLY
7. FLUSHING WATER SUPPLY
8. S.F.V. SENSOR FLUSH VALVE
9. HOT WATER
10. INDICATE RISE/DROP

INTERNAL PLUMBING LAYOUT

PROJECT TITLE:

COMMERCIAL C9 AT EKANA SPORTZ CITY PVT.LTD

THIS IS TO CERTIFY THAT THIS BUILDING IS PROPOSED AS PER THE RULES & REGULATIONS OF MAHARASHTRA 2021.

SIGN OF LAND LORD.


SIGN OF ARCHITECT.

SCALE:- 1:200
SHEET-A0

DATE:- 16.09.2024




architectural consultant pvt. ltd.
architects, engineers, planner
landscape design, interior design, & valuer
Office:- 1st & 2nd floor laxmi vardan commercial complex at
patrakar puram crossing gomtinagar, lucknow,
Dial :- +91-522-2393123, 2394123, 4044123
Email id:- skyline@usahcc.com
ARCHITECTS :- SANJAY & VIJAY SINHA

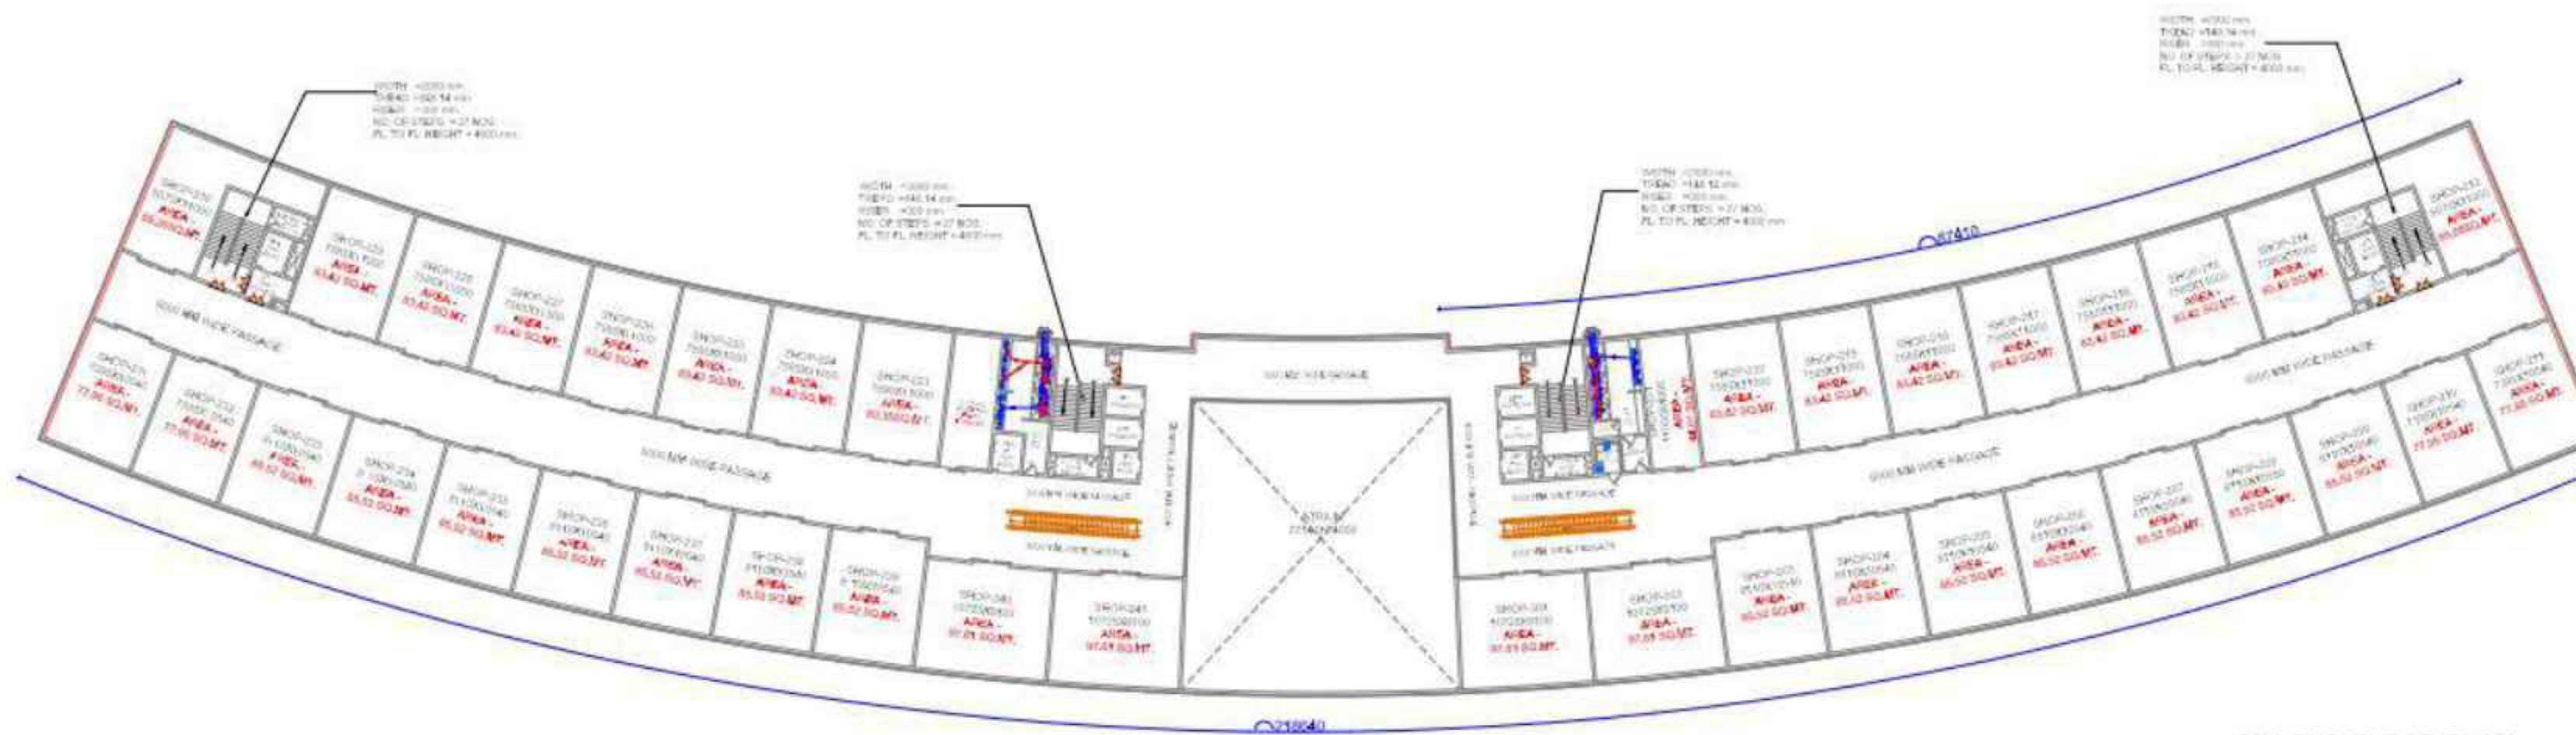

SECOND FLOOR PLAN

GRID 2000X2000

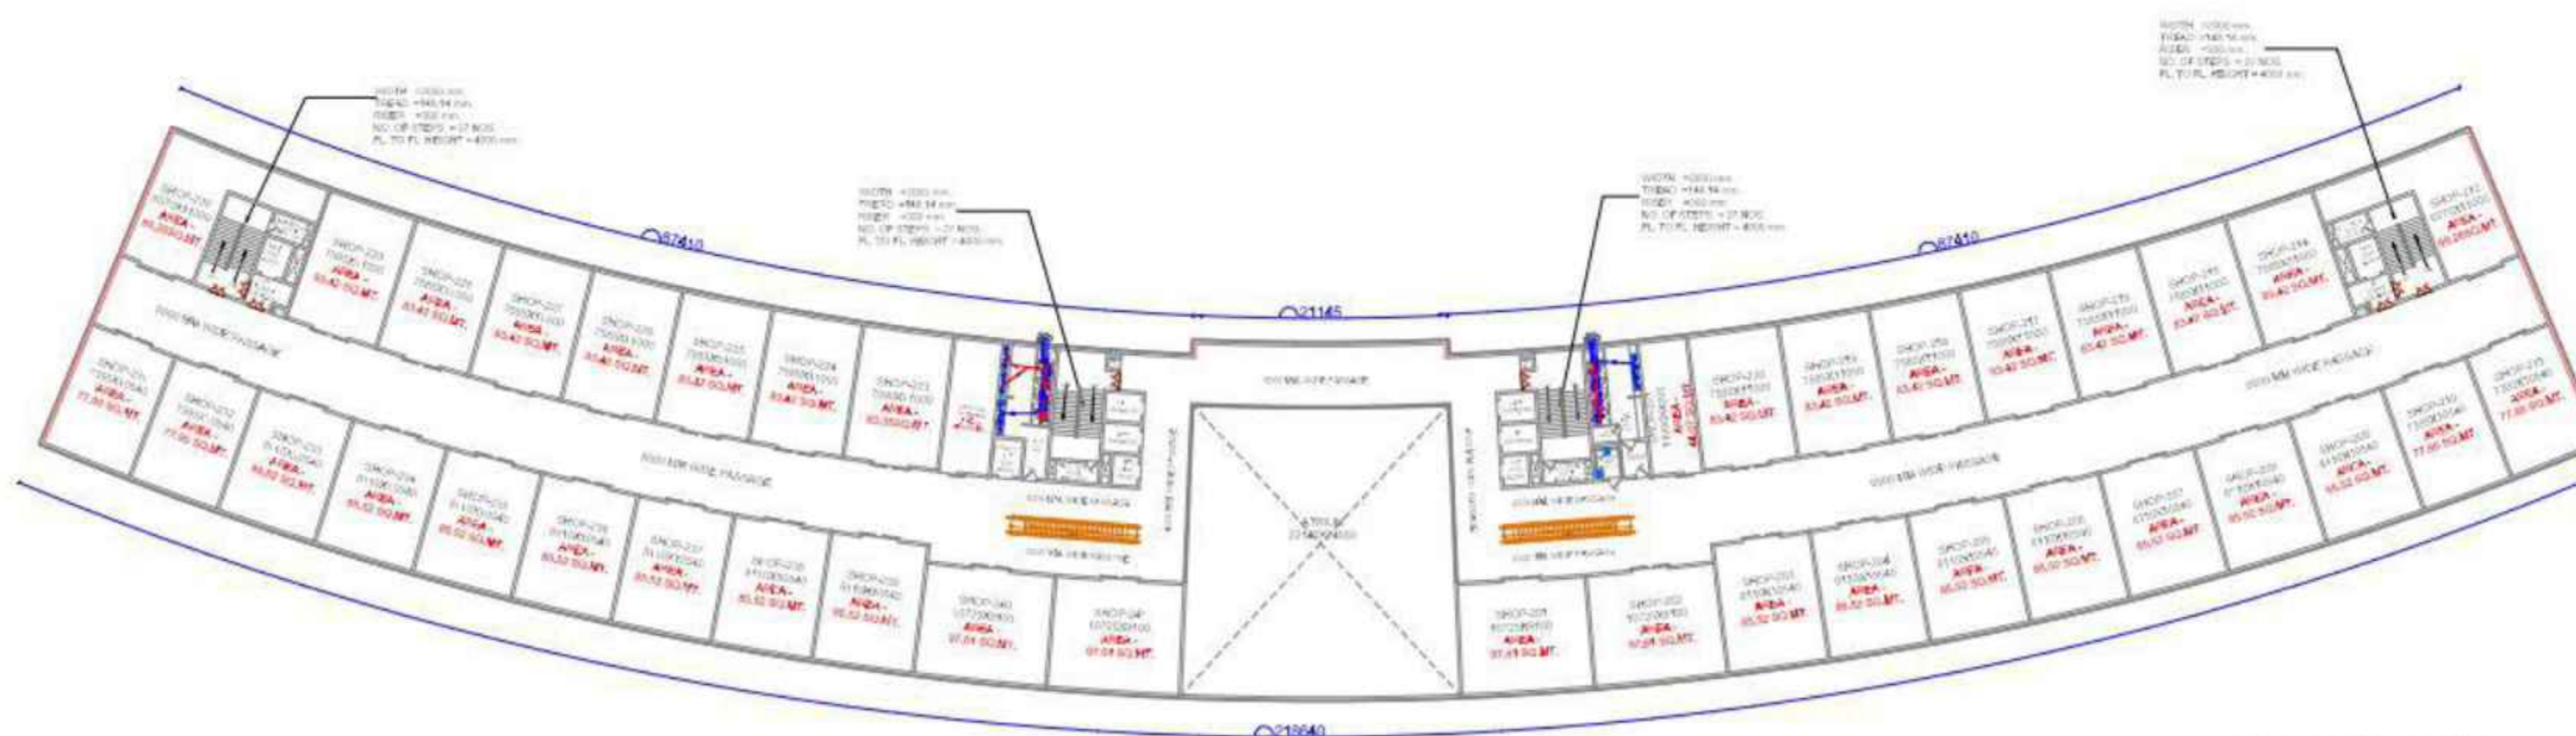

THIRD FLOOR PLAN

GRID 2000X2000

Legend For Vertical Pipes

- 1 110Ø Soil Vent Pipe as per tender
- 2 110Ø Waste Water/Vent Pipe as per tender
- 3 CWS DN. TAKE PIPE as per tender
- 4 FWS DN. TAKE PIPE as per tender
- 5 HWS DN. TAKE PIPE as per tender

THIS DRAWING REPRESENTS ONLY A PLUMBING DETAIL, FOR ARCHITECTURAL / STRUCTURAL AND OTHER SERVICES REFER RELEVANT DRAWINGS. PLEASE CO-ORDINATE THIS DRAWING WITH ALL OTHER RELEVANT DRAWINGS. F.T. MEANS DEEP SEAL 'P' TRAP WITH A PROVISION TO TAKE THE INLET FITTINGS FOR CONNECTION TO WASHBASIN & SINK ETC. AS REQUIRED. LOCATION OF FLOOR TRAPS GIVEN IN THE DRAWINGS MAY CHANGE (L.S. PER CONDITION AND ARCHITECTURAL REQUIREMENTS). SLOPE IN THE TOILET SHALL BE KEPT GENERALLY TOWARDS THE FLOOR TRAP FOR WATER SUPPLY DOWN TAKE PIPE REFER TERRACE PLUMBING DIAGRAM. FOR RISE/LEVEL OF MANHOLE & CH. REFER EXTERNAL SEWERAGE & DRAINAGE

1. ALL INTERNAL POTABLE WATER SUPPLY, FRESH, VENTILATED AND TANKAGE LEVEL PIPES SHALL BE USED AS PER SPECIFICATION. 2. ALL OF FITTINGS LIKE, ANGLE VALVES, BALL VALVES, AND TAPS, SHALL BE FIXED WITH WALL FLANGED AT THE CORNER OF TUBS OR AS SHOWN IN EXTERNAL ARCHITECTURAL DRAWINGS. 3. THIS DRAWING SHALL BE READ IN CONJUNCTION WITH RELEVANT ARCHITECTURAL, ELECTRICAL, MECHANICAL, AND OTHER SERVICES DRAWINGS. 4. THIS DRAWING SHALL NOT BE SCALED AND NOTED OTHERWISE TO BE FOLLOWED. 5. ALL MATERIALS SHALL BE PRESENTED AS PER COMPANY PRACTICE AND ALL DEFECTS SHALL BE RECTIFIED.

SUBMISSION DRAWING

NORTH

SHEET NO.



LEGEND FOR SANITATION

1. F.T. FLOOR TRAP WITH 150X150mm CUT OUT
2. F.D. FLOOR DRAIN 150X150mm CUT OUT
3. U.T. URINAL TRAP
4. (S.P.) SOIL PIPE 110MMØ
5. (W.P.) WASTE PIPE 110MMØ
6. C.O.P. CLEAN OUT PLUG
7. P-TRAP
8. CUT OUT 100X100mm FOR WASH BASIN / URINAL

LEGEND FOR PLUMBING

1. C.W.V. COLD WATER VALVE
2. W.B. WASH BASIN
3. B.T./H.F. BIB TAP/HEALTH FAUCET
4. A.V. ANGLE VALVE
5. B.V. BALL VALVE
6. COLD WATER SUPPLY
7. FLUSHING WATER SUPPLY
8. S.F.V. SENSOR FLUSH VALVE
9. HOT WATER
10. INDICATE RISE/DROP

INTERNAL PLUMBING LAYOUT

PROJECT TITLE:

COMMERCIAL C9 AT EKANA SPORTZ CITY PVT.LTD

THIS IS TO CERTIFY THAT THIS BUILDING IS PROPOSED AS PER THE RULES & REGULATIONS OF MAHARASHTRA 2021.

SIGN OF LAND LORD.


SIGN OF ARCHITECT.

SCALE:- 1:200
SHEET-A0

DATE:- 16.09.2024




architectural consultant pvt. ltd.
architects, engineers, planner
landscape design, interior design, & valuer
Office:- lind & lilrd floor laxmi varden commercial complex at
patrakar puram crossing gomtinagar, lucknow,
Dial :- +91-522-2393123, 2394123, 4044123
Email Id:- skyline@usahcc.com
ARCHITECTS :- SANJAY & VIJAY SINHA

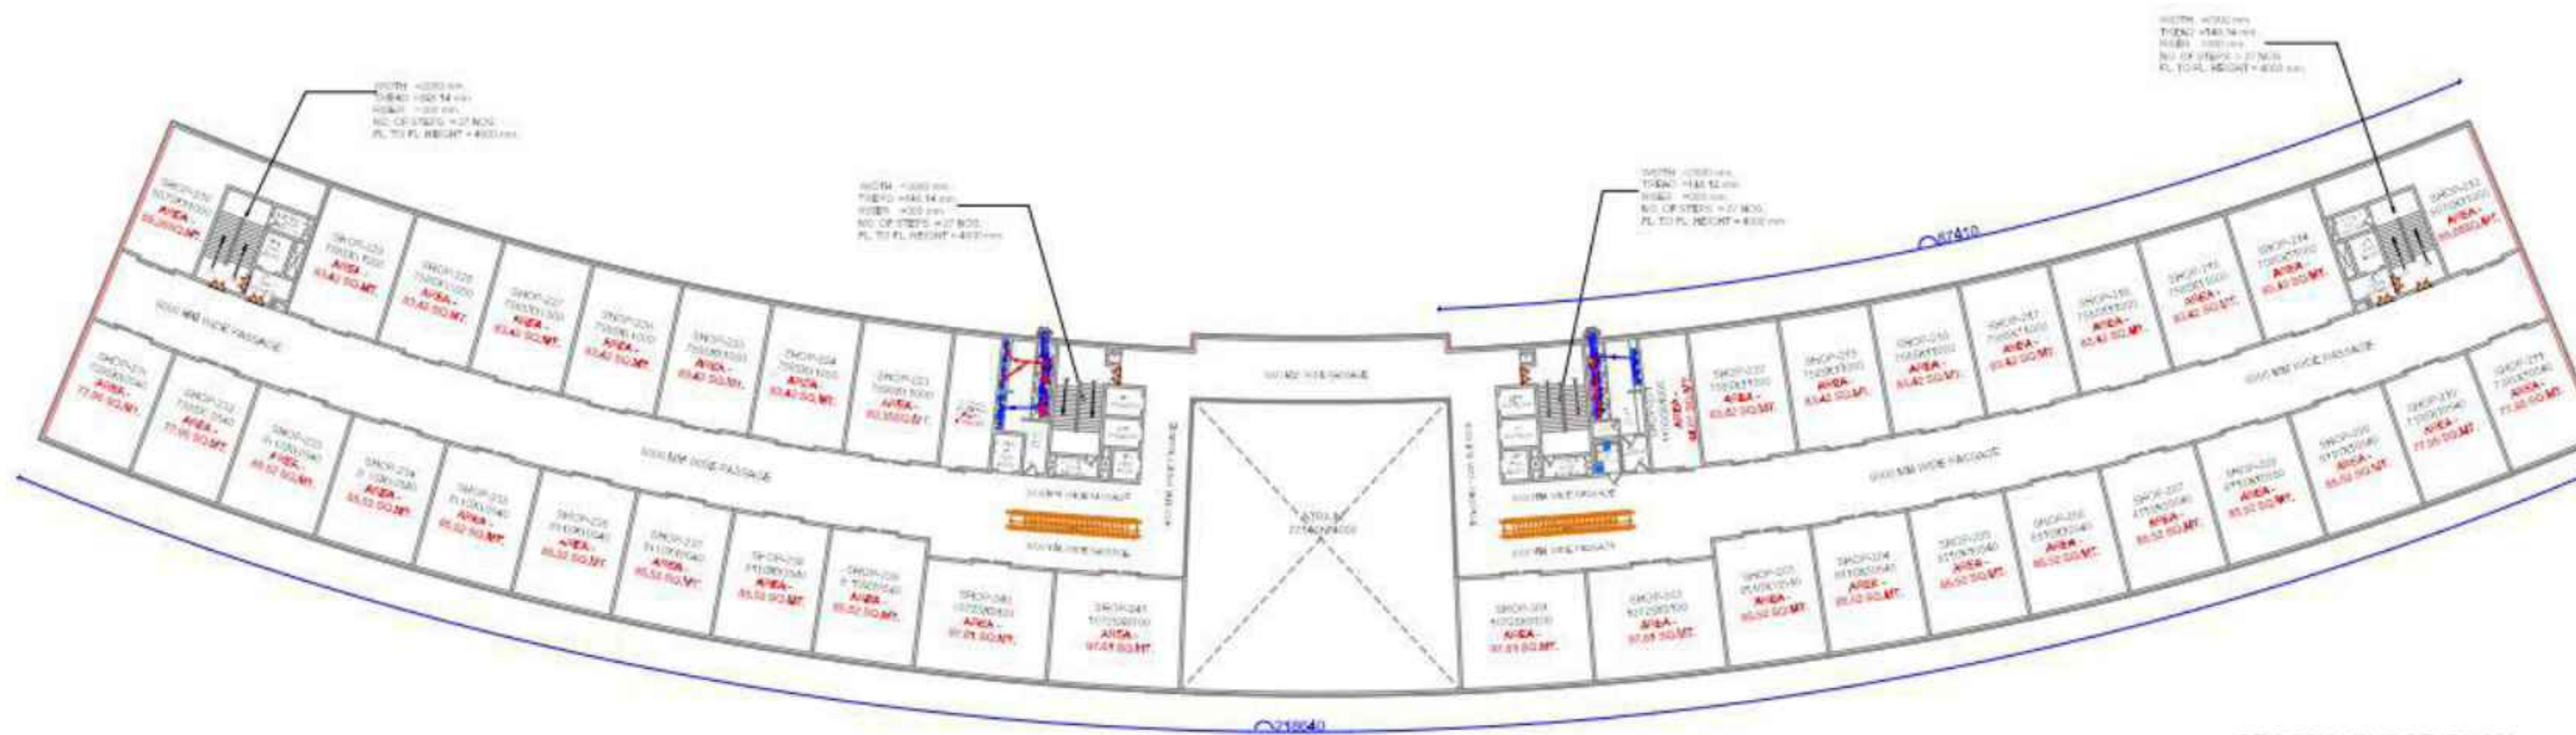

SECOND FLOOR PLAN

GRID 2000X2000

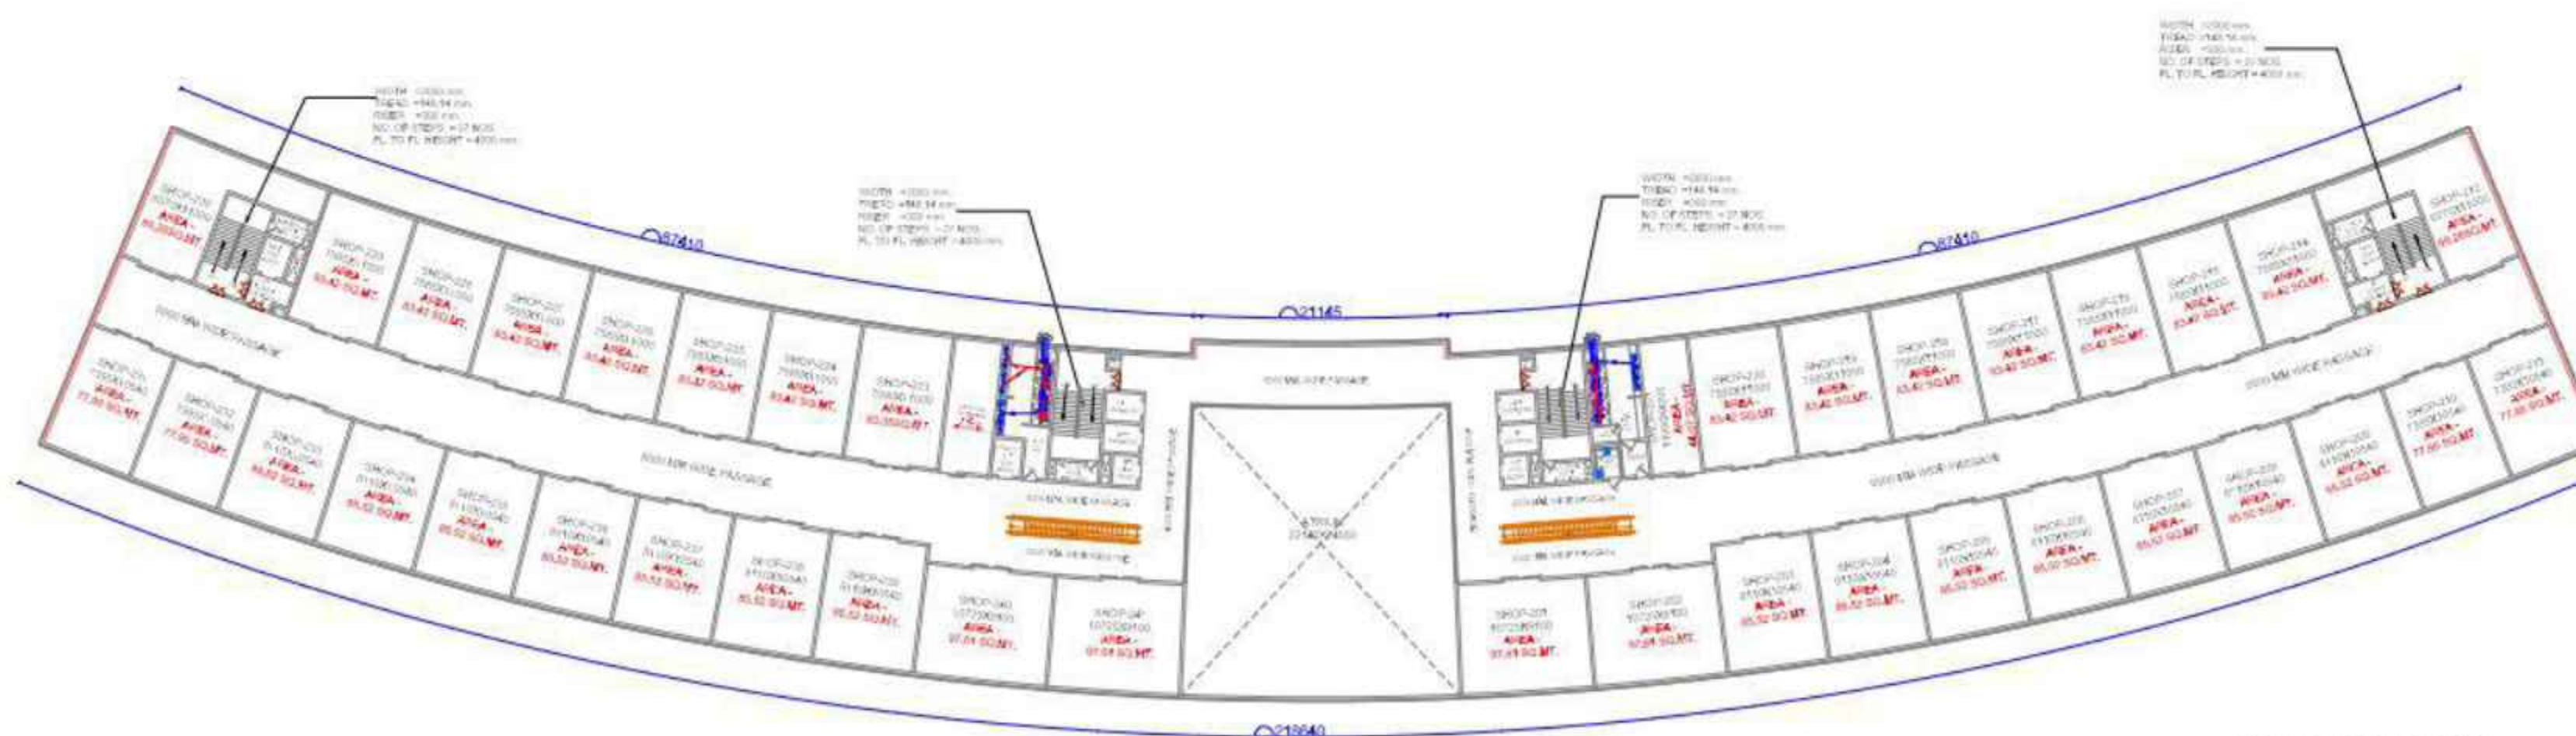

THIRD FLOOR PLAN

GRID 2000X2000

Legend For Vertical Pipes

- 1 110Ø Soil Vent Pipe as per tender
- 2 110Ø Waste Water/Vent Pipe as per tender
- 3 CWS DN. TAKE PIPE as per tender
- 4 FWS DN. TAKE PIPE as per tender
- 5 HWS DN. TAKE PIPE as per tender

THIS DRAWING REPRESENTS ONLY A PLUMBING DETAIL, FOR ARCHITECTURAL / STRUCTURAL AND OTHER SERVICES REFER RELEVANT DRAWINGS. PLEASE CO-ORDINATE THIS DRAWING WITH ALL OTHER RELEVANT DRAWINGS. F.T. MEANS DEEP SEAL 'P' TRAP WITH A PROVISION TO TAKE THE INLET FITTINGS FOR CONNECTION TO WASHBASIN & SINK ETC. AS REQUIRED. LOCATION OF FLOOR TRAPS GIVEN IN THE DRAWINGS MAY CHANGE (L.S. PER CONDITION AND ARCHITECTURAL REQUIREMENTS). SLOPES IN THE TOILET SHALL BE KEPT GENERALLY TOWARDS THE FLOOR TRAP FOR WATER SUPPLY DOWN TAKE PIPE REFER TERRACE PLUMBING DIAGRAM. FOR RISE/LEVEL OF MANHOLE & CH. REFER EXTERNAL SEWERAGE & DRAINAGE


1. ALL INTERNAL POTABLE WATER SUPPLY, FRESH, VENTILATED AND TANKAGE LEVEL PIPES SHALL BE USED AS PER SPECIFICATIONS. 2. ALL OF FITTINGS LIKE, ANGLE VALVES, BALL VALVES, AND TRAPS SHALL BE FIXED WITH WALL FLANGES AT THE CORNER OF TUBS OR AS SHOWN IN EXTERNAL ARCHITECTURAL TIE DRAWING. 3. THIS DRAWING SHALL BE READ IN CONJUNCTION WITH RELEVANT ARCHITECTURAL, ELECTRICAL, MECHANICAL, AND OTHER SERVICES DRAWINGS. 4. THIS DRAWING SHALL NOT BE SCALED AND NOTED OTHERWISE TO BE FOLLOWED. 5. ALL PREPARED SHALL BE PRECISELY SETTED AS PER COMPANY PRACTICE AND ALL DEFECTS SHALL BE RECTIFIED.

SUBMISSION DRAWING

NORTH



SHEET NO.

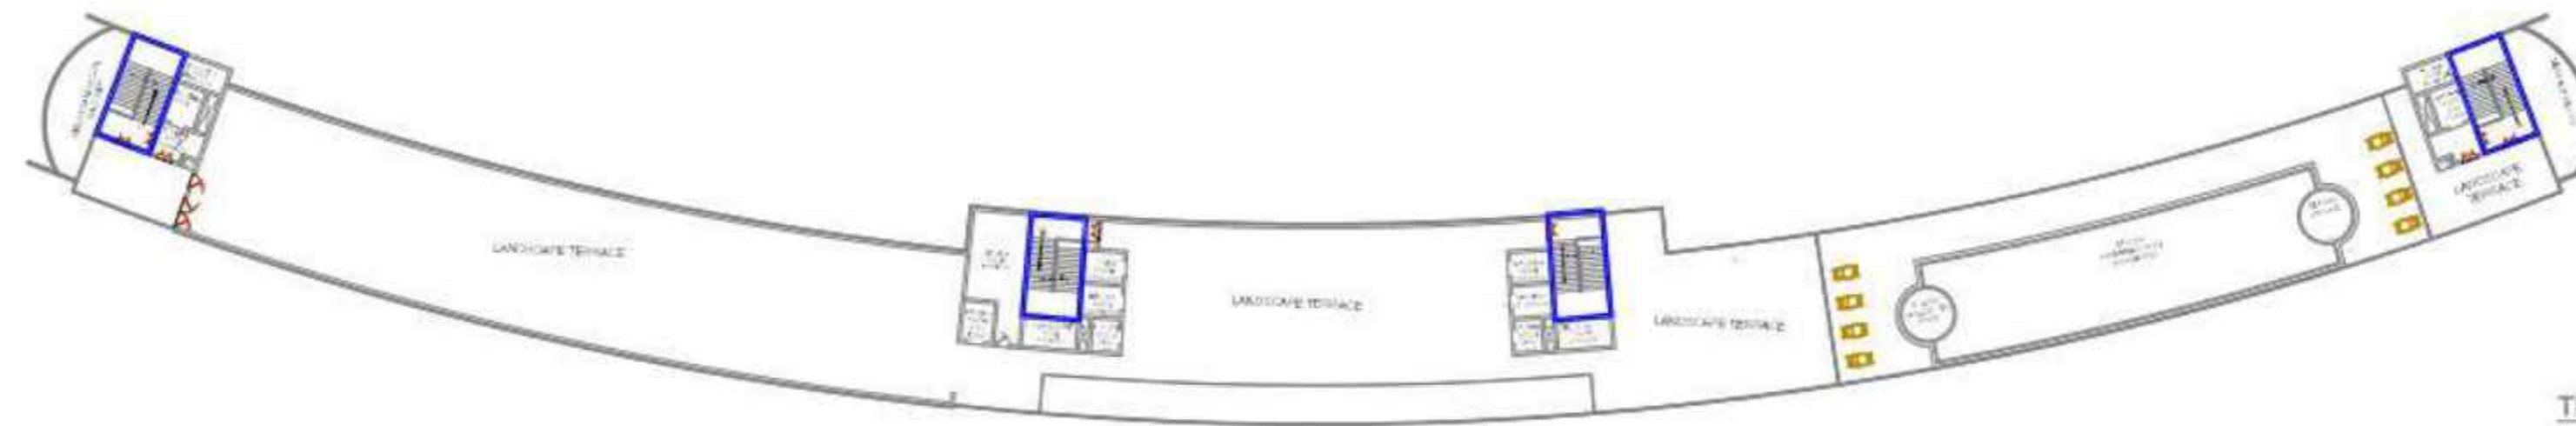

TERRACE FLOOR PLAN
GRID 2000X2000

PROJECT TITLE:

COMMERCIAL C9 AT EKANA SPORTZ CITY
PVT.LTD

THIS IS TO CERTIFY THAT THIS BUILDING IS PROPOSED
AS PER THE RULES & REGULATIONS OF MAHAYOJANA 2021.

SIGN OF LAND LORD.

SIGN OF ARCHITECT.

SCALE:- 1:200
SHEET-A0

DATE:- 16.09.2024



architectural consultant pvt. ltd.
architects, engineers, planner
landscape design, interior design, & value
Office :- 11nd & 111rd floor laxmi vandan commercial complex at
patrakar puram crossing gomtinagar, lucknow,
Dial :- +91-522-2393123,2394123,4044123
Email id:- skyline@usahcc.com
ARCHITECTS :- SANJAY & VIJAY SINHA

SUBMISSION DRAWING

NORTH



SHEET NO.

LEGEND FOR SANITATION

- | | | |
|----|--------|---|
| 1. | F.T. | FLOOR TRAP WITH 150X150mm CUT OUT |
| 2. | F.D. | FLOOR DRAIN 150X150mm CUT OUT |
| 3. | U.T. | URINAL TRAP |
| 4. | (S.P.) | SOIL PIPE 110MMØ |
| 5. | (W.P.) | WASTE PIPE 110MMØ |
| 6. | C.O.P. | CLEAN OUT PLUG |
| 7. | P-TRAP | P-TRAP |
| 8. | | CUT OUT 100X100mm FOR WASH BASIN / URINAL |

LEGEND FOR PLUMBING

- | | | |
|-----|----------|-----------------------|
| 1. | C.W.V. | COLD WATER VALVE |
| 2. | W.B. | WASH BASIN |
| 3. | B.T./H.F | BIB TAP/HEALTH FAUCET |
| 4. | A.V. | ANGLE VALVE |
| 5. | B.V. | BALL VALVE |
| 6. | | COLD WATER SUPPLY |
| 7. | | FLUSHING WATER SUPPLY |
| 8. | S.F.V. | SENSOR FLUSH VALVE |
| 9. | | HOT WATER |
| 10. | | INDICATE RISE/DROP |

INTERNAL PLUMBING LAYOUT

PROJECT TITLE:

COMMERCIAL C9 AT EKANA SPORTZ CITY PVT.LTD

THIS IS TO CERTIFY THAT THIS BUILDING IS PROPOSED AS PER THE RULES & REGULATIONS OF MAHAYOJANA 2021.

SIGN OF LAND LORD.


SIGN OF ARCHITECT.

SCALE:- 1:200
SHEET-A0

DATE:- 16.09.2024




architectural consultant pvt. ltd.
architects, engineers, planner
landscape design, interior design, & valuer
Office:- 1Ind & 1IInd floor laxmi vardan commercial complex at
patrakar puram crossing gomtinagar, lucknow,
Dial :- +91-522-2393123,2394123,4044123
Email Id:- skyline@usahcc.com
ARCHITECTS :- SANJAY & VIJAY SINHA

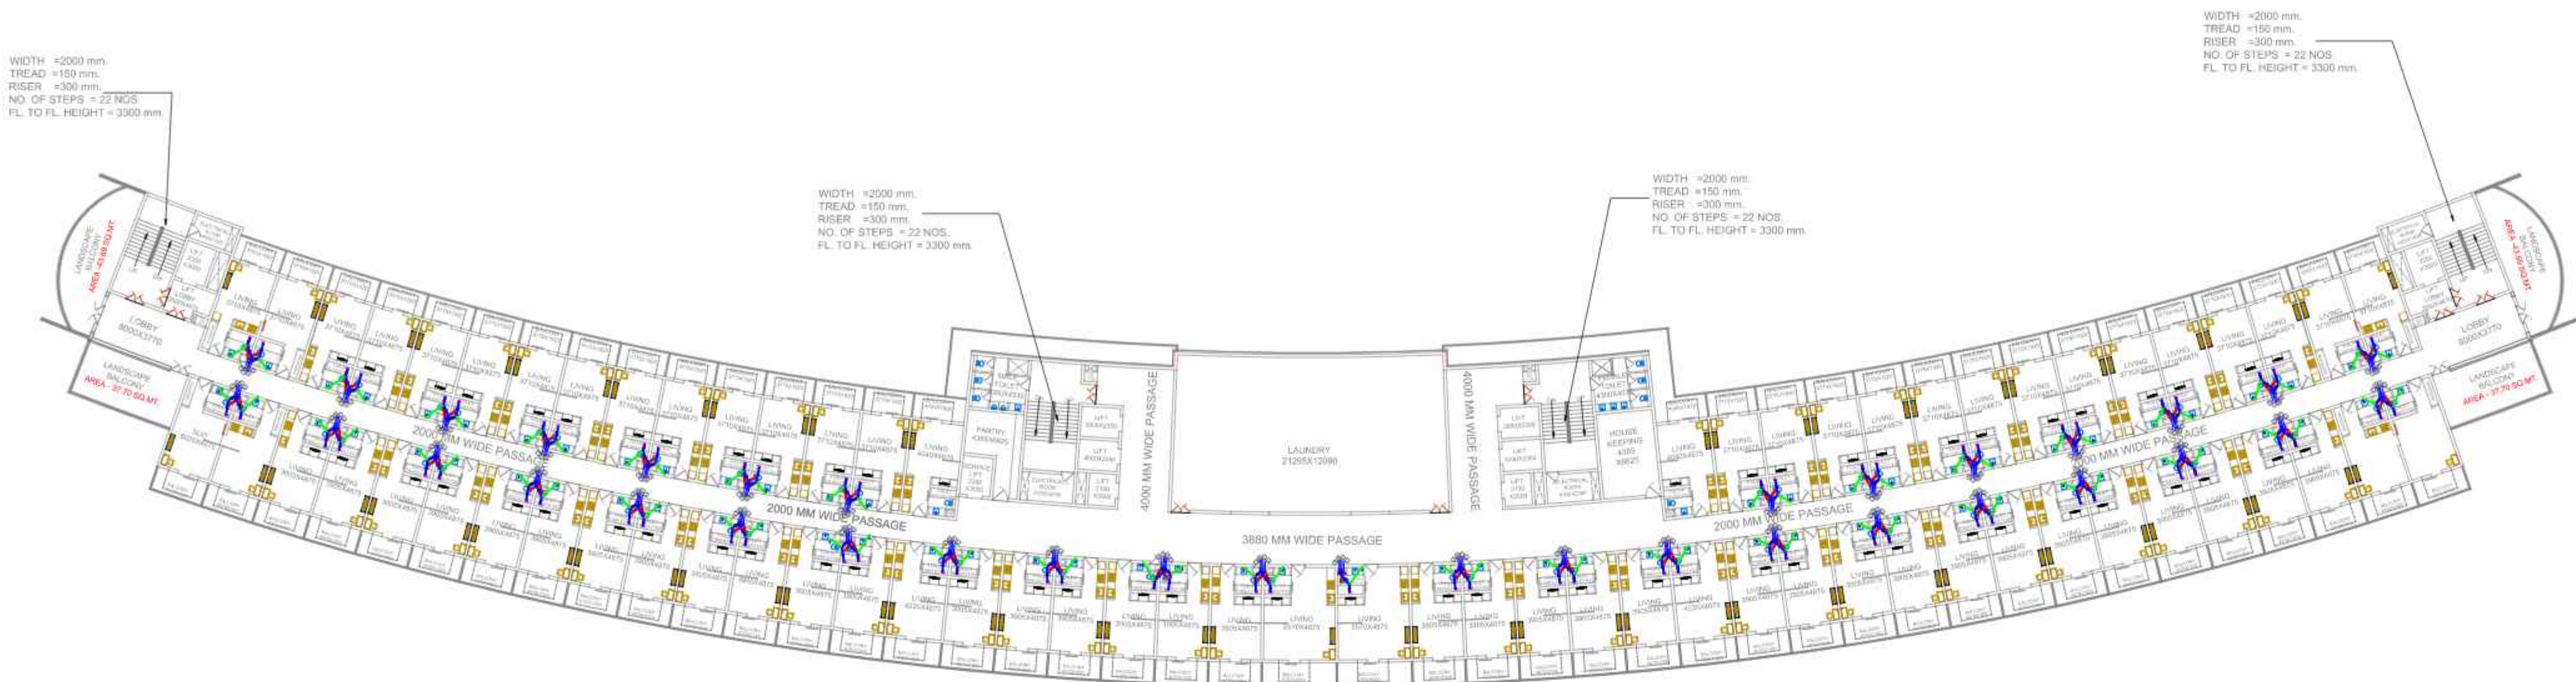

6TH FLOOR PLAN

GRID 2000X2000

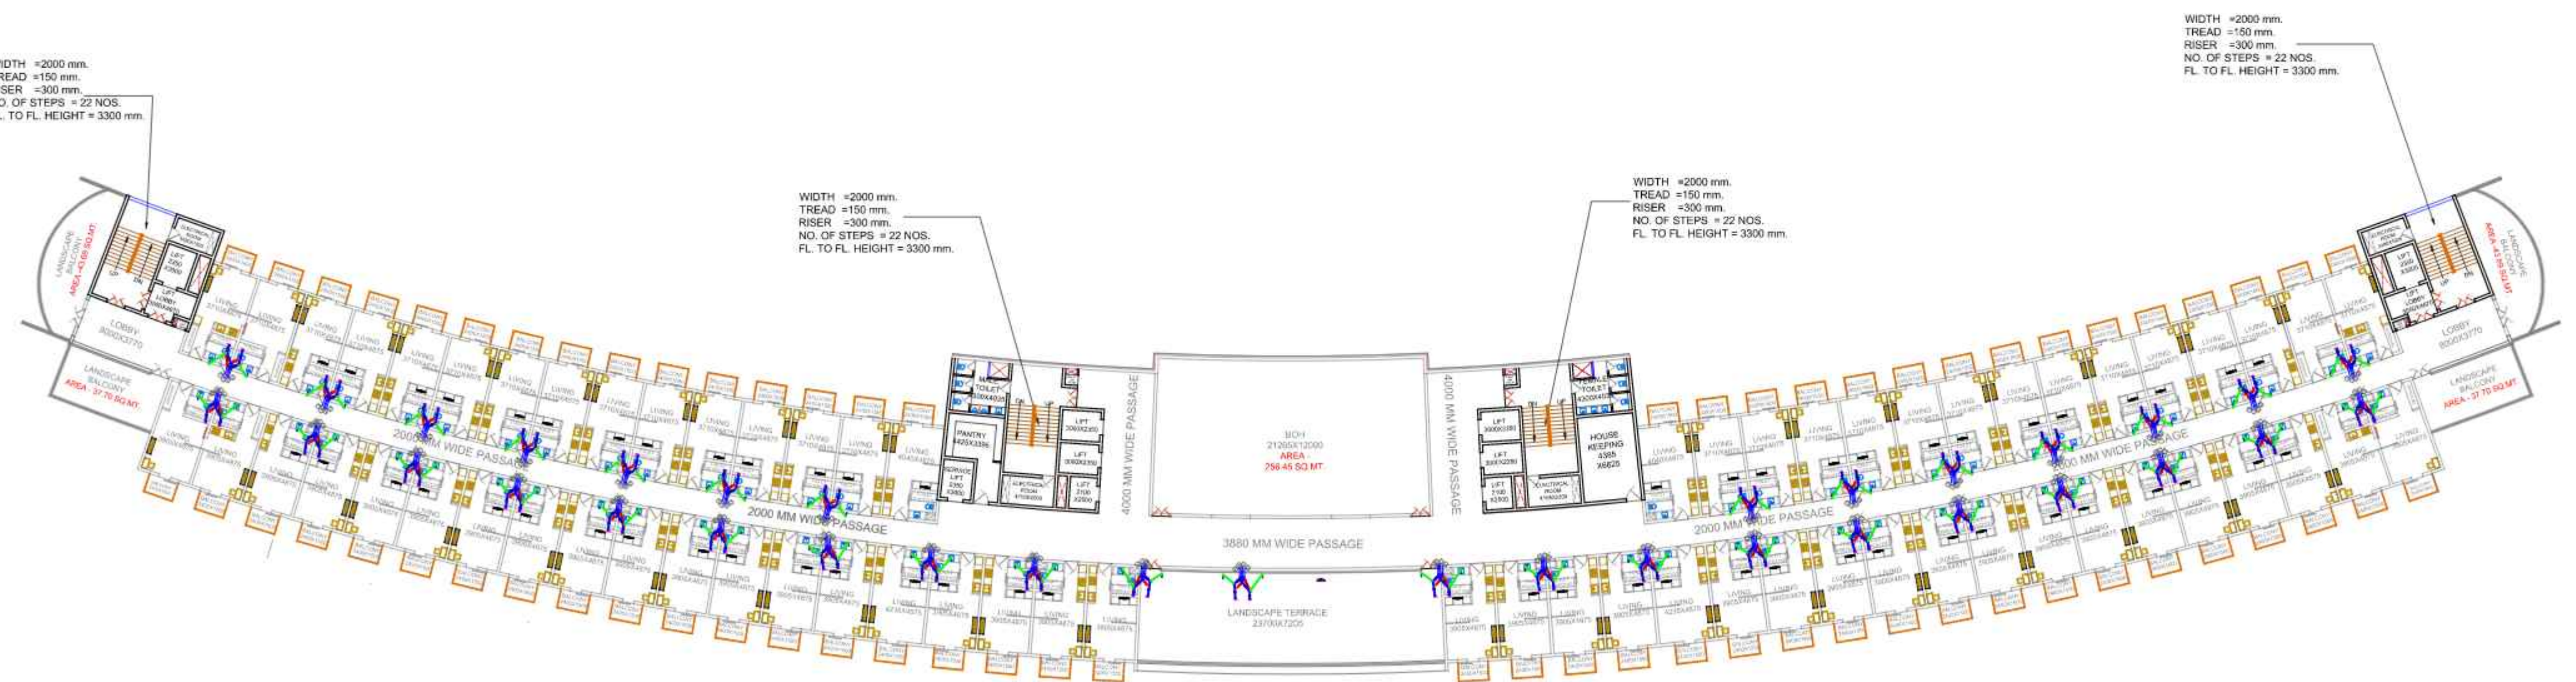

7TH FLOOR PLAN

GRID 2000X2000

Legend For Vertical Pipes

- | | |
|---|---|
| 1 | 110Ø Soil Vent Pipe as per tender |
| 2 | 110Ø Waste WaterVent Pipe as per tender |
| 3 | CWS DN. TAKE PIPE as per tender |
| 4 | FWS DN. TAKE PIPE as per tender |
| 5 | HWS DN. TAKE PIPE as per tender |


1. THIS DRAWING REPRESENTS ONLY A PLUMBING DETAIL, FOR ARCHITECTURAL / STRUCTURAL AND OTHER SERVICES REFER RELEVANT DRAWINGS.
2. PLEASE CO-ORDINATE THIS DRAWING WITH ALL OTHER RELEVANT DRAWINGS
3. F.T. MEANS DEEP SEAL "P" TRAP WITH A PROVISION TO TAKE THE INLET FITTINGS FOR CONNECTION TO WASHBASIN & SINK ETC. AS REQUIRED.
4. LOCATION OF FLOOR TRAPS GIVEN IN THE DRAWINGS MAY CHANGE I/LAS PER CONDITION AND ARCHITECTURAL REQUIREMENTS.
5. SLOPE IN THE TOILET SHALL BE KEPT GENERALLY TOWARDS THE FLOOR TRAP
6. FOR WATER SUPPLY DOWN TAKE PIPE REFER TERRACE PLUMBING DIAGRAM.
7. FOR INVERT LEVEL OF MANHOLE & CB. REFER EXTERNAL SEWERAGE & DRAINAGE

NOTES:-

- ALL INTERNAL POTABLE WATER SUPPLY PIPELINES, VERTICALS AND TERRACE LEVEL PIPES SHALL BE USED AS PER SPECIFICATION.
- ALL OF FITTINGS LIKE ANGLE VALVES, BIB TAPS, SHALL BE FIXED WITH WALL FLANGES AT THE CORNER OF TILES OR AS SHOWN IN DETAILED ARCHITECTURAL TOILET DRAWINGS.
- THIS DRAWING SHALL BE READ IN CONJUNCTION WITH RELEVANT ARCHITECTURAL DRAWINGS, EXTERNAL WATER SUPPLY, TERRACE LEVEL WATER ROUTING AND EXTERNAL SEWERAGE DRAWINGS.
- THIS DRAWING SHALL NOT BE SCALED AND WRITTEN DIMENSIONS TO BE FOLLOWED.
- ALL PIPELINES SHALL BE PRESSURE TESTED AS PER STANDARD PRACTICE AND ALL DEFECTS SHALL BE RECTIFIED.

SUBMISSION DRAWING

NORTH

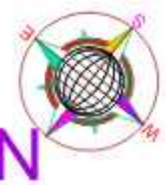

SHEET NO.

LEGEND FOR SANITATION

- | | | |
|----|--------|---|
| 1. | F.T. | FLOOR TRAP WITH 150X150mm CUT OUT |
| 2. | F.D. | FLOOR DRAIN 150X150mm CUT OUT |
| 3. | U.T. | URINAL TRAP |
| 4. | (S.P.) | SOIL PIPE 110MMØ |
| 5. | (W.P.) | WASTE PIPE 110MMØ |
| 6. | C.O.P. | CLEAN OUT PLUG |
| 7. | P-TRAP | P-TRAP |
| 8. | | CUT OUT 100X100mm FOR WASH BASIN / URINAL |

LEGEND FOR PLUMBING

- | | | |
|-----|----------|-----------------------|
| 1. | C.W.V. | COLD WATER VALVE |
| 2. | W.B. | WASH BASIN |
| 3. | B.T./H.F | BIB TAP/HEALTH FAUCET |
| 4. | A.V. | ANGLE VALVE |
| 5. | B.V. | BALL VALVE |
| 6. | | COLD WATER SUPPLY |
| 7. | | FLUSHING WATER SUPPLY |
| 8. | S.F.V. | SENSOR FLUSH VALVE |
| 9. | | HOT WATER |
| 10. | | INDICATE RISE/DROP |

INTERNAL PLUMBING LAYOUT

PROJECT TITLE:

COMMERCIAL C9 AT EKANA SPORTZ CITY PVT.LTD

THIS IS TO CERTIFY THAT THIS BUILDING IS PROPOSED AS PER THE RULES & REGULATIONS OF MAHAYOJANA 2021.

SIGN OF LAND LORD.



SIGN OF ARCHITECT.

SCALE:- 1:200
SHEET-A0

DATE:- 16.09.2024



architectural consultant pvt. ltd.
architects, engineers, planner
landscape design, interior design, & valuer
Office:- IInd & IIInd floor laxmi vardan commercial complex at
patrakar puram crossing gomtinagar, lucknow,
Dial :- +91-522-2393123,2394123,4044123
Email Id:- skyline@usahcc.com
ARCHITECTS :- SANJAY & VIJAY SINHA

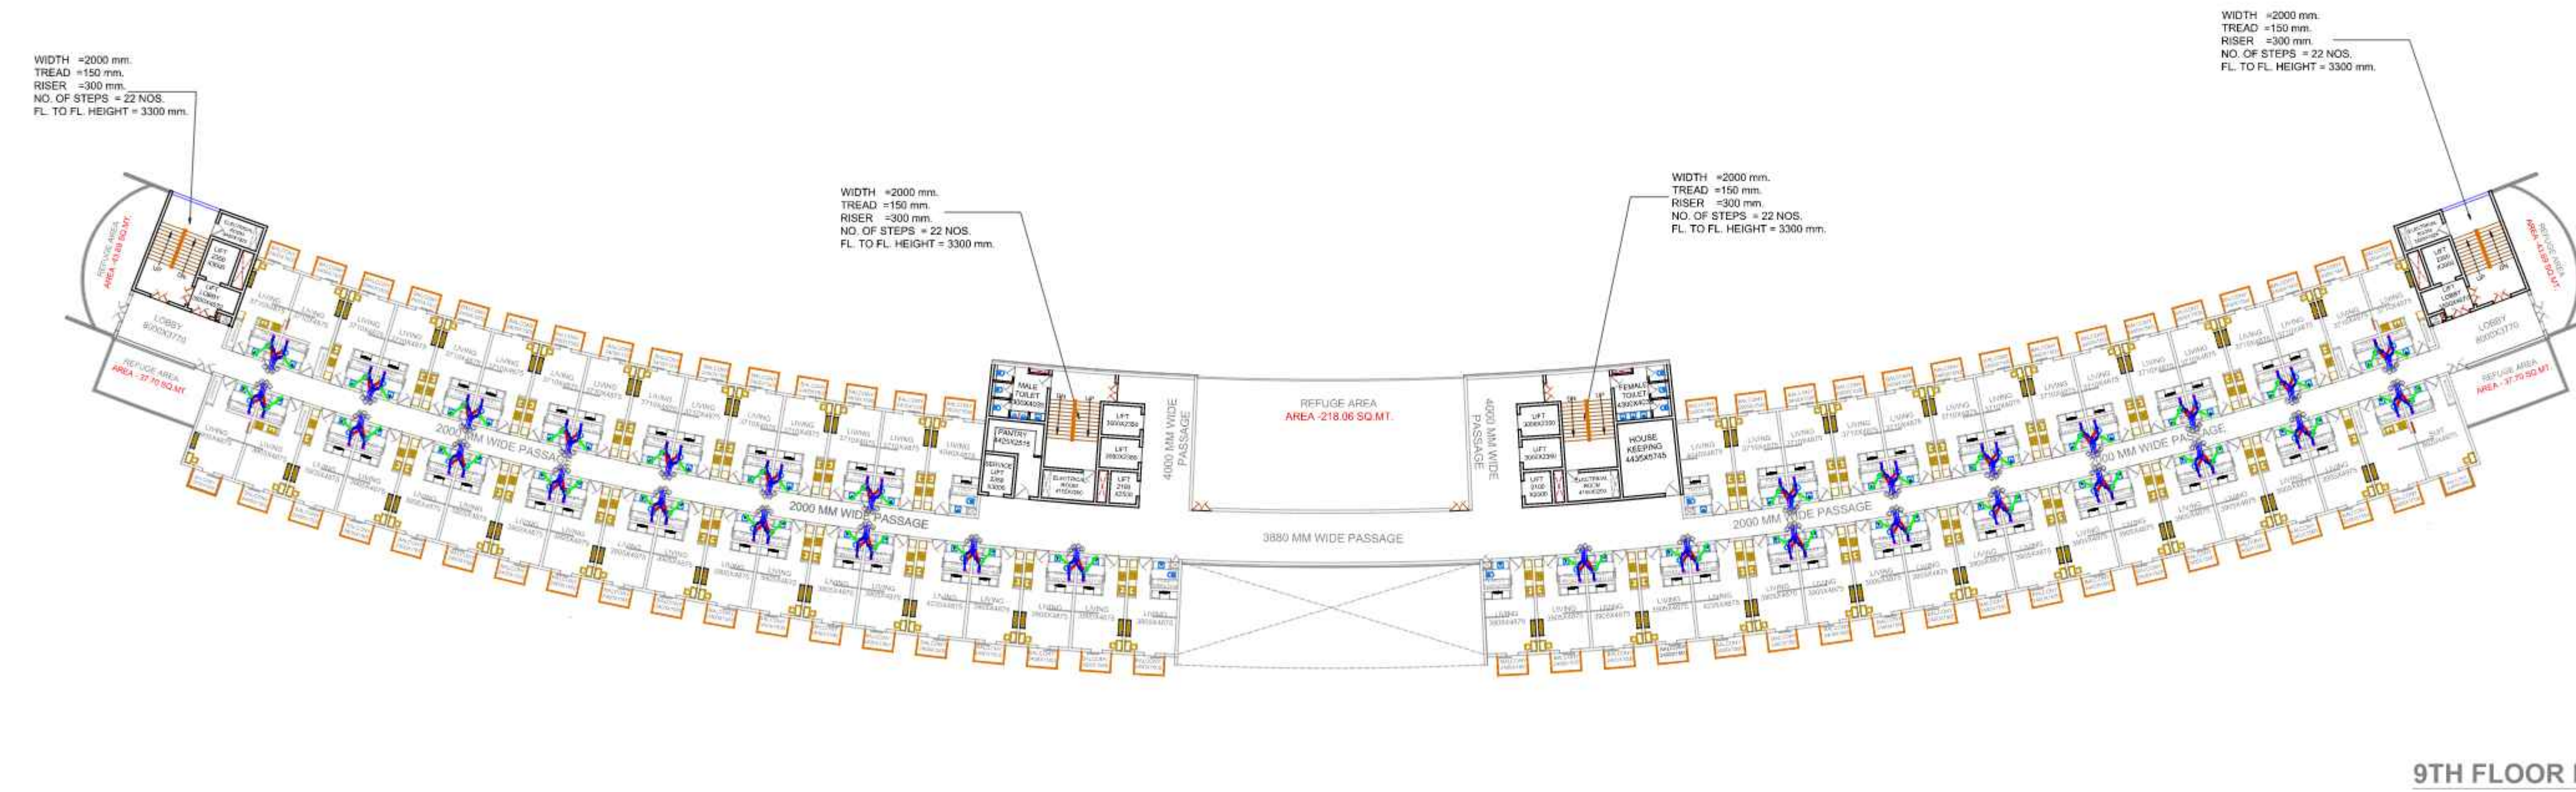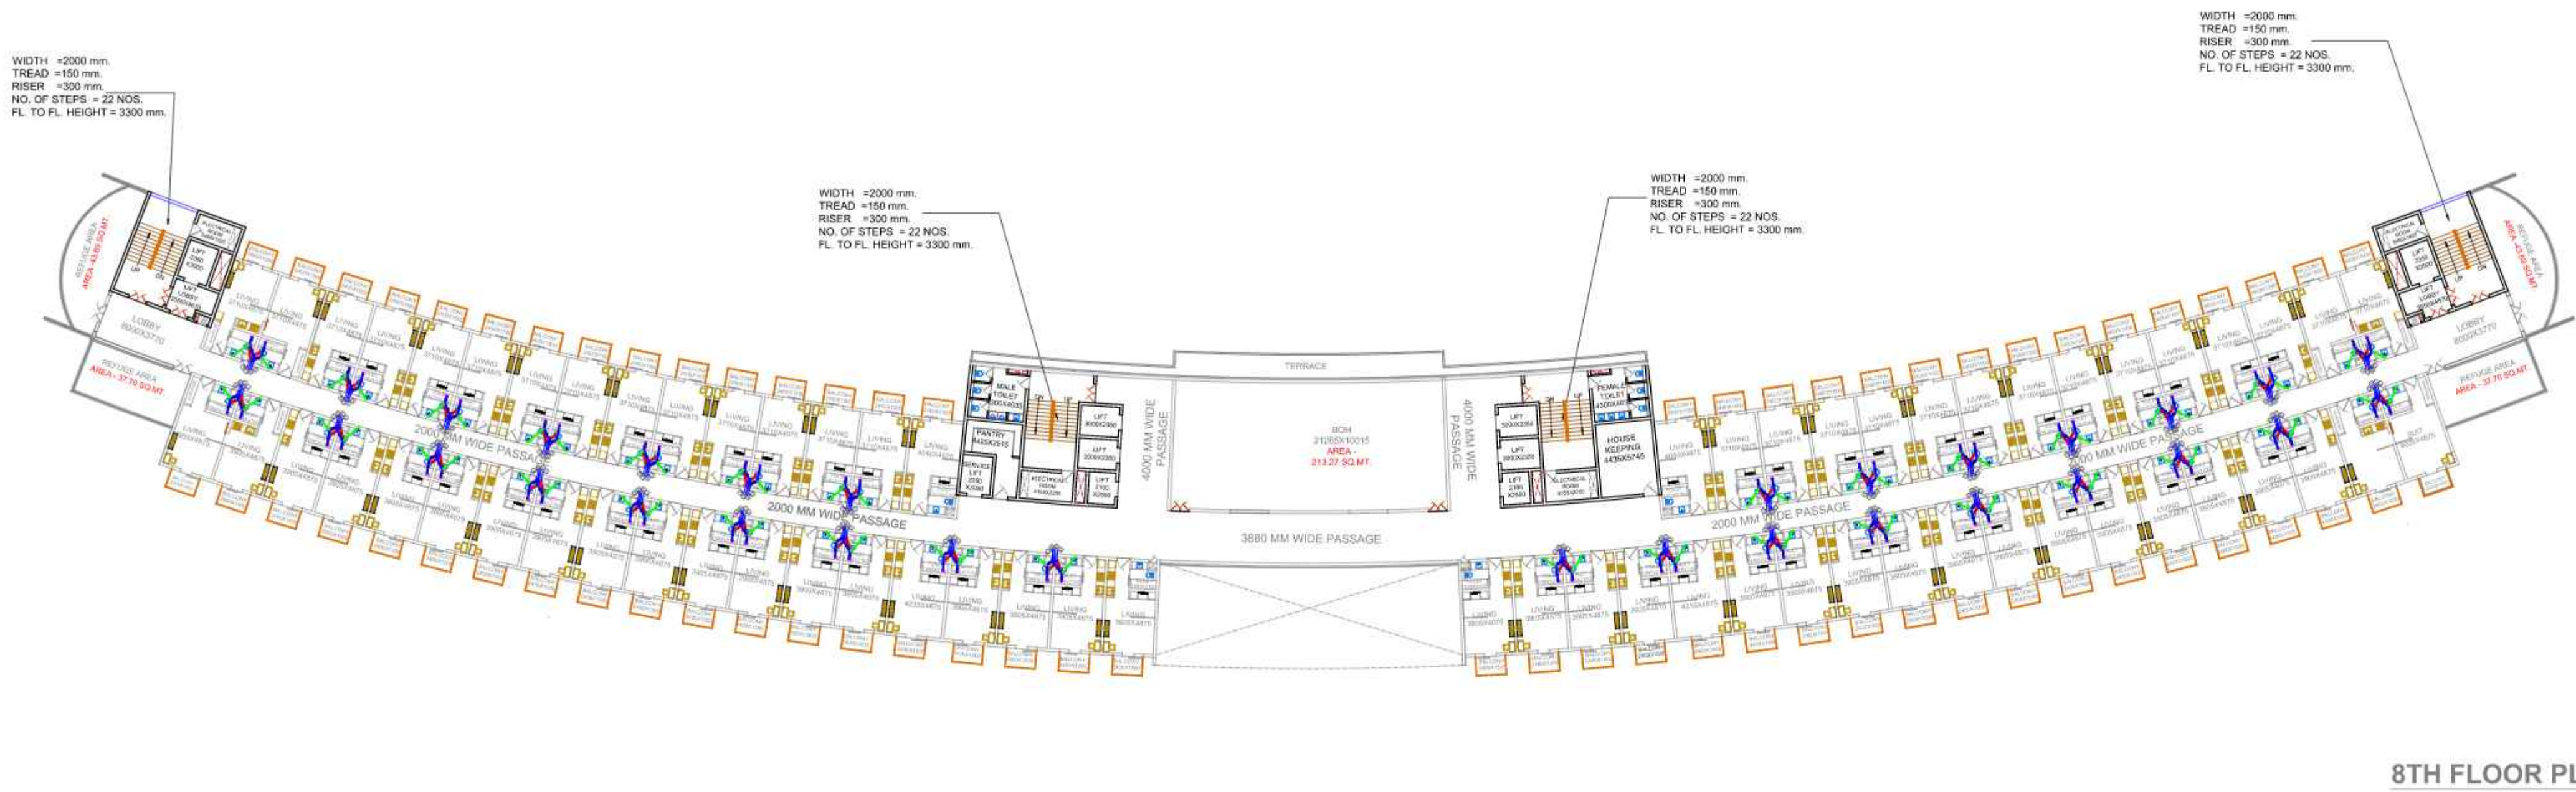

Legend For Vertical Pipes

- | | |
|---|---|
| 1 | 110Ø Soil Vent Pipe as per tender |
| 2 | 110Ø Waste WaterVent Pipe as per tender |
| 3 | CWS DN. TAKE PIPE as per tender |
| 4 | FWS DN. TAKE PIPE as per tender |
| 5 | HWS DN. TAKE PIPE as per tender |

- THIS DRAWING REPRESENTS ONLY A PLUMBING DETAIL, FOR ARCHITECTURAL / STRUCTURAL AND OTHER SERVICES REFER RELEVANT DRAWINGS.
- PLEASE CO-ORDINATE THIS DRAWING WITH ALL OTHER RELEVANT DRAWINGS
- F.T. MEANS DEEP SEAL "P" TRAP WITH A PROVISION TO TAKE THE INLET FITTINGS FOR CONNECTION TO WASHBASIN & SINK ETC. AS REQUIRED.
- LOCATION OF FLOOR TRAPS GIVEN IN THE DRAWINGS MAY CHANGE I/LAS PER CONDITION AND ARCHITECTURAL REQUIREMENTS.
- SLOPE IN THE TOILET SHALL BE KEPT GENERALLY TOWARDS THE FLOOR TRAP
- FOR WATER SUPPLY DOWN TAKE PIPE REFER TERRACE PLUMBING DIAGRAM.
- FOR INVERT LEVEL OF MANHOLE & CB. REFER EXTERNAL SEWERAGE & DRAINAGE

NOTES:-

- ALL INTERNAL POTABLE WATER SUPPLY PIPELINES, VERTICALS AND TERRACE LEVEL PIPES SHALL BE USED AS PER SPECIFICATION.
- ALL OF FITTINGS LIKE ANGLE VALVES, BIB TAPS, SHALL BE FIXED WITH WALL FLANGES AT THE CORNER OF TILES OR AS SHOWN IN DETAILED ARCHITECTURAL TOILET DRAWINGS.
- THIS DRAWING SHALL BE READ IN CONJUNCTION WITH RELEVANT ARCHITECTURAL DRAWINGS, EXTERNAL WATER SUPPLY, TERRACE LEVEL WATER ROUTING AND EXTERNAL SEWERAGE DRAWINGS.
- THIS DRAWING SHALL NOT BE SCALED AND WRITTEN DIMENSIONS TO BE FOLLOWED.
- ALL PIPELINES SHALL BE PRESSURE TESTED AS PER STANDARD PRACTICE AND ALL DEFECTS SHALL BE RECTIFIED.