


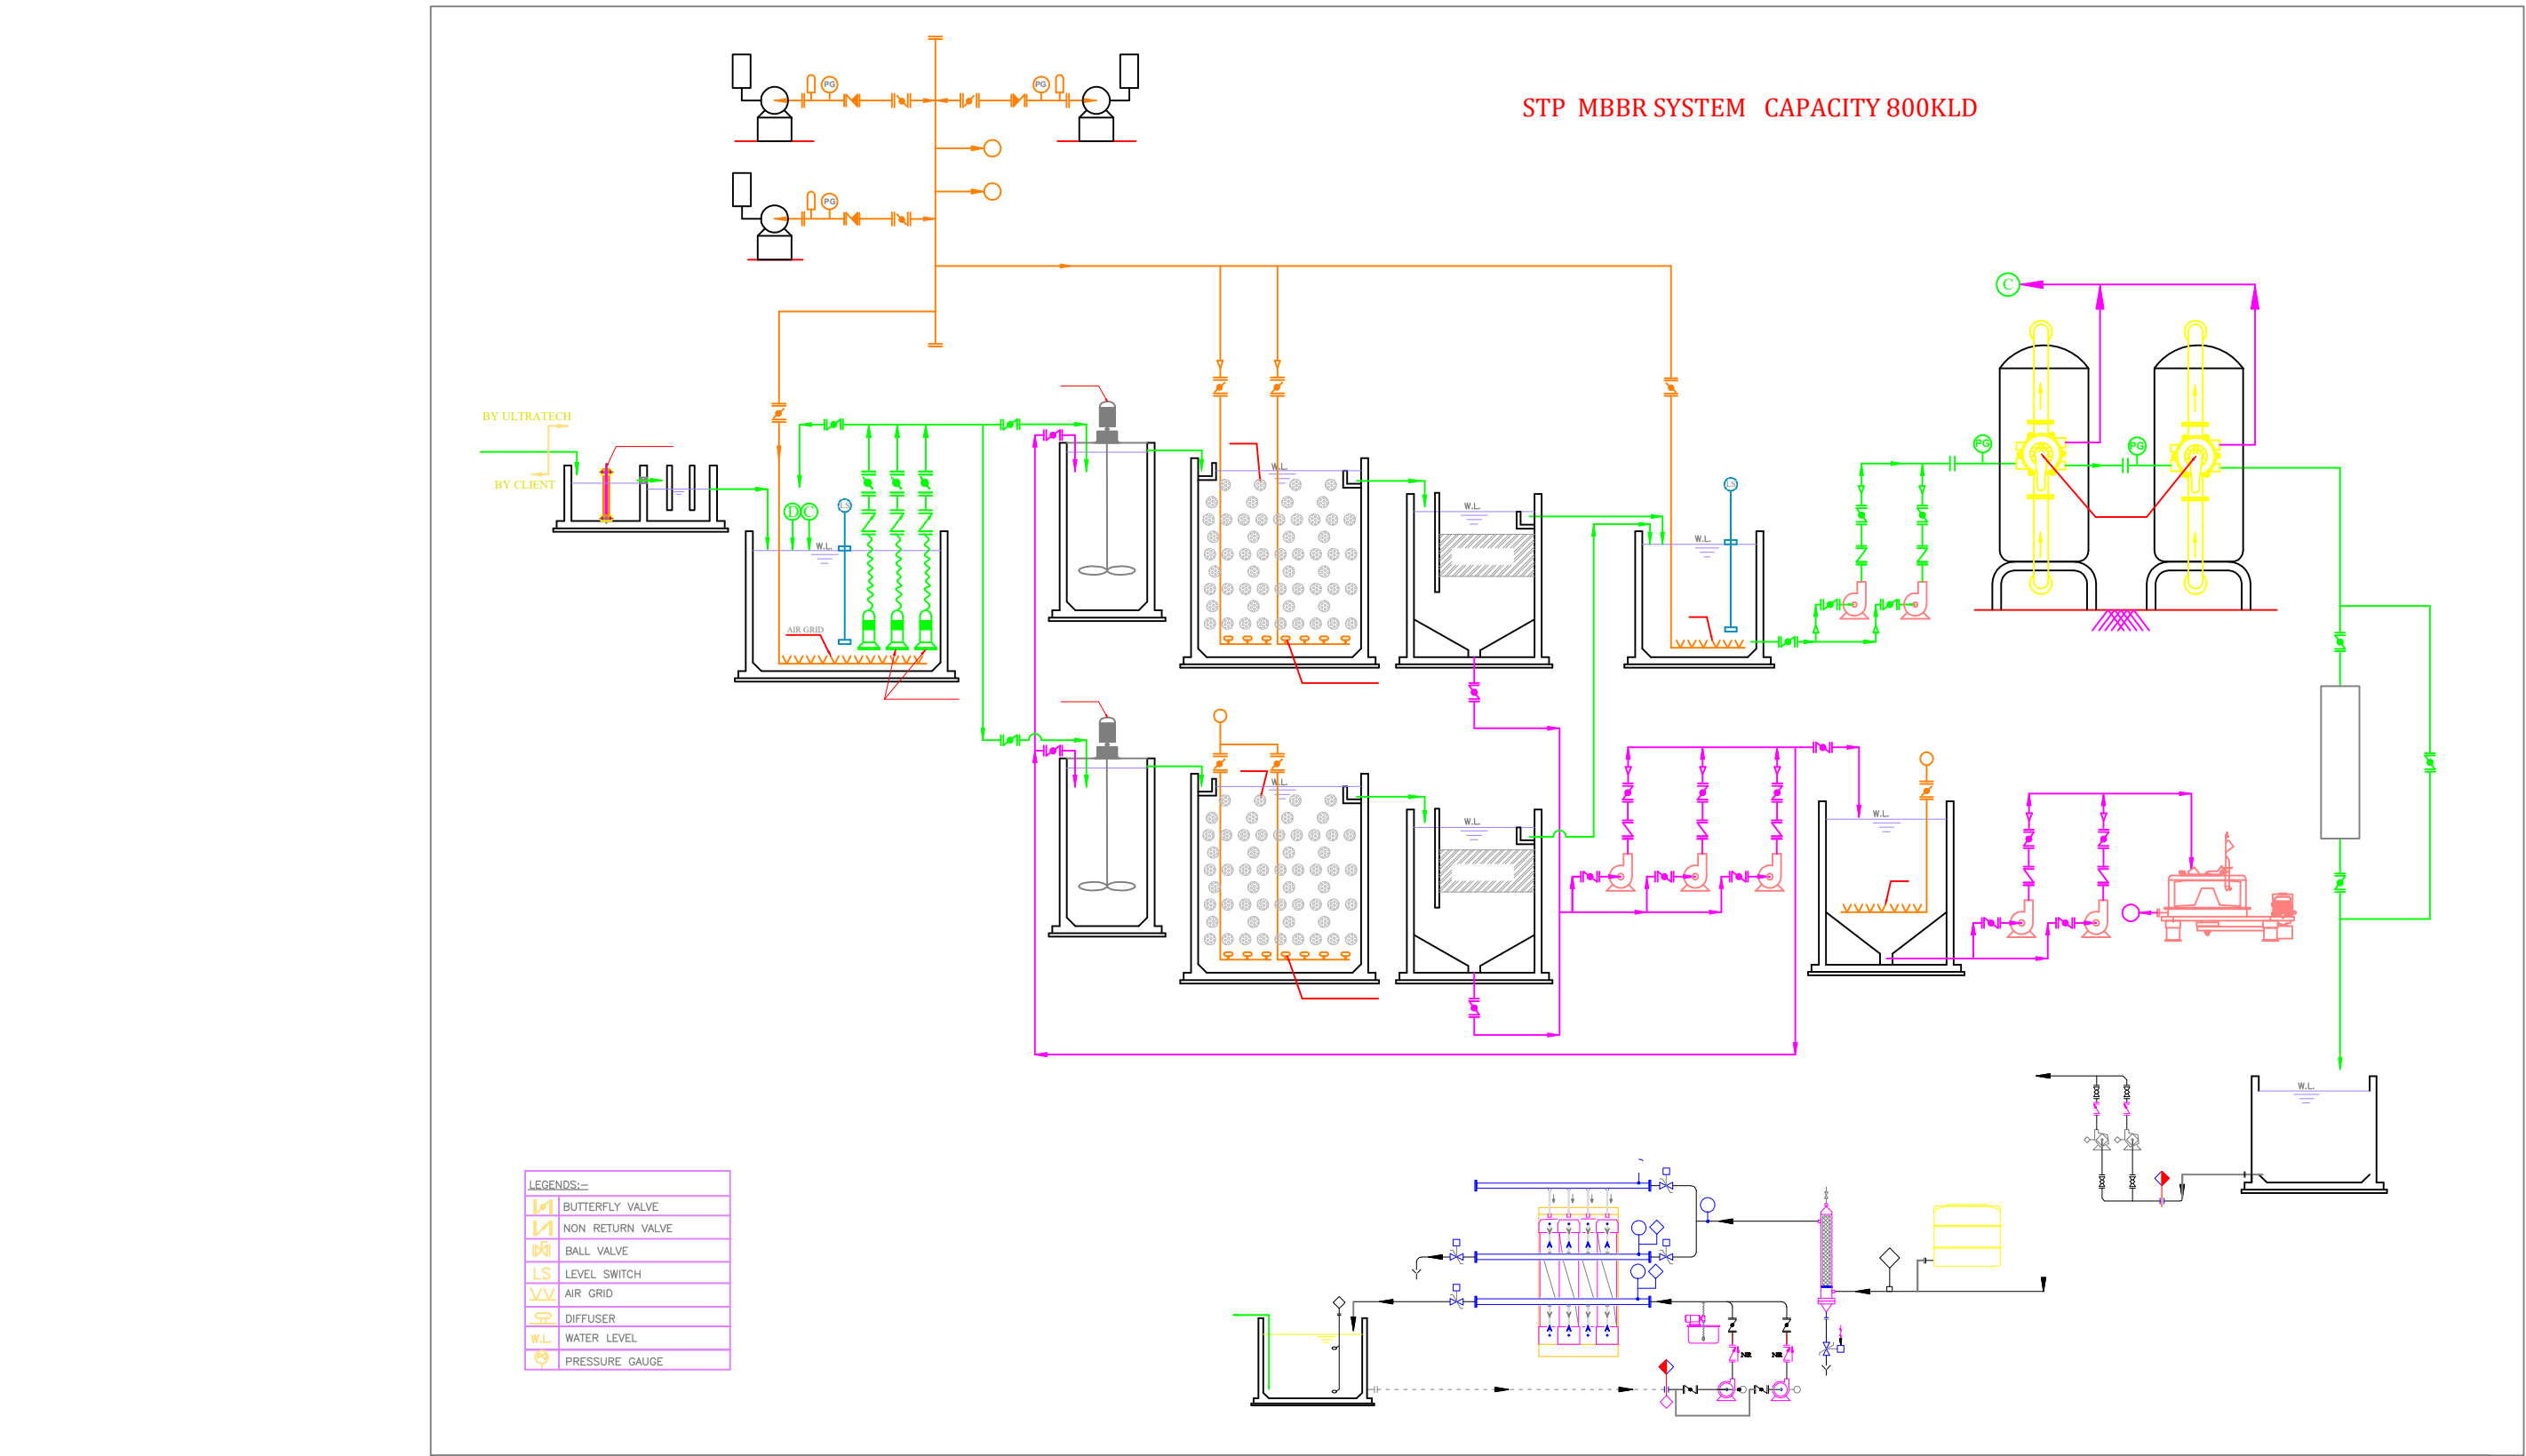


18M WIDE ROAD

ORGANIC WASTE CONVERTER
@ BASEMENT LEVEL
CAPACITY : 1100 KG/DAY

STP-800KLD
AT BASEMENTS FLOOR LEVEL
(1.5M BELOW BASEMENT LEVEL)
RESIDENTIAL+RETAIL, AREA:713 SQM

45 M WIDE GREEN

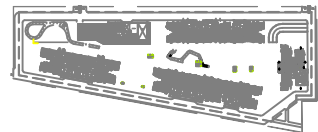

KEY PLAN

REV	DESCRIPTION	DATE	BY
A	ISSUE FOR APPROVAL	07/04/2025	

REV	DESCRIPTION	DATE	BY
A	ISSUE FOR APPROVAL	07/04/2025	

SCHEMATIC DESIGN

CLIENT:
GODREJ PROPERTIES LIMITED
Prestige Oberoi, Kasturba Road, Ambikapur Veedhi,
Sampangi Rama Nagar, Bangalore - 560001

PROJECT:
RSP HOUSE, # 30, MUSEUM ROAD,
BANGALORE - 560001 TEL: 25588888 FAX: 25588818




ARCHITECT:
RSP DESIGN CONSULTANTS (India) PVT. LTD.
Office No. 5B, 5th Floor, S. No. 8
+ 23/1/2, Near Mhatre Bridge, Erandwane,
Pune - 411 004, INDIA

STRUCTURAL CONSULTANT:
WALTER P MOORE ENGINEERING INDIA PVT. LTD.
Down Town City Centre,
Office No. 5B, 5th Floor, S. No. 8
+ 23/1/2, Near Mhatre Bridge, Erandwane,
Pune - 411 004, INDIA

SERVICE CONSULTANT:
SEED Engineering Consultants Pvt. Ltd.
No. 37, U.P. Complex, First Floor, Double Road,
Indiranagar 2nd stage, Bangalore 560 038.
Tel: +91 80 4128 4668
web: www.seedengineering.com
Bangalore | Dubai | Kochi | Mumbai | Singapore
DRAWING TITLE:

SITE LEVEL
DRAINAGE LAYOUT

DRAWN:	MA	CHECKED:	PS	APPROVED:	MD
SCALE @ A1:	1:500	START DATE:	05.08.2025	PLOT DATE:	
DRAWING NO:	PI-2455-GPL-SS-DR-100	REV. NO:			
AUTHORITY DRAWING NO:					

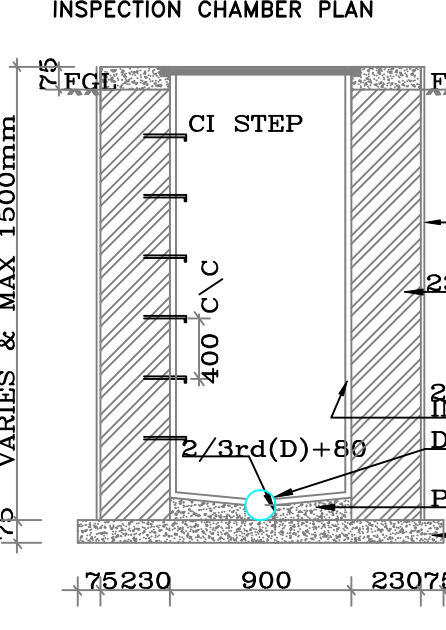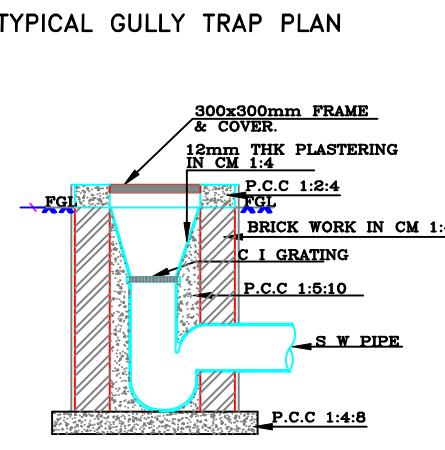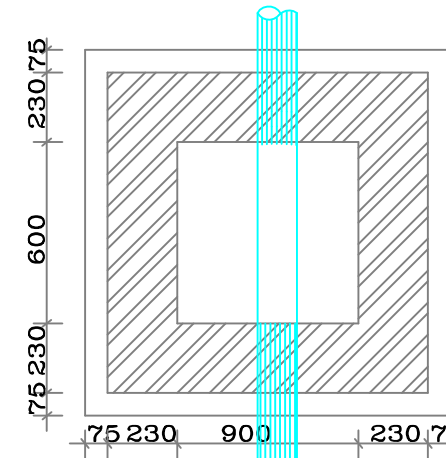

SL. NO.	SYMBOL	DESCRIPTION
1	RECHARGE PIT	RECHARGE PIT
2	GULLY TRAP	GULLY TRAP
3	INSPECTION CHAMBER	INSPECTION CHAMBER
4	SOIL PIPE	SOIL PIPE
5	WASTE PIPE	WASTE PIPE