


10 TH FLOOR PLAN
" SUKHAD "

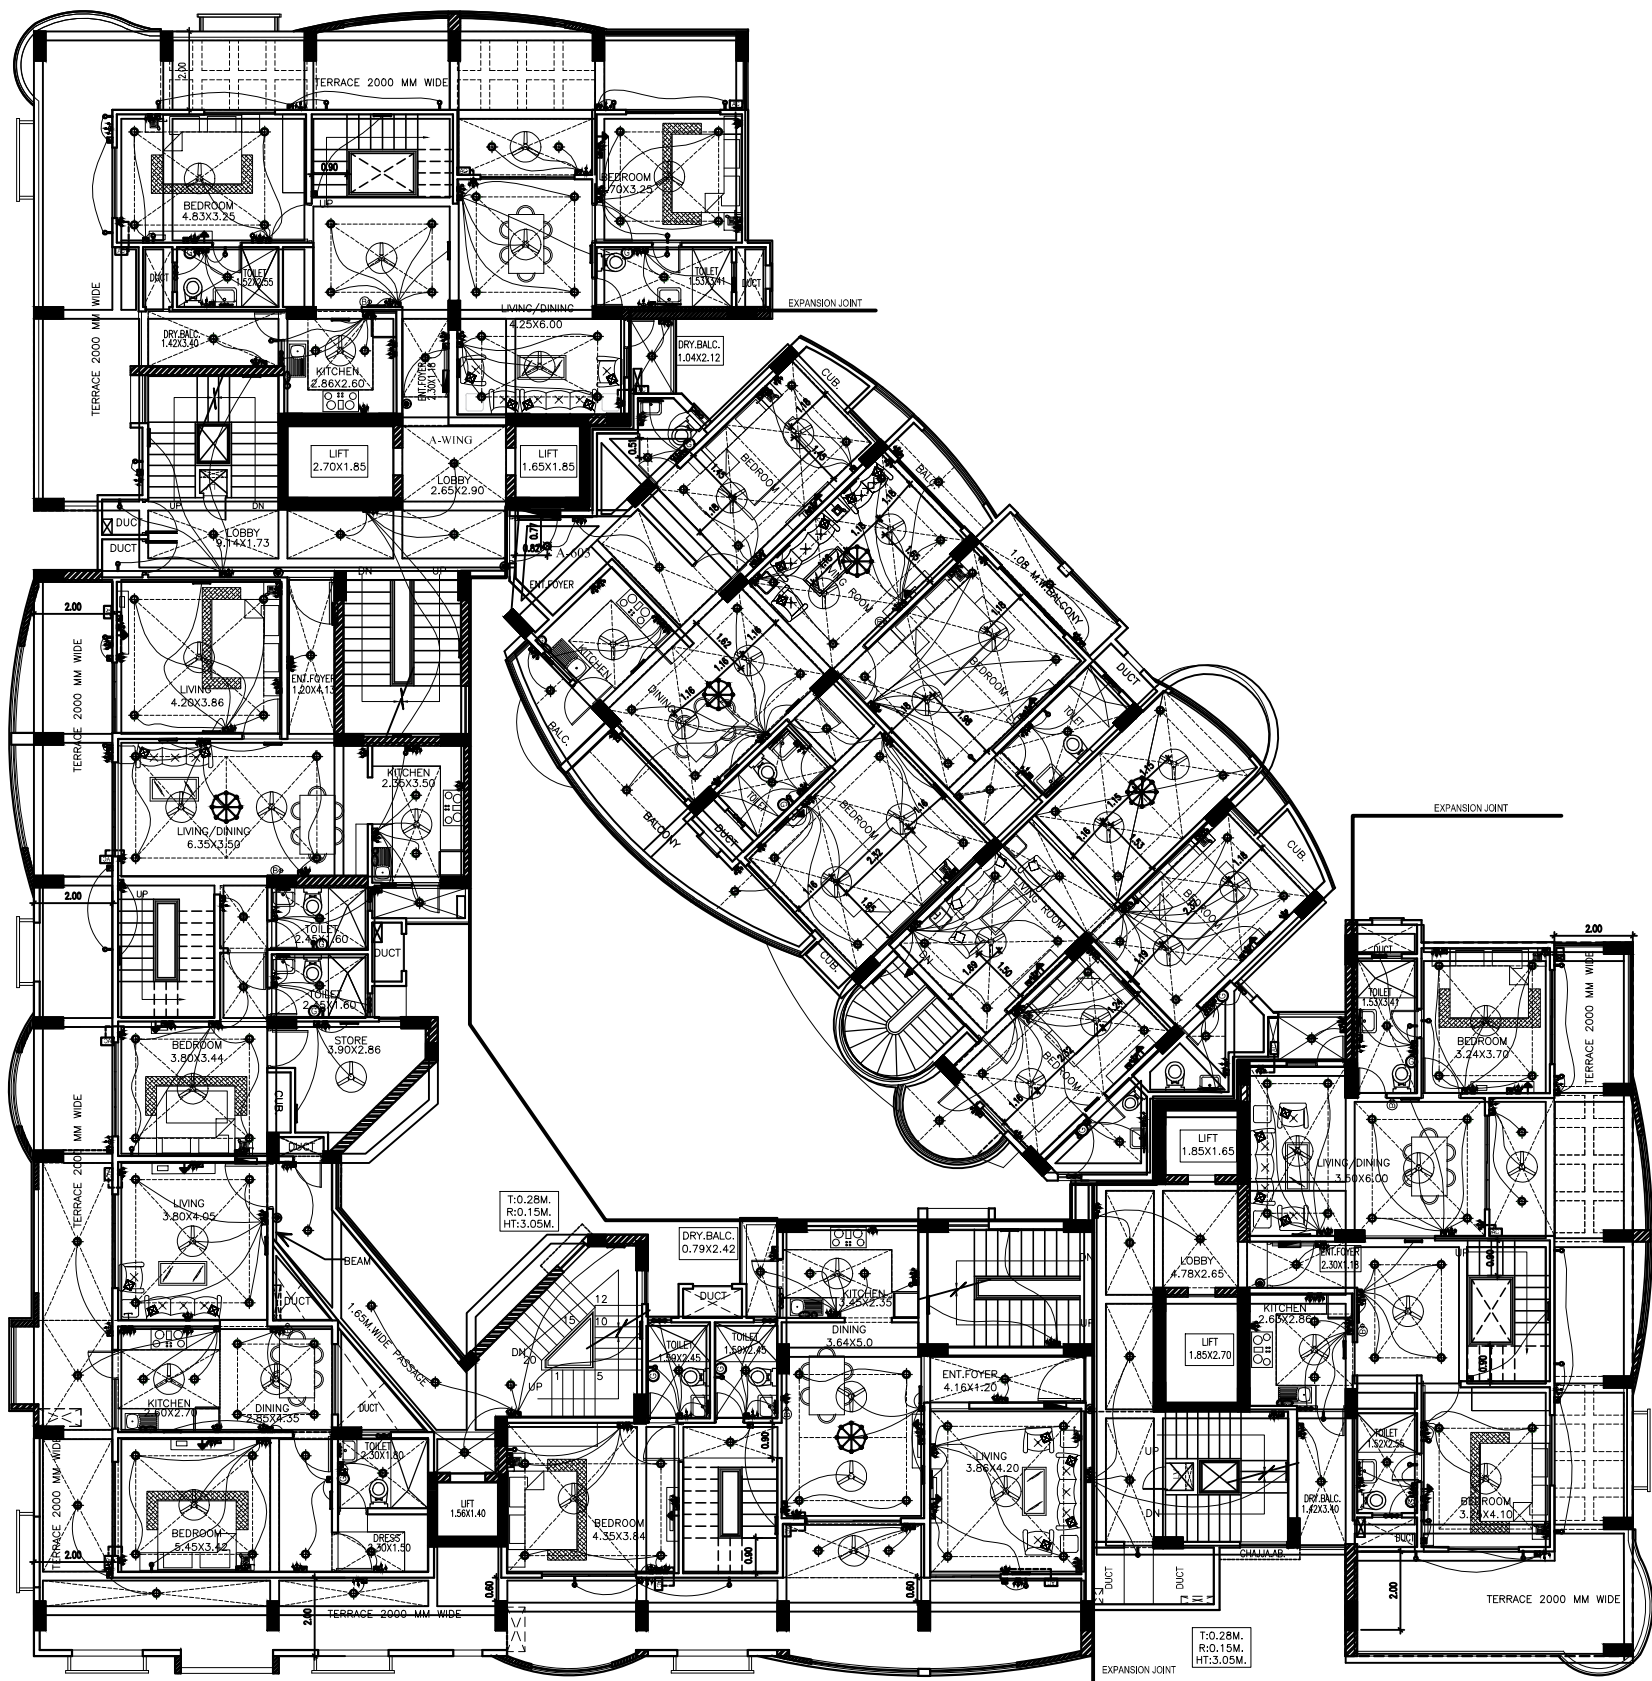

S. No.	SYMBOL	DESCRIPTION	POSITION
1.		BELL PUSHER DOOR BELL	1000
2.		LIGHT POINT WALL BRACKET	2100
3.		CEILING LIGHT (SURFACE)	2100
4.		1 X 30 WATT TUBE LIGHT	2100
5.		BELL BUZZER	2100
6.		MIRROR LIGHT (1.8 W)	2000
7.		CEILING FAN	2100
8.		EXHAUST FAN	2100
9.		10 AMP FUSION POINT	200
10.		10 AMP FUSION POINT	200
11.		20 AMP INDUSTRIAL SOCKET 1 AC POINT	200 / 1000
12.		CHANDIELIER	2000
13.		TV POINT	200
14.		TELEPHONE POINT	200
15.		SWITCHBOARD	1000
16.		GATE LIGHT	1000
17.		MAIN SWITCH	1000
18.		G.E.	1000
19.		G.E.	1000
20.		WATER PUMP	1000
21.		CHANDIELIER	1000

TENTH FLOOR PLAN
SCALE:1:100

drg. title	TENTH FLOOR PLAN ELECTRICAL PLAN		AGRAWAL & ASSOCIATE H.L.G.-42, SECTOR - E, OPP MODERN SCHOOL, ALIGANJ, LUCKNOW TEL-2329902, TELEFAX-2335494. MOBILE-9415113355	
	client	SIVANSSH INFRASTRUCTURE DEVELOPMENT PVT.LTD.	OWNER	ARCHITECT
project	GROUP HOUSING-1 AT SIVANSSH INFRASTRUCTURE DEVELOPMENT PVT.LTD. SECTOR 11 VRINDAVAN YOJNA,LUCKNOW.			
drg. no.	ALL UNITS ARE IN MTRS.		scale: N.T.S. date: 04.02.2017 draw: MONIKA	10