



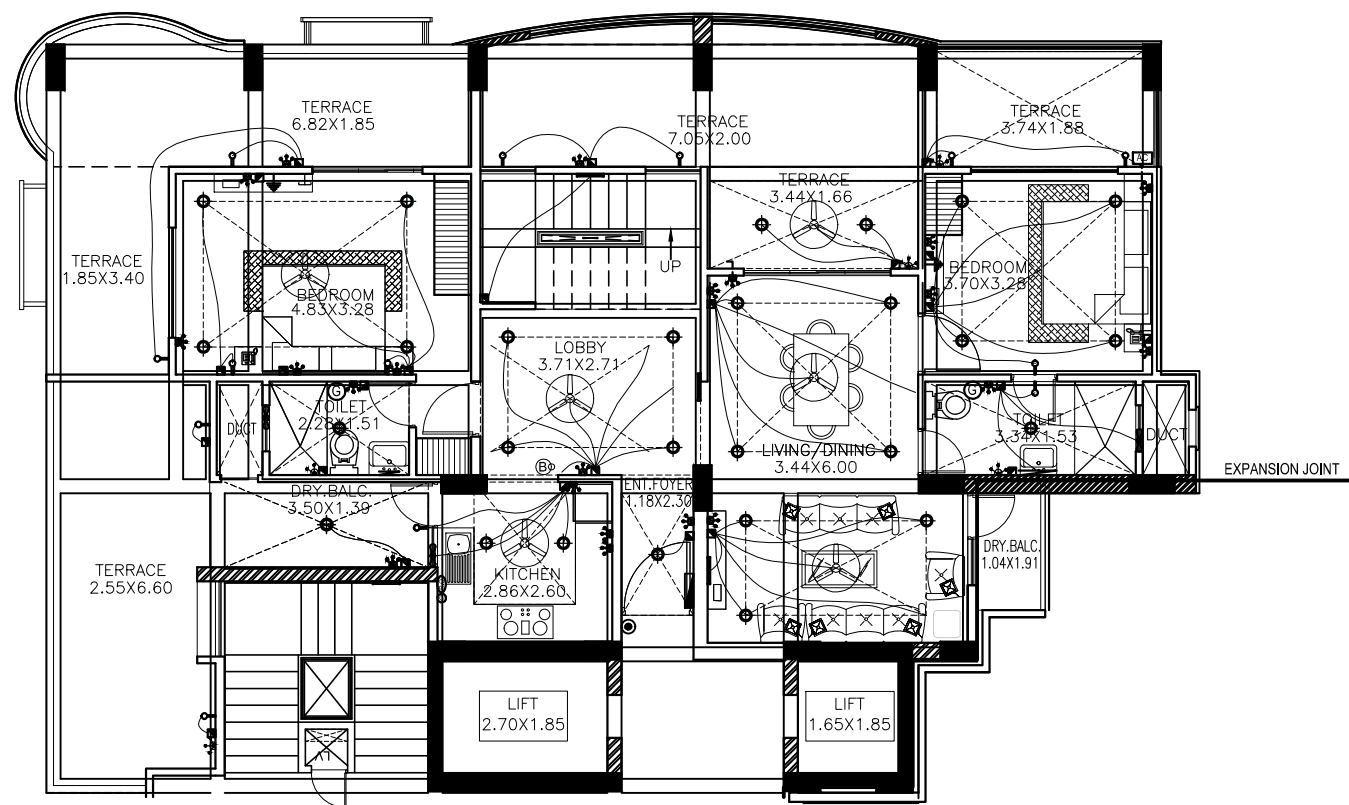

TENTH FLOOR PLAN (ELECTRICAL LAYOUT)

SCALE:1:100

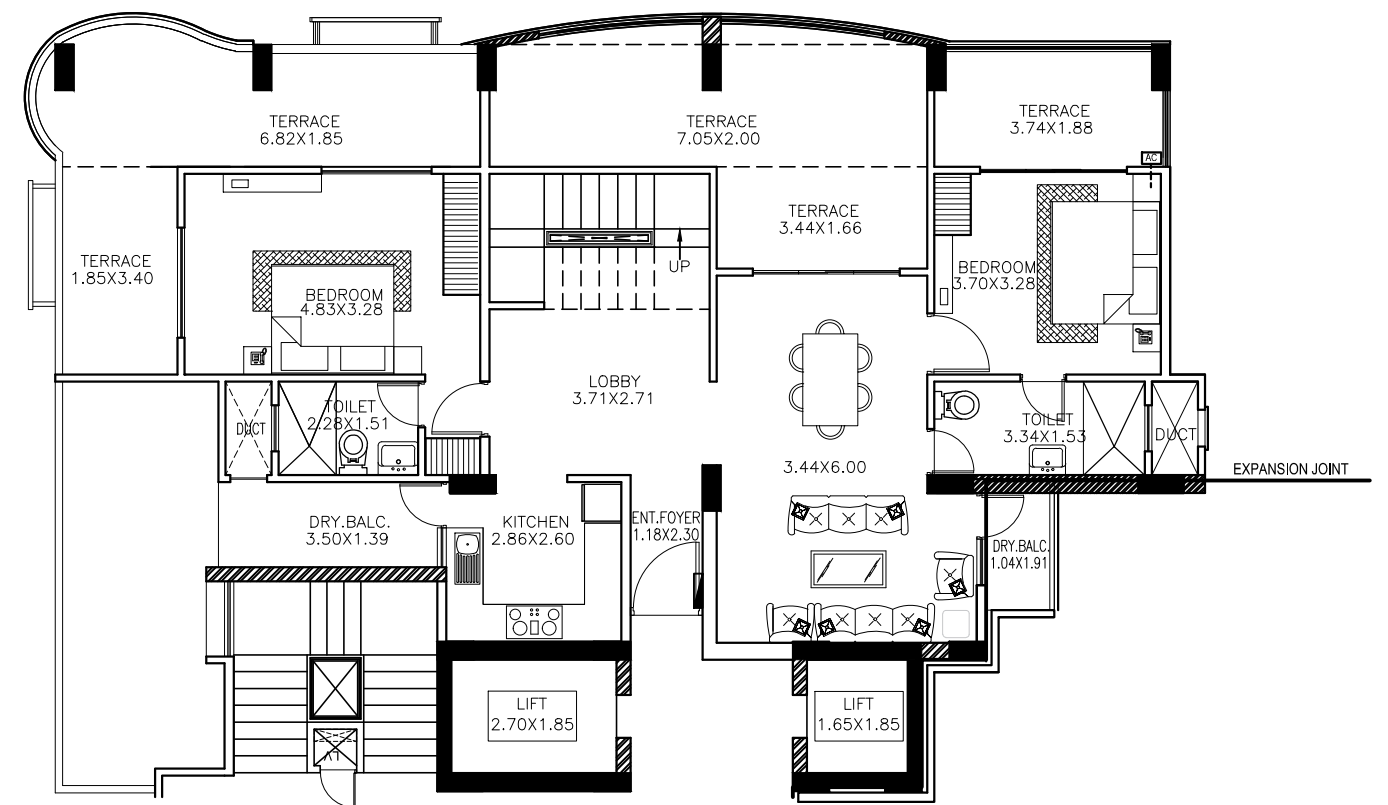

TENTH FLOOR PLAN (FURNITURE LAYOUT)

SCALE:1:100

drg. title	TENTH FLOOR PLAN ELECTRICAL N FURNITURE PLAN		architect	AGRAWAL & ASSOCIATE H.I.G.-42, SECTOR - E, OPP MODERN SCHOOL, ALIGANJ, LUCKNOW TEL-2329902, TELEFAX-2335494. MOBILE-9415113355		
client	SIVANSSH INFRASTRUCTURE DEVELOPMENT PVT.LTD.		OWNER		ARCHITECT	
project	GROUP HOUSING-1 AT SIVANSSH INFRASTRUCTURE DEVELOPMENT PVT.LTD. SECTOR 11 VRINDAVAN YOJNA,LUCKNOW.		drg. no	ALL UNITS ARE IN MTRS.	scale: N.T.S.	10
					date: 28-07-2017	
					dealt : ASHWINI	