


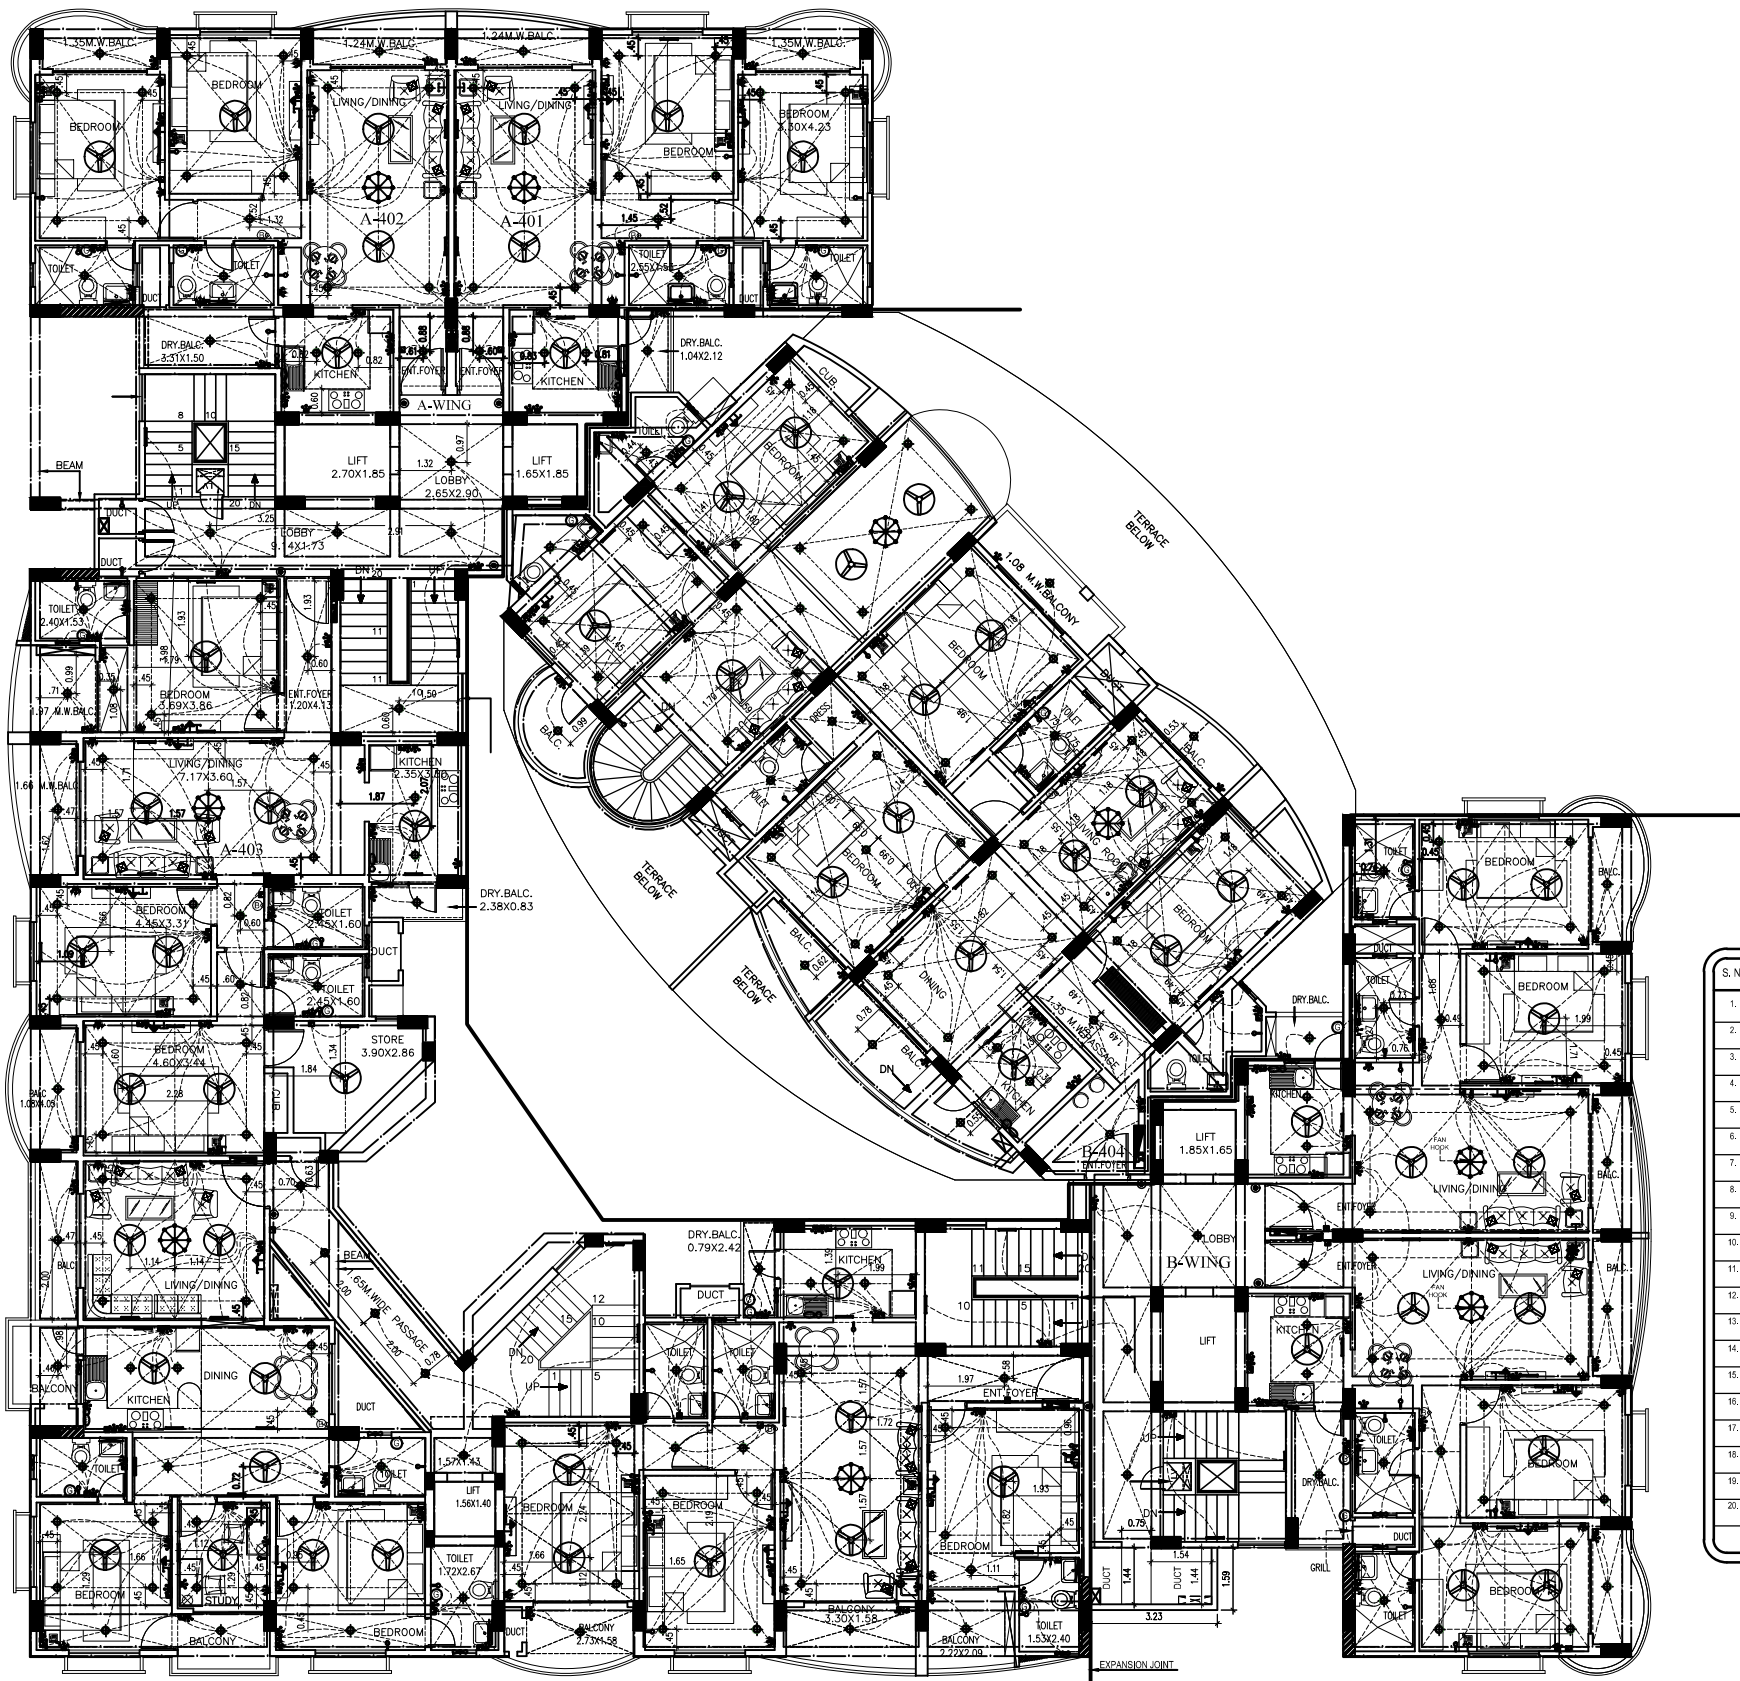

| S. No. | SYMBOL | DESCRIPTION                         | POSITION   |
|--------|--------|-------------------------------------|------------|
| 1.     |        | BELL PUSHER/DOOR BELL               | 1050       |
| 2.     |        | LIGHT POINT WALL BRACKET            | 2100       |
| 3.     |        | CEILING LIGHT (SURFACE)             | CEILING    |
| 4.     |        | 1 X 36 WATT TUBE LIGHT              | 2100       |
| 5.     |        | BELL BUZZER                         | 2100       |
| 6.     |        | MIRROR LIGHT (18 W)                 | 2000       |
| 7.     |        | CEILING FAN                         | CEILING    |
| 8.     |        | EXHAUST FAN                         | 2100       |
| 9.     |        | 10/15 AMP PLUG POINT                | 200        |
| 10.    |        | 20 AMP INDUSTRIAL SOCKET / AC POINT | 200 / 1050 |
| 11.    |        | CHANDELIER                          | CEILING    |
| 12.    |        | T.V. POINT                          | 200        |
| 13.    |        | TELEPHONE POINT                     | 200        |
| 14.    |        | SWITCH BOARD                        | 1050       |
| 15.    |        | GATE LIGHT                          | 1500       |
| 16.    |        | MAIN METER                          | 1050       |
| 17.    |        | D.B.                                | 1050       |
| 18.    |        | GEYSER                              | 1950       |
| 19.    |        | WATER PURIFIER                      | 1800       |
| 20.    |        | CHIMNEY HOOD                        | 1500       |

|            |                                                                                                          |                                                               |                     |
|------------|----------------------------------------------------------------------------------------------------------|---------------------------------------------------------------|---------------------|
| fig. title | FOURTH FLOOR PLAN<br>ELECTRICAL LAYOUT                                                                   | architect                                                     | AGRAWAL & ASSOCIATE |
| client     | SIVANSSH INFRASTRUCTURE DEVELOPMENT<br>PVT.LTD.                                                          | OWNER                                                         | ARCHITECT           |
| project    | GROUP HOUSING-1 AT SIVANSSH<br>INFRASTRUCTURE DEVELOPMENT PVT.LTD.<br>SECTOR 11 VRINDAVAN YOJNA,LUCKNOW. | 04                                                            |                     |
| fig. no    | ALL UNITS<br>ARE IN MTRS.                                                                                | scale: 1:15<br>date: 08-07-2019<br>auth: ASHWINI H. GANDHARDE |                     |