


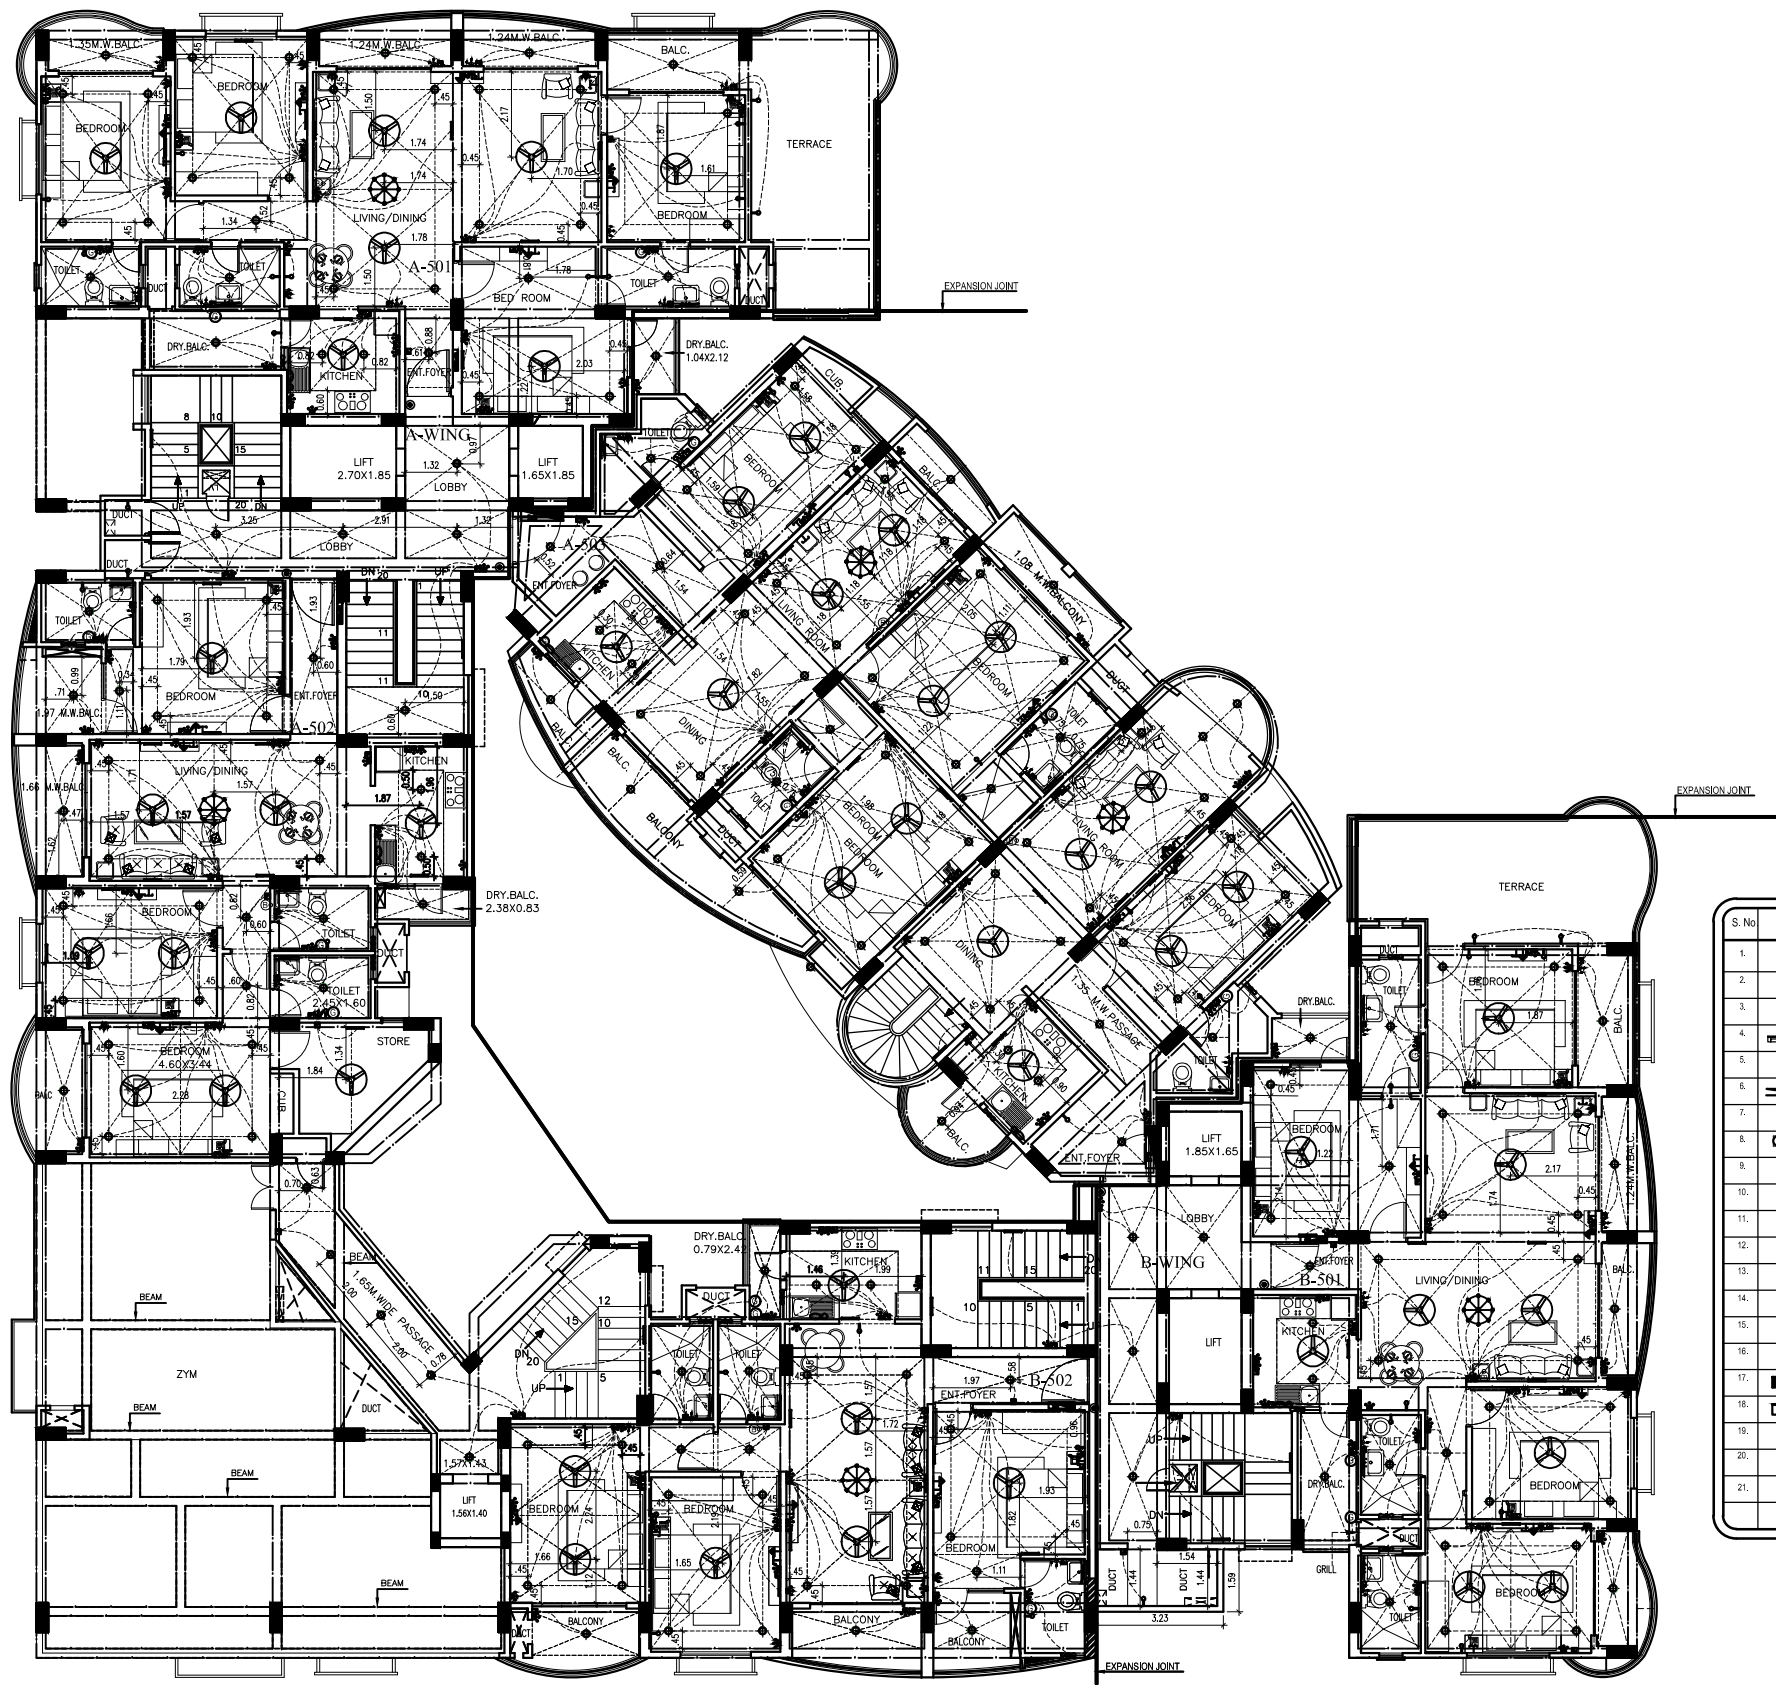

S. No	SYMBOL	DESCRIPTION	POSITION
1.		BELL PUSHER/ DOOR BELL	1050
2.		LIGHT POINT/ WALL BRACKET	2100
3.		CEILING LIGHT (SURFACE)	CEILING
4.		1 X 36 WATT TUBE LIGHT	2100
5.		BELL BUZZER	2100
6.		MIRROR LIGHT (18 W)	2000
7.		CEILING FAN	CEILING
8.		EXHAUST FAN	2100
9.		10 AMP PLUG POINT	200
10.		15 AMP POWER POINT	200
11.		20 AMP. INDUSTRIAL SOCKET / AC POINT	200 / 1950
12.		CHANDELIER	CEILING
13.		T.V POINT	200
14.		TELEPHONE POINT	200
15.		SWITCH BOARD	1950
16.		GATE LIGHT	1500
17.		MAIN METER	1000
18.		D.B.	1050
19.		GEYSER	1950
20.		WATER PURIFIER	1800
21.		CHIMNEY/ HOOD	1950

FIFTH FLOOR PLAN
SCALE:1:100

drg. title	FIFTH FLOOR PLAN ELECTRICAL PLAN	architect	AGRAWAL & ASSOCIATE	
			OWNER	ARCHITECT
client	SIVANSSH INFRASTRUCTURE DEVELOPMENT PVT.LTD.	project		
project	GROUP HOUSING-1 AT SIVANSSH INFRASTRUCTURE DEVELOPMENT PVT.LTD. SECTOR 11 VRINDAVAN YOJNA,LUCKNOW.			
drg. no			ALL UNITS ARE IN MTRS.	03