


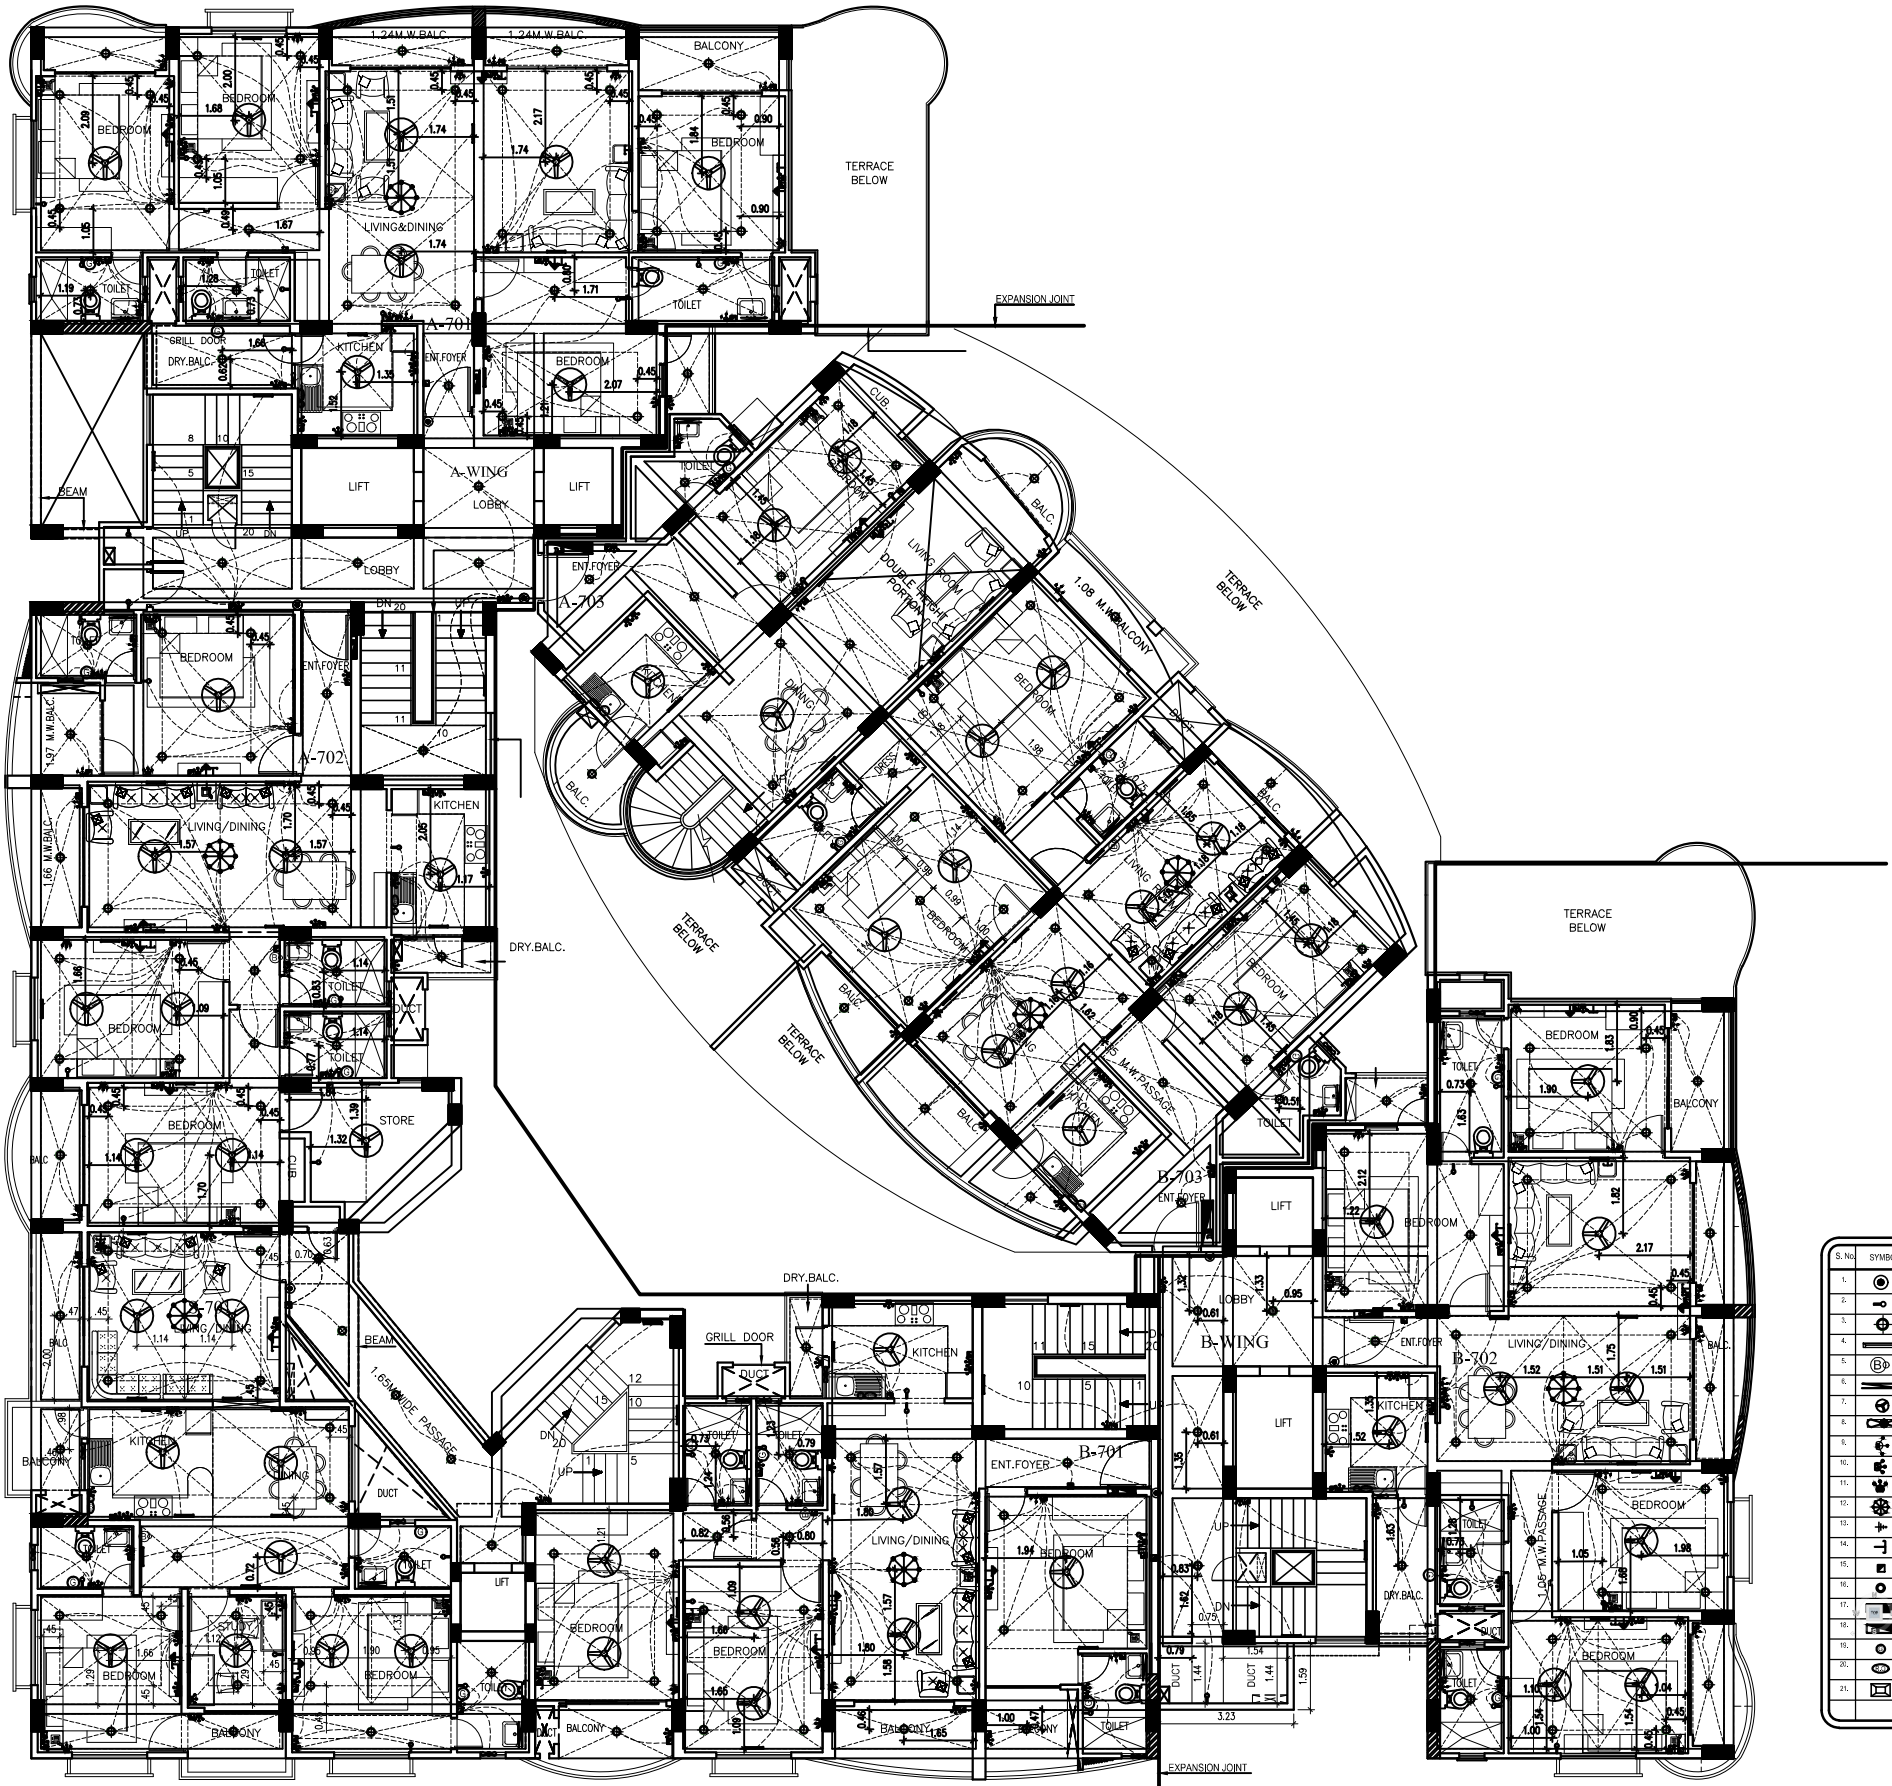

S.No.	SYMBOL	DESCRIPTION	POSITION
1.		BELL PUSHER DOOR BELL	1050
2.		LIGHT POINT WALL BRACKET	2500
3.		CEILING LIGHT (SURFACE)	2500
4.		1 X 36 WATT TUBE LIGHT	2500
5.		BELL BUZZER	2500
6.		MIRROR LIGHT (18 W)	2000
7.		CEILING FAN	CEILING
8.		EXHAUST FAN	2500
9.		10 AMP PLUG POINT	250
10.		15 AMP POWER POINT	200
11.		20 AMP INDUSTRIAL SOCKET/AC POINT	200 / 1050
12.		CHANDLIER	CEILING
13.		TV POINT	200
14.		TELEPHONE POINT	200
15.		SWITCH BOARD	1050
16.		GATE LIGHT	1500
17.		WATER METER	1050
18.		D/L	1050
19.		GEYSER	1050
20.		WATER PURIFIER	1050
21.		CHIMNEY HOOD	1500

SEVENTH FLOOR PLAN
SCALE:1:100

Project	Client	SEVENTH FLOOR ELECTRICAL LAYOUT PLAN	AGRAWAL & ASSOCIATE	
	SIVANSSH INFRASTRUCTURE DEVELOPMENT PVT.LTD.		OWNER	ARCHITECT
Project	GROUP HOUSING-1 AT SIVANSSH INFRASTRUCTURE DEVELOPMENT PVT.LTD. SECTOR 11 VRINDAVAN YOJNA,LUCKNOW.			