


9 TH FLOOR PLAN
ADVANCED COPY

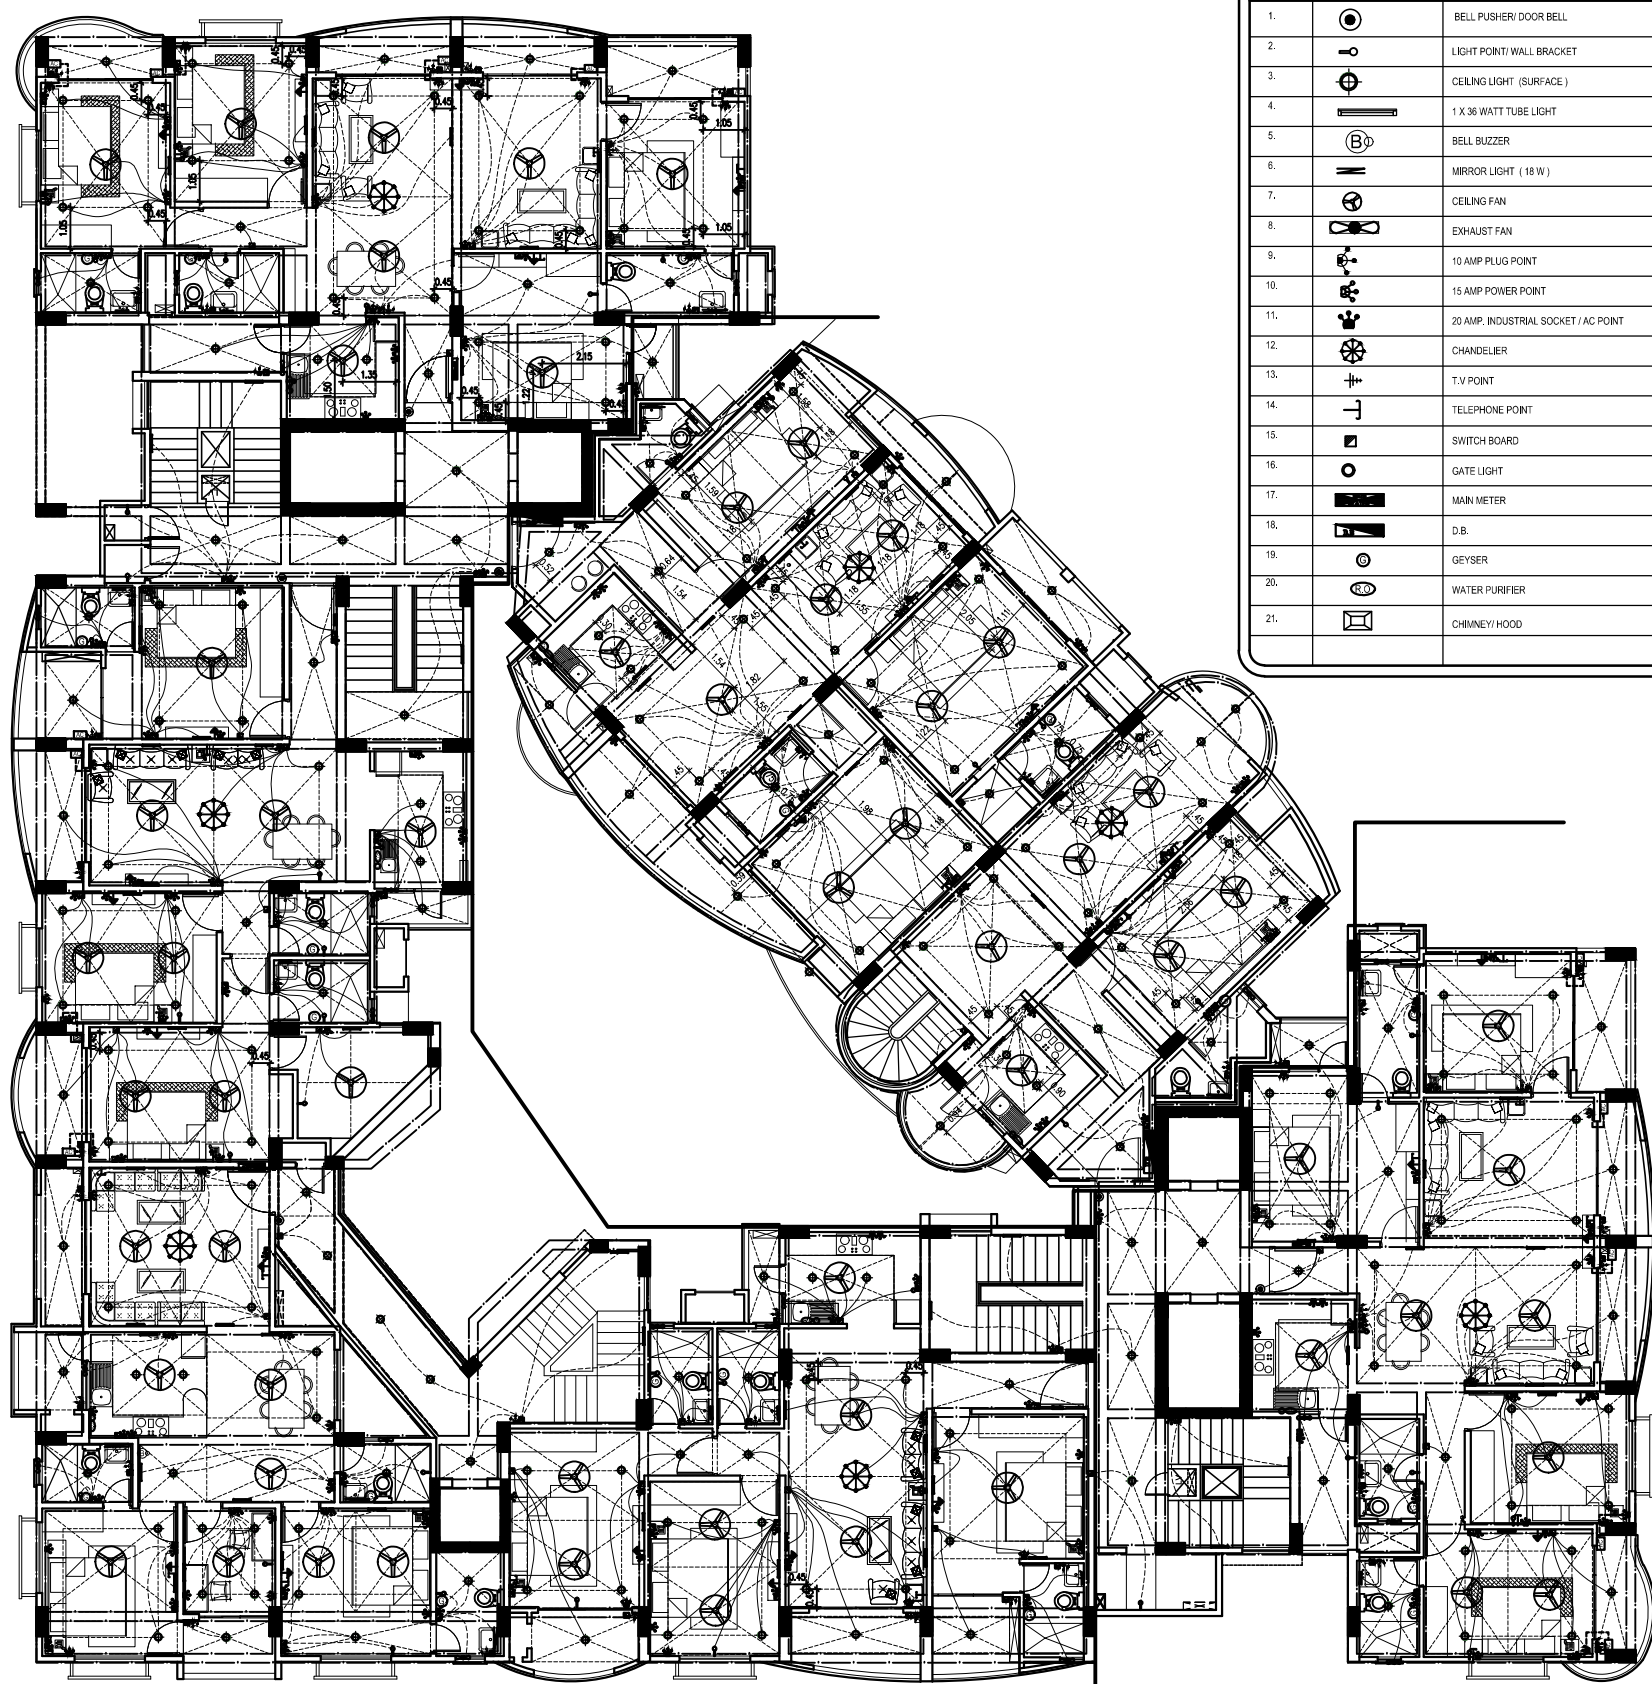

S.No.	SYMBOL	DESCRIPTION	POSITION
1.		BELL PUSHER/ DOOR BELL	1050
2.		LIGHT POINT/ WALL BRACKET	2100
3.		CEILING LIGHT (SURFACE)	CEILING
4.		1 X 36 WATT TUBE LIGHT	2100
5.		BELL BUZZER	2100
6.		MIRROR LIGHT (18 W)	2000
7.		CEILING FAN	CEILING
8.		EXHAUST FAN	2100
9.		10 AMP PLUG POINT	200
10.		15 AMP POWER POINT	200
11.		20 AMP. INDUSTRIAL SOCKET / AC POINT	200 / 1050
12.		CHANDELIER	CEILING
13.		T.V POINT	200
14.		TELEPHONE POINT	200
15.		SWITCH BOARD	1050
16.		GATE LIGHT	1500
17.		MAIN METER	1050
18.		D.B.	1050
19.		GEYSER	1950
20.		WATER PURIFIER	1800
21.		CHIMNEY/ HOOD	1500

NINE FLOOR PLAN

project	client	architect	AGRAWAL & ASSOCIATE H.L.G.-42, SECTOR - E, OPP MODERN SCHOOL, ALIGANJ, LUCKNOW TEL-2329902, TELEFAX-2335494. MOBILE-9415113355	
			OWNER	ARCHITECT
project	client	architect	SIVANSSH INFRASTRUCTURE DEVELOPMENT PVT.LTD.	
			GROUP HOUSING-1 AT SIVANSSH INFRASTRUCTURE DEVELOPMENT PVT.LTD. SECTOR 11 VRINDAVAN YOJNA,LUCKNOW.	
project	client	architect	ALL UNITS ARE IN MTRS.	scale: N.T.S. date: 26-02-2016 sheet: Ashrini
				09