


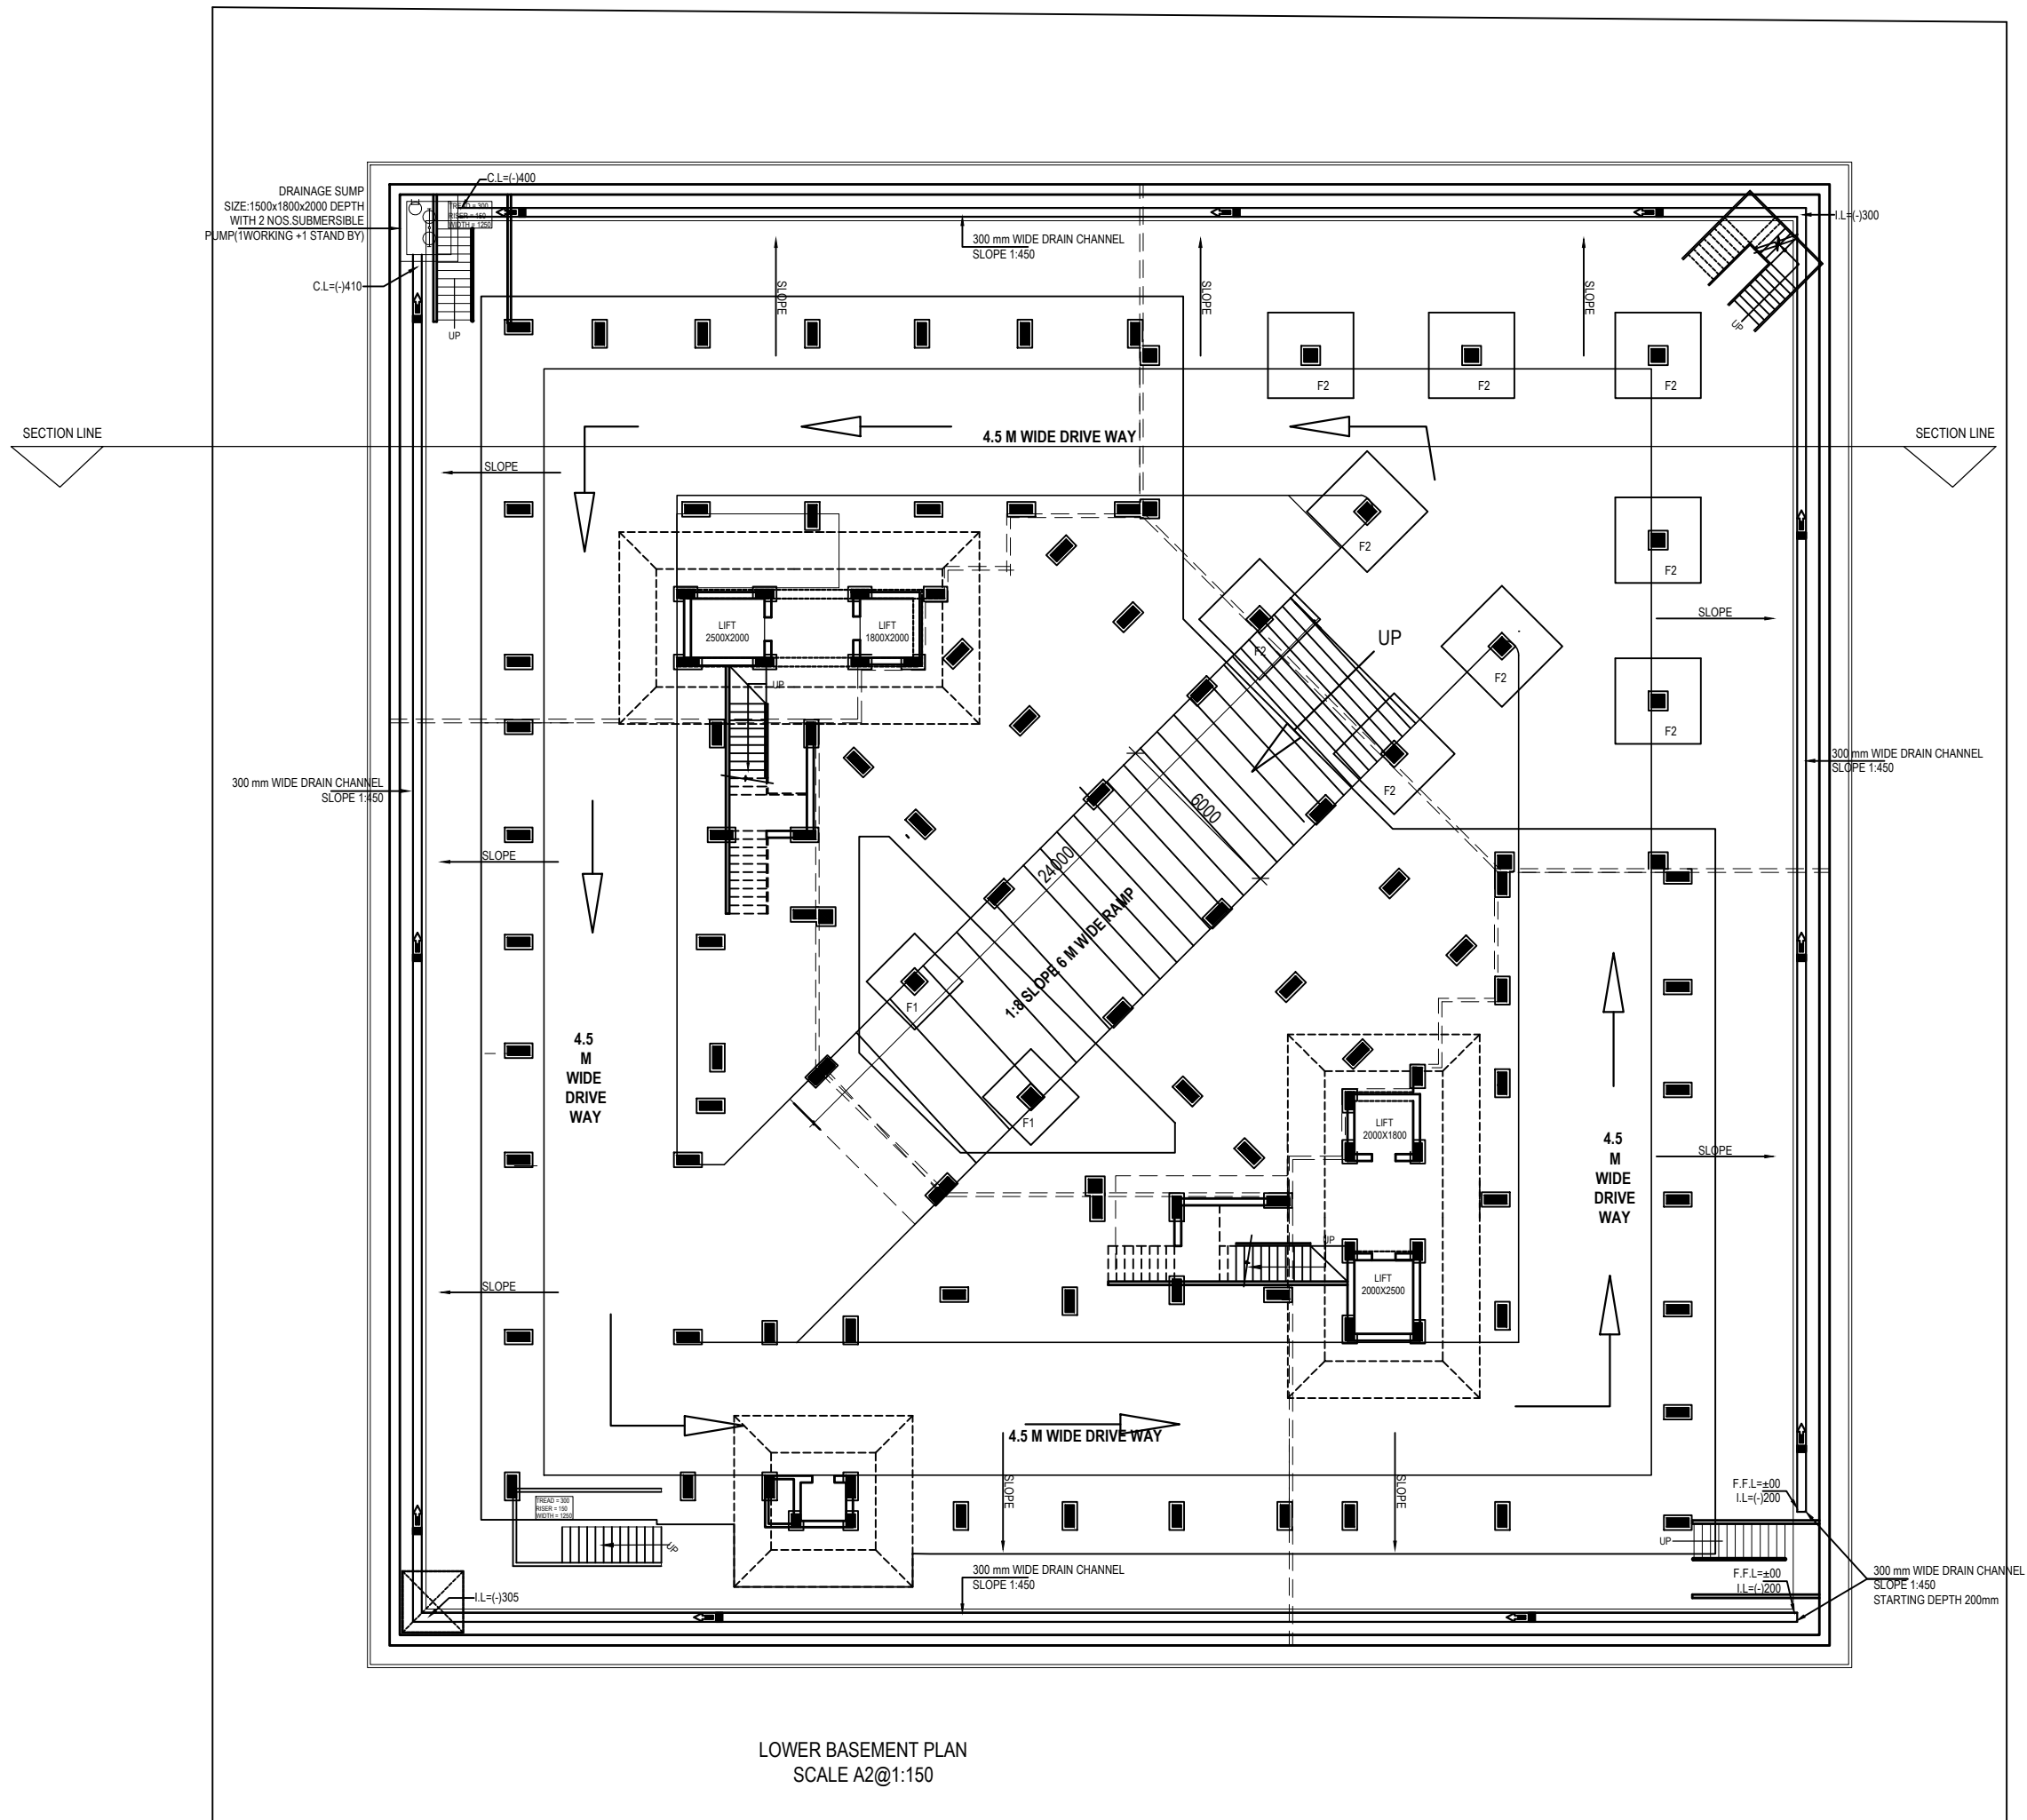

LOWER BASEMENT PLAN
SCALE A2@1:150

LEGEND :

S. No.	SYMBOL	DESCRIPTION	POSITION

NOTES :

rev. no.	date	revision

project **GROUP HOUSING FOR SIVANSSH
INFRASTRUCTURE DEVELOPMENT PVT.LTD.
AT GH-1, SECTOR-11, VRINDAVAN
YOJNA,LUCKNOW.**

title
PLUMBING DRAWING

subtitle
BASEMENT FLOOR PLAN

drawing released for
☒ **APPROVAL** ☐ **SUBMISSION**
☐ **ADVANCE COPY** ☐ **CONSTRUCTION**

drg. no. **SUKHADA / PL-01** drawn by **Imran**

scale **A2@1:175** designed by **Shakir shabbir**

date **14.01.2015** checked by **Anand Havelia**

architects
AGRAWAL & ASSOCIATE

services consultant
Consummate Engineering Services (P) Ltd.
Noida Office : B - 67, Sector - 67, Noida - 201 301
Tel : (0120) 2593500 (30 Lines)
Lko. Office : R 006, Rohtas Plumeria, Gomti Nagar, Lucknow
Tel : (0522) 6515455
e mail : mail@cespl.in, website : www.cespl.in

