


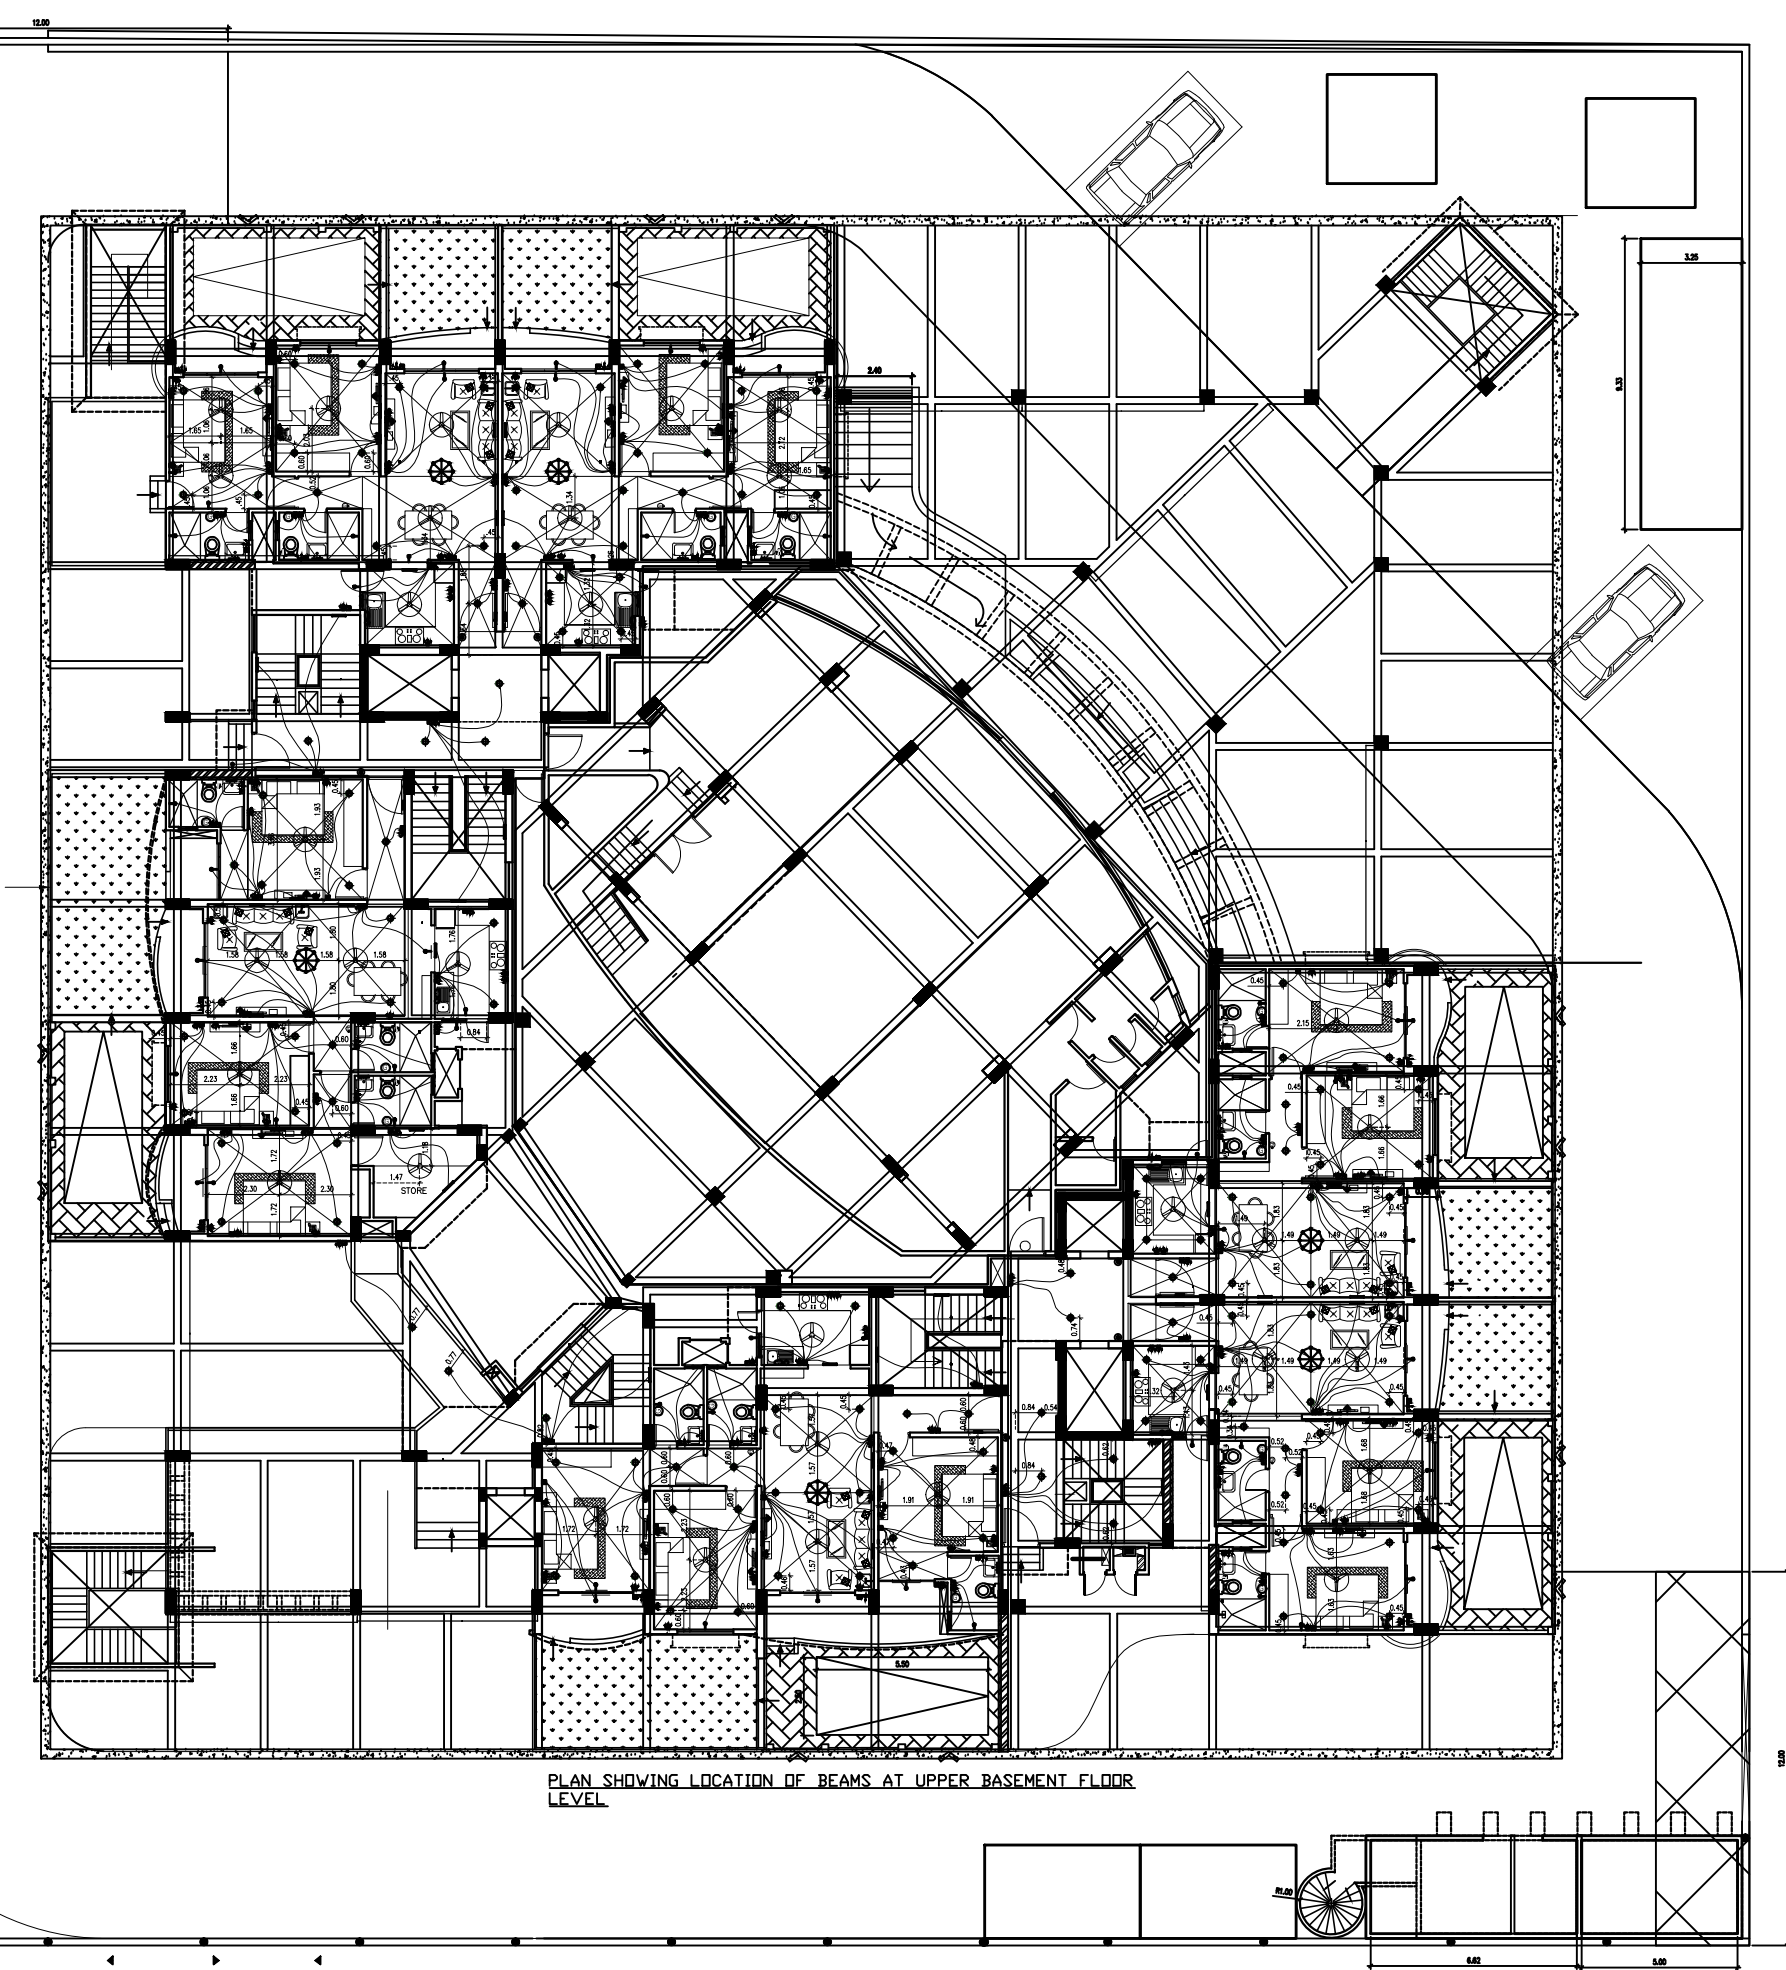

PLAN SHOWING LOCATION OF BEAMS AT UPPER BASEMENT FLOOR LEVEL

S. No.	SYMBOL	DESCRIPTION	POSITION
1.		BELL PUSHER/ DOOR BELL	1050
2.		LIGHT POINT/ WALL BRACKET	2100
3.		CEILING LIGHT (SURFACE)	CEILING
4.		1 X 36 WATT TUBE LIGHT	2100
5.		BELL BUZZER	2100
6.		MIRROR LIGHT (18 W)	2000
7.		CEILING FAN	CEILING
8.		EXHAUST FAN	2100
9.		10 AMP PLUG POINT	200
10.		15 AMP POWER POINT	200
11.		20 AMP INDUSTRIAL SOCKET / AC POINT	200 / 1050
12.		CHANDIELIER	CEILING
13.		T.V POINT	200
14.		TELEPHONE POINT	200
15.		SWITCH BOARD	1050
16.		GATE LIGHT	1050
17.		MAIN METER	1050
18.		D.B.	1050
19.		GEYSER	1050
20.		WATER PURIFIER	1800
21.		CHIMNEY HOOD	1000

drg. title	GROUND FLOOR (ELECTRICAL LAYOUT)			
	project	GROUP HOUSING-1 AT SIVANSSH INFRASTRUCTURE DEVELOPMENT PVT.LTD. SECTOR 11 VERANDAVAN YOJNA,LUCKNOW.		
		client	SIVANSSH INFRASTRUCTURE DEVELOPMENT PVT.LTD.	
			architect	AGRAWAL & ASSOCIATE
drg. no	OWNER		ARCHITECT	
		scale: 1:100	02	
		date: 12 - 10 - 2016		
		drawn:		