




प्लान नं. 17-महाराष्ट्र राज्य शासन, मुंबई
सर्व अधिकार सुरक्षित 1997

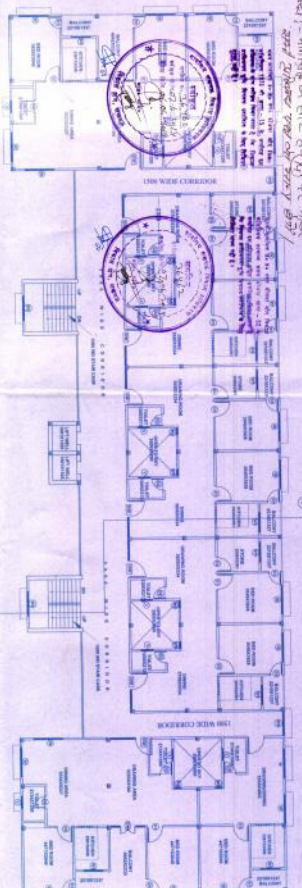


PROPOSED TYPICAL FLOOR PLAN (10th TO 12th FLOOR PLAN) (BLOCK - A)
SCALE: 1:100

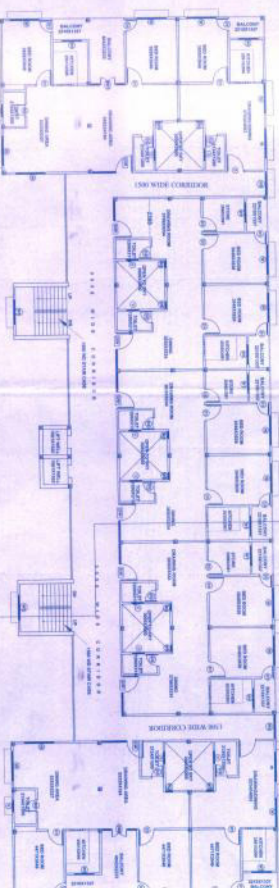

EXISTING TYPICAL FLOOR PLAN (7th TO 8th FLOOR PLAN) (BLOCK - A)
SCALE: 1:100

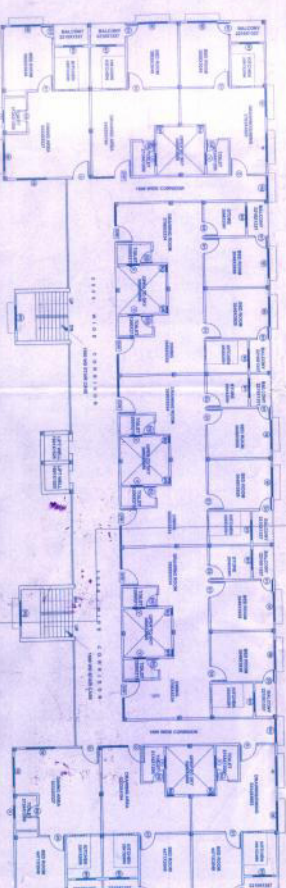

EXISTING TYPICAL FLOOR PLAN (1st TO 6th FLOOR PLAN) (BLOCK - A)
SCALE: 1:100

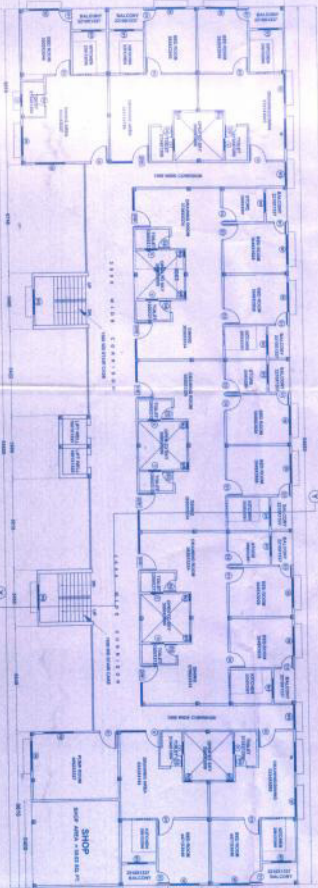


EXISTING GROUND FLOOR PLAN (BLOCK - A)
SCALE: 1:100



LOCATION PLAN (L.D.A.)
SCALE: 1:100



CHHATRAPATI SHIVAJI MAHARAJ TERMINUS
KEY / LOCATION - PLAN
SCALE: 1:100

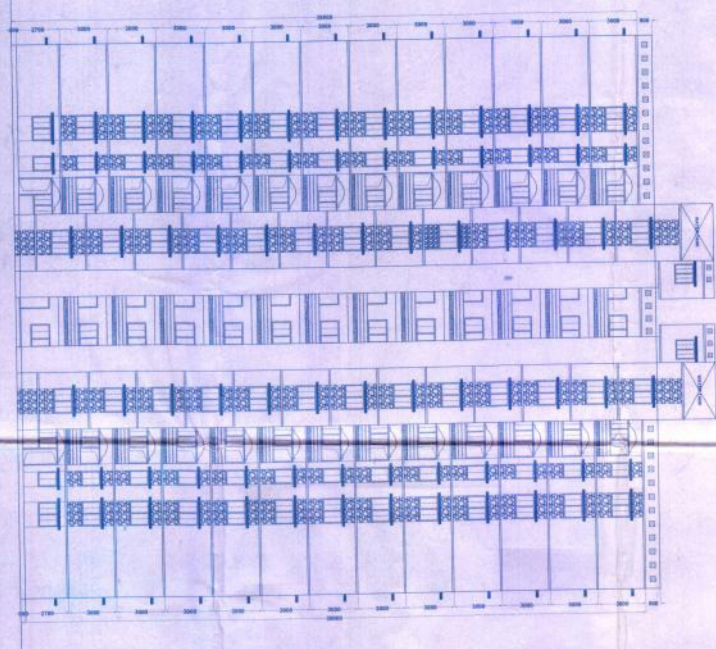

PROPOSED FRONT ELEVATION (BLOCK - A)
SCALE: 1:100

REVISED EXISTING CLIM
PROPOSED GROUP HOUSING
BUILDING PLAN FOR M.S.
DRAGON AGE REALTORS PVT.
LTD. ON KHASRA NO. 35 AND 36
SITUATED AT SARAI SHENK,
CHINMAT, LUCKNOW.

DOOR, WINDOW & VENTILATION SCHEDULE

NO.	ITEM	QTY	UNIT	VAL.	REMARKS
1	DOOR	100	SQ. FT.	1000	
2	WINDOW	200	SQ. FT.	2000	
3	VENTILATION	100	SQ. FT.	1000	
4	DOOR	100	SQ. FT.	1000	
5	WINDOW	200	SQ. FT.	2000	
6	VENTILATION	100	SQ. FT.	1000	
7	DOOR	100	SQ. FT.	1000	
8	WINDOW	200	SQ. FT.	2000	
9	VENTILATION	100	SQ. FT.	1000	
10	DOOR	100	SQ. FT.	1000	
11	WINDOW	200	SQ. FT.	2000	
12	VENTILATION	100	SQ. FT.	1000	

REFERENCE:-
1. PROPOSED GROUP HOUSING THIS
2. EXISTING GROUP HOUSING THIS
3. EXISTING GROUP HOUSING THIS
4. EXISTING GROUP HOUSING THIS
5. EXISTING GROUP HOUSING THIS
6. EXISTING GROUP HOUSING THIS
7. EXISTING GROUP HOUSING THIS
8. EXISTING GROUP HOUSING THIS
9. EXISTING GROUP HOUSING THIS
10. EXISTING GROUP HOUSING THIS
11. EXISTING GROUP HOUSING THIS
12. EXISTING GROUP HOUSING THIS

SUBMISSION
DRAWING
TOTAL SHEET NO. 14
SHEET NO. 0004
AS SHOWN THIS



DATE: 10/10/2024
BY: [Signature]
FOR: [Signature]

प्रतिबद्धा ! - भागनिष्ठ के सीट से (मि) मा. अ. मिल
एवं प्रतिबद्धा प्रकाश का प्रकाश है जो !

and apply to the one that's been
 assigned more than 100 - 120
 and are always with the same
 to have a very good chance of
 being one of the best.

[illegible]

REFERENCE

1. PROPOSED CONST. SHOWN THIS
2. EXISTING CONST. SHOWN THIS
3. SAN WATER PIPE SHOWN THIS
4. DRAIN LINE SHOWN THIS
5. ASHLEY LINE SHOWN THIS

FIRE HYDRANT SHOWN THIS

TOTAL SHEET NO.-0

	STUDENT'S SIGNATURE
	STUDENT'S SIGNATURE

