

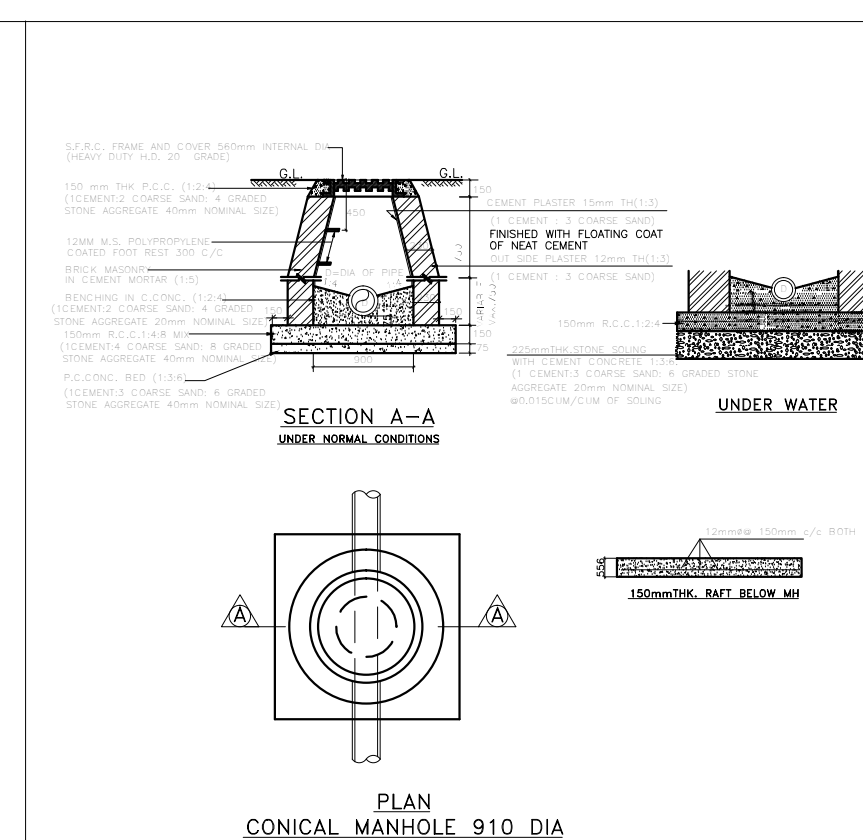
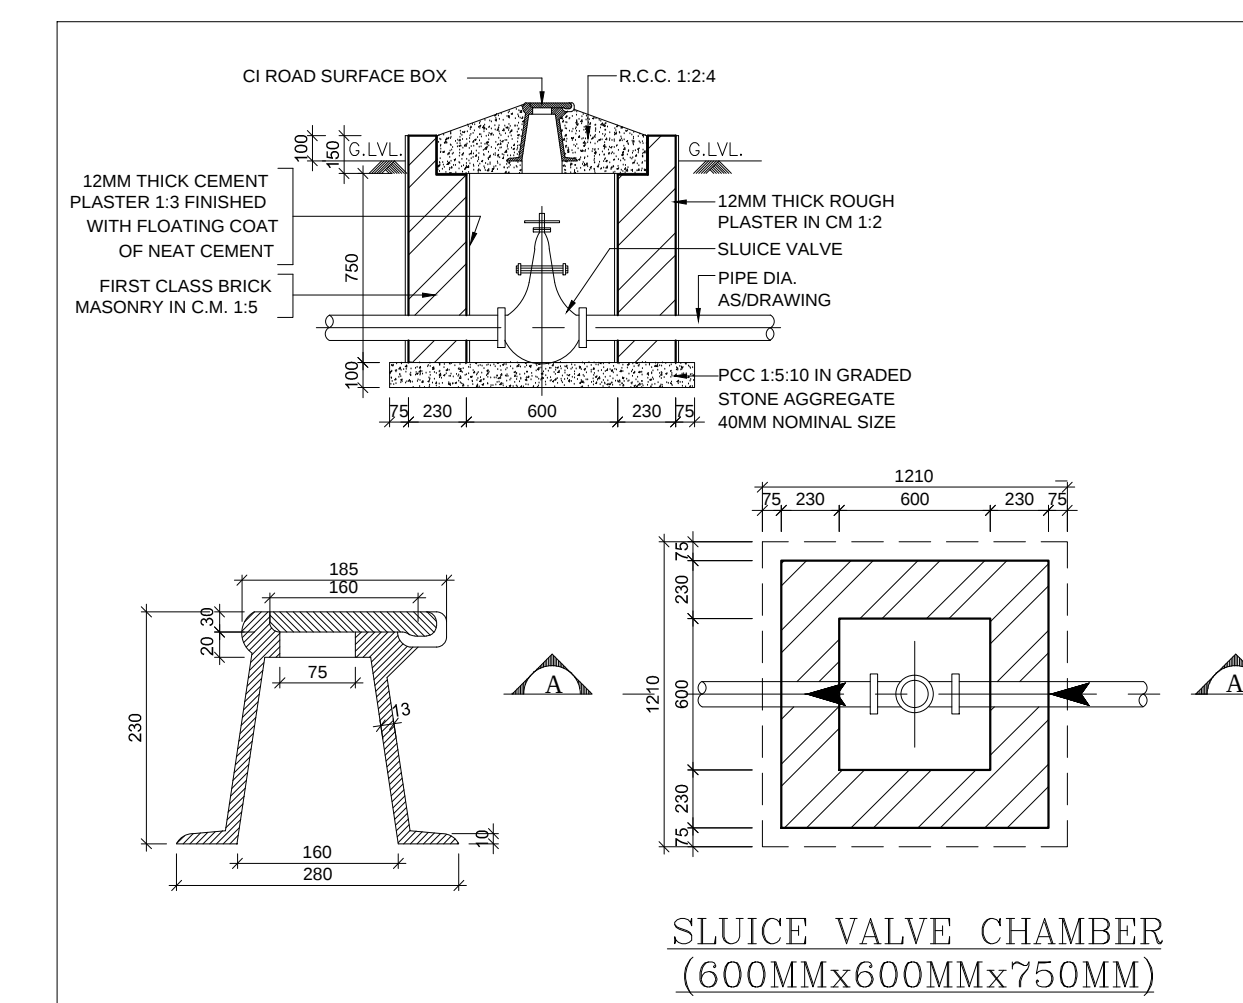
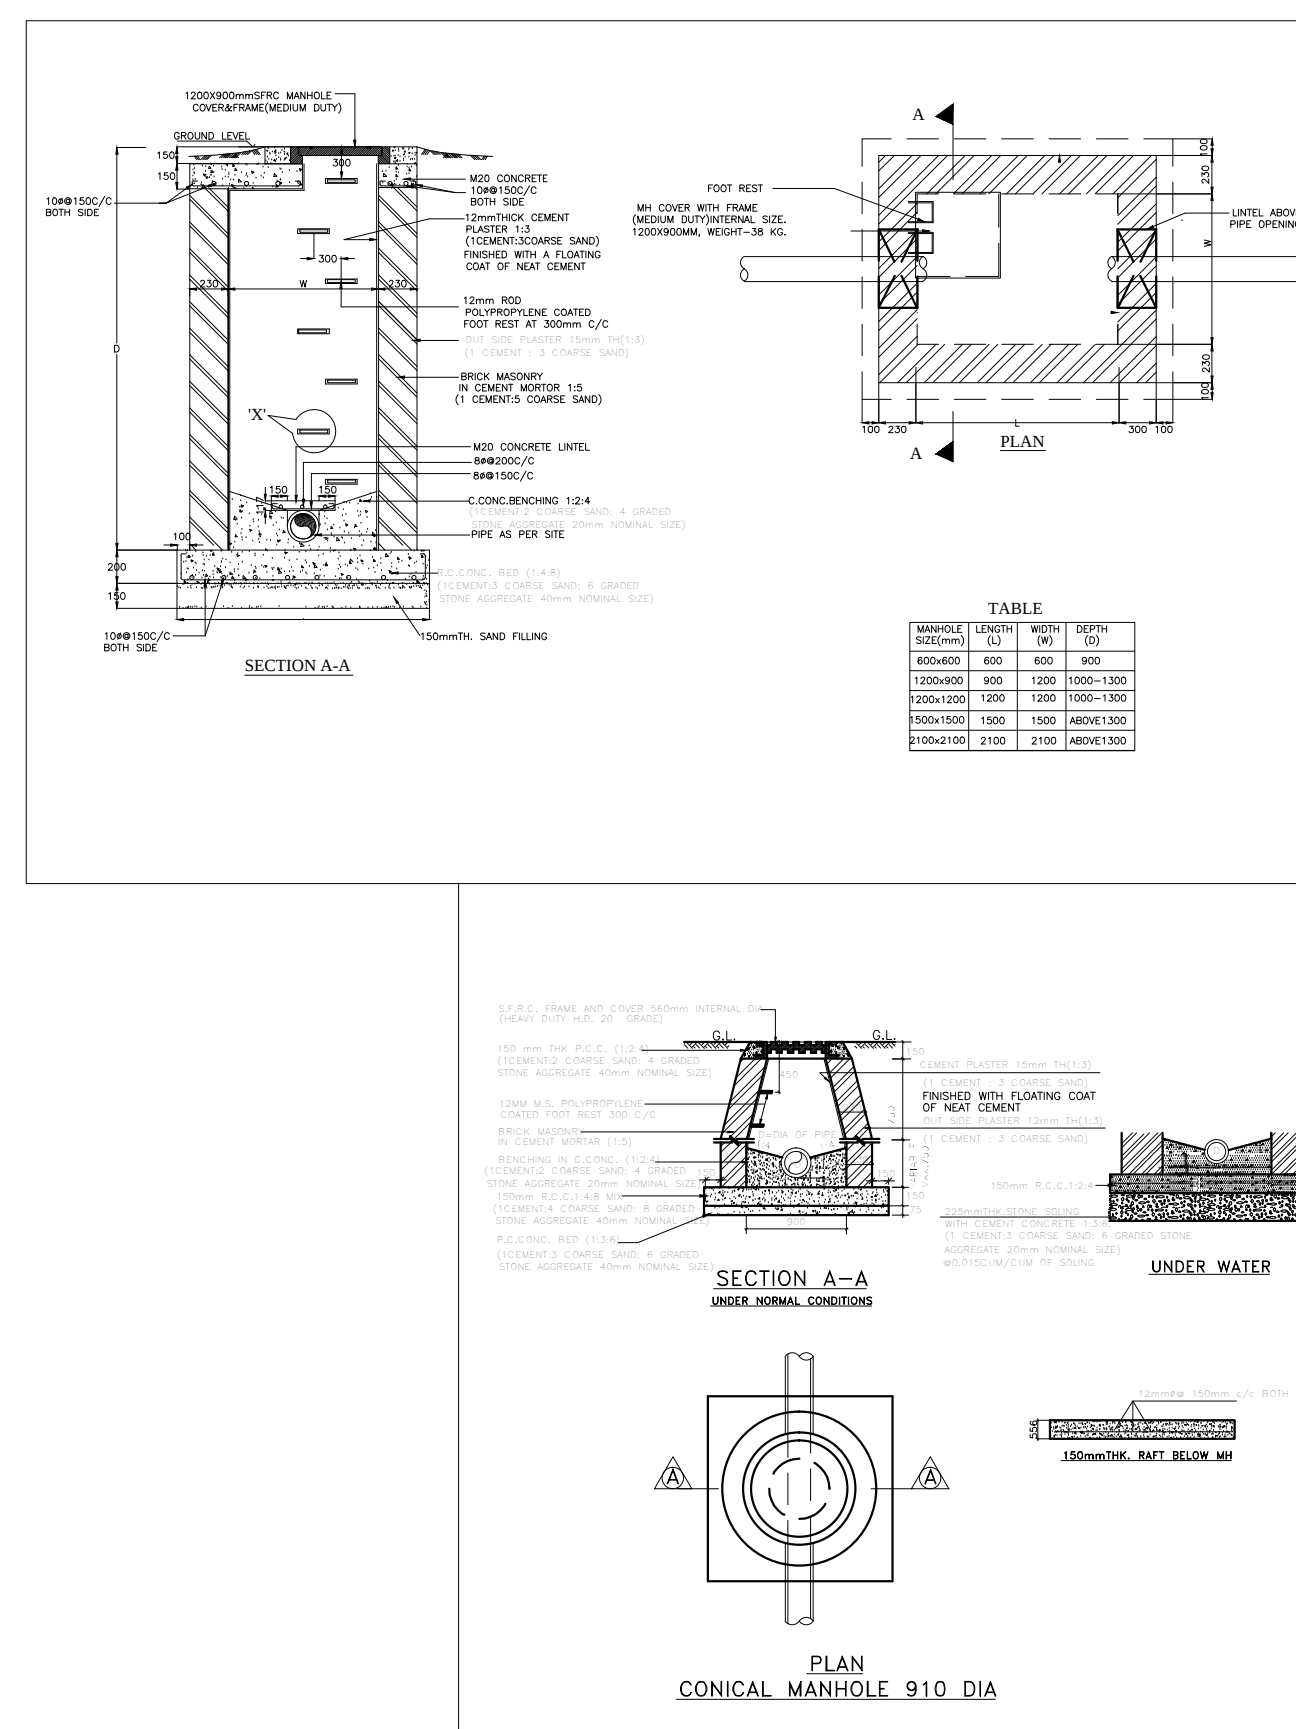
 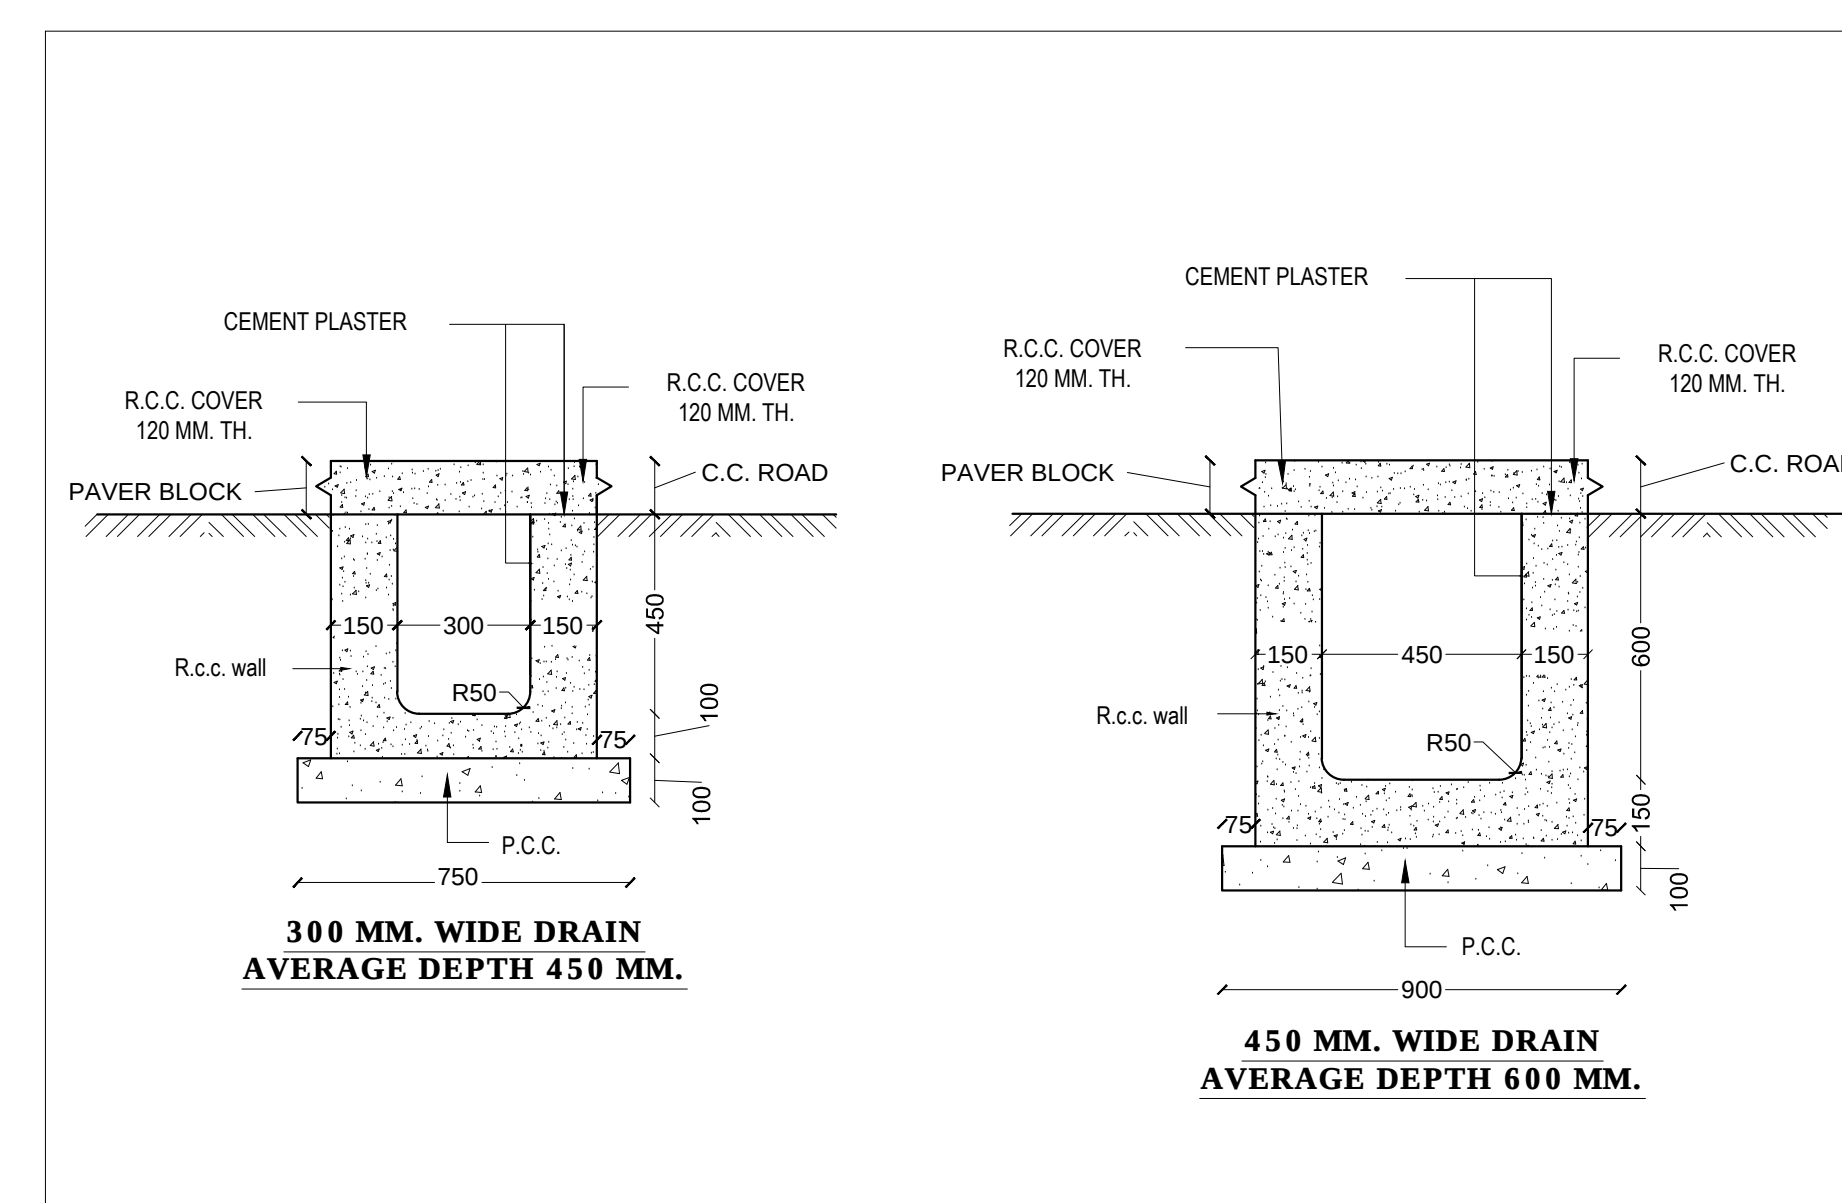
 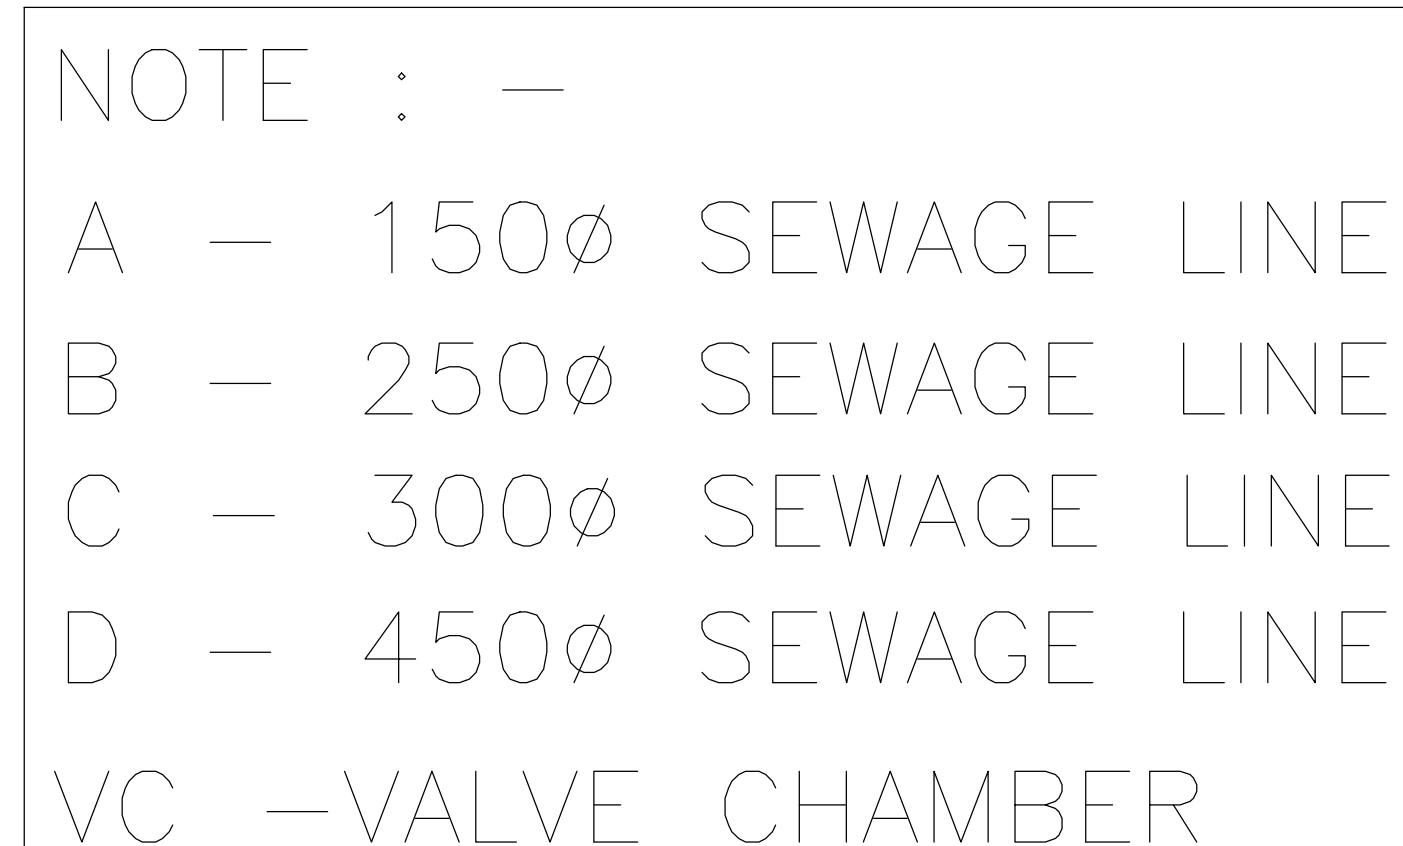




24 M WIDE ROAD



		LEGEND	HEIGHT
01		SWITCH BOARD	1050MM. FFL.
02		CEILING FAN	CEILING
03		1X18W CFL LIGHT	CEILING
04		1X28W WALL LIGHT	2250MM. FFL.
05		BRACKET LIGHT	2250MM. FFL.
06		EXHAUST FAN(600MM Ø)	
07		EXHAUST FAN(450MM Ø)	
08		TELEPHONE POINT	350MM. FFL.
09		TV POINT	1200MM. FFL.
10		5A SOCKET OUTLET	350MM. FFL.
11		15A SOCKET OUTLET	350MM. FFL.
12		GEYSER POINT	2250MM. FFL.
13		1X28W CEILING LIGHT	CEILING
14		DISTRIBUTION BOARD	1500MM. FFL.
15		BELL POINT	1050MM. FFL.
16		BUZZAR	1800MM. FFL.

SUBMISSION DRAWING

PROJECT :-

PROPOSED GROUP HOUSING SCHEME UNDER INFORMAL CATEGORY IN SECTOR - 10 & 12, GREATER NOIDA.

DWG. TITLE

PLUMBING PLAN

DRAWN BY:

AJIT SINGH

CHECKED BY:

KULWANT

DATE:

26-10-2013

SCALE :

3	NTS
---	-----

DRG NO. :

PL-02

AED

CONSULTING ARCHITECTS:

ARCH-EN DESIGN
DELHI OFF.:

Architect **ASHOK KUMMAR**

B-¹/₃₇, HAUZ KHAS, NEW DELHI-16.

011-45188222, Fax:- 011- 45188288

LUCKNOW OFF.: 4/5, VISHAL KHAND, GOMTI NAGAR, LUCKNOW
0522-4088222, Fax :- 0522- 4088288

ELECTRICAL CONSULTANTS:

RAD infra

CONSULTING MEP ENGINEERS

Plot No 4, Gali 11, Nand Vihar,
Sector-16 A , Dwarka, NEW DELHI -110078
TELEPHONE : 64630016

E-MAIL:radinfra2011@gmail.com

	SCALE	DATE	JAN - 2013
	DEALT BY -	DATE	25-10-2013


ASHWANI KUMAR
MANAGER(PLNG.)

MANISH LAL
SR. EXE./PLNG.)

NIMISHA SHARMA
S.M. (PLNG (ARCH))

HARISH VERMA
A.C.E.O.

RAMA RAMAN
C.E.O

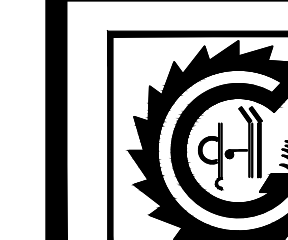

**GREATER NOIDA INDUSTRIAL
DEVELOPMENT AUTHORITY**