

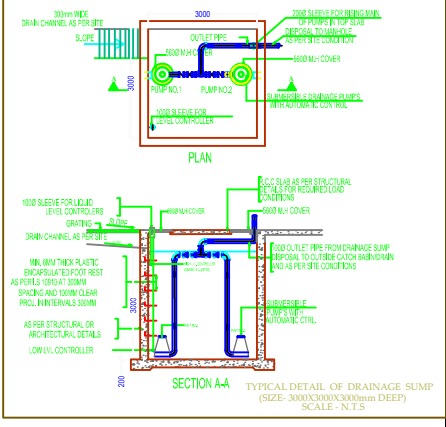
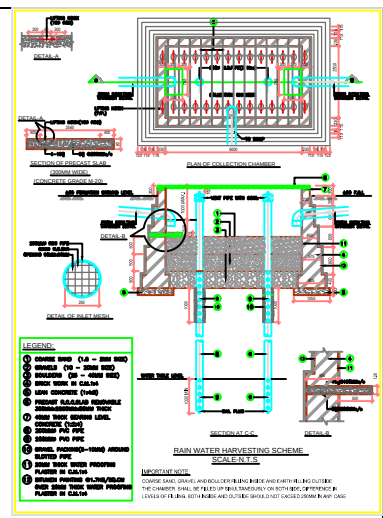


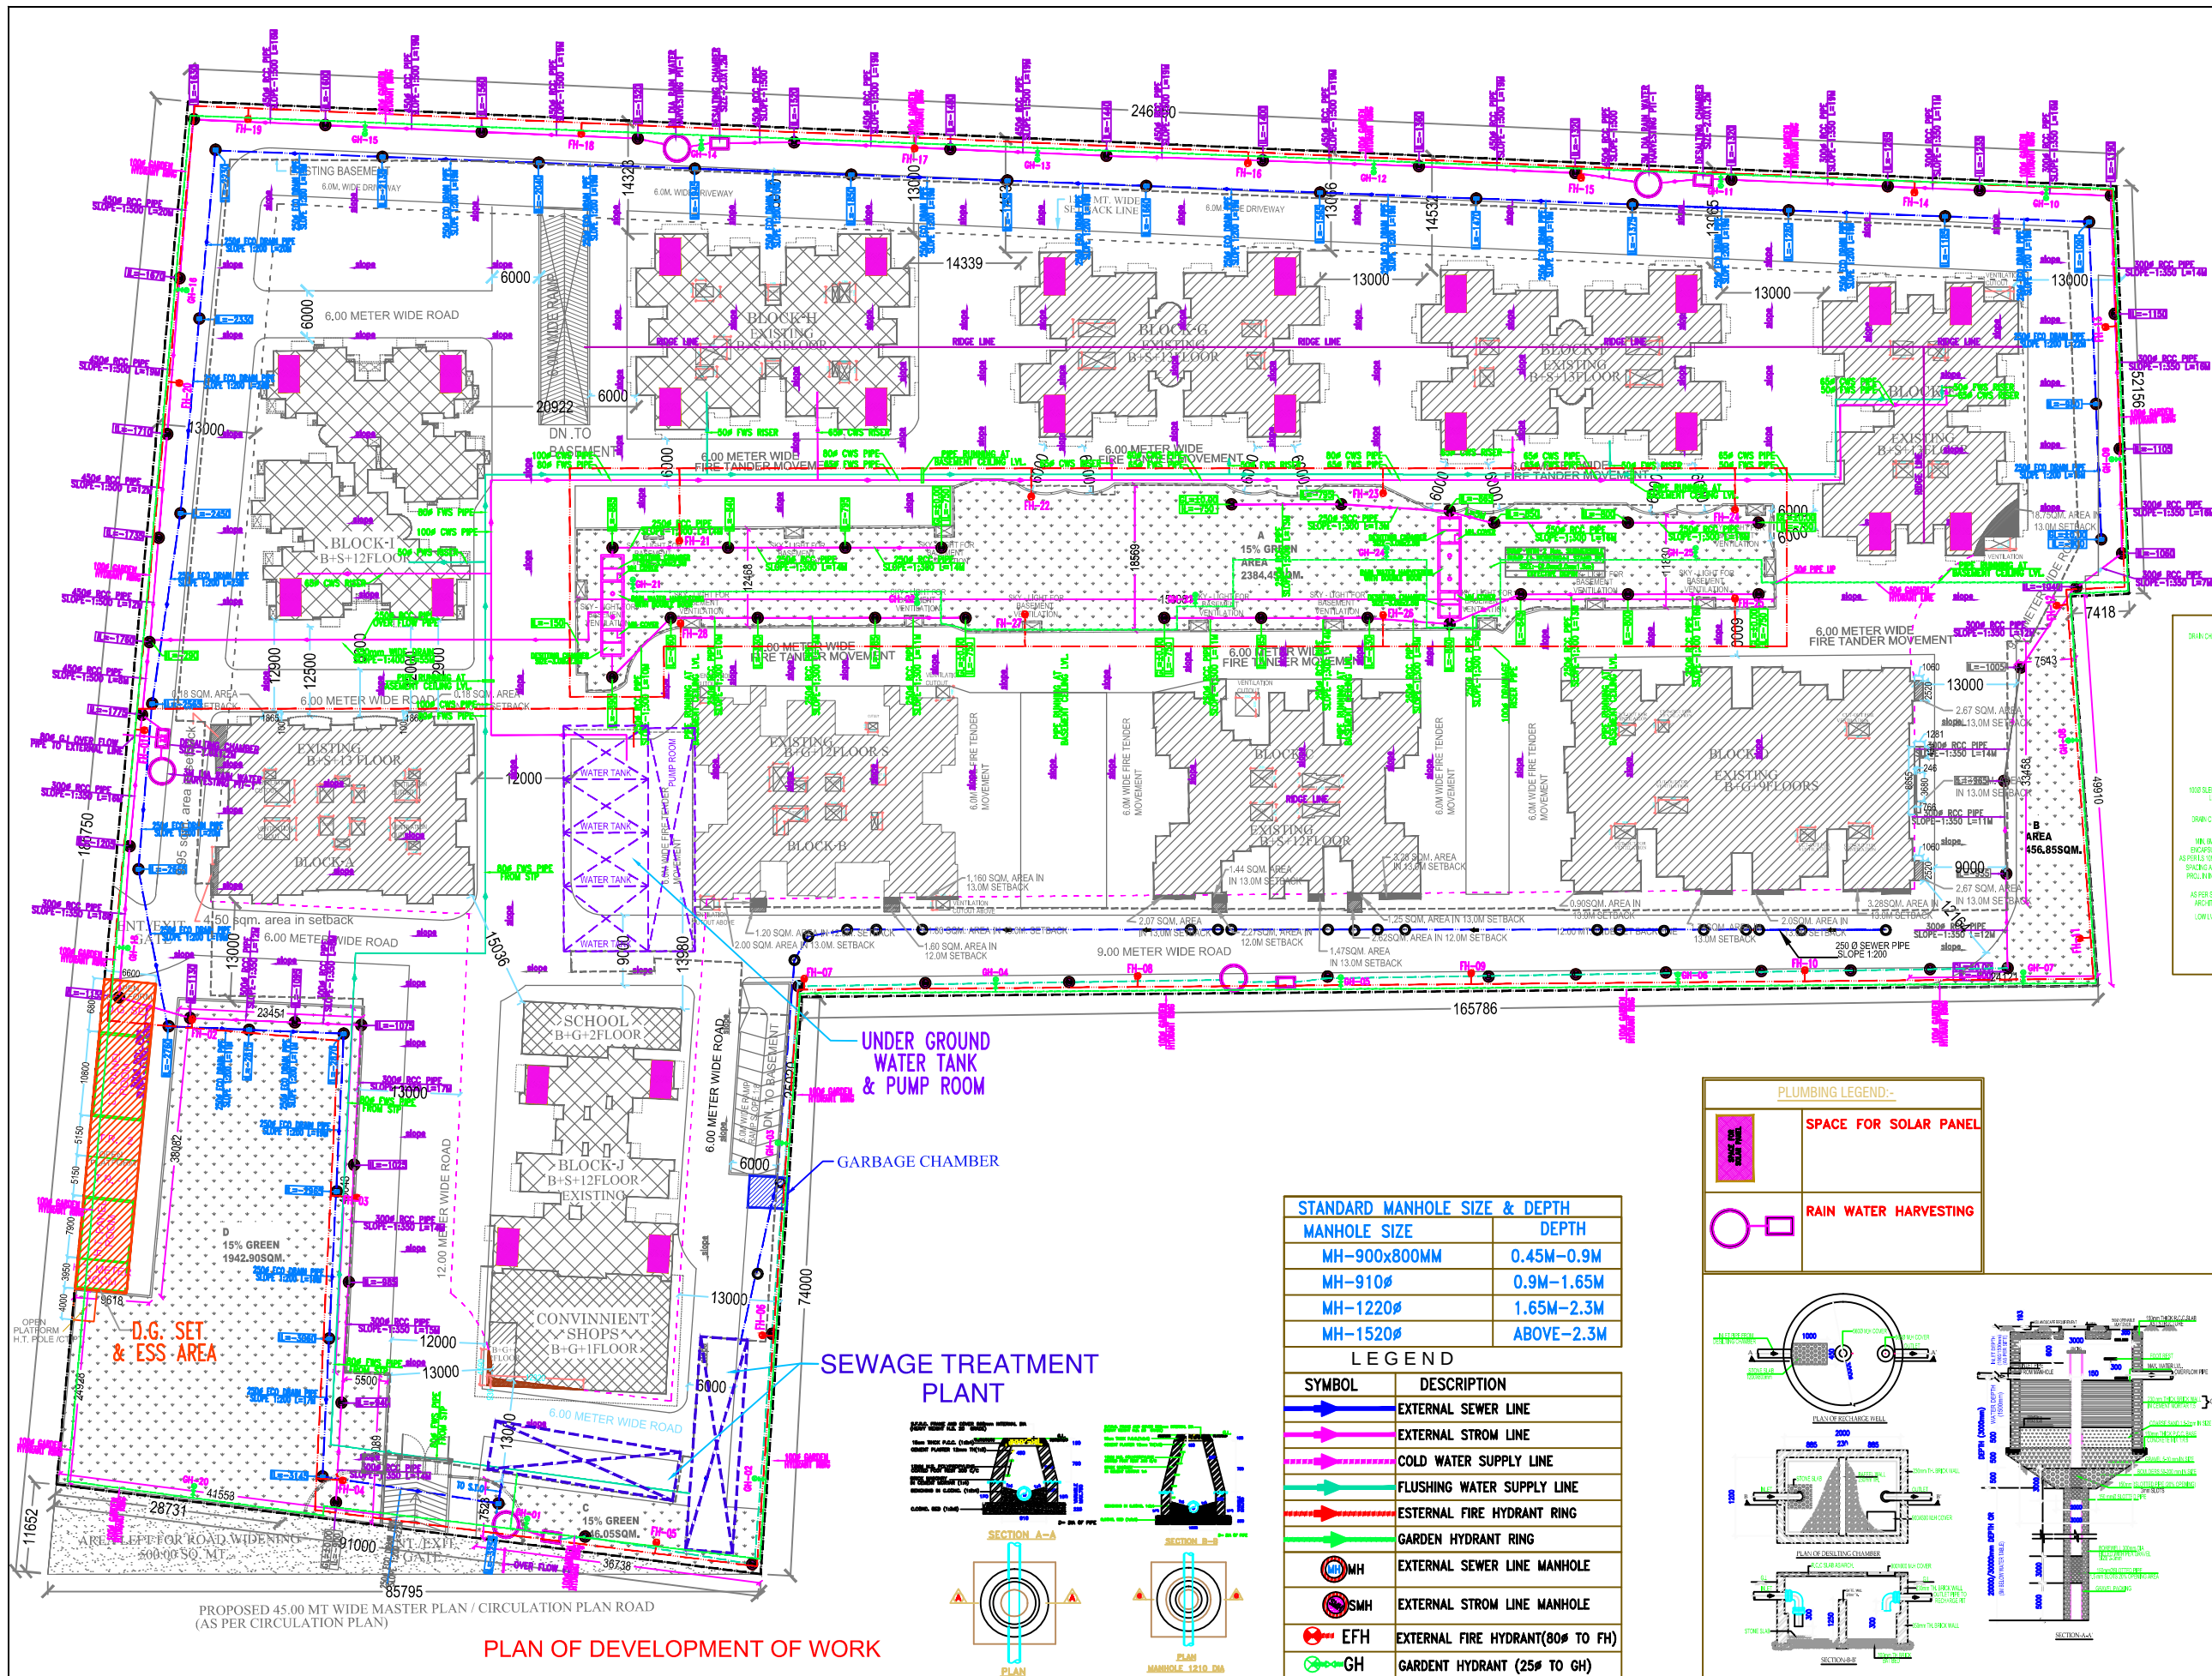

PLUMBING LEGEND:-	
	SPACE FOR SOLAR PANEL
	RAIN WATER HARVESTING

STANDARD MANHOLE SIZE & DEPTH	
MANHOLE SIZE	DEPTH
MH-900x800MM	0.45M-0.9M
MH-910ø	0.9M-1.65M
MH-1220ø	1.65M-2.3M
MH-1520ø	ABOVE-2.3M

LEGEND	
SYMBOL	DESCRIPTION
	EXTERNAL SEWER LINE
	EXTERNAL STROM LINE
	COLD WATER SUPPLY LINE
	FLUSHING WATER SUPPLY LINE
	EXTERNAL FIRE HYDRANT RING
	GARDEN HYDRANT RING
	EXTERNAL SEWER LINE MANHOLE
	EXTERNAL STROM LINE MANHOLE
	EXTERNAL FIRE HYDRANT(80ø TO FH)
	GARDENT HYDRANT (25ø TO GH)

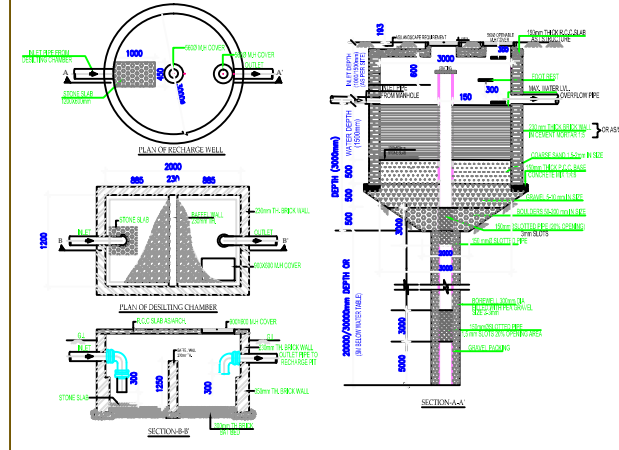

PROJECT:

DRAWING FOR THE GROUP HOUSING
AT KHASARA NO. 1093, 1094 & 1095
AT VILLAGE NOORNAGAR PARGANA LONI
DISTT. / TEHSIL GHAZIABAD U.P.

OWNER:

M/s. SHRI ENERGY PVT. LTD.
DIRECTOR : SH. H.K. GARG

DRAWING TITLE :

PLAN OF DEVELOPMENT OF WORK

OWNER'S SIGN

ARCHITECT'S SIGN

ANUJ AGARWAL ARCHITECTS
OFFICE:- A-244 KAUSHAMBI GHAZIABAD (U.P.)
Ph-0120 - 6454182, 4165716, TEL. FAX - 2773592
e-mail - arch.anujagarwal@gmail.com

SCALE

DEALT BY

DATE

DRG. No.

DG-02