


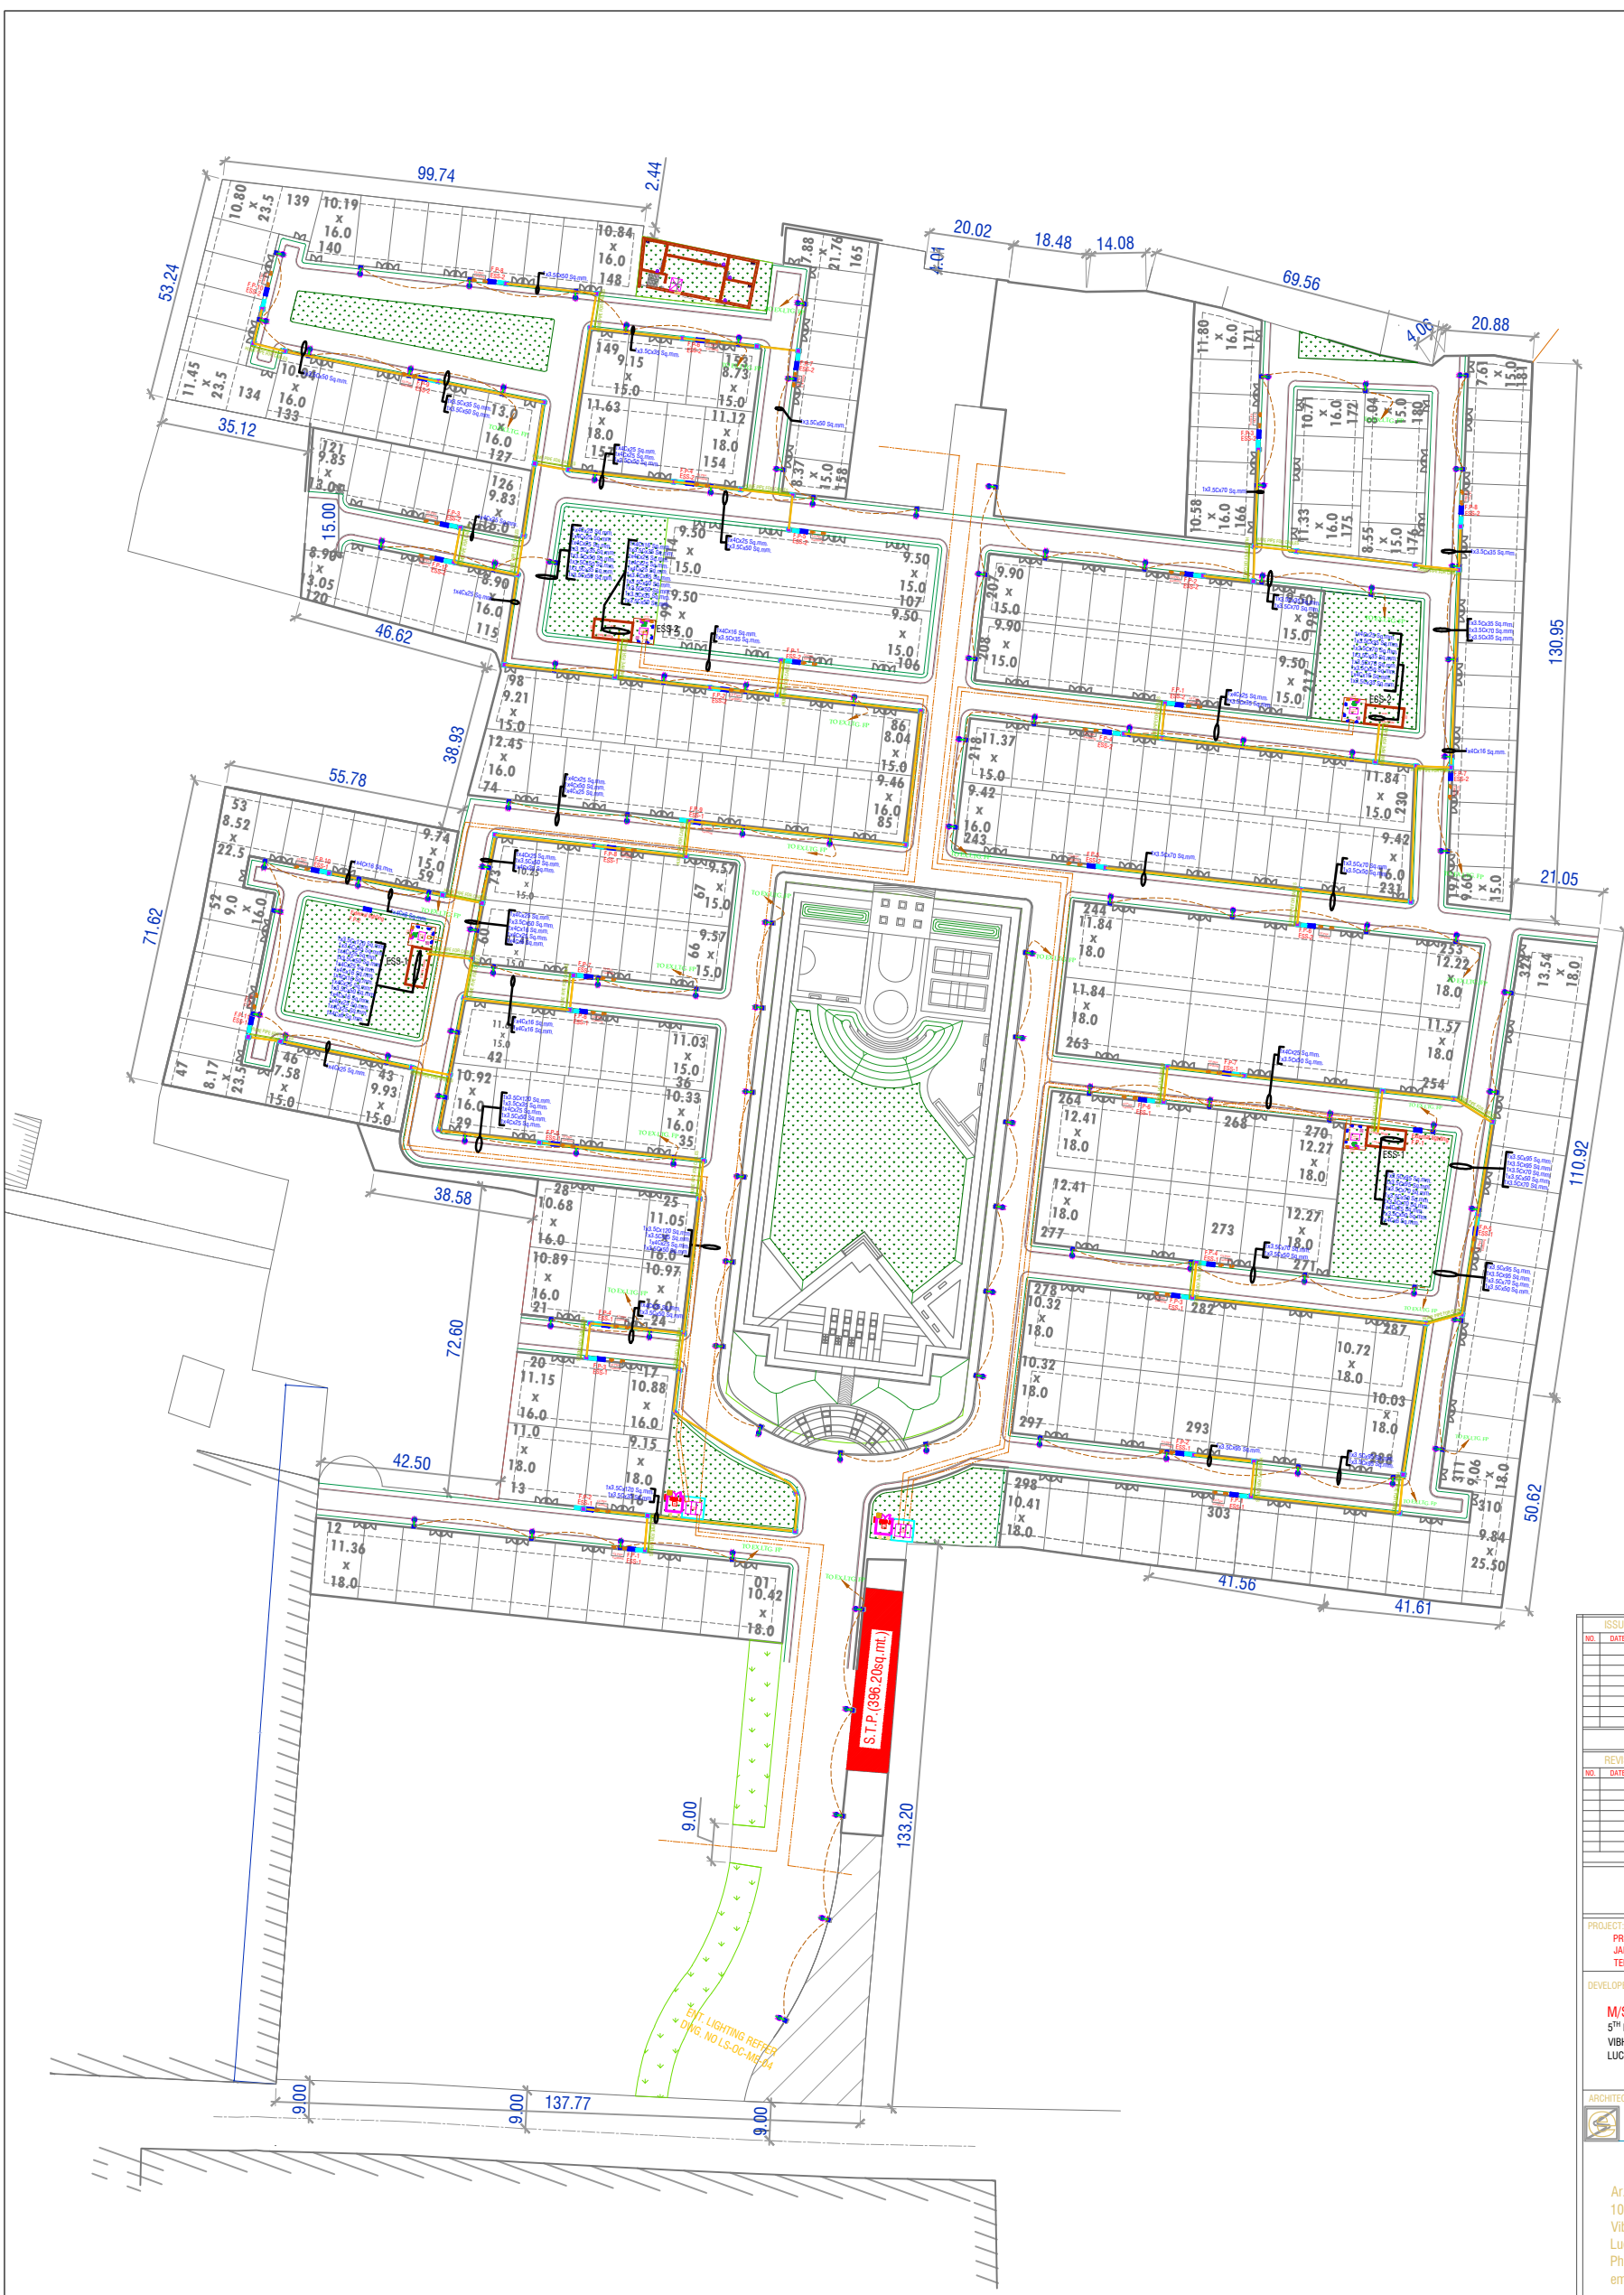

ISSUES				
NO.	DATE	BY	DESCRIPTION	PRINTS
REVISIONS				
NO.	DATE	BY	DESCRIPTION	
PROJECT:				
PROJECT MINI TOWNSHIP- ORO CITY , JANKIPURAM EXTENSION, GRAM-MADIAON, TEHSHIL-BAKSHI KA TALAB,KURSI ROAD,LUCKNOW				
DEVELOPER/PROMOTER:				
M/S ORO CONSTRUCTIONS PVT. LTD. 5 TH FLOOR,ELDECO TOWER , VIBHUTI KHAND,GOMTI NAGAR , LUCKNOW-226010				
ARCHITECT:				
				
espaces				
Ar.Sanjay Kumar Gupta 108.F. Floor,Corporate Chamber-1, Vibhuti Khand,Gomti Nagar, Lucknow-226010 Ph.No.4065958,9415114589 email-espaces_arch@rediffmail.com				
MEP CONSULTANTS:				
PARADISE CONSULTANTS PLOT NO. 103, POCKET-1, BASEMENT JASOLA VIHAR NEW DELHI - 110025 PH + 91-11-29943801, 46132800, 41030619 E-mail: paradiseconsultants@gmail.com				
DRAWING TITLE :				
EXTERNAL SITE PLAN ELECTRICAL LAYOUT				
scale :	1:500 (A0)	drawn by :	T.S.RAWAT	
date :	21/06/17	checked by :	ANIL	
project no :	-----	approved by :	NAFEES	
drawing no :	EL-PC-OC-SITE-ELE.-101			
REVISION				